



ATTACHMENT 04

Drawings

Part 2 of 5

605-14-662


5 pages

3 Aug 2015

Loma Linda, California VA Health Care System (605)

Stairwell Renovation

CONSTRUCTION

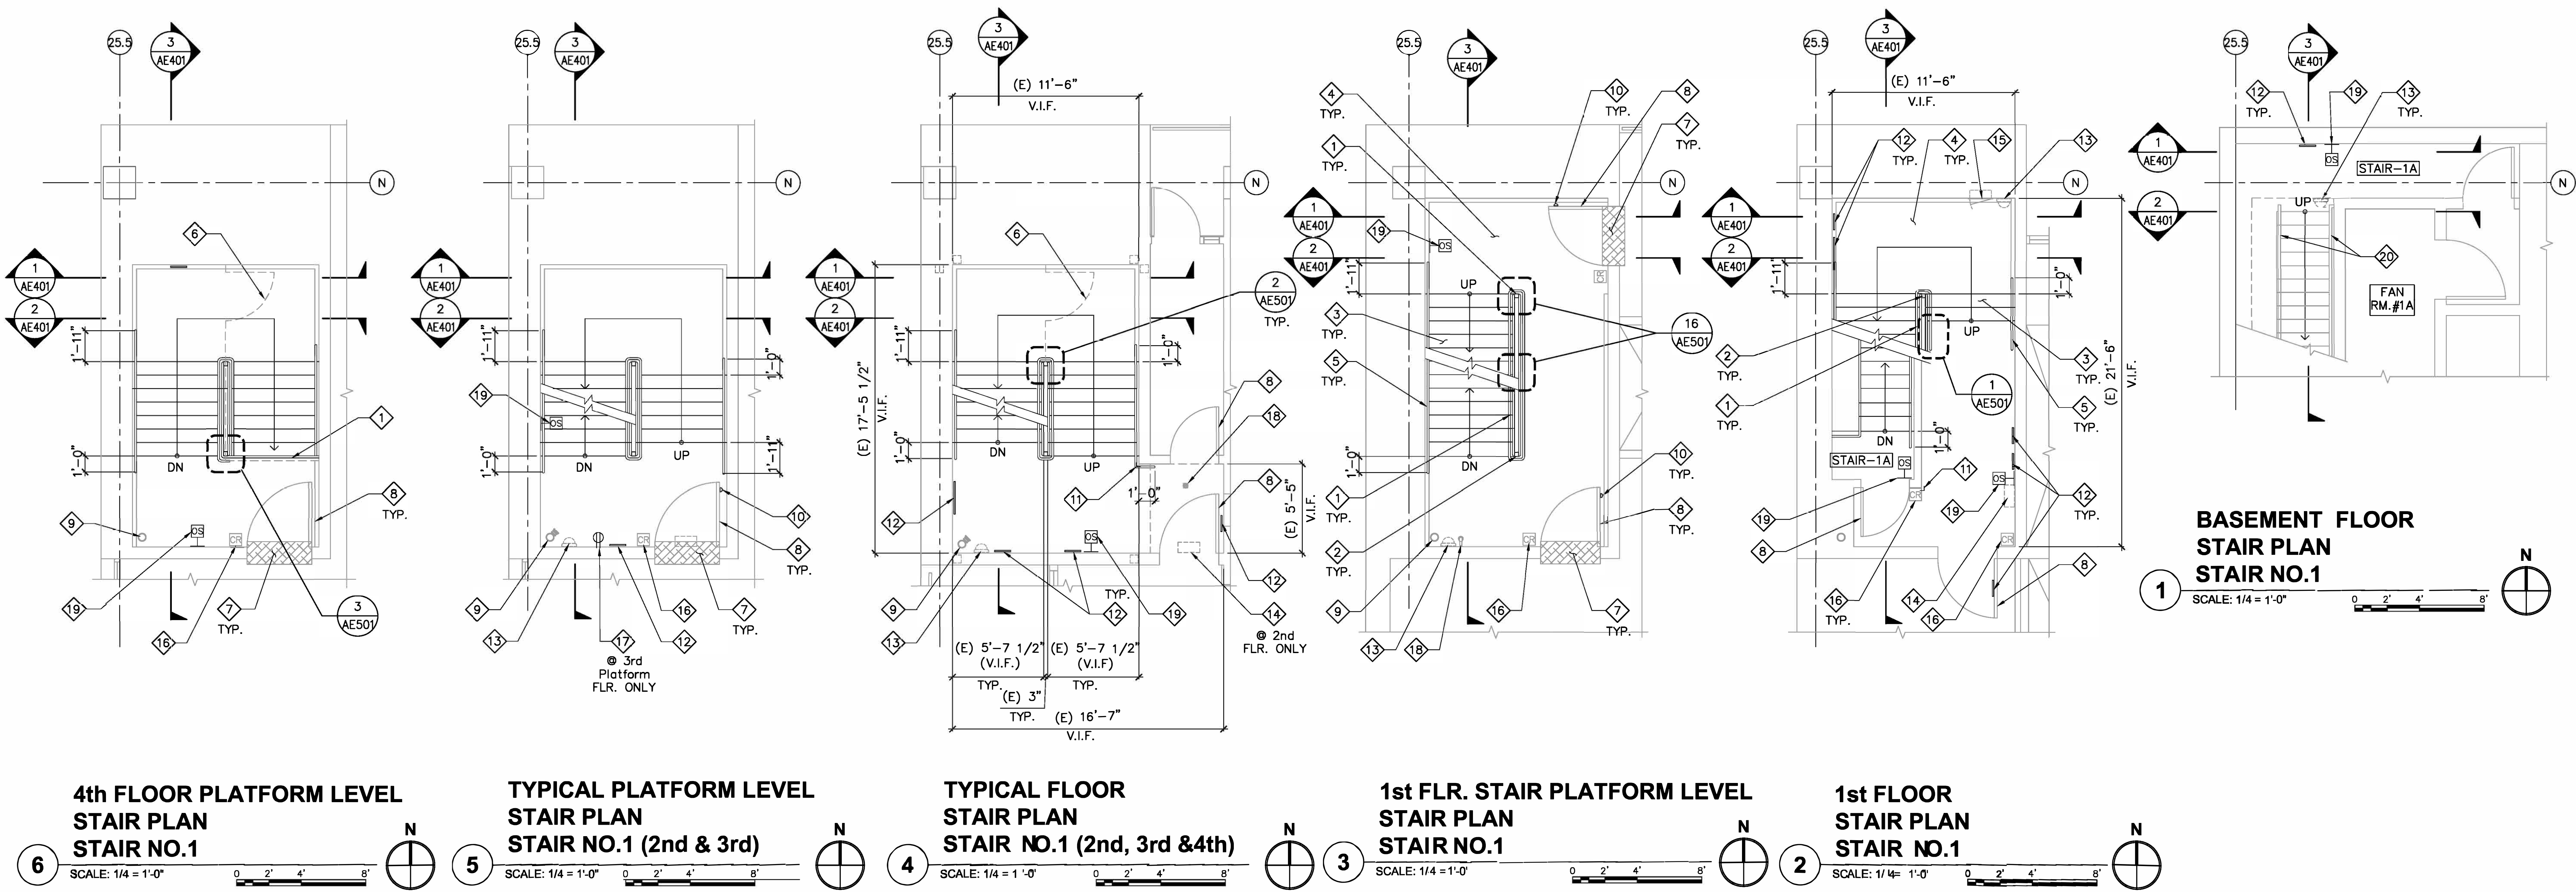


KEY NOTES (FOR SHEETS AE101, AE102 AND AE103)


- (N) HANDRAIL AND GUARDRAIL - SEE AE501 FOR DETAILS
- (E) NEWEL POST WITH (N) FINISH - SEE FIN. SCHED. ON SHT. AF601
- (N) FINISH ON STAIR TREADS AND RISERS - SEE FIN. SCHED. ON SHT. AF601
- (N) FLOOR FINISHES - SEE FIN. SCHED. ON SHT. AF601
- (N) WALL MOUNTED HANDRAILS
- (E) WIRE MESH DOOR AND PARTITION WITH (N) FINISH (AT 4TH FLR. ONLY)
- (E) CHECKERED PLATE THRESHOLD WITH (N) FINISH - SEE FINISH SCHED. ON SHT. AF601
- (E) DOOR AND DOOR FRAME WITH (N) FINISH
- (E) CSP RISER TO REMAIN
- (N) DOOR STOPPER - SEE FINISH SCHED. ON SHT. AF601
- (N) CORNER GUARD - SEE FINISH SCHED. ON SHT. AF601 AND DETAIL 8A/501
- (N) SIGNAGE WITHIN THE STAIRWELL TO MATCH THE NEWLY RENOVATED STAIRWELL SIGNAGE (GOVERNMENT FURNISHED CONTRACTOR INSTALLED)
- (E) CAMERA SYSTEM TO REMAIN - SEE ELECT.
- (E) WIRELESS ACCESS POINT (WAP) EQUIPMENT FOR COMMUNICATION SYSTEM TO REMAIN - SEE ELECT.
- (E) WALL ACCESS PANEL TO REMAIN, PAINT TO MATCH ADJACENT SURFACE
- (E) WALL MOUNTED ACCESS CONTROL CARD READER TO REMAIN
- (E) ELECT. WALL OUTLET WITH (N) SS COVER PLATE - SEE ELECT.
- (E) SPRINKLER PIPE AND HEAD TO REMAIN
- (N) WIRELESS OCCUPANCY SENSOR COMPATIBLE WITH (N) LIGHTING FIXTURES - SEE ELECT.
- (E) HANDRAILS WITH (N) PAINT TO MATCH PAINT ON FLOORS ABOVE

GENERAL NOTES (FOR SHEETS AE101, AE102 AND AE103)

- (E) CSP RISER TYPICAL ON STAIRS NO. 1, 2, & 7 FROM FIRST FLOOR LEVEL TO THE LAST FLOOR LEVEL
- FOR LOCATIONS OF WALL WITH WALL MURAL COVERINGS SEE SHEETS AE401, AE402 AND AE403
- PROVIDE RESILIENT STEP TREADS AND RISER WITH CONTRASTING STRIP FOR VISUALLY IMPAIRED AT TOP AND BOTTOM NOSING OF STAIRS
- FOR LOCATION OF (N) LIGHTING FIXTURES - SEE ELECT. AND FOR MOUNTING HEIGHT SEE AE401, AE402 AND AE403
- REPAINT ALL EXPOSED PIPES AND CONDUIT WITHIN THE PROJECT SCOPE. FOR FIRE SPRINKLER PIPING COLOR 'FIRE RED', OTHER CONDUITS/PIPING: COLOR TO MATCH (E) ADJACENT SURFACES
- REPAINT ALL DOORS TYPICAL ON STAIRS NO. 1, 2, & 7
- FOR FINISH SCHEDULE, SEE SHEET AF601
- REROUTE CONDUITS INTERFERING/OBSTRUCTING (N) WORK. PATCH GYPBOARD UPON INSTALLATION OF CONDUITS, FINISH AND COLOR TO MATCH ADJACENT SURFACE
- FOR LOCATION OF (N) MUSIC/PAGING SPEAKERS AND SYSTEM - SEE ELECT.
- REPAIR ALL AREAS DAMAGED DUE TO WORK UNDER THIS PROJECT. MATERIAL, FINISH AND COLOR TO MATCH ADJACENT SURFACE
- SEE AD101

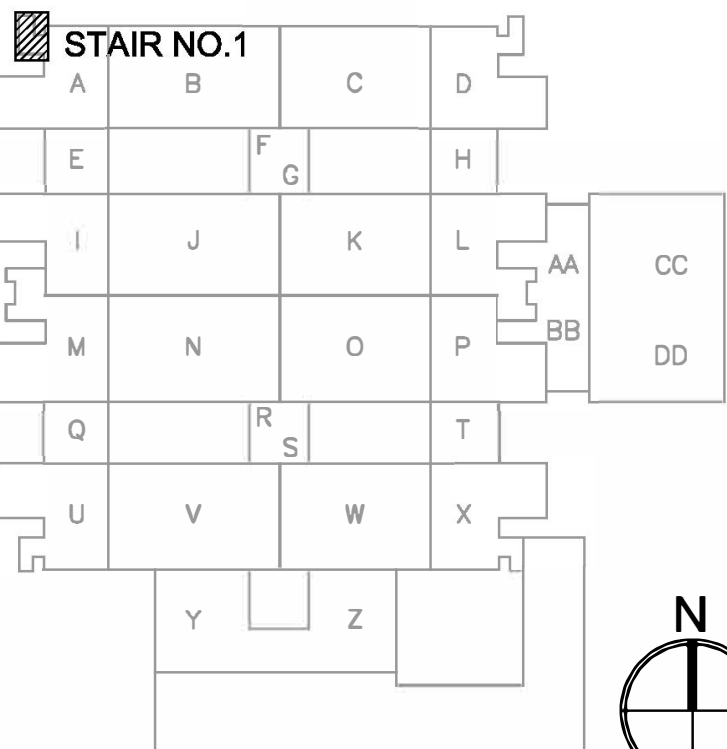

NO.	DATE	DESCRIPTION
PROJECT TITLE: DESIGN RENOVATION OF THREE STAIRWELLS		
SHEET TITLE: STAIR PLANS (STAIR NO.1)		
JERRY L. PETTIS MEMORIAL VETERANS MEDICAL CENTER		
11201 BENTON STREET LOMA LINDA, CALIFORNIA 92357		
DRAWN: CELIA	CHIEF ENGINEERING	SCALE: 1/4"=1'-0"
CHECKED: RK	DATE: 08-03-2015	DRAWING NO. AE101
CLINICAL ENGINEER	SAFETY ENGINEER	SHEET NO. DWG. 6 OF 25
CHIEF OF SECTION	ENERGY COORDINATOR	PROJECT NO. 605-14-662
CHIEF OF SERVICE		CHIEF OF STAFF
ASST. HOSP. DIRECTOR		HOSPITAL DIRECTOR

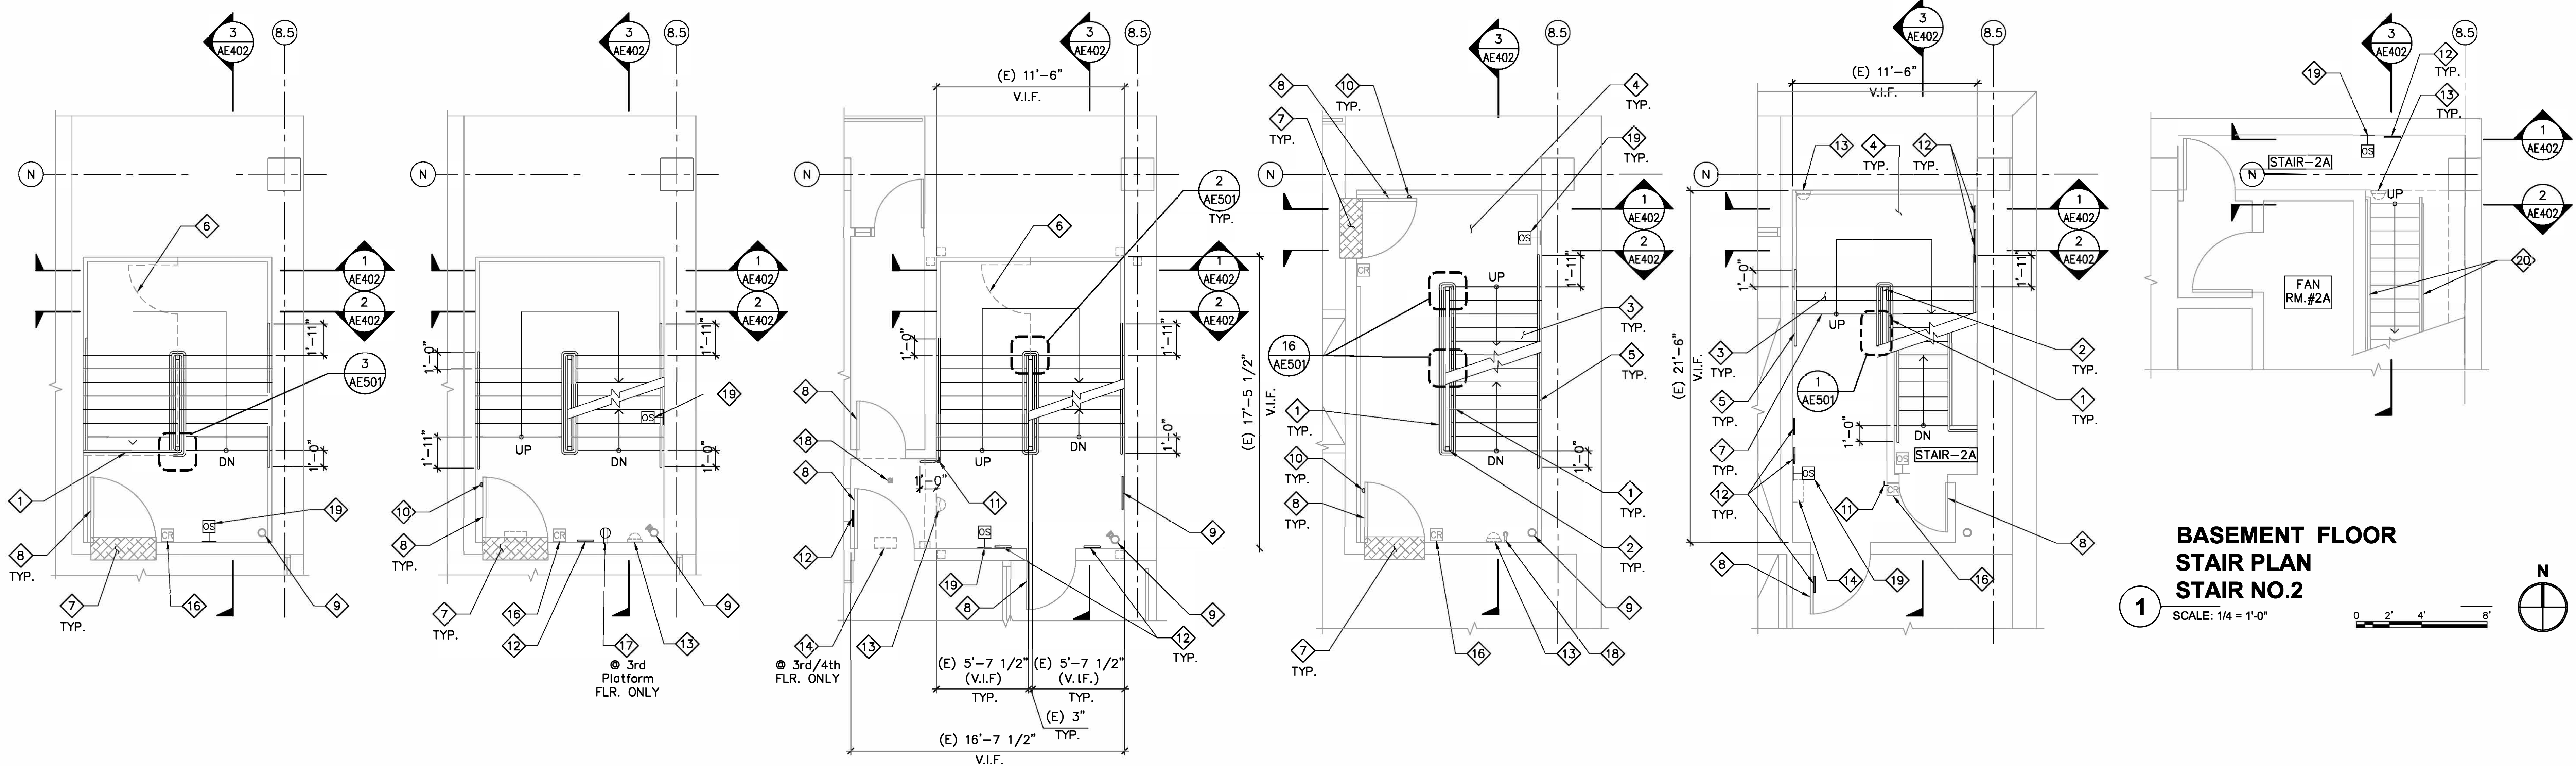

4th FLOOR PLATFORM LEVEL STAIR PLAN STAIR NO.2
 SCALE: 1/4" = 1'-0"

TYPICAL PLATFORM LEVEL STAIR PLAN STAIR NO.2 (2nd & 3rd)
 SCALE: 1/4" = 1'-0"

TYPICAL FLOOR STAIR PLAN STAIR NO.2 (2nd, 3rd & 4th)
 SCALE: 1/4" = 1'-0"

1st FLR. STAIR PLATFORM LEVEL STAIR PLAN STAIR NO.2
 SCALE: 1/4" = 1'-0"



1st FLOOR STAIR PLAN STAIR NO.2
 SCALE: 1/4" = 1'-0"

KEY NOTES

SEE SHEET AE101

GENERAL NOTES


SEE SHEET AE101

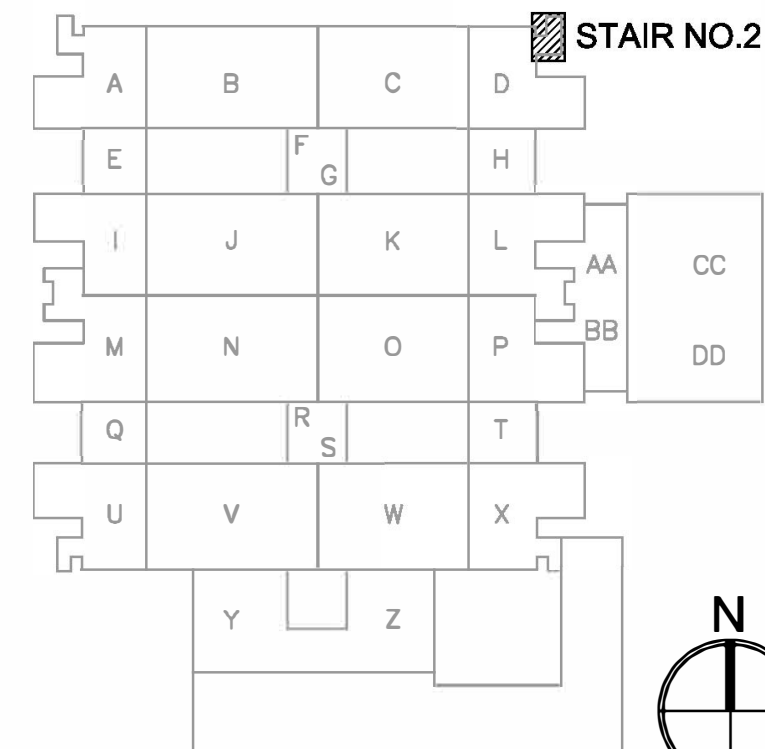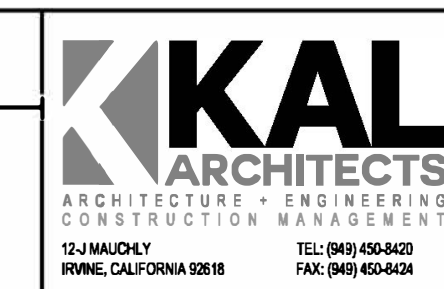

KEY PLAN

NO.	DATE	DESCRIPTION
PROJECT TITLE: DESIGN RENOVATION OF THREE STAIRWELLS		
SHEET TITLE: STAIR PLANS (STAIR NO.2)		
JERRY L. PETTIS MEMORIAL VETERANS MEDICAL CENTER		
11201 BENTON STREET LOMA LINDA, CALIFORNIA 92357		
DRAWN: CELIA	CHIEF ENGINEERING	SCALE: 1/4" = 1'-0"
CHECKED: RK	DATE: 08-03-2015	DRAWING NO. AE102
CLINICAL ENGINEER	SAFETY ENGINEER	SHEET NO. 7 OF 25
CHIEF OF SECTION	ENERGY COORDINATOR	PROJECT NO. 605-14-662
CHIEF OF SERVICE	CHIEF OF STAFF	
ASST. HOSP. DIRECTOR	HOSPITAL DIRECTOR	

FINAL SUBMITTAL

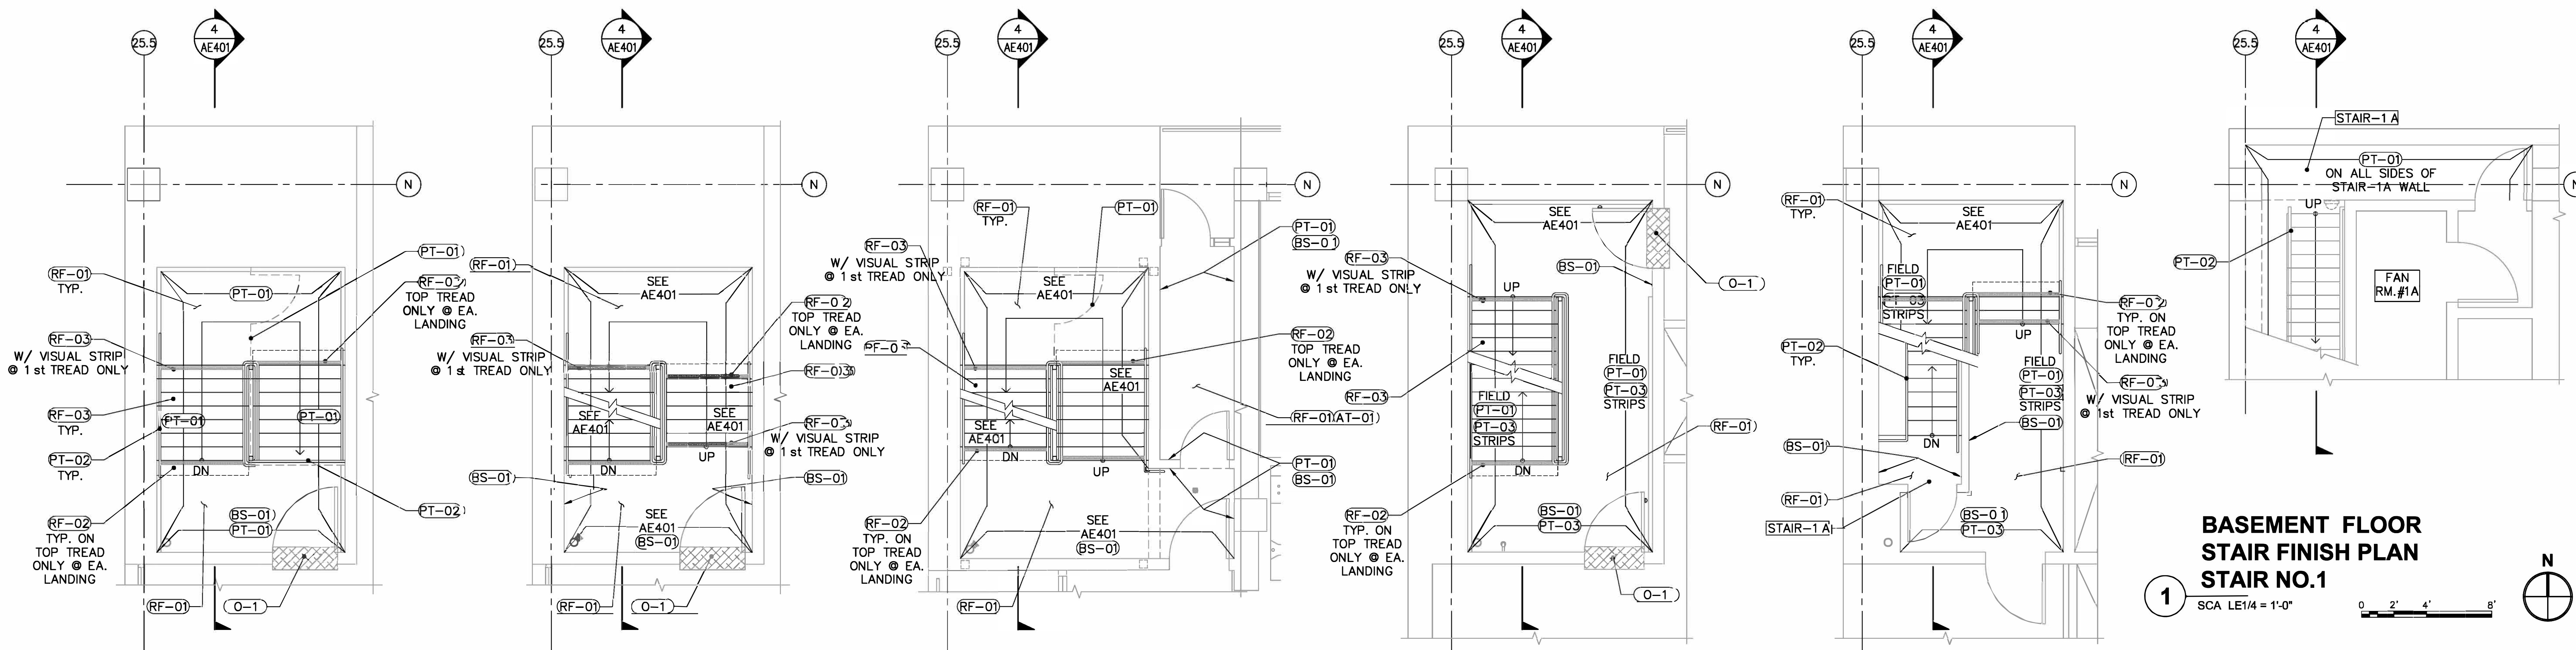

4th FLOOR PLATFORM LEVEL
STAIR FINISH PLAN
STAIR NO.1

TYPICAL PLATFORM LEVEL
STAIR FINISH PLAN
STAIR NO.1 (2nd & 3rd)



TYPICAL FLOOR
STAIR FINISH PLAN
STAIR NO.1 (2nd, 3rd & 4th)

1st FLR. STAIR PLATFORM LEVEL
STAIR FINISH PLAN
STAIR NO.1


1st FLOOR
STAIR FINISH PLAN
STAIR NO.1

GENERAL NOTES

- WALLS NOT SPECIFIED WITH NEW FINISH NUMBER ARE PT-01, SEE FINISH SCHEDULE (AF601) FOR DETAILS

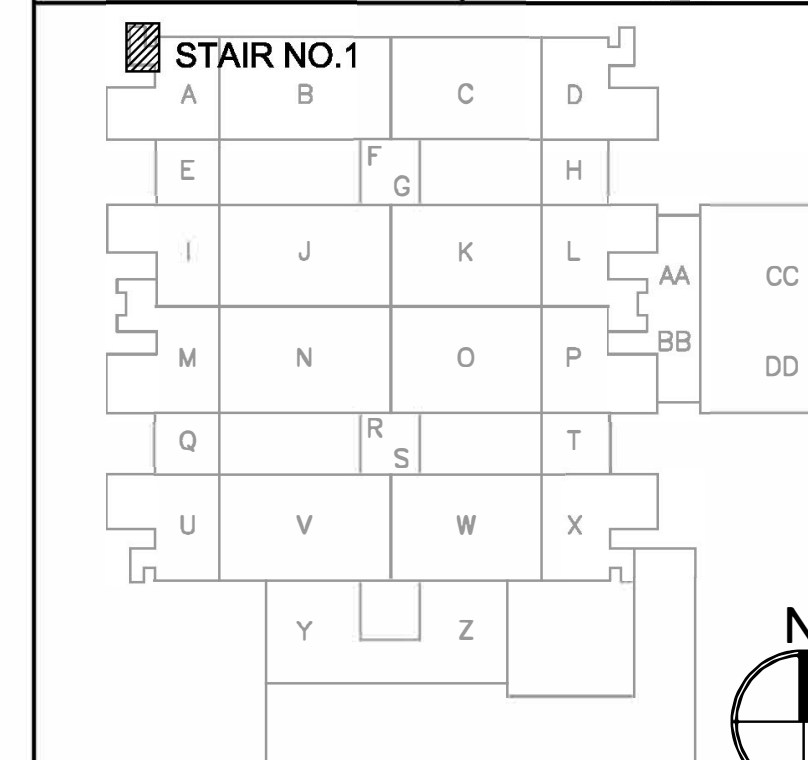
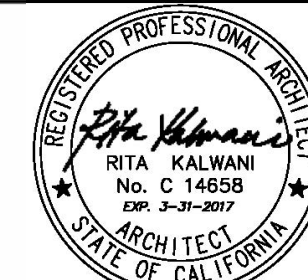


NO.	DATE	DESCRIPTION
PROJECT TITLE: DESIGN/RENOVATION OF THREE STAIRWELLS		
SHEET TITLE: STAIR FINISH PLANS (STAIR NO.1)		
JERRY L. PETTIS MEMORIAL VETERANS MEDICAL CENTER		
11201 BENTON STREET LOMA LINDA, CALIFORNIA 92357		
DRAWN: CELIA	CHIEF ENGINEERING	SCALE: 1/4"=1'-0"
CHECKED: RK	DATE: 08-03-2015	DRAWING NO. AF101
CLINICAL ENGINEER	SAFETY ENGINEER	SHEET NO. 9 OF 25
CHIEF OF SECTION	ENERGY COORDINATOR	PROJECT NO. 605-14-662
CHIEF OF SERVICE		CHIEF OF STAFF
ASST. HOSP. DIRECTOR	HOSPITAL DIRECTOR	

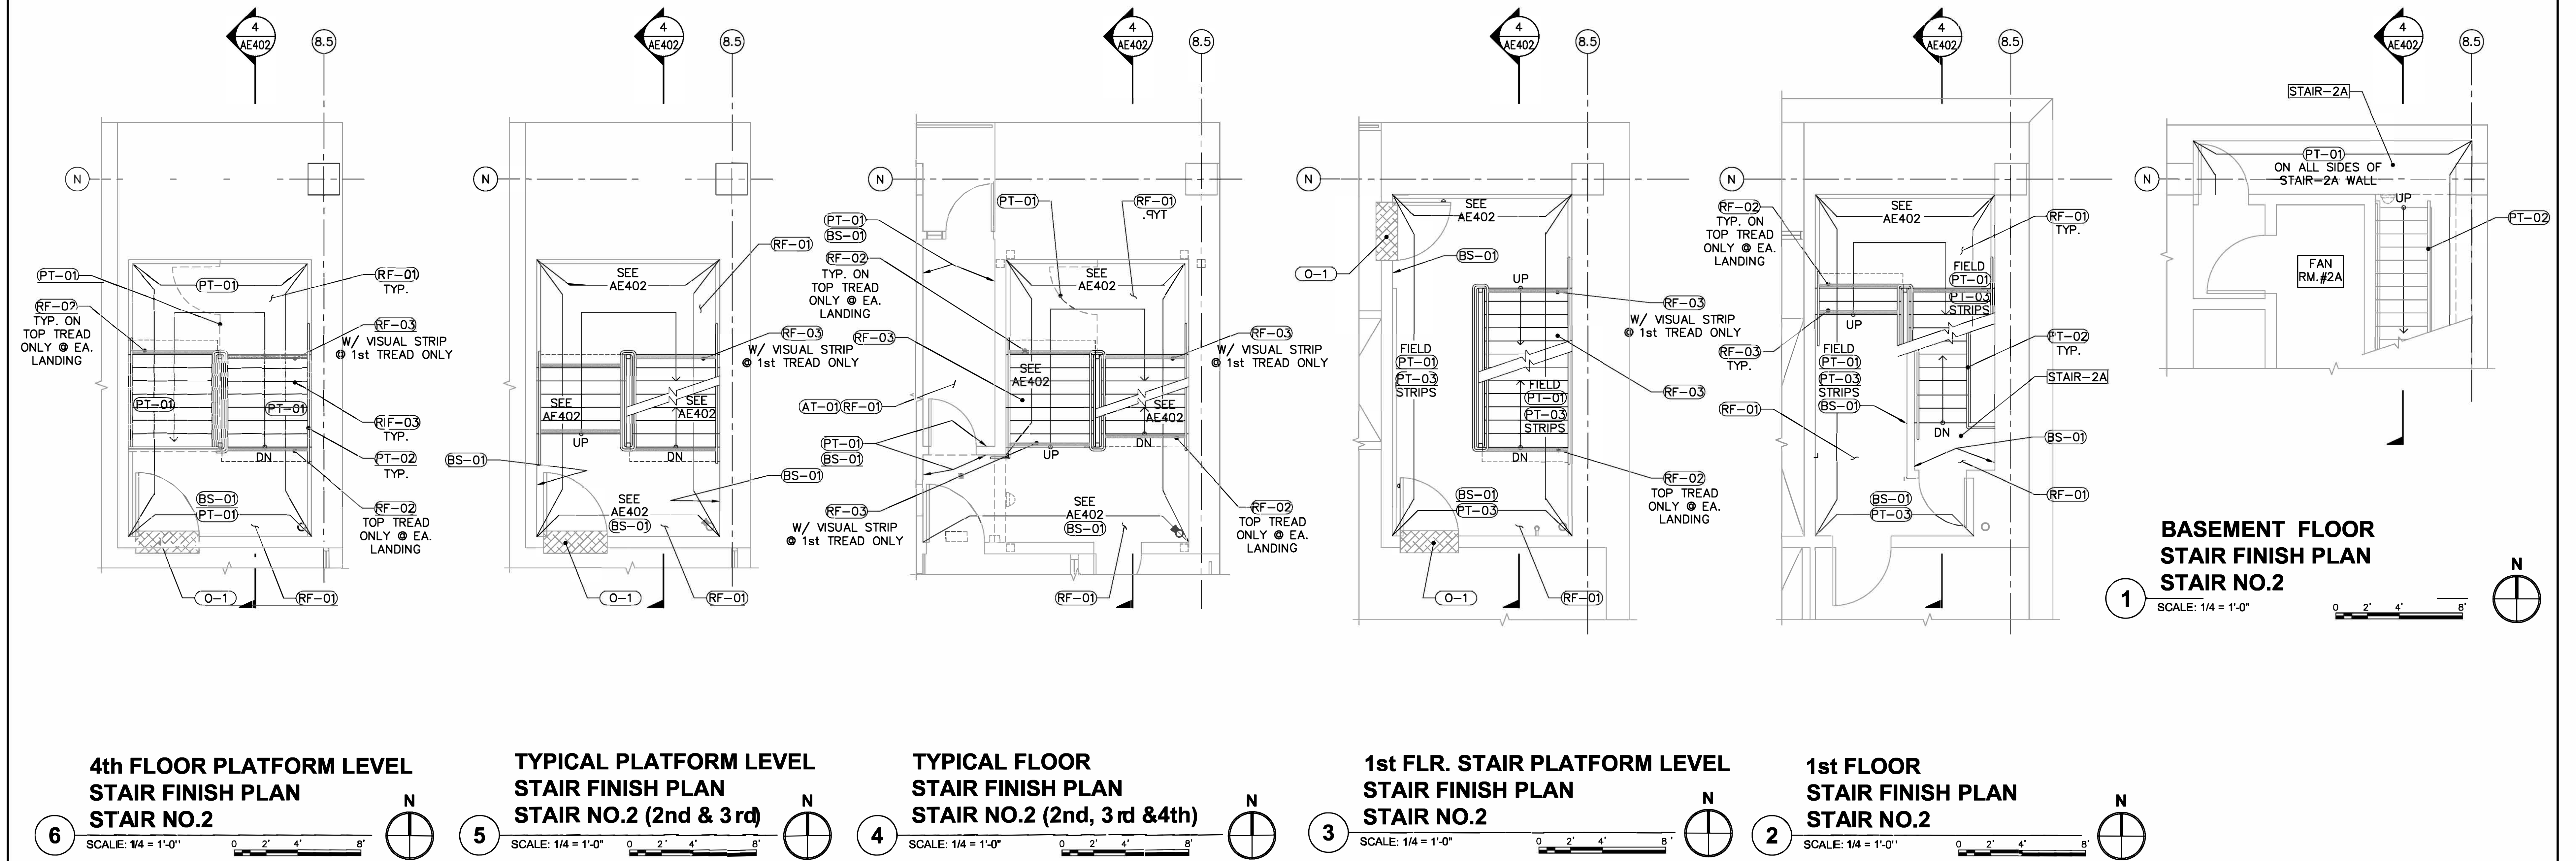

GENERAL NOTES

SEE SHEET AF101

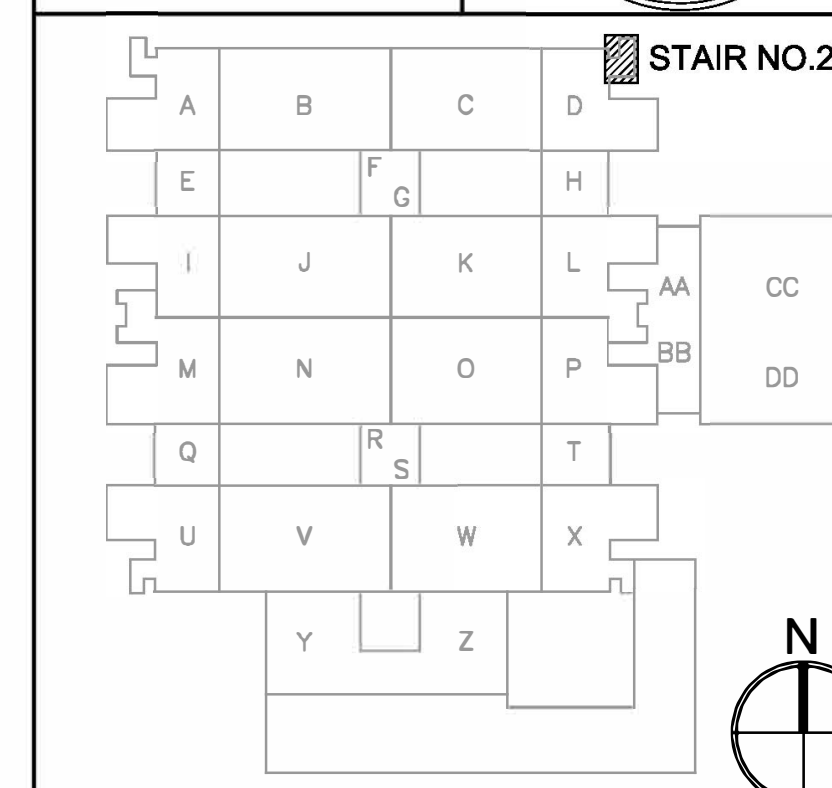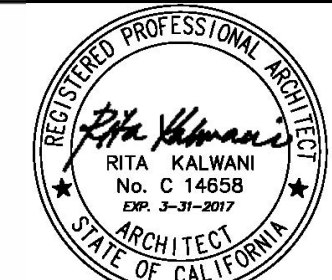

NO.	DATE	DESCRIPTION
PROJECT TITLE: DESIGN RENOVATION OF THREE STAIRWELLS		
SHEET TITLE: STAIR FINISH PLANS (STAIR NO.2)		
JERRY L. PETTIS MEMORIAL VETERANS MEDICAL CENTER		
11201 BENTON STREET LOMA LINDA, CALIFORNIA 92357		
DRAWN: CELIA	CHIEF ENGINEERING	SCALE: 1/4" = 1'-0"
CHECKED: RK	DATE: 08-03-2015	DRAWING NO. AF102
CLINICAL ENGINEER	SAFETY ENGINEER	SHEET NO. 10 OF 25
CHIEF OF SECTION	ENERGY COORDINATOR	PROJECT NO. 605-14-662
CHIEF OF SERVICE		CHIEF OF STAFF
ASST. HOSP. DIRECTOR		HOSPITAL DIRECTOR

FINAL SUBMITTAL