




1 EQUIPMENT CURB (TYP.)
SCALE: 1" = 1'-0"
NOTE: NO CURB PENETRATIONS ALLOWED (TYPICAL)

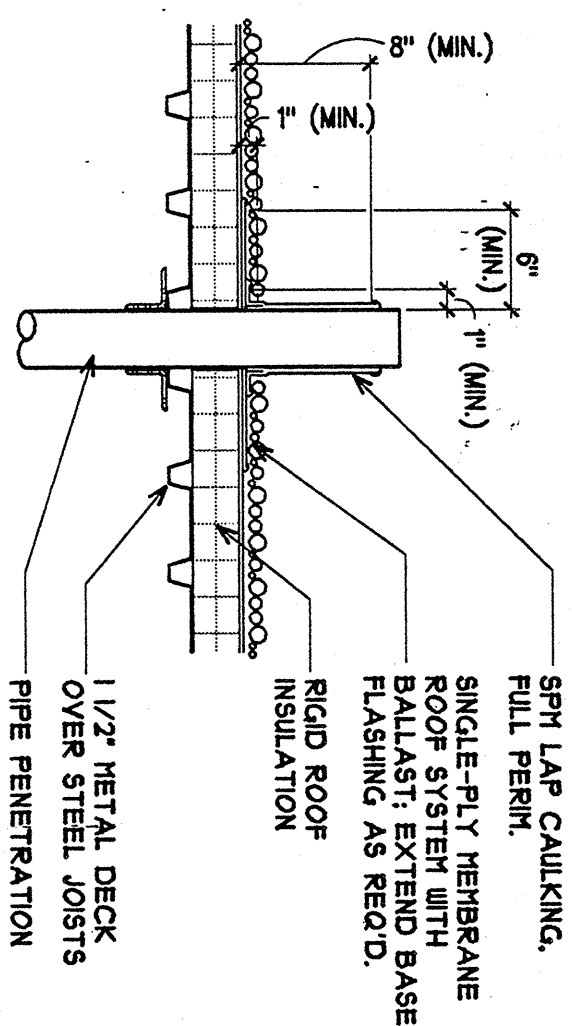


2 PLUMBING VENT (VTR)
SCALE: 1" = 1'-0"
REFER TO PLUMBING DRAWINGS FOR LOCATIONS (TYP)

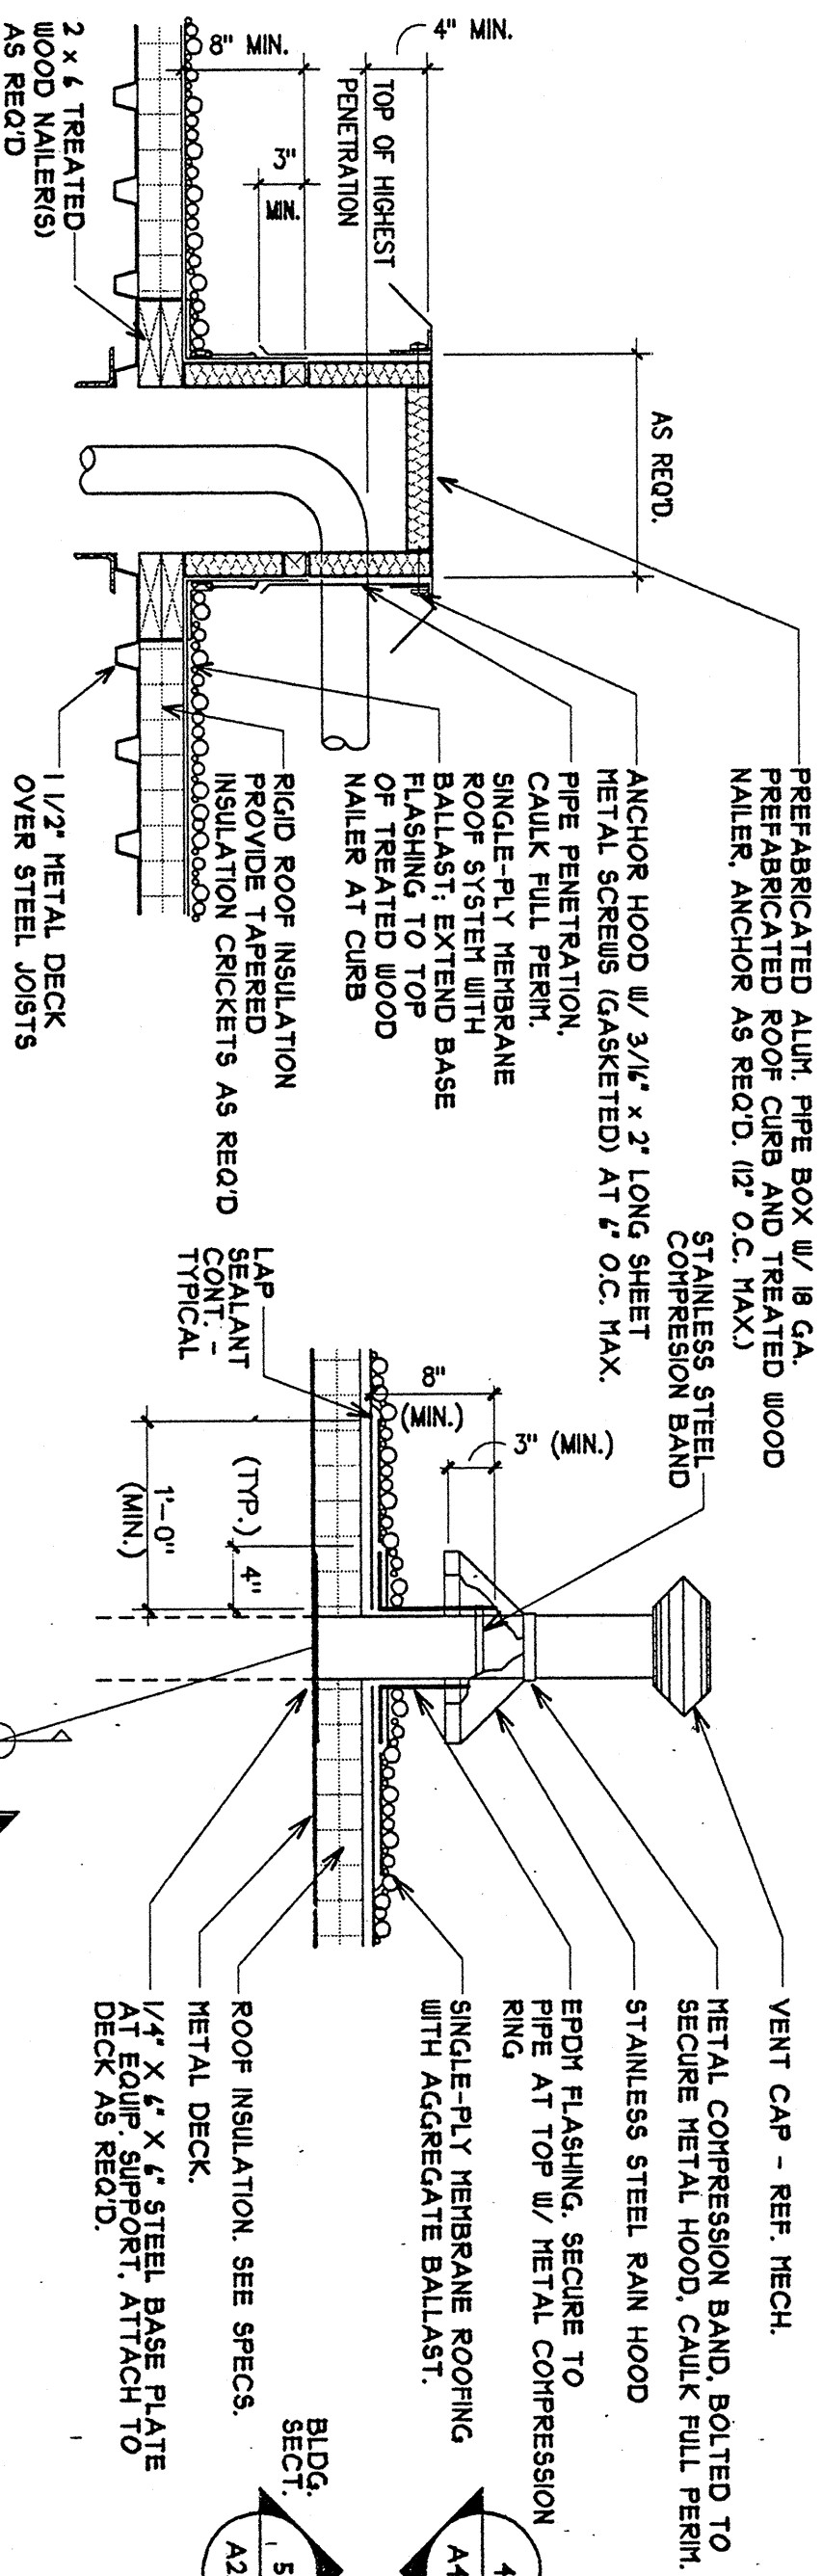


3 PIPE BOX DETAIL
SCALE: 1" = 1'-0"
REFER TO MECHANICAL DRAWINGS FOR LOCATIONS (TYP)

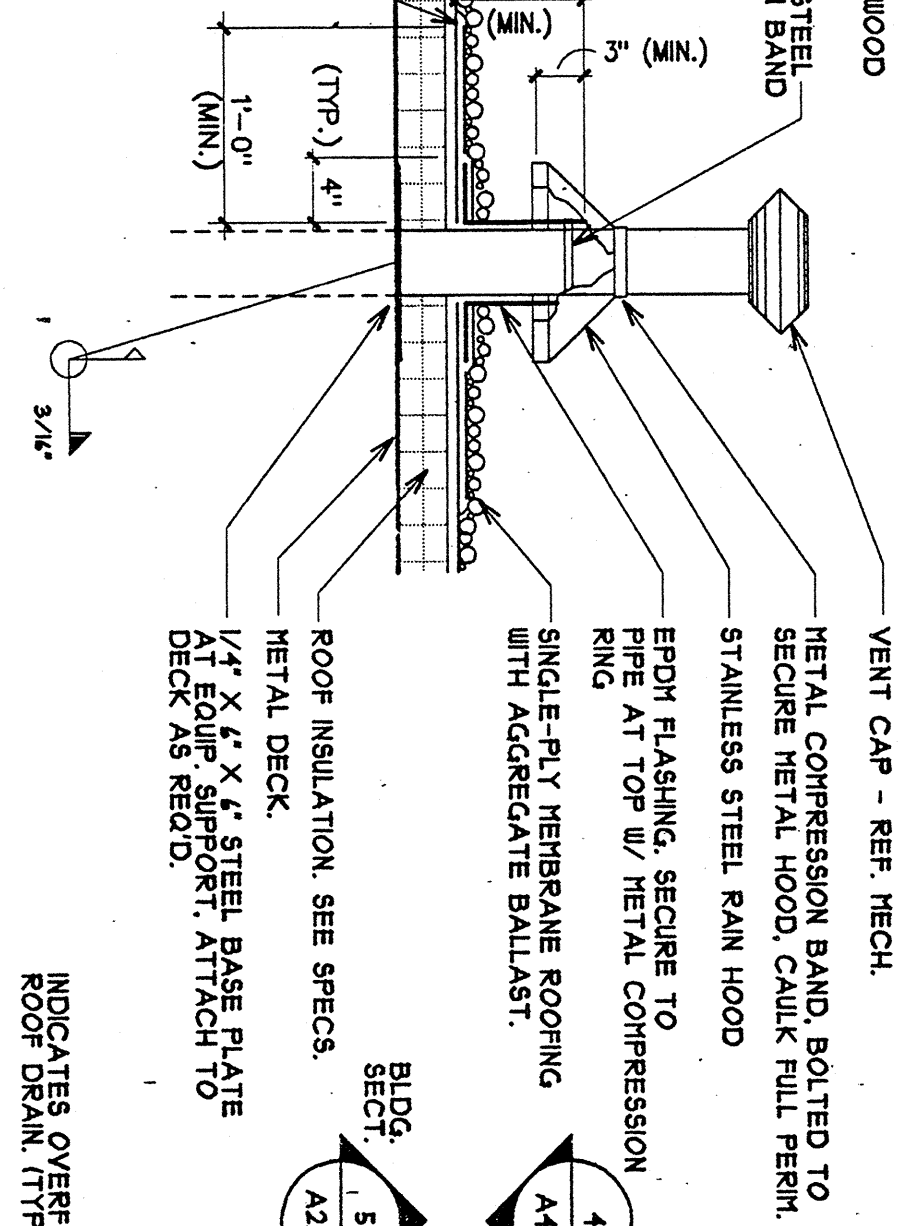


5 DETAIL AT FLUE
SCALE: 1" = 1'-0"
REFER TO MECHANICAL DRAWINGS FOR LOCATIONS (TYP)

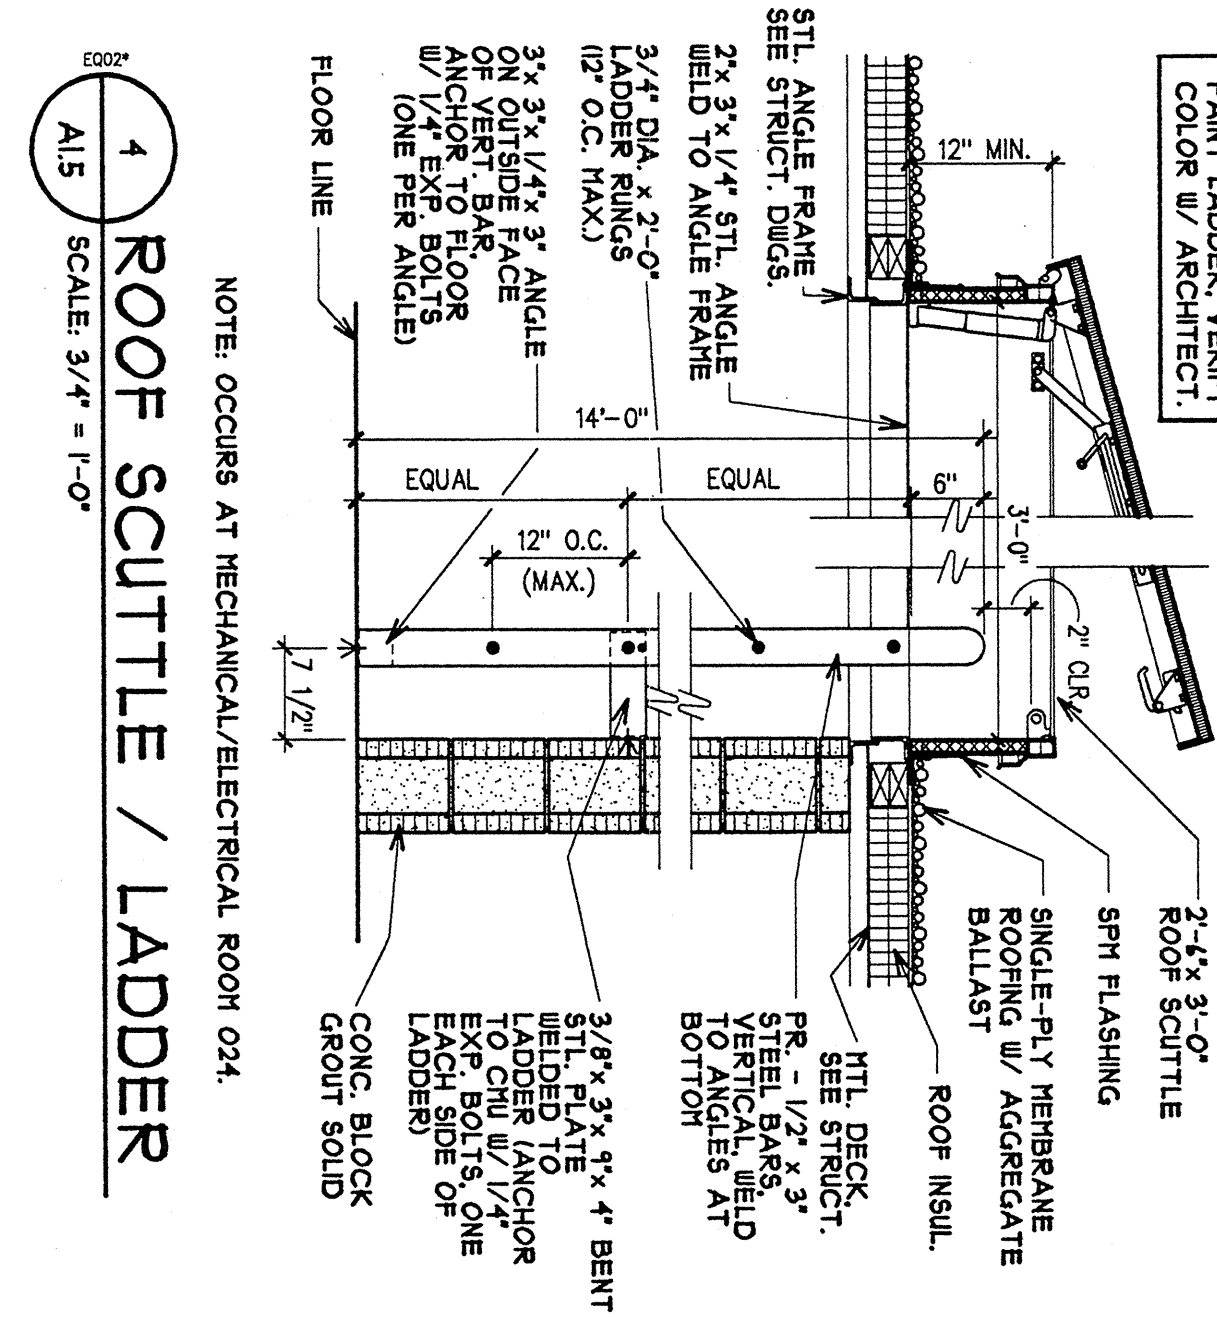

4 ROOF SCUTTLE / LADDER
SCALE: 3/4" = 1'-0"
NOTE: OCCURS AT MECHANICAL/ELECTRICAL ROOF 024.

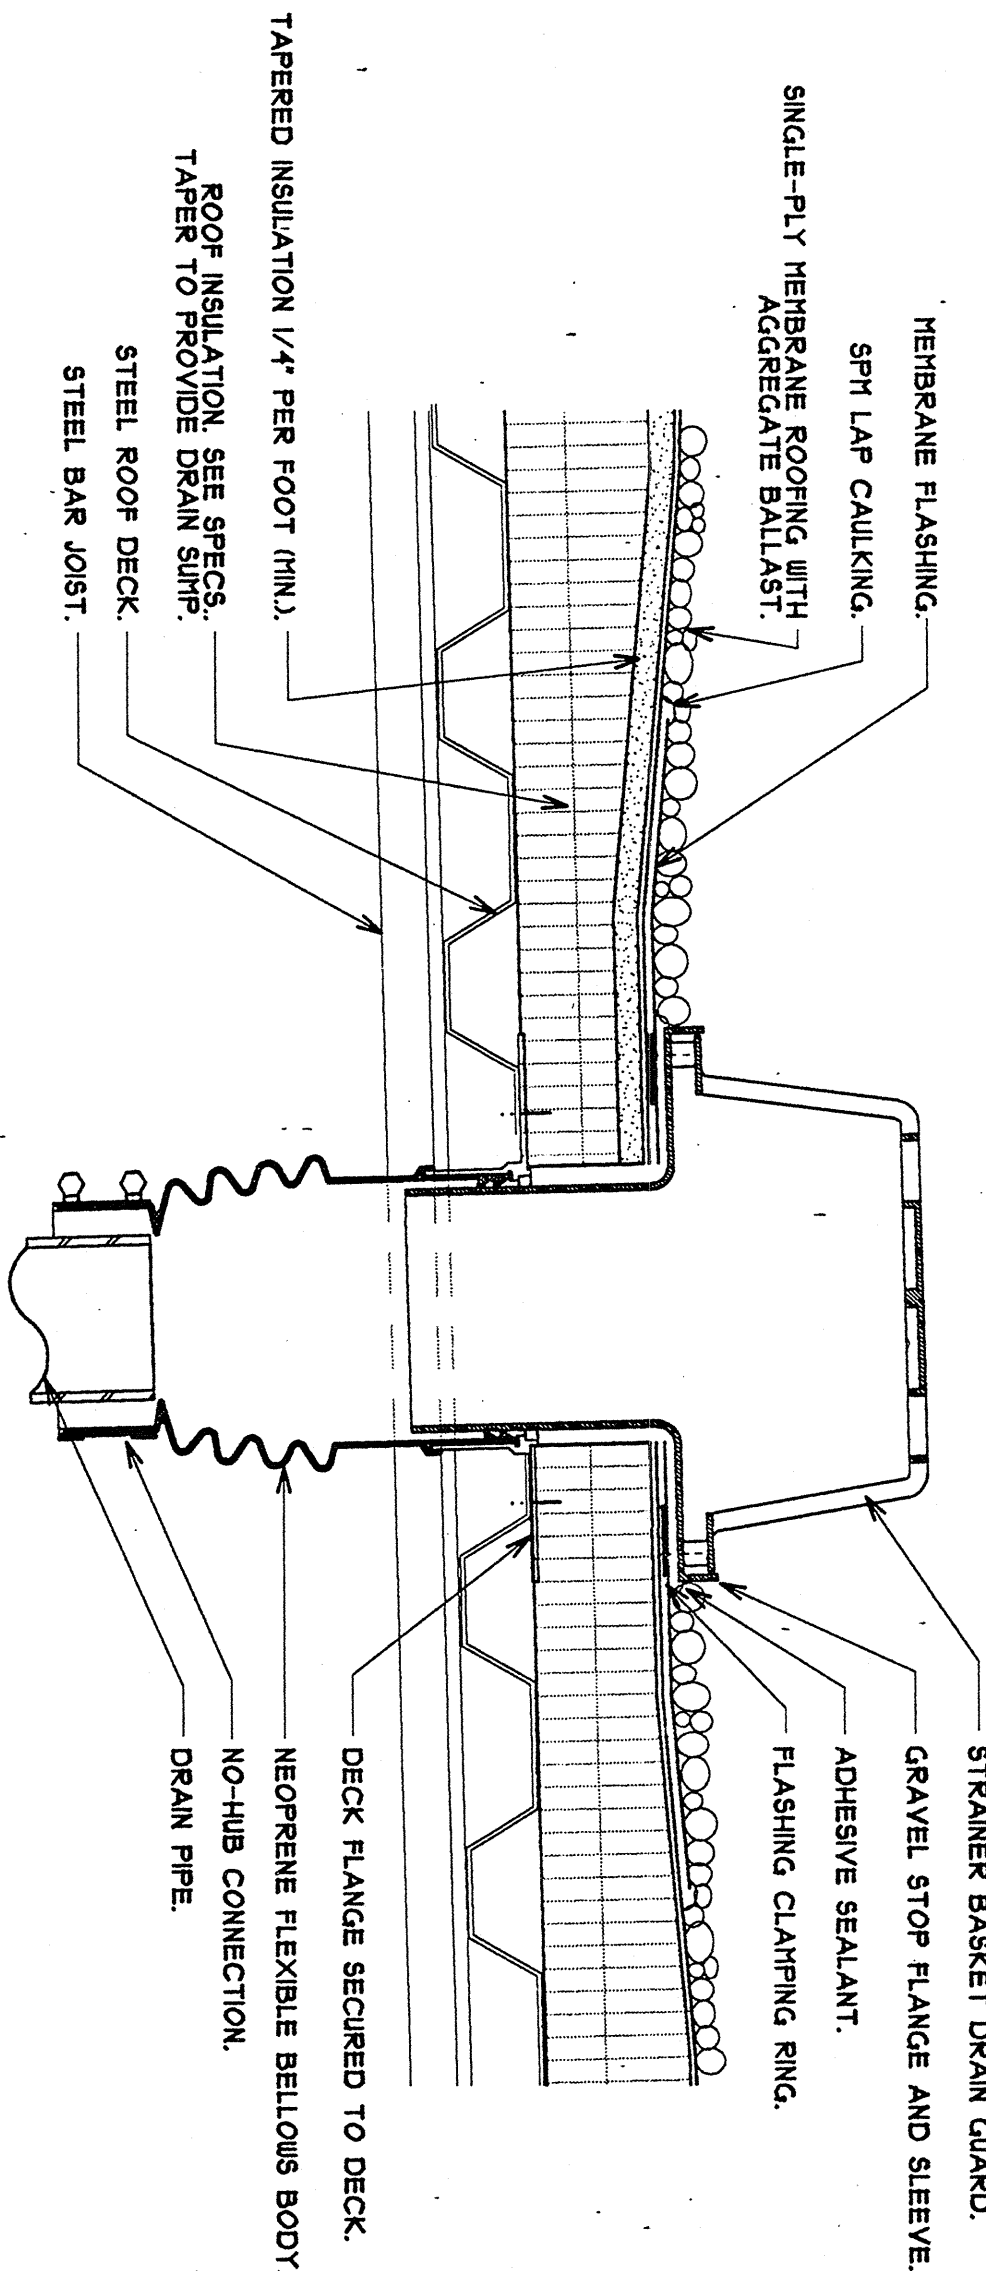

6 DETAIL AT ROOF DRAIN
SCALE: 3" = 1'-0"

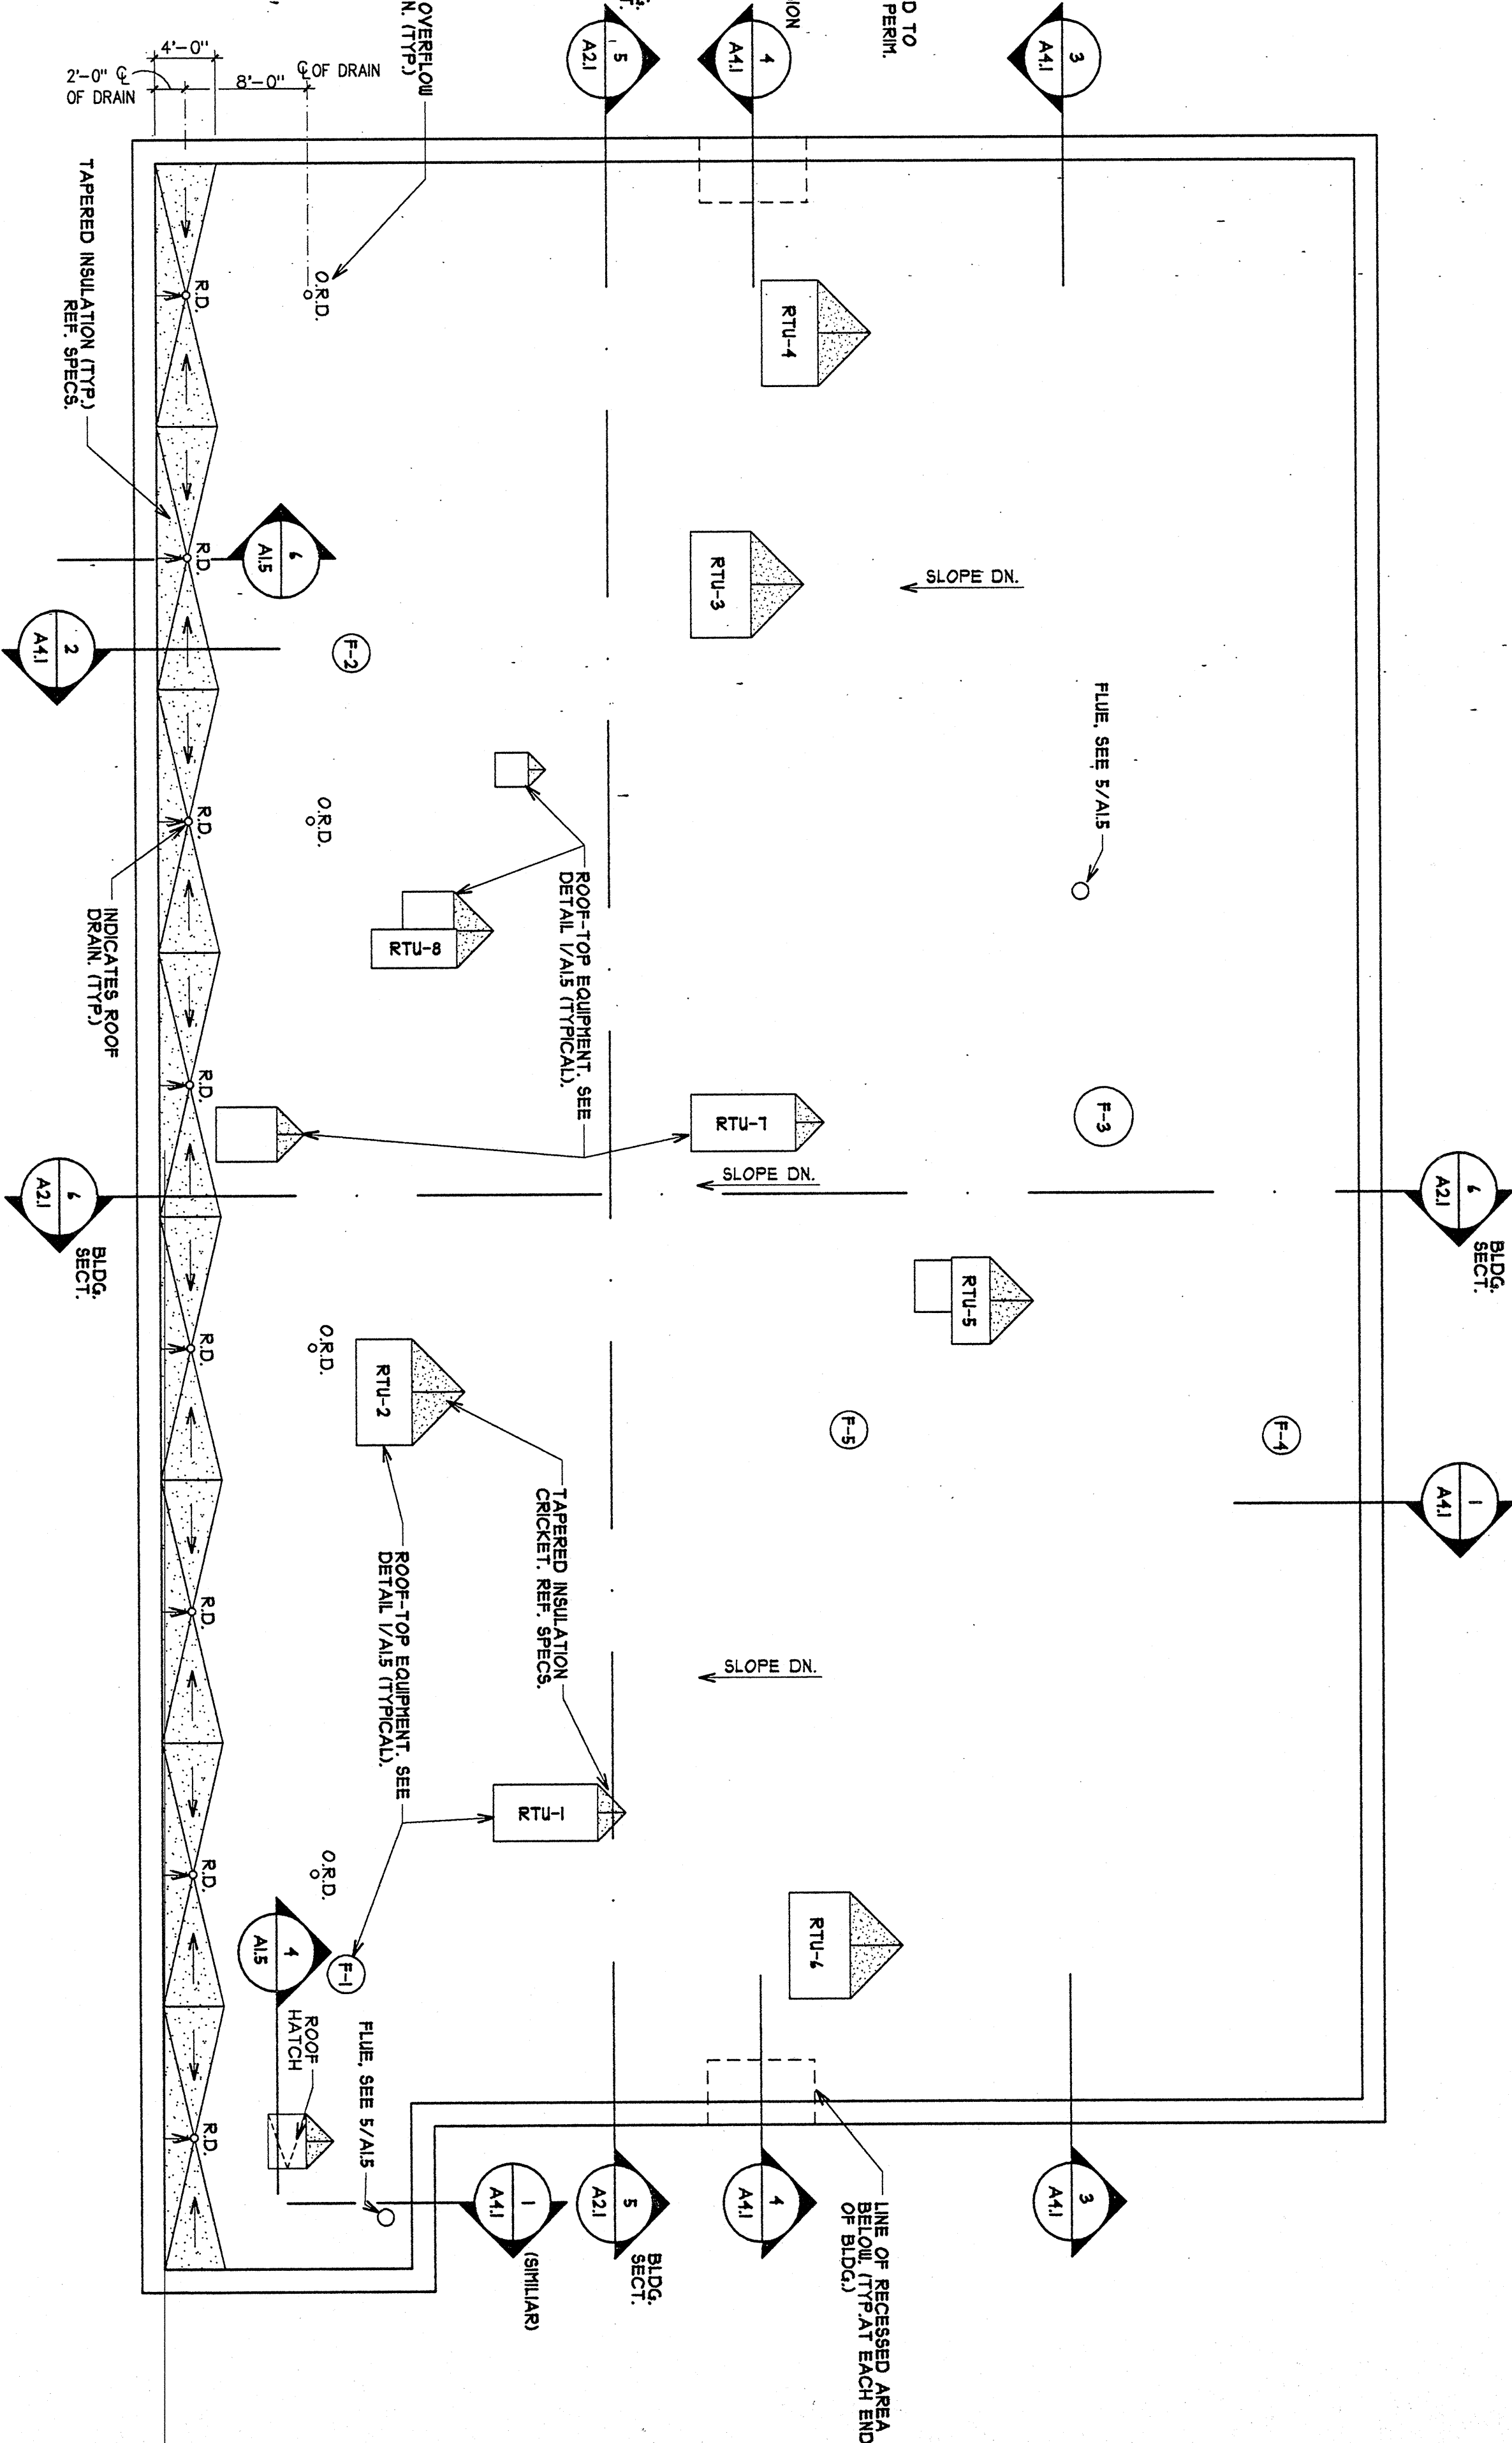


GENERAL ROOF NOTES:

1. ROOFING SHALL BE 40 MIL SINGLE-PLY MEMBRANE BALLASTED OVER POLYISOCYANURATE INSULATION. REFER TO SPECIFICATIONS.
2. ALL ROOF PENETRATIONS SHALL BE FLASHED/SEALED AS PER ROOFING MANUFACTURER'S REQUIREMENTS AND RECOMMENDATIONS.
3. MIN. ROOF SLOPE SHALL BE 1/4" PER FOOT. TAPERED INSULATION CRICKETS TO BE 4'-0" WIDE (MINIMUM). PROVIDE TAPERED INSULATION CRICKETS AS INDICATED, INCLUDING PIPE BOXES (TYPICAL).
4. ALL CAP FLASHING TO HAVE E.I./C.I. AS REQUIRED BY MANUFACTURER AND RECOMMENDED BY THE CURRENT SHACMA MANUAL. REF. SPECS. (TYPICAL).
5. NO FACE NAILING ALLOWED AT CAP FLASHING.
6. ALL ROOF VENTS, EXHAUST CAPS, EXPOSED PIPING AND OTHER ROOF PENETRATIONS TO BE PAINTED TO MATCH ROOF COLOR. VERIFY W/ ARCHITECT.
7. REFER TO MECHANICAL, PLUMBING, FIRE PROTECTION AND ELECTRICAL DRAWINGS FOR ALL OTHER ROOF PENETRATIONS THROUGH ROOF NOT INDICATED.
8. REFER TO MECHANICAL DRAWINGS FOR GAS LINE SUPPORT ON ROOF.




GRAPHIC SCALE

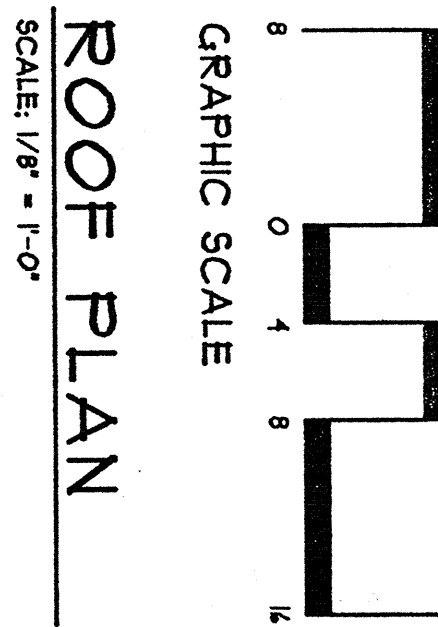

Revisions	Date

COLEMAN
FOSTER
architects
incorporated

Successor firm to motion and shoppes architects, inc.
441. 1912
1000 North Main Street
Columbia, SC 29201
Phone: 803.799.1111
Fax: 803.799.1112
Email: info@colemanfooster.com

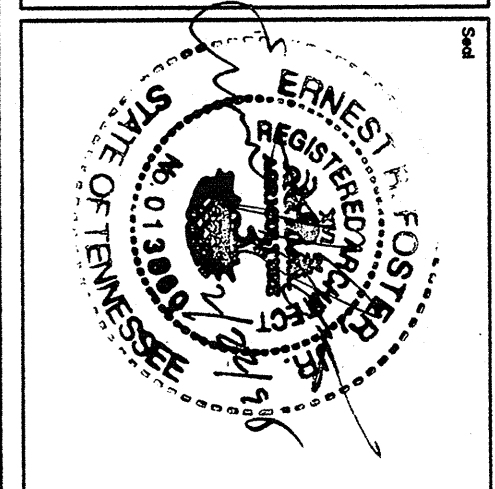

Project Title	Roofing Title
ENGINEERING SHOPS BUILDING	ROOF PLAN
Approved: Division Chief	Approved: Division Chief
Approved: Service Director	Approved: Service Director

Building Number	ID	RF	MC
VA MEDICAL CENTER HEMPHIS			

Project Title	Roofing Title
ENGINEERING SHOPS BUILDING	ROOF PLAN
Approved: Division Chief	Approved: Division Chief
Approved: Service Director	Approved: Service Director

Veterans Administration