


4 WALL SECTION
A1.1 SCALE: 3/4" = 1'-0"

NOTE: REFER TO SECTION 1/A1.1 FOR TYPICAL NOTES.

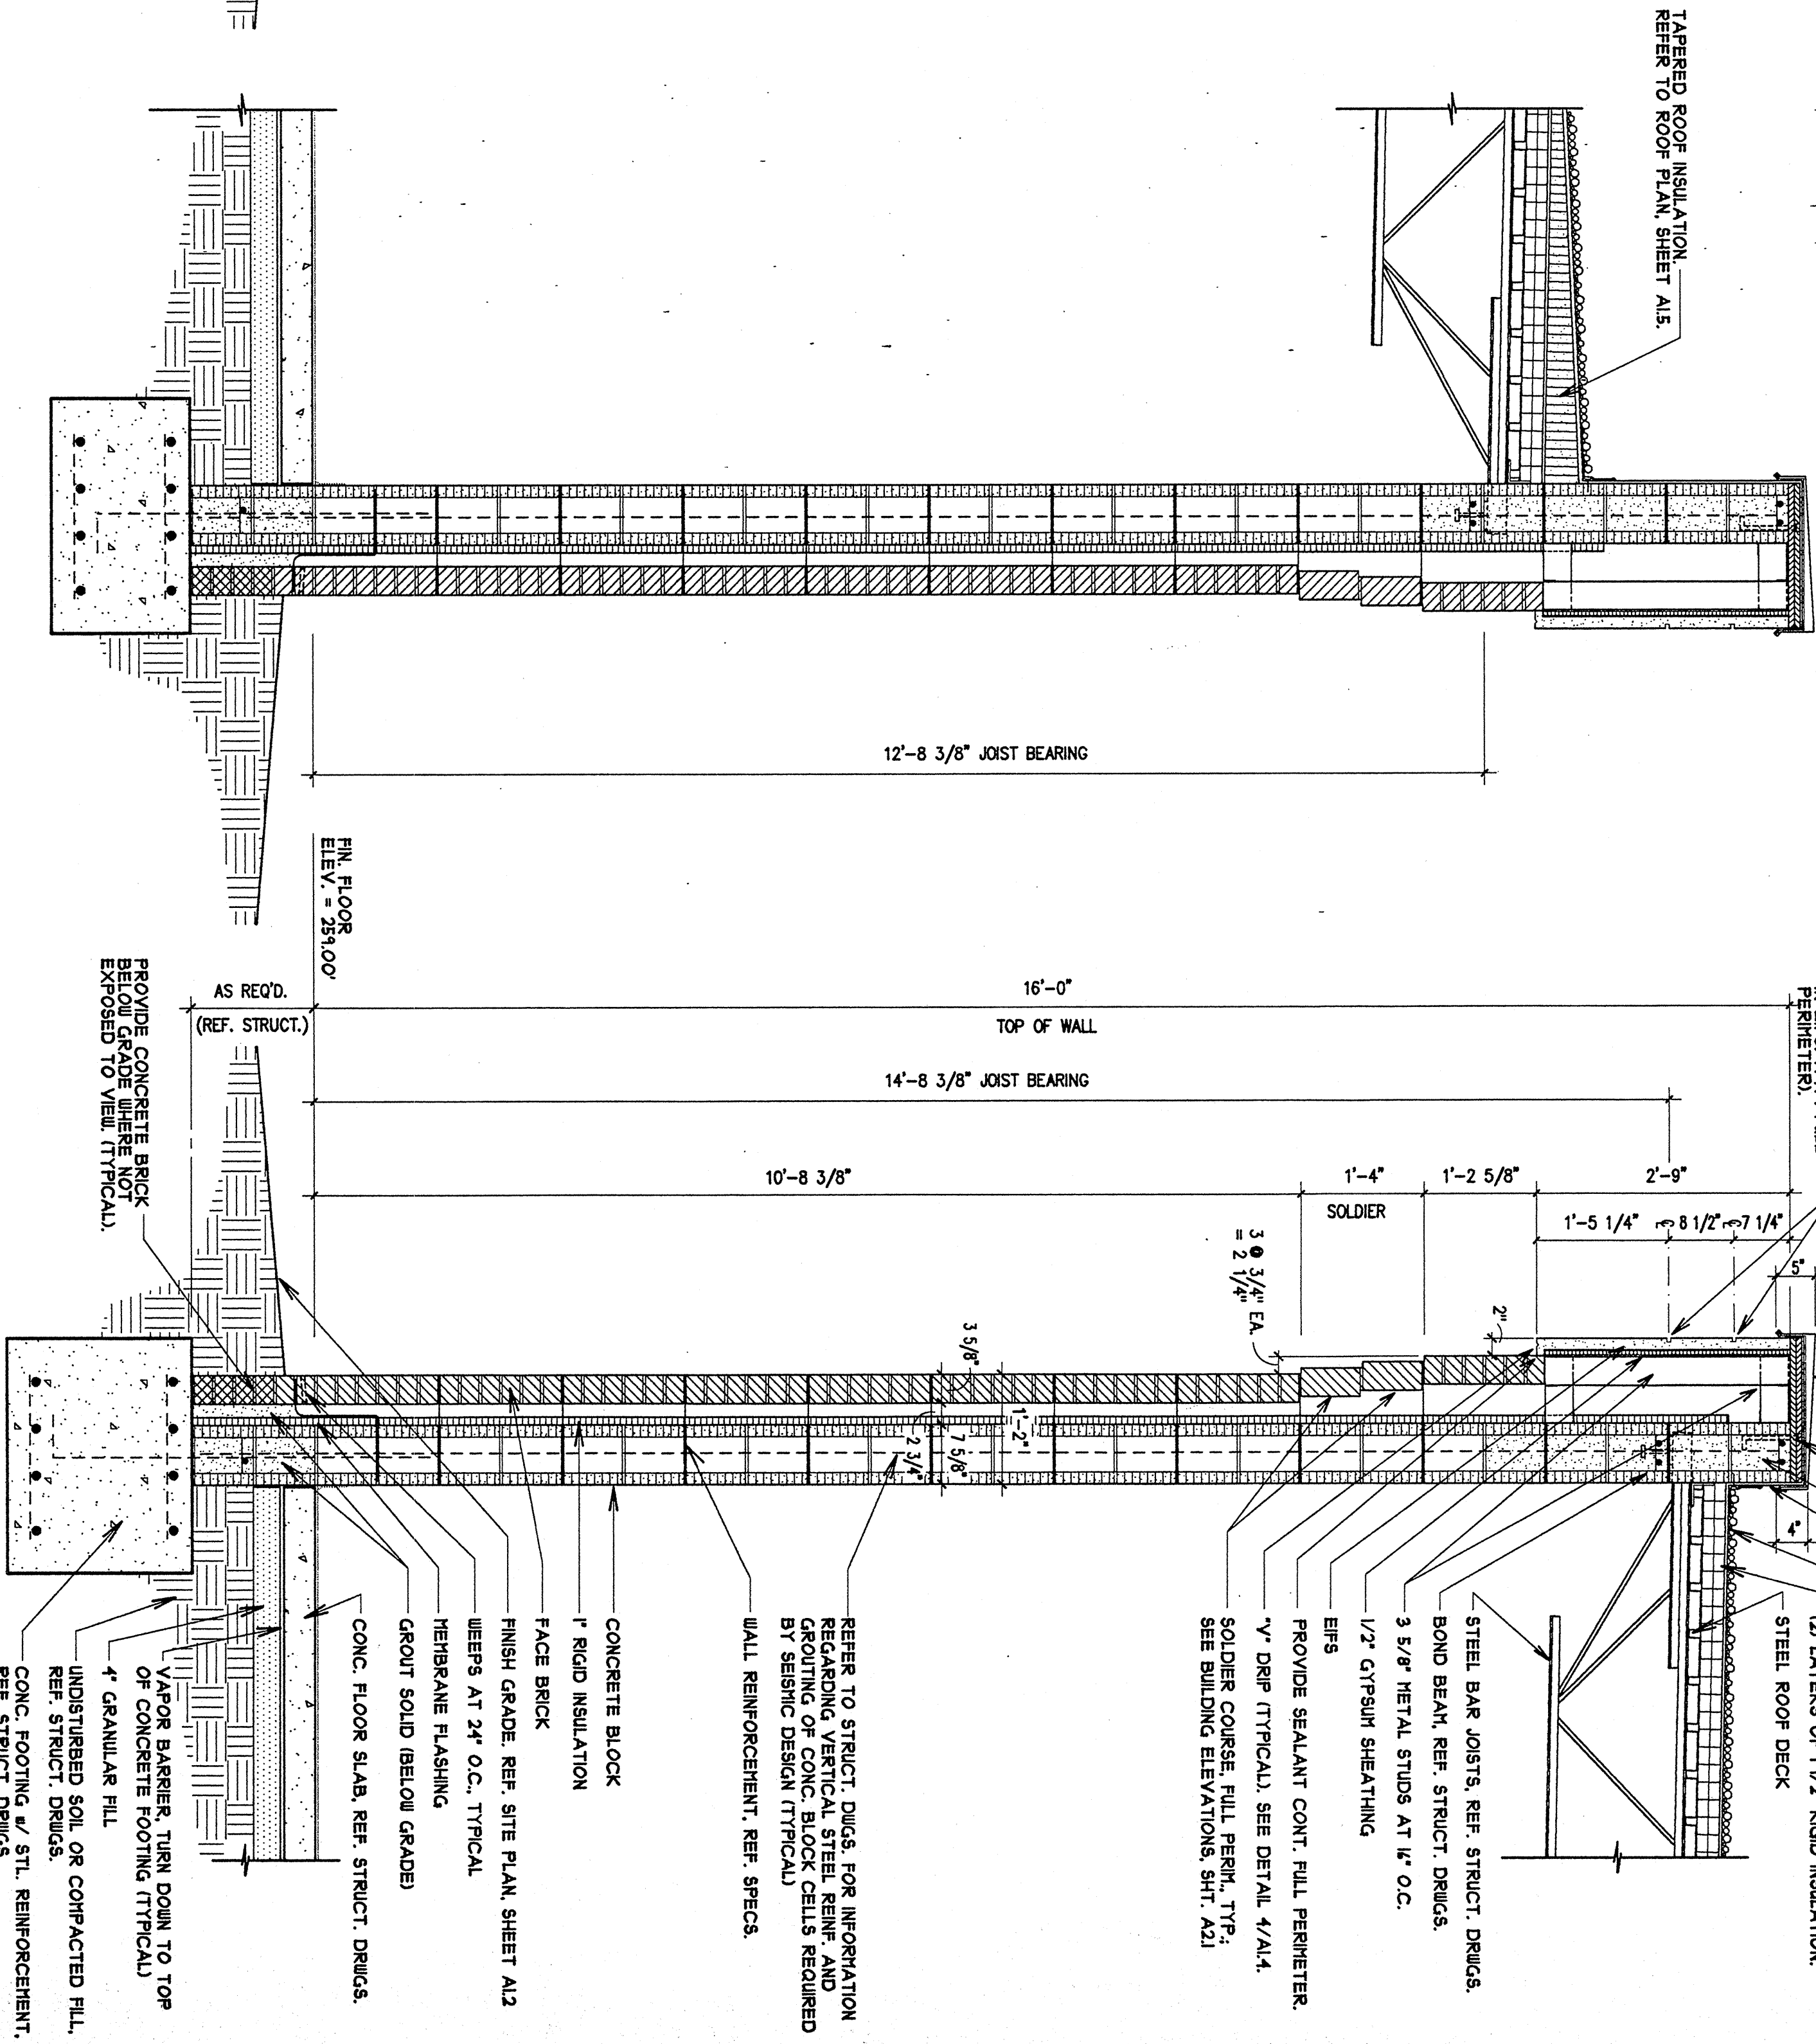


1 WALL SECTION
A1.1 SCALE: 3/4" = 1'-0"

NOTE: REFER TO STRUCT. DRUGS. FOR SIZES OF MISCELLANEOUS
STEEL ANGLES, CLIPS AND PLATES NOT INDICATED ON ARCHITECTURAL
PLANS. PAINT ALL WHERE EXPOSED TO VIEW (TYPICAL).

Revisions	Date

**COLEMAN
FOSTER
architects
incorporated**
5411 1912
605 2002 2003 2004 2005 2006 2007 2008 2009 2010 2011 2012 2013 2014 2015 2016 2017 2018 2019 2020
Charles E. Coleman, AIA - Principal Rany Foster, AIA - Principal

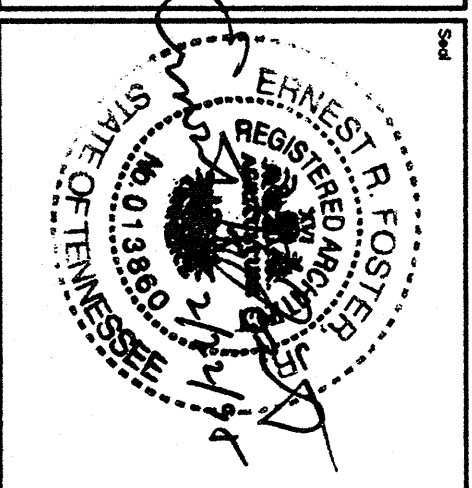

Project Title		Drawing No.	
WALL SECTIONS		A4.1	
Approved: Division Chief	Building Number	Checked: RF	Drawn: MC
Approved: Service Director	10		
Location		Project Title	
VA MEDICAL CENTER MEMPHIS		ENGINEERING SHOPS BUILDING	
Date		Project No.	
FEBRUARY 22, 1995		VA NO. 44-101	
		ARCH. NO. 2574	
Drawn: MC		Project Title	
A4.1		ENGINEERING SHOPS BUILDING	
Page 1 of 12		Veterans Administration	