



2 TYP. VTR DETAIL
SCALE: 1/2"=1'-0"
RE: 1/A1.4

3 TYP. OVERFLOW DRAIN
SCALE: 1"=1'-0"
RE: 1/A1.4


4 **TYP. ROOF DRAIN**
SCALE: 1/2"=1'-0"
RE: 1/A1.4

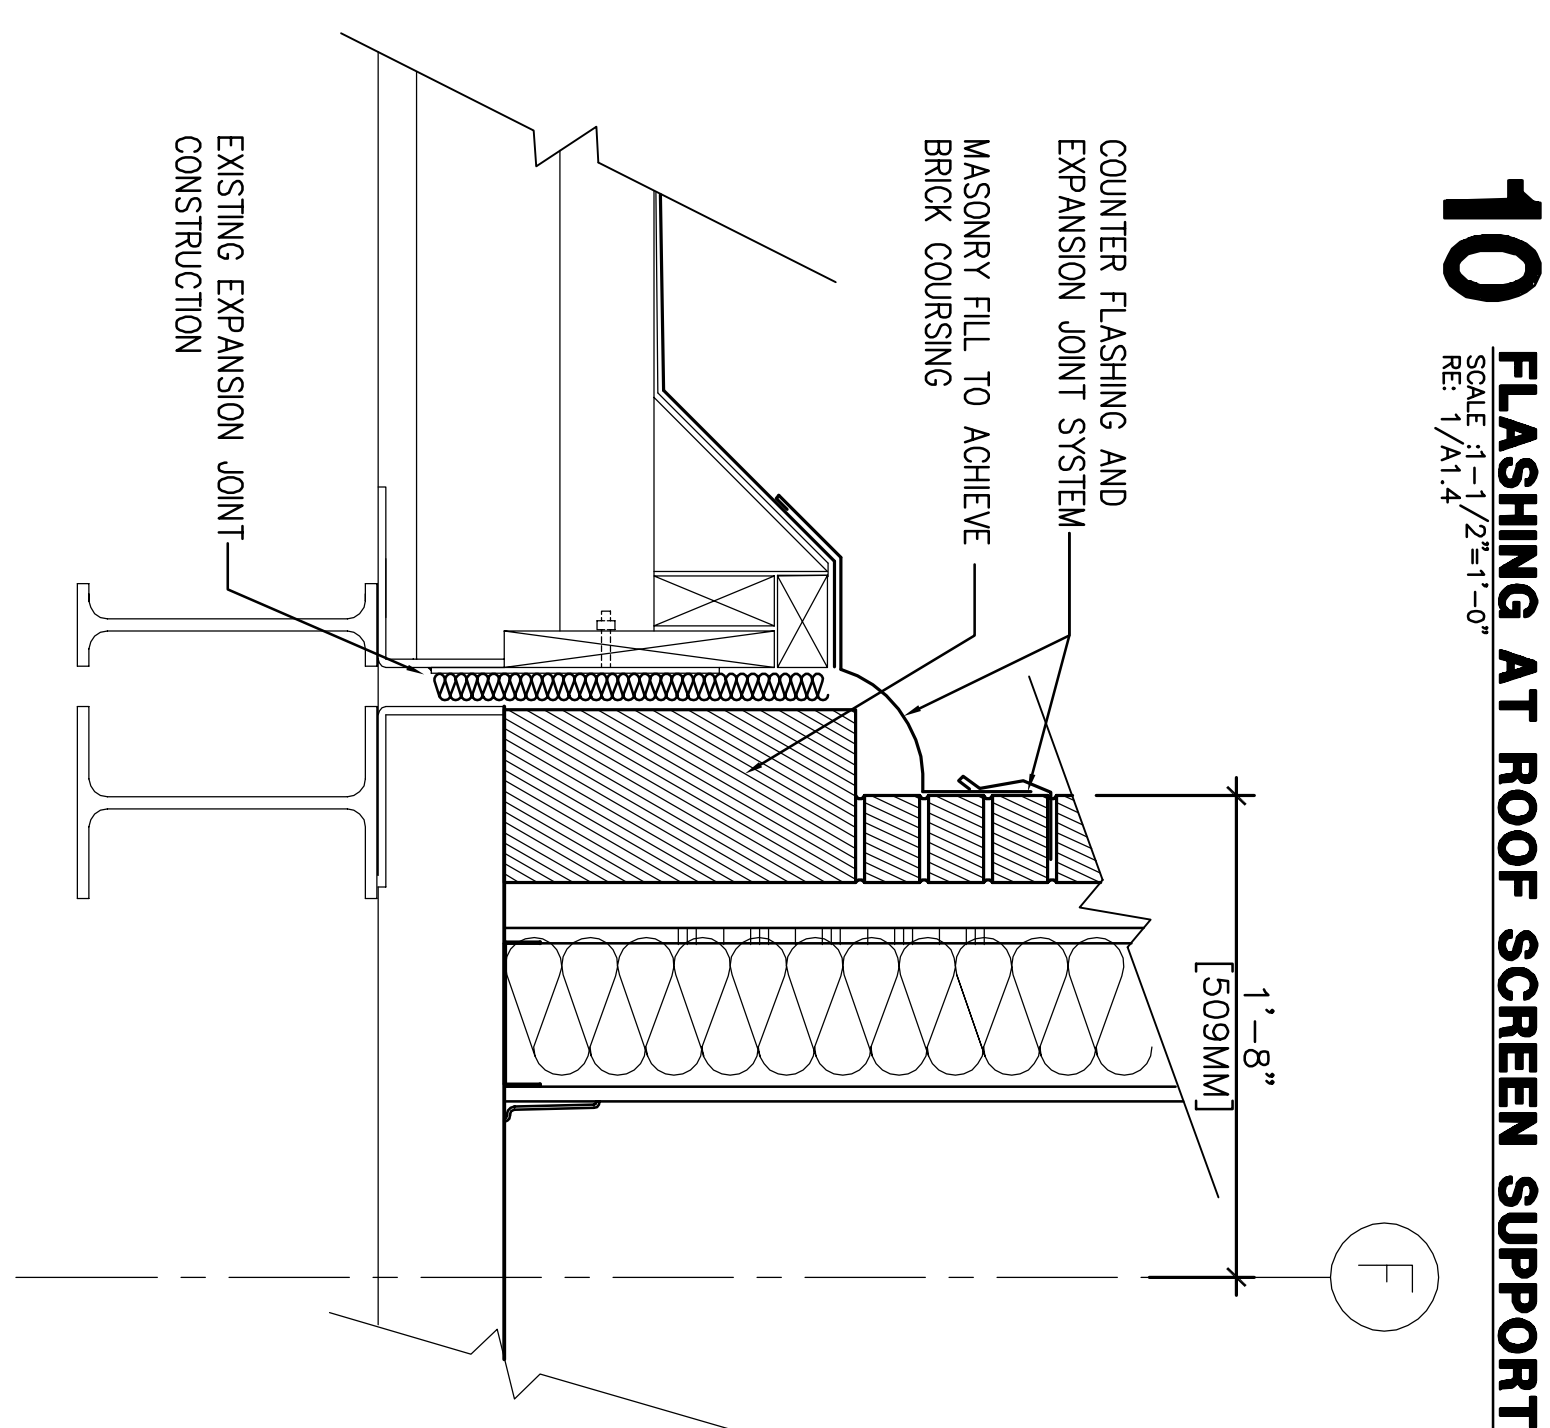


7 TYPICAL ROOF EDGE DETAIL

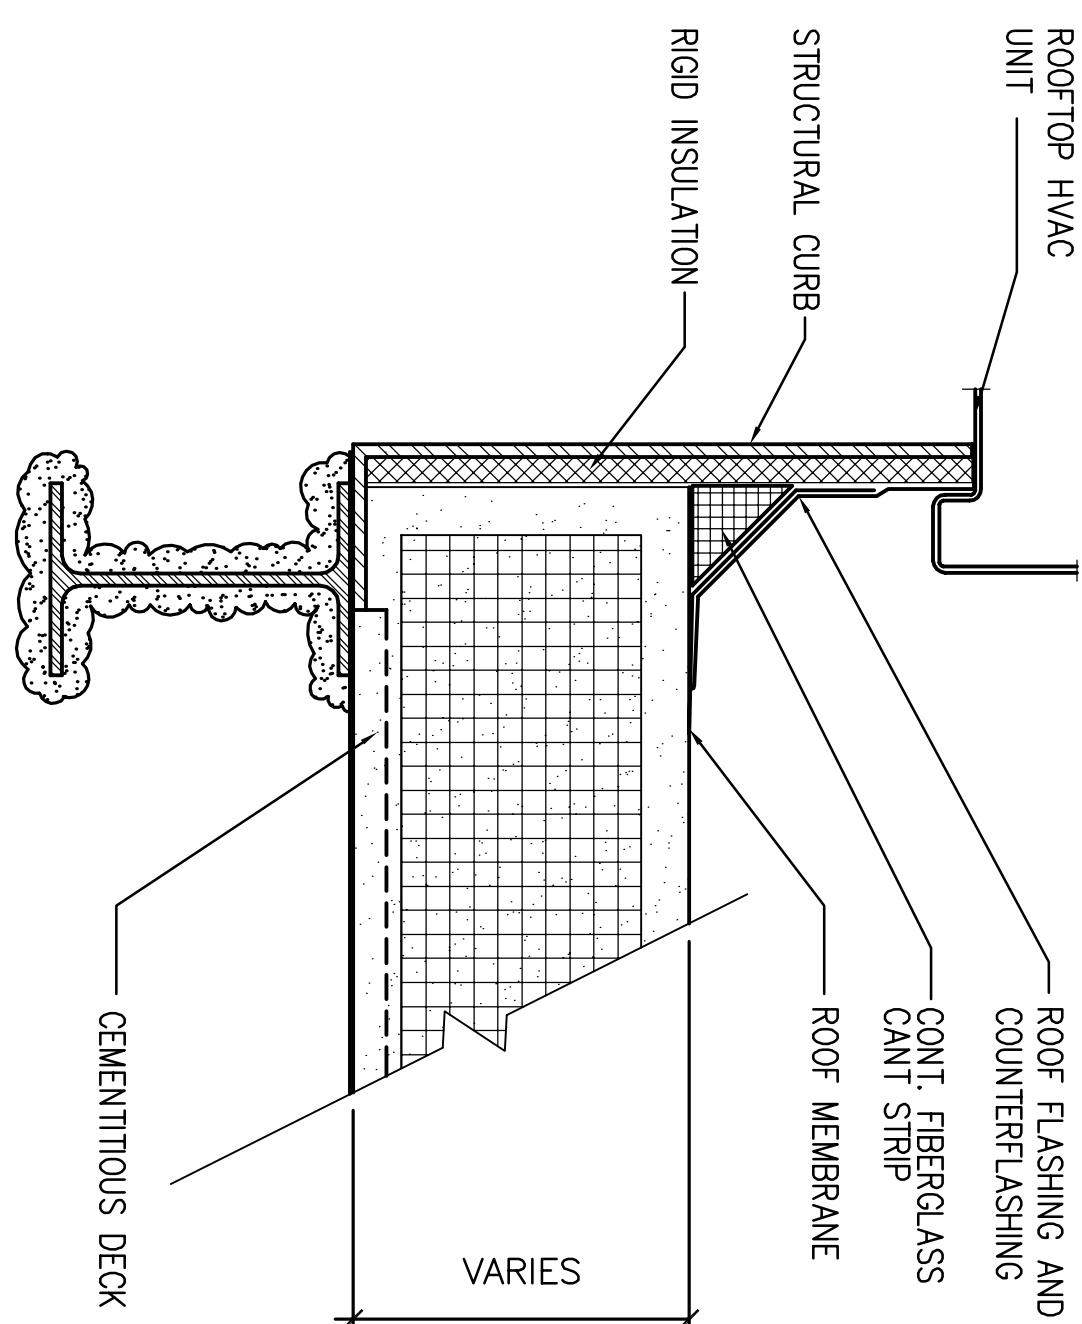

9 TYPICAL ROOF EXPANSION JOINT

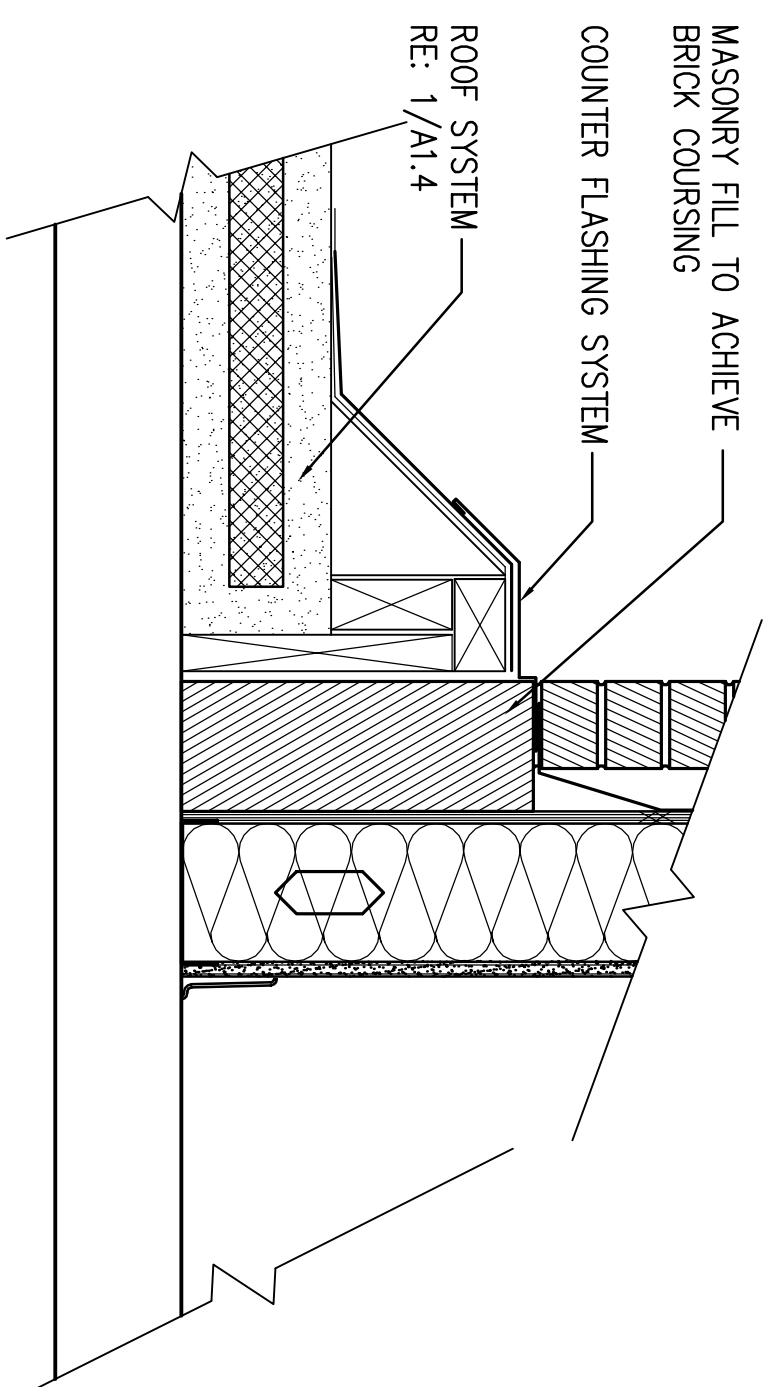


6 ROOF CURB DETAIL
SCALE: 1/2"=1'-0"
RE: 1/A1.4

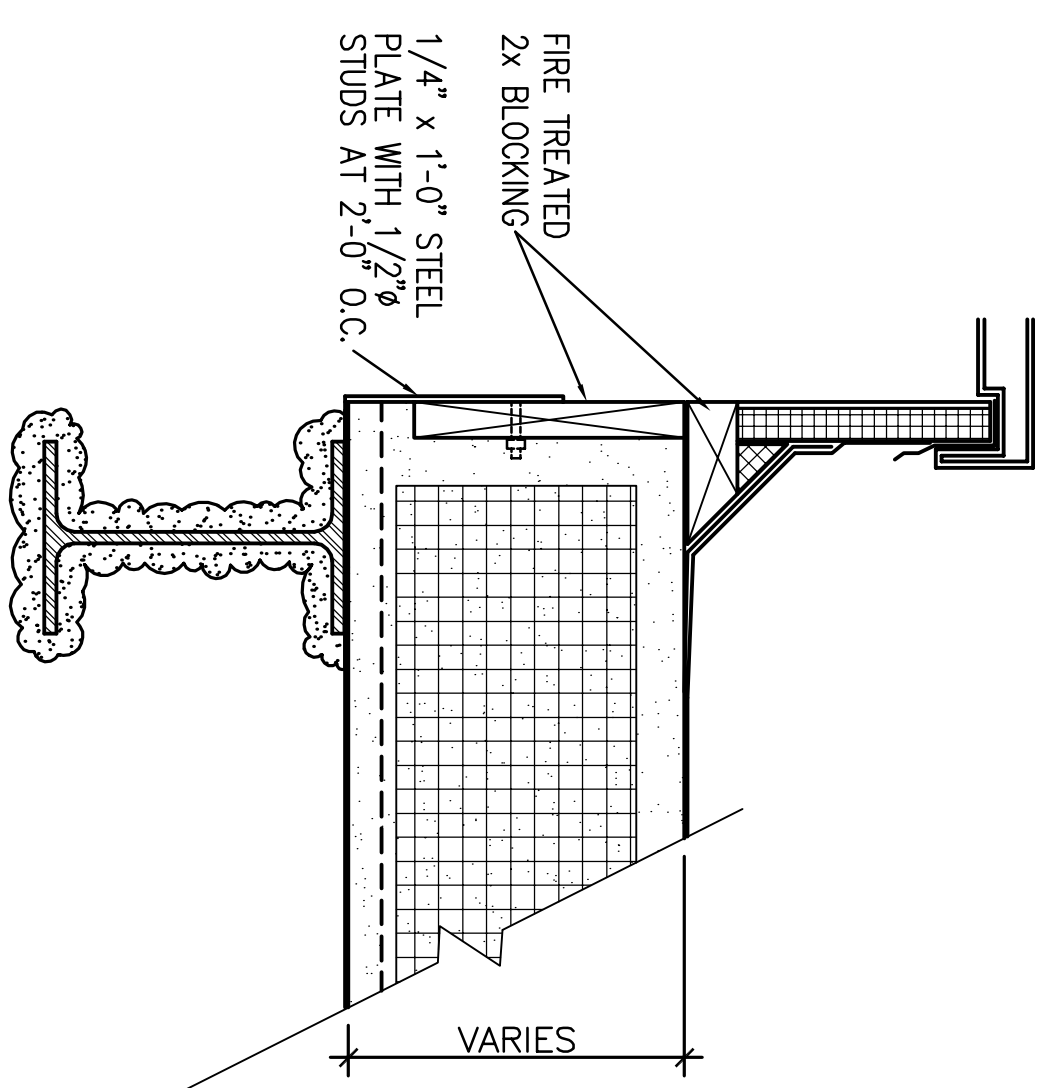

5 ROOF SCUTTLE DETAIL

8 FLASHING DETAIL

SCALE 1/4"=1'-0"

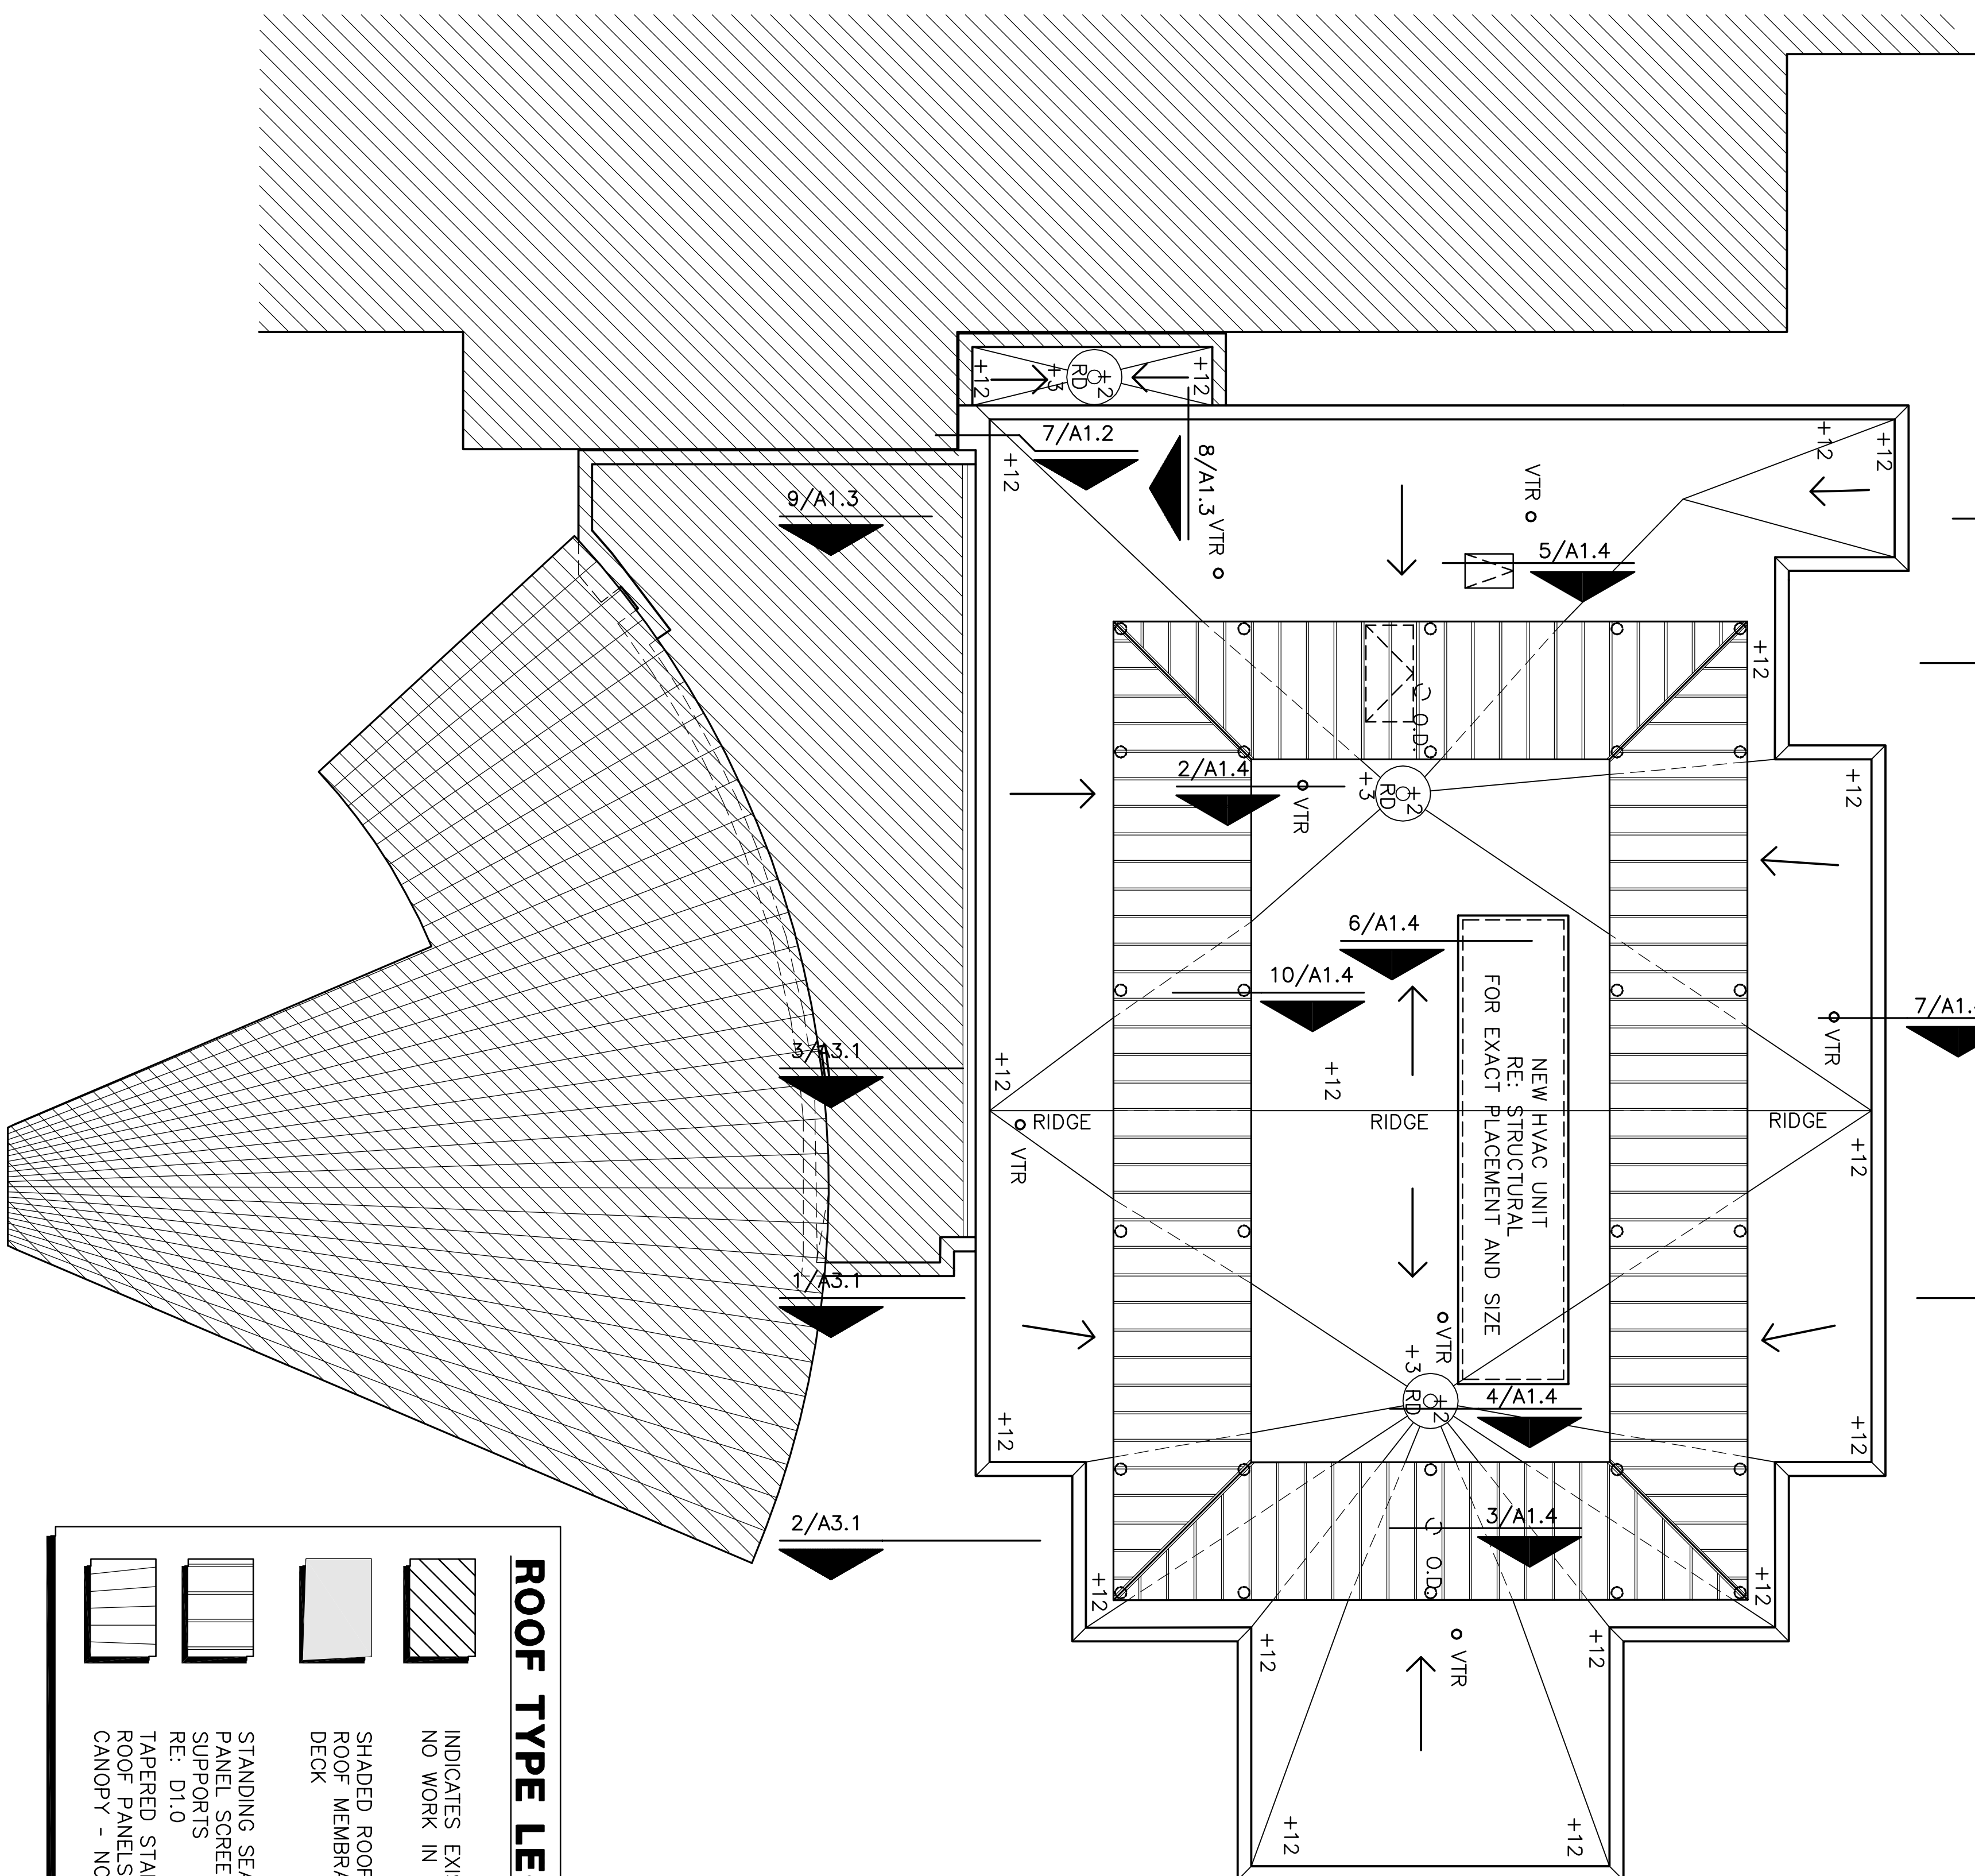

ROOF TYPE LEGEND:

INDICATES EXISTING CONSTRUCTION
NO WORK IN THIS AREA

SHADED ROOF AREAS CONSIST OF
ROOF MEMBRANE ON CEMENTITIOUS
DECK

STANDING SEAM METAL ROOF
PANELS STEEPLY AND
SUPPORTS

RE: D10

TAEARED STANDING SEAM METAL
ROOF PANELS AT EXISTING
CANOPY - NO WORK REQUIRED



APPROVED: MEDICAL CENTER DIRECTOR	APPROVED: FACILITY PLANNER	APPROVED: SERVICE CHIEF
APPROVED: ASSOCIATE DIRECTOR	APPROVED: CHIEF ENGINEER	APPROVED: SERVICE CHIEF
APPROVED: ASSISTANT DIRECTOR	APPROVED: SERVICE CHIEF	APPROVED: SERVICE CHIEF

DRAWING TITLE		PROJECT TITLE		DATE	
ROOF PLAN DETAILS		VETERAN'S ADMINISTRATION OUTPATIENT CARE FACILITY THIRD FLOOR ADDITION		17 NOVEMBER 2000	
BUILDING NUMBER		CHECKED	DRAWN	PROJECT NUMBER	
--		TFCC-BG	TFCC-SB	82998	
LOCATION		DRAWING NO.			
FAYETTEVILLE, AR		A1.4			
		Dwg 8 of 43			