

A

B

C

D

E

F

1

A

B

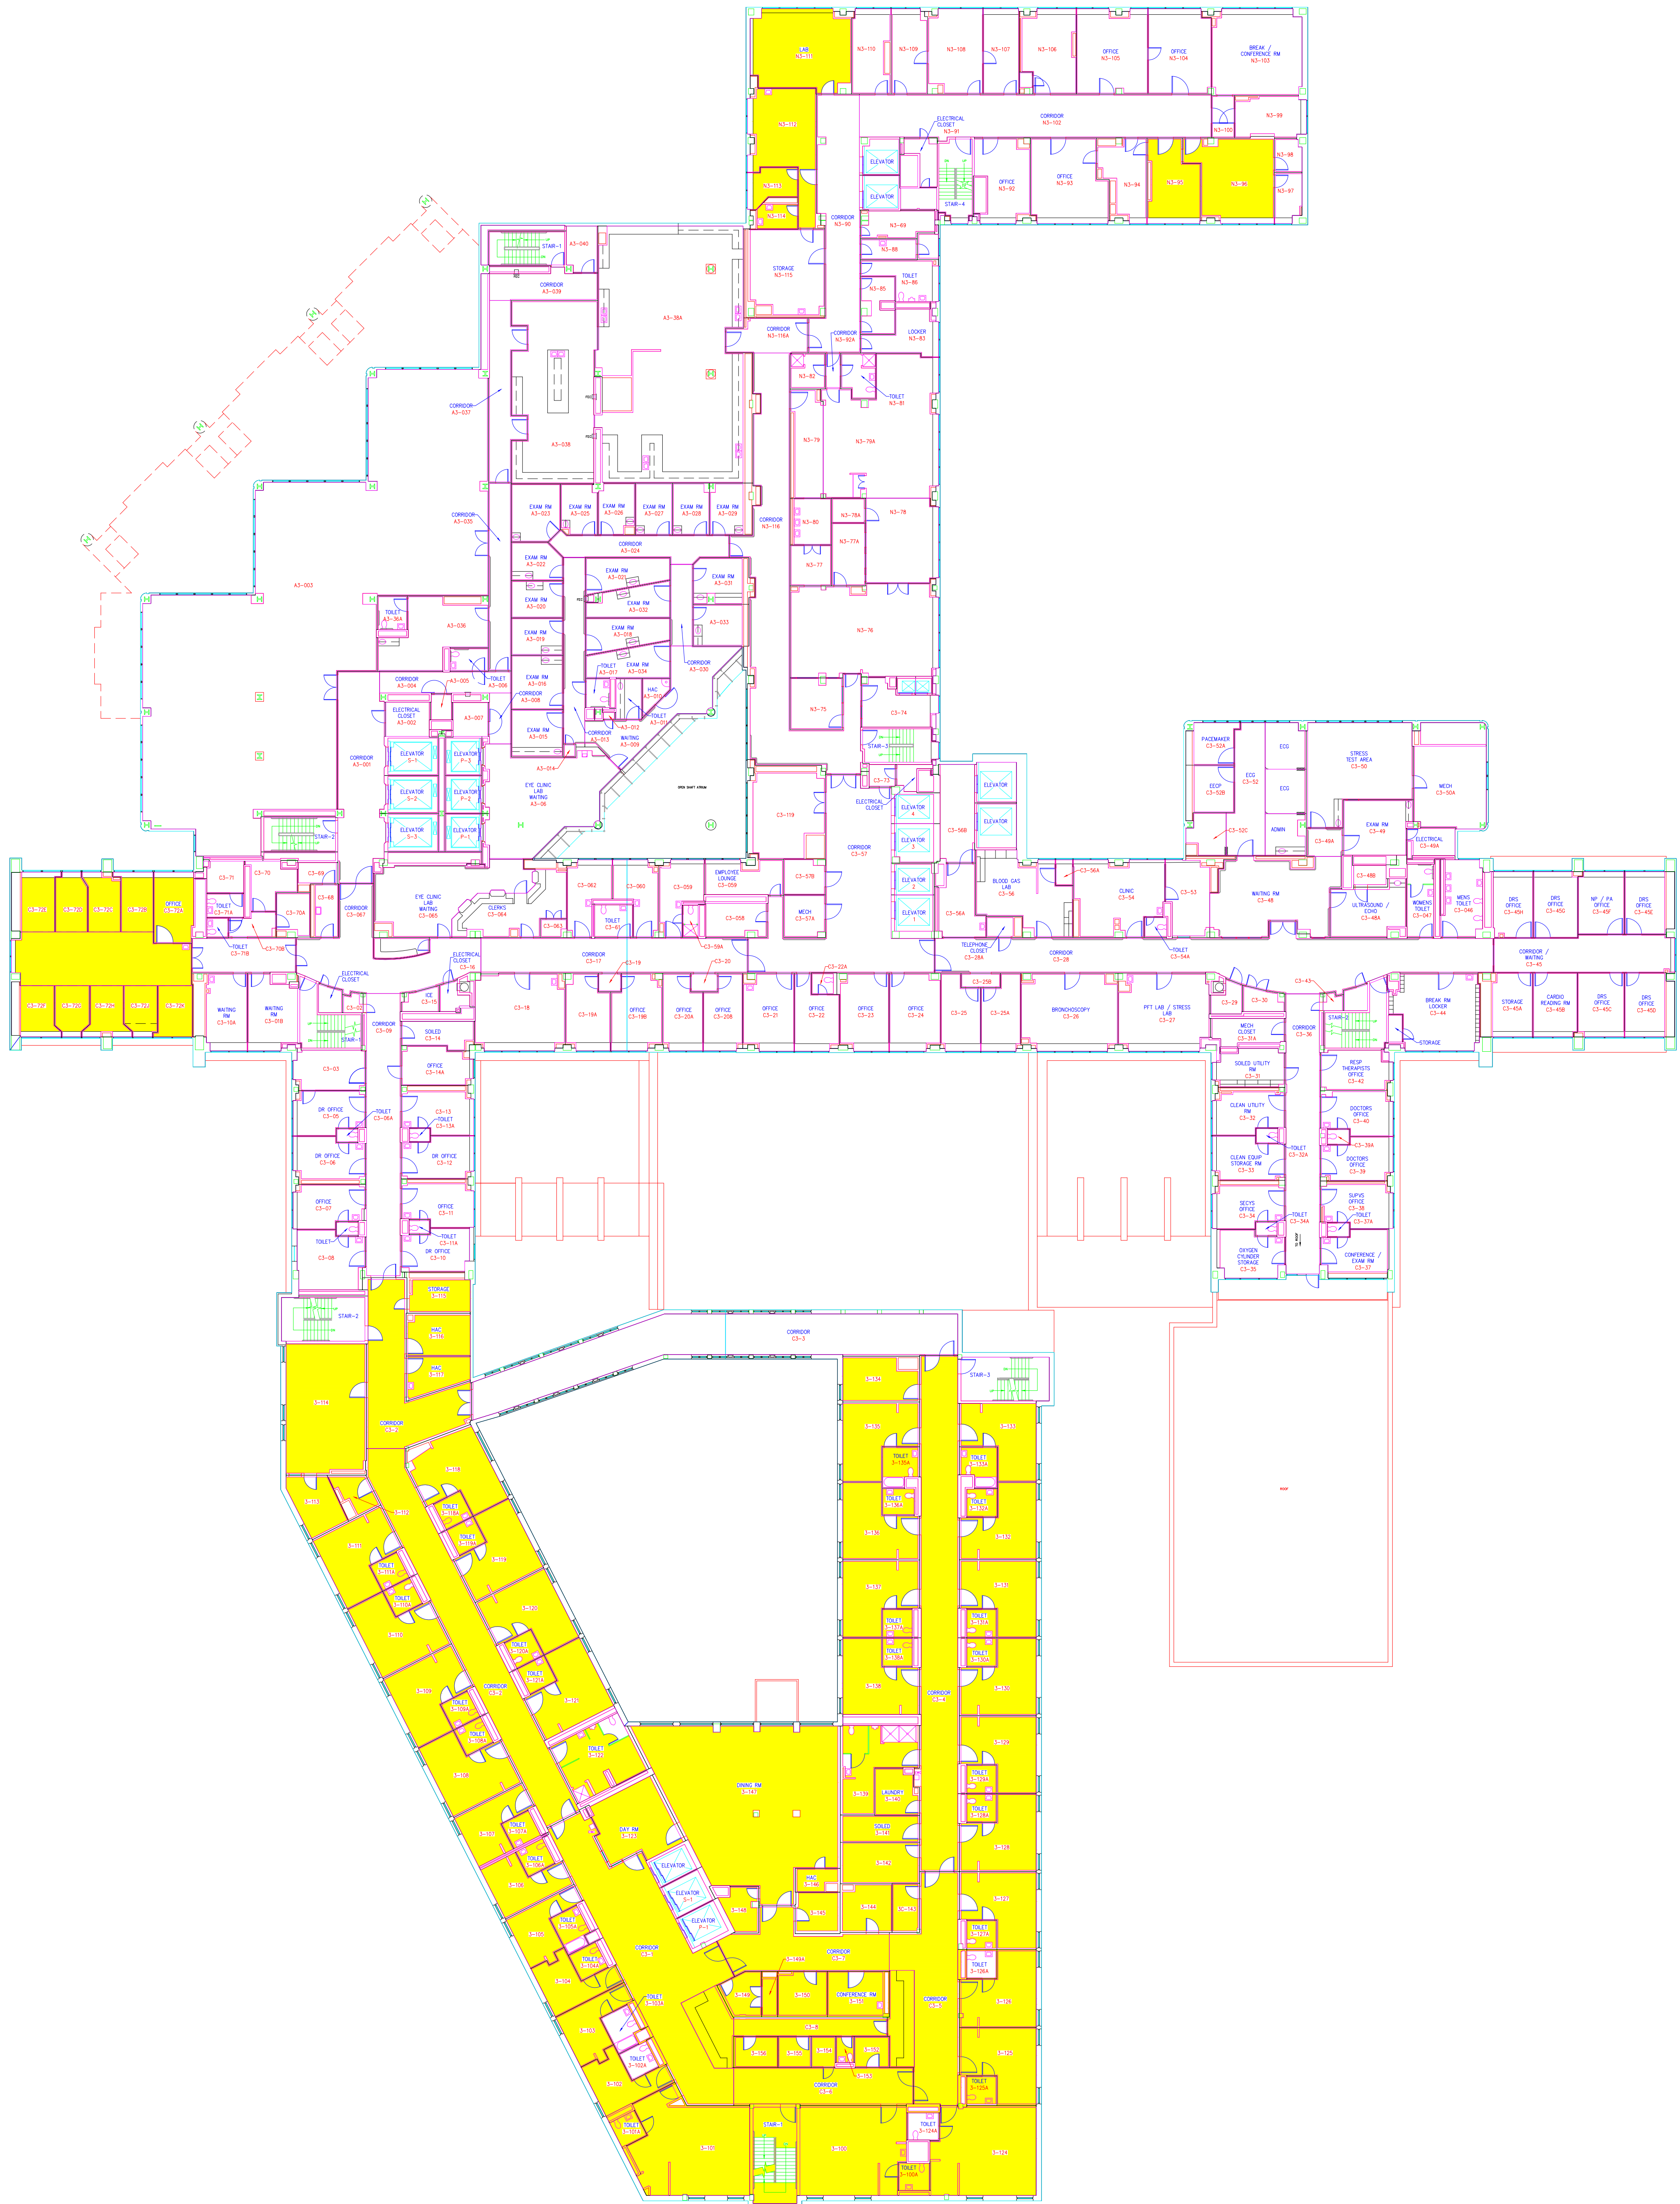
C

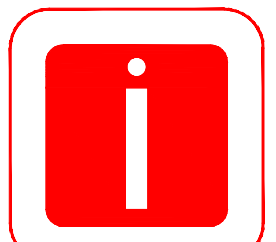
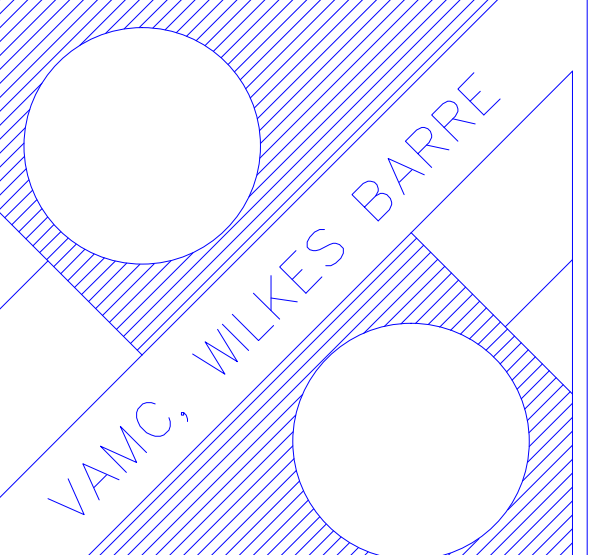
D

E

F

three inches = one foot
one and one half inches = one foot
one inch = one foot
three quarters inch = one foot
one half inch = one foot
three eighths inch = one foot
one quarter inch = one foot
one eighth inch = one foot



| | | | | | | | | | | | | | | | | |
|---------------------------|--|-------------------------|-------------------|------------------------------------------------|---------------------------------------------------------------------------------------------------------------------------------------------------------------------------------------------------|------------------|----------------------------------------------------|-------------|---------------|--|-----------------------------------|--|---------------------------------------------------------------------------------------|--|-----------------------------------|--|
| Revisions | | Date | Professional Seal | |  Indus Systems, Inc. 2352, Main Street, Concord MA 01742 Tel: 978-461-0555 www.indus-systems.com | | Drawing Title THIRD FLOOR PLAN ARCHITECTURAL | | Project Title | | Date 10-27-2010 Project No. | |  | | VA Department of Veterans Affairs | |
| Approved: Project Manager | | Approved: Service Chief | | Building Number 01 | | Checked Drawn | | Drawing No. | | | | | | | | |
| Approved: Service Chief | | Approved: Service Chief | | Location VAMC, WILKES BARRE PENNSYLVANIA | | Drawing No. | | | | | | | | | | |