




1 TYPICAL WHEELCHAIR LAVATORY DETAIL
SCALE: NONE

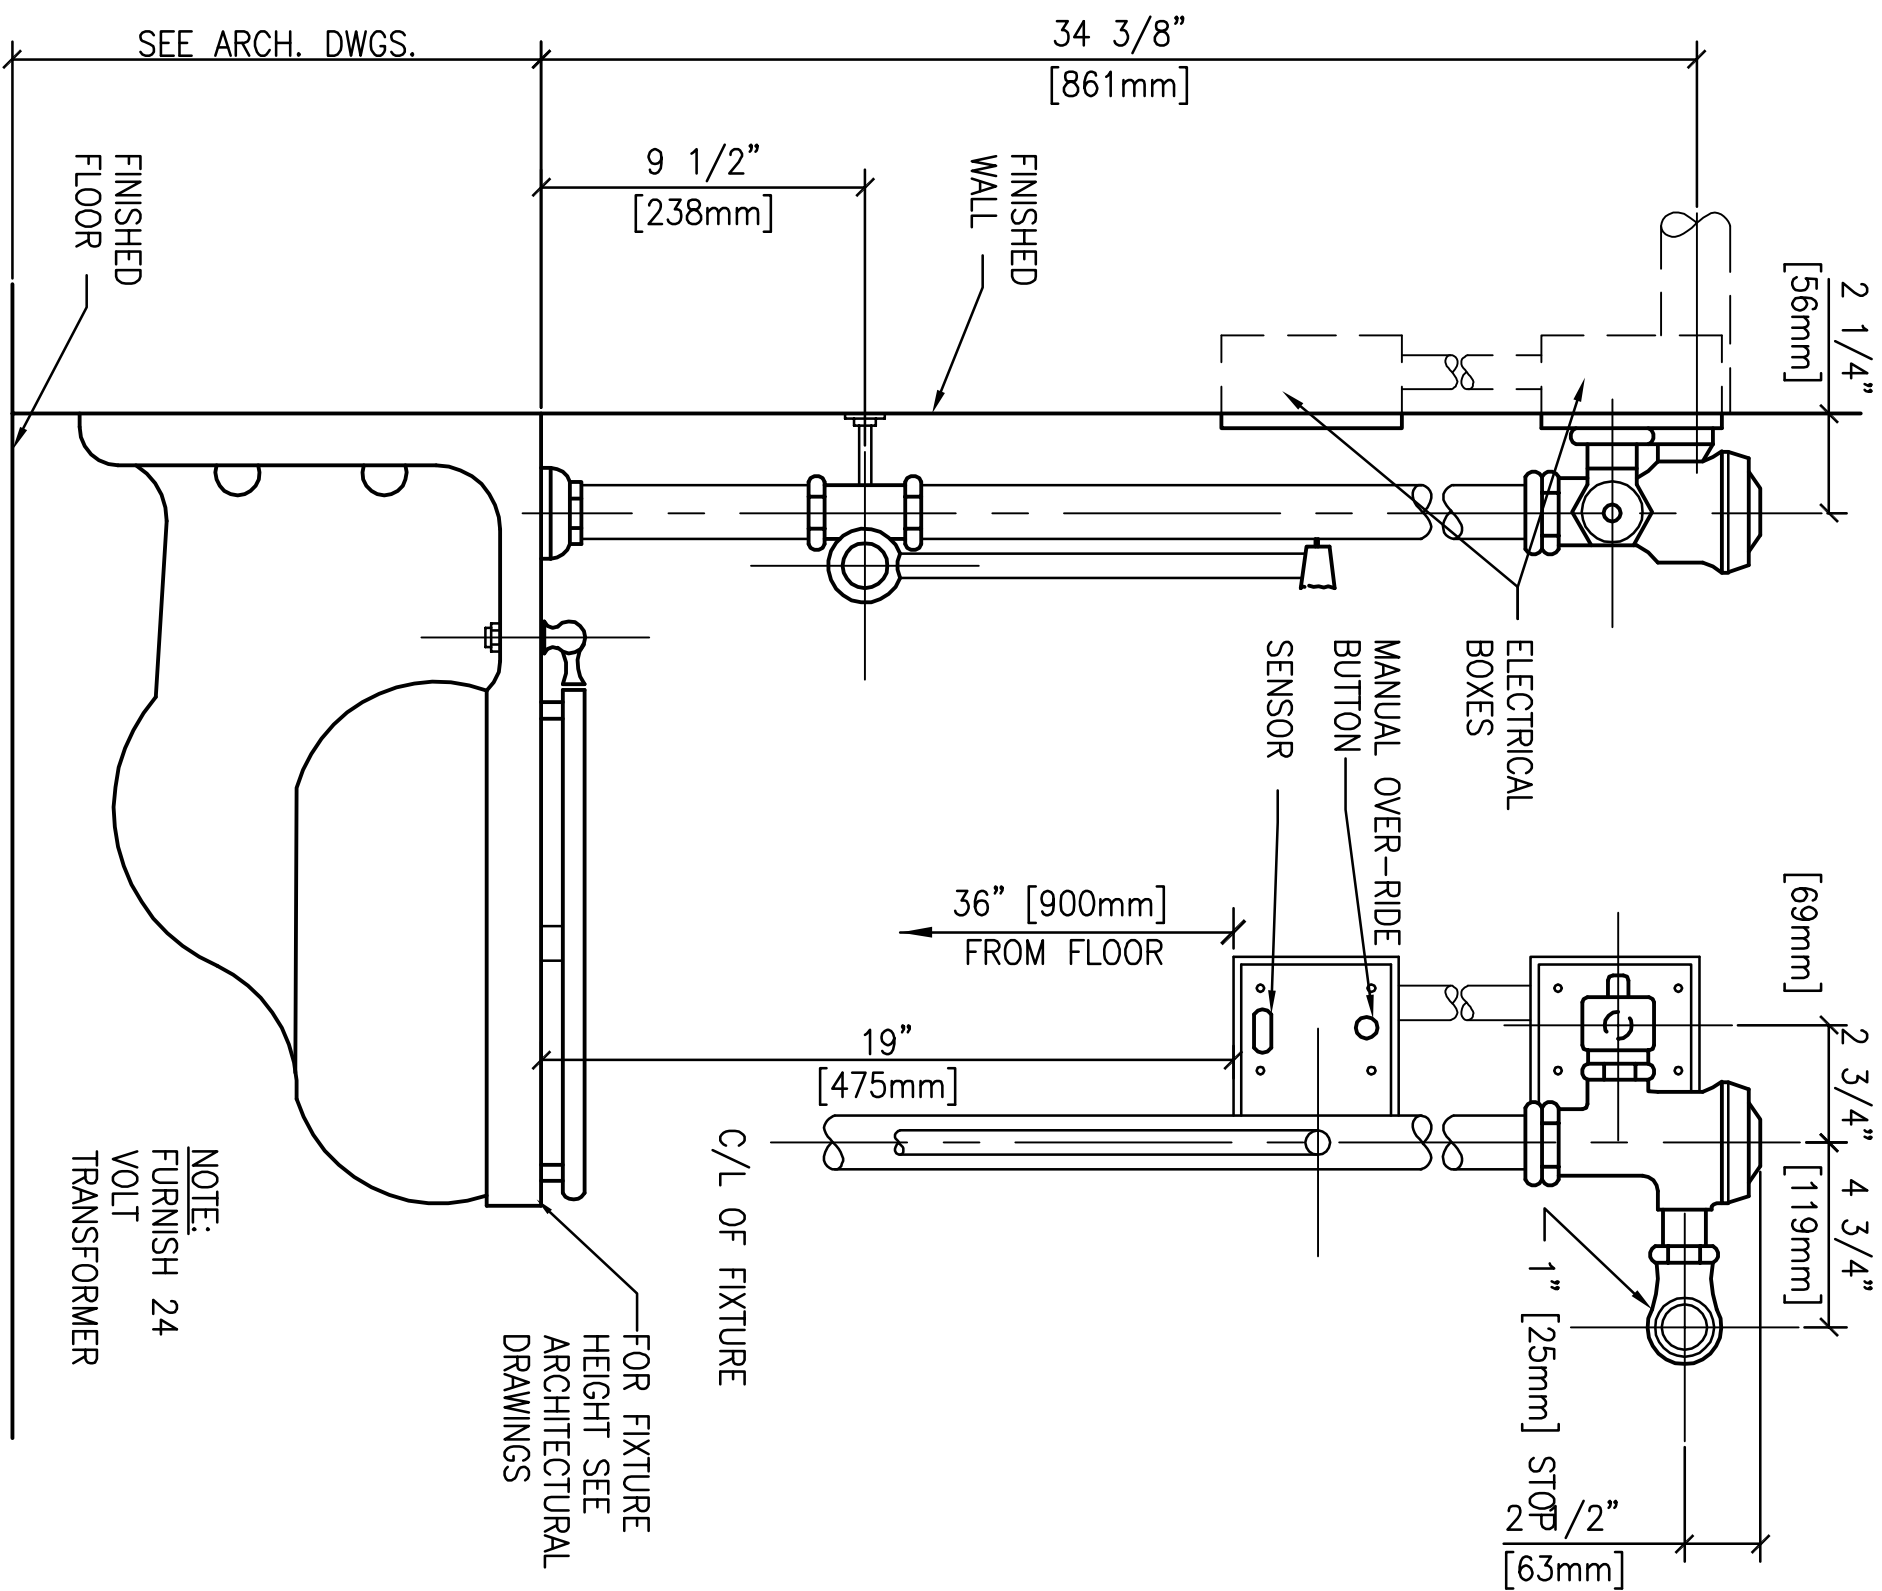


2 WATER CLOSET DETAIL - SENSOR OPERATED
SCALE: NONE

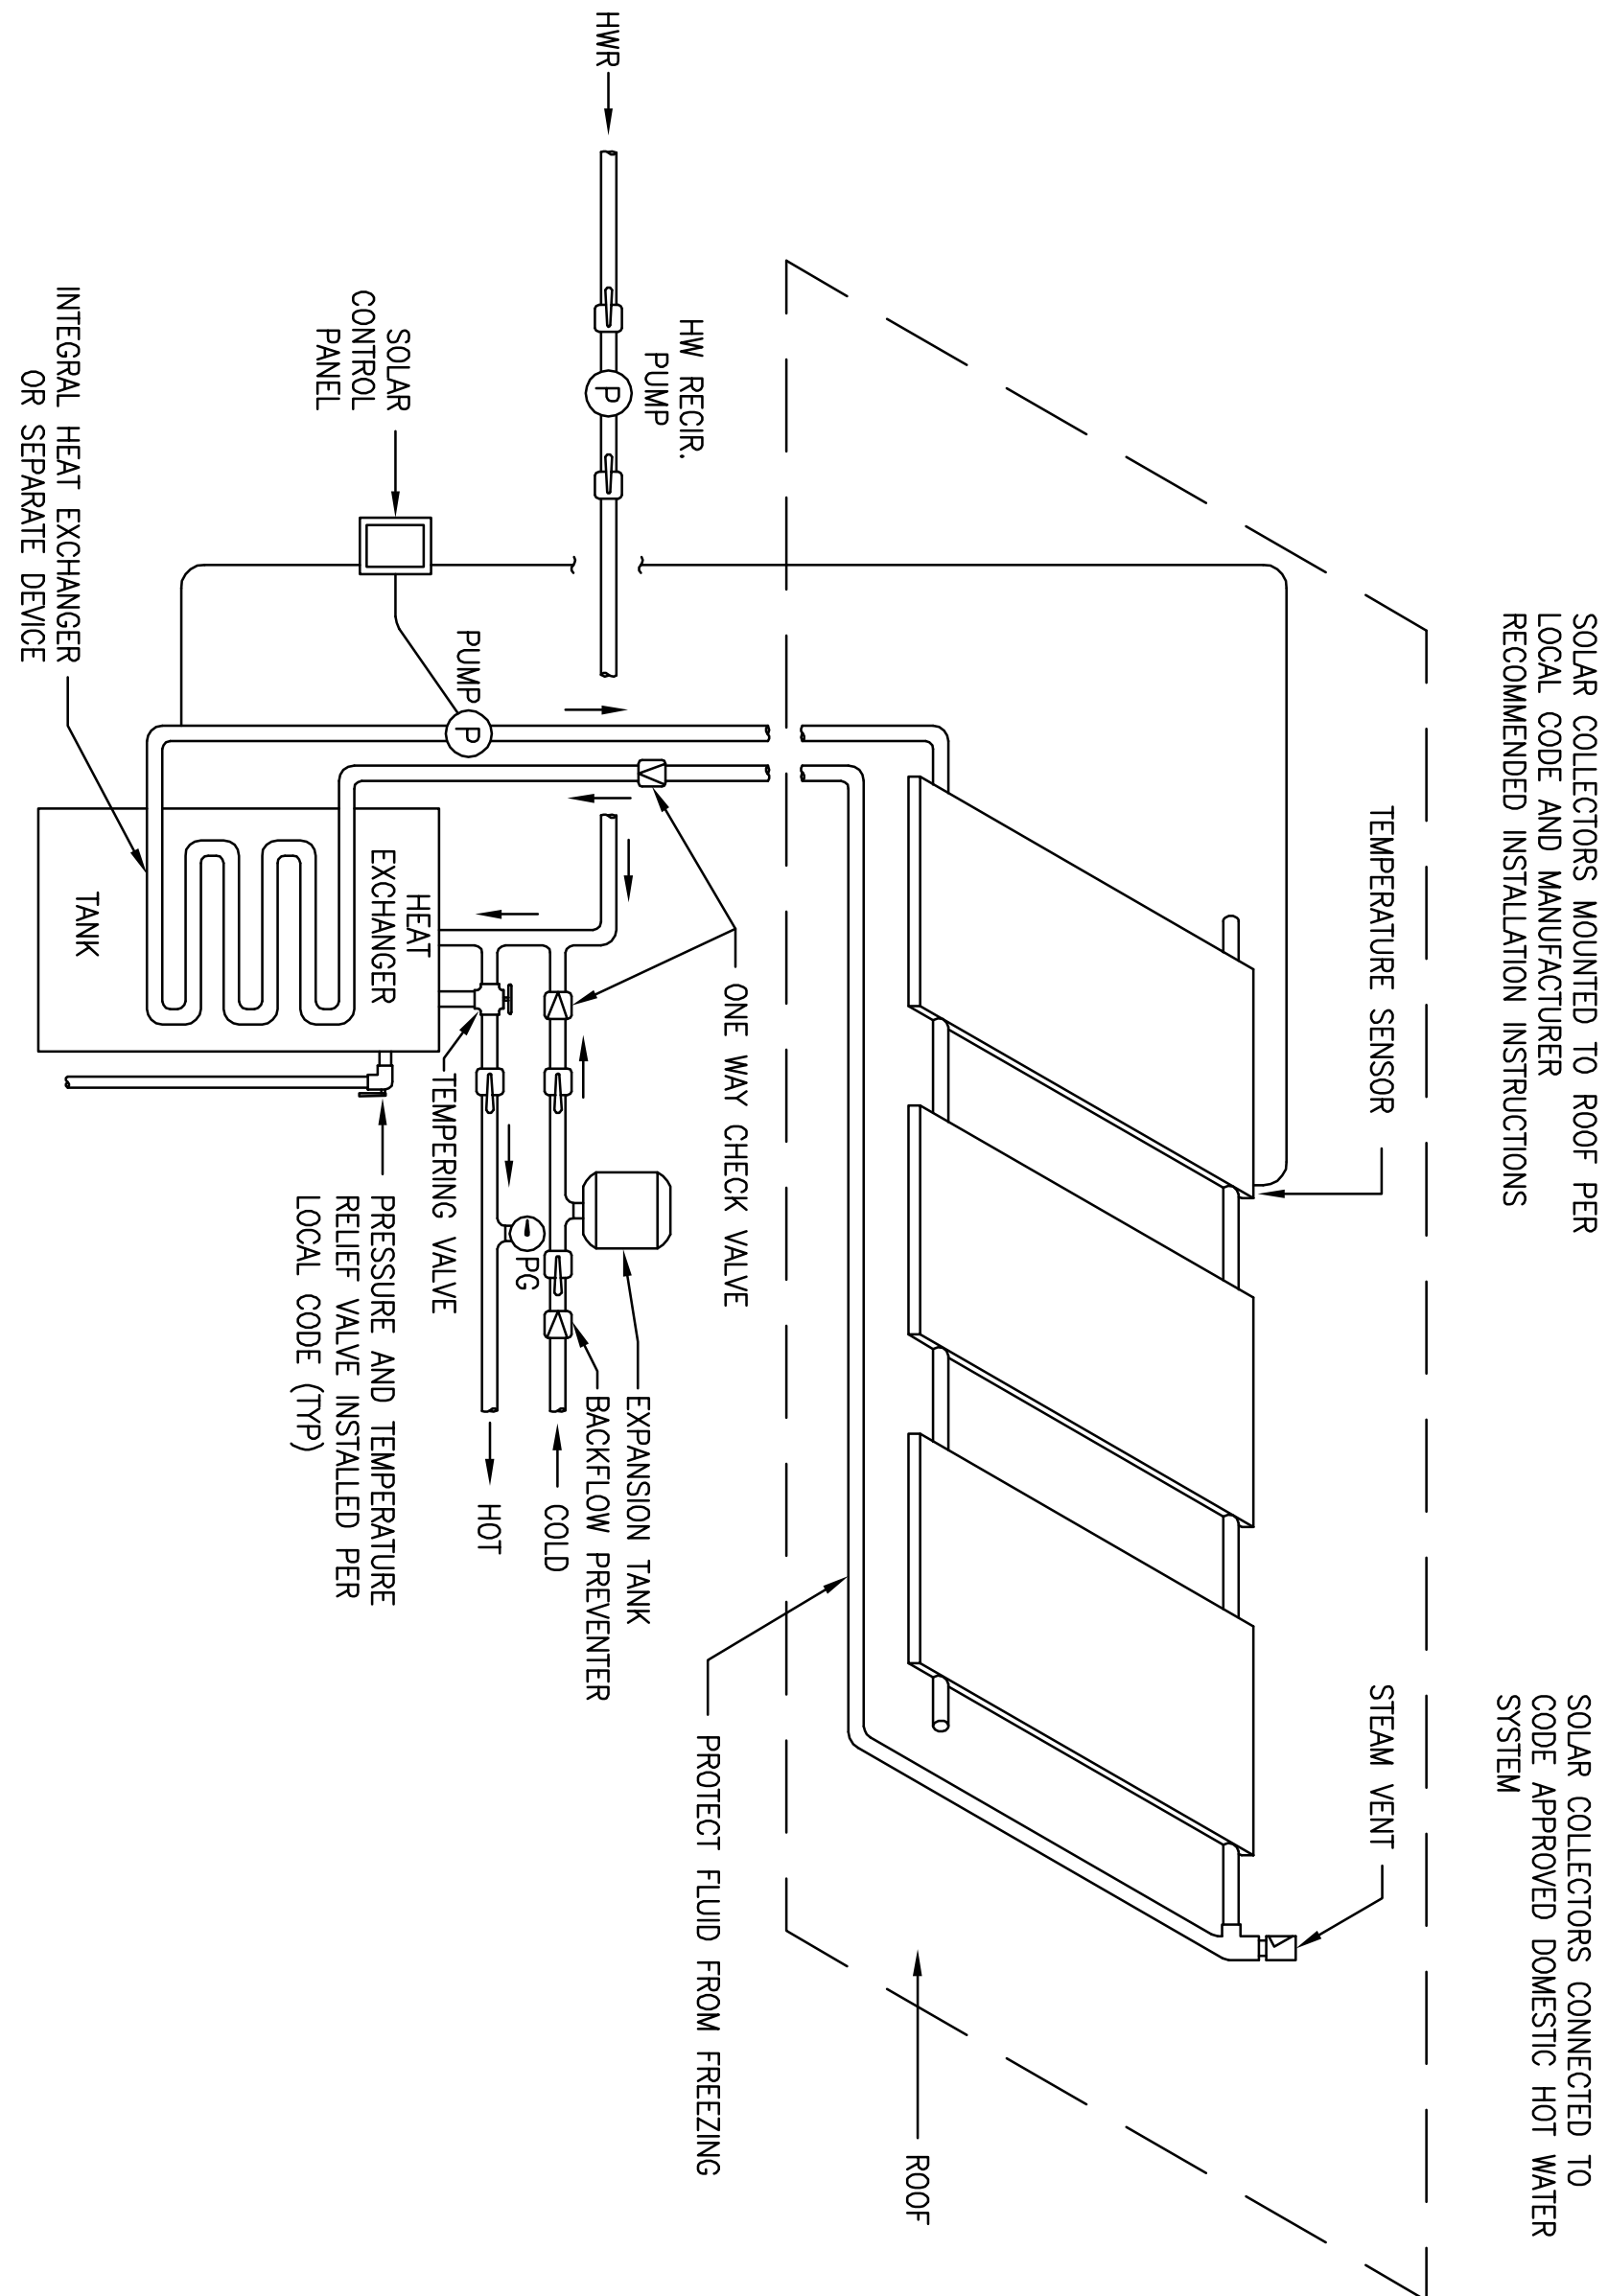


4 SOLAR CLOSED LOOP INDIRECT HEATING SYSTEM
SCALE: NONE

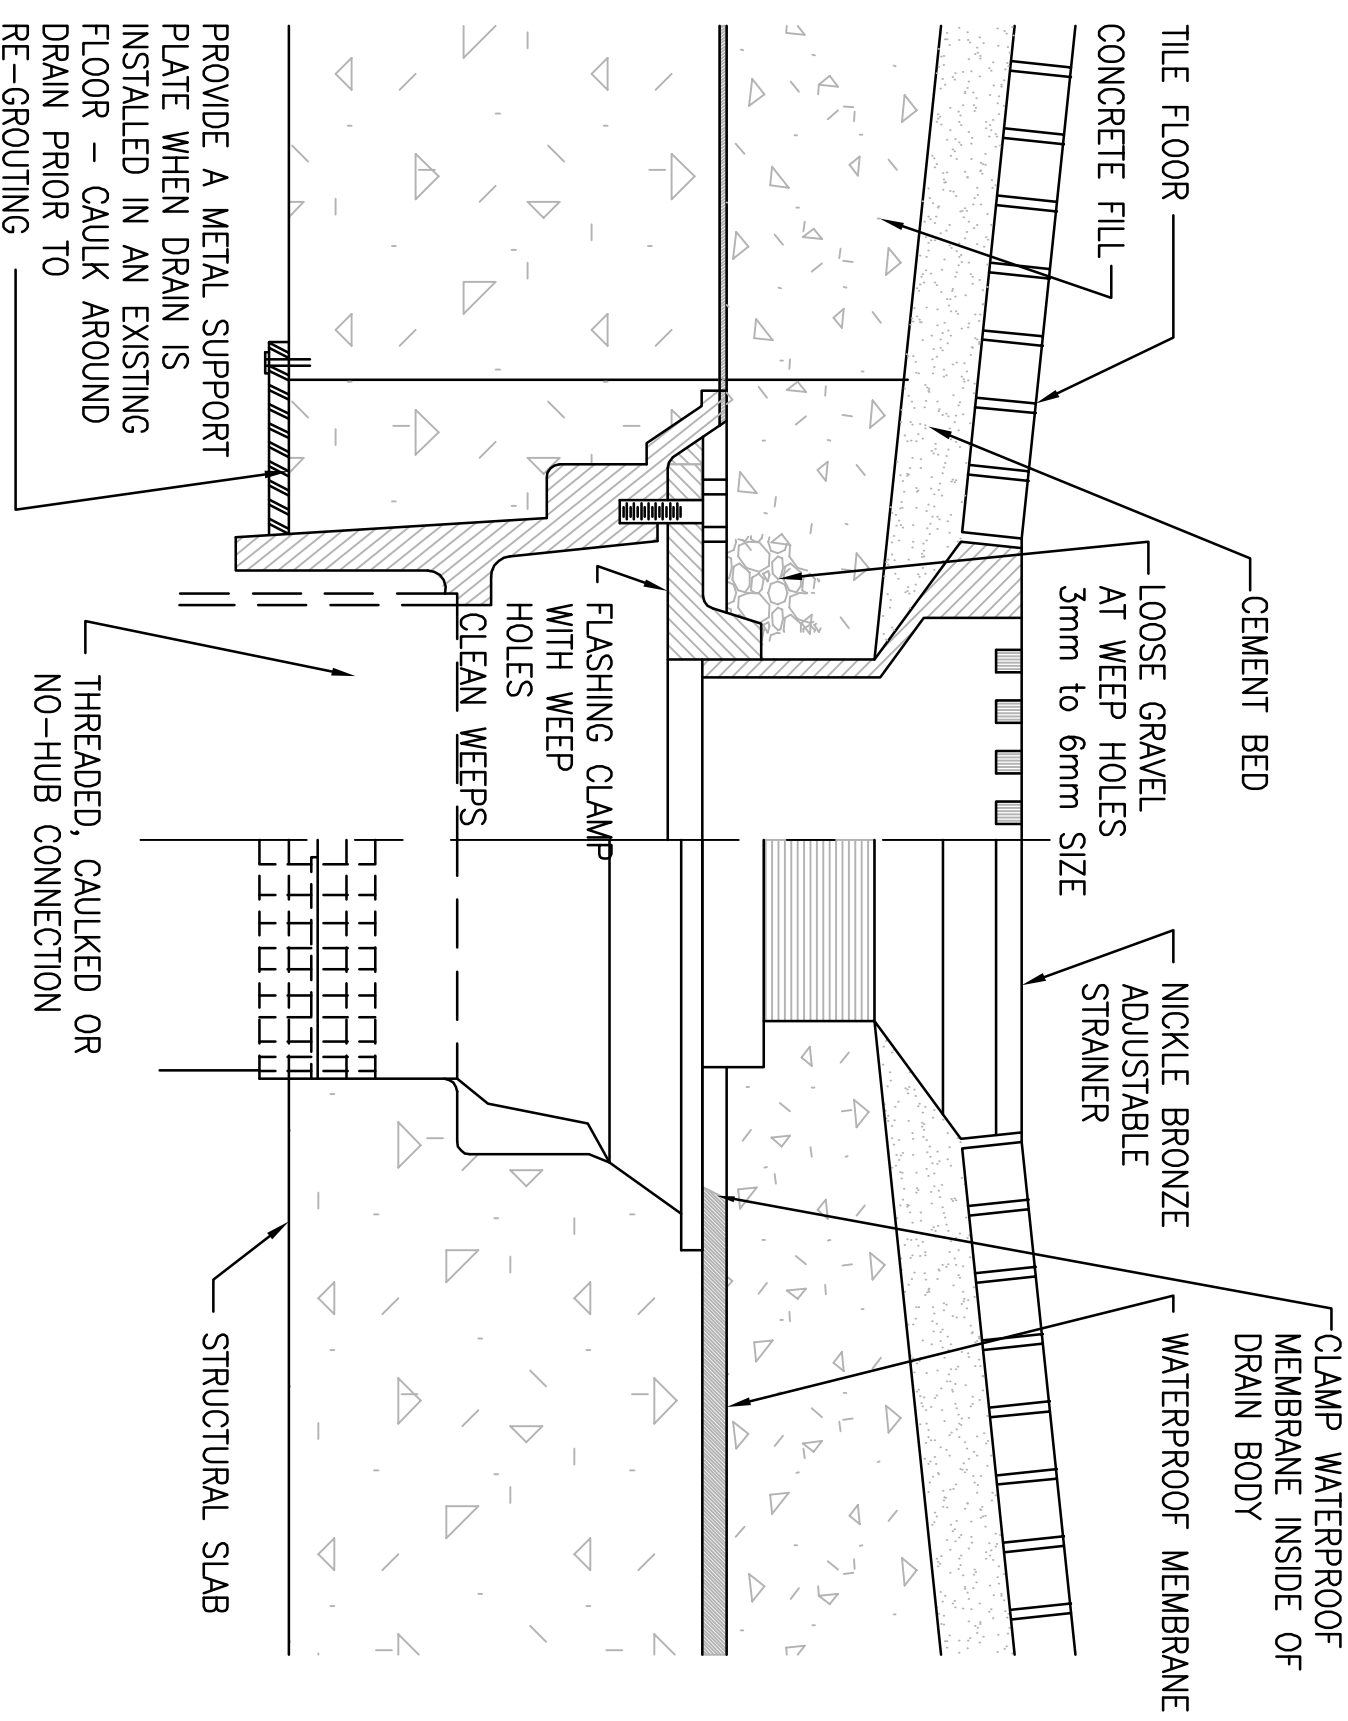


5 TYPE 'C' FLOOR DRAIN DETAIL
SCALE: NONE

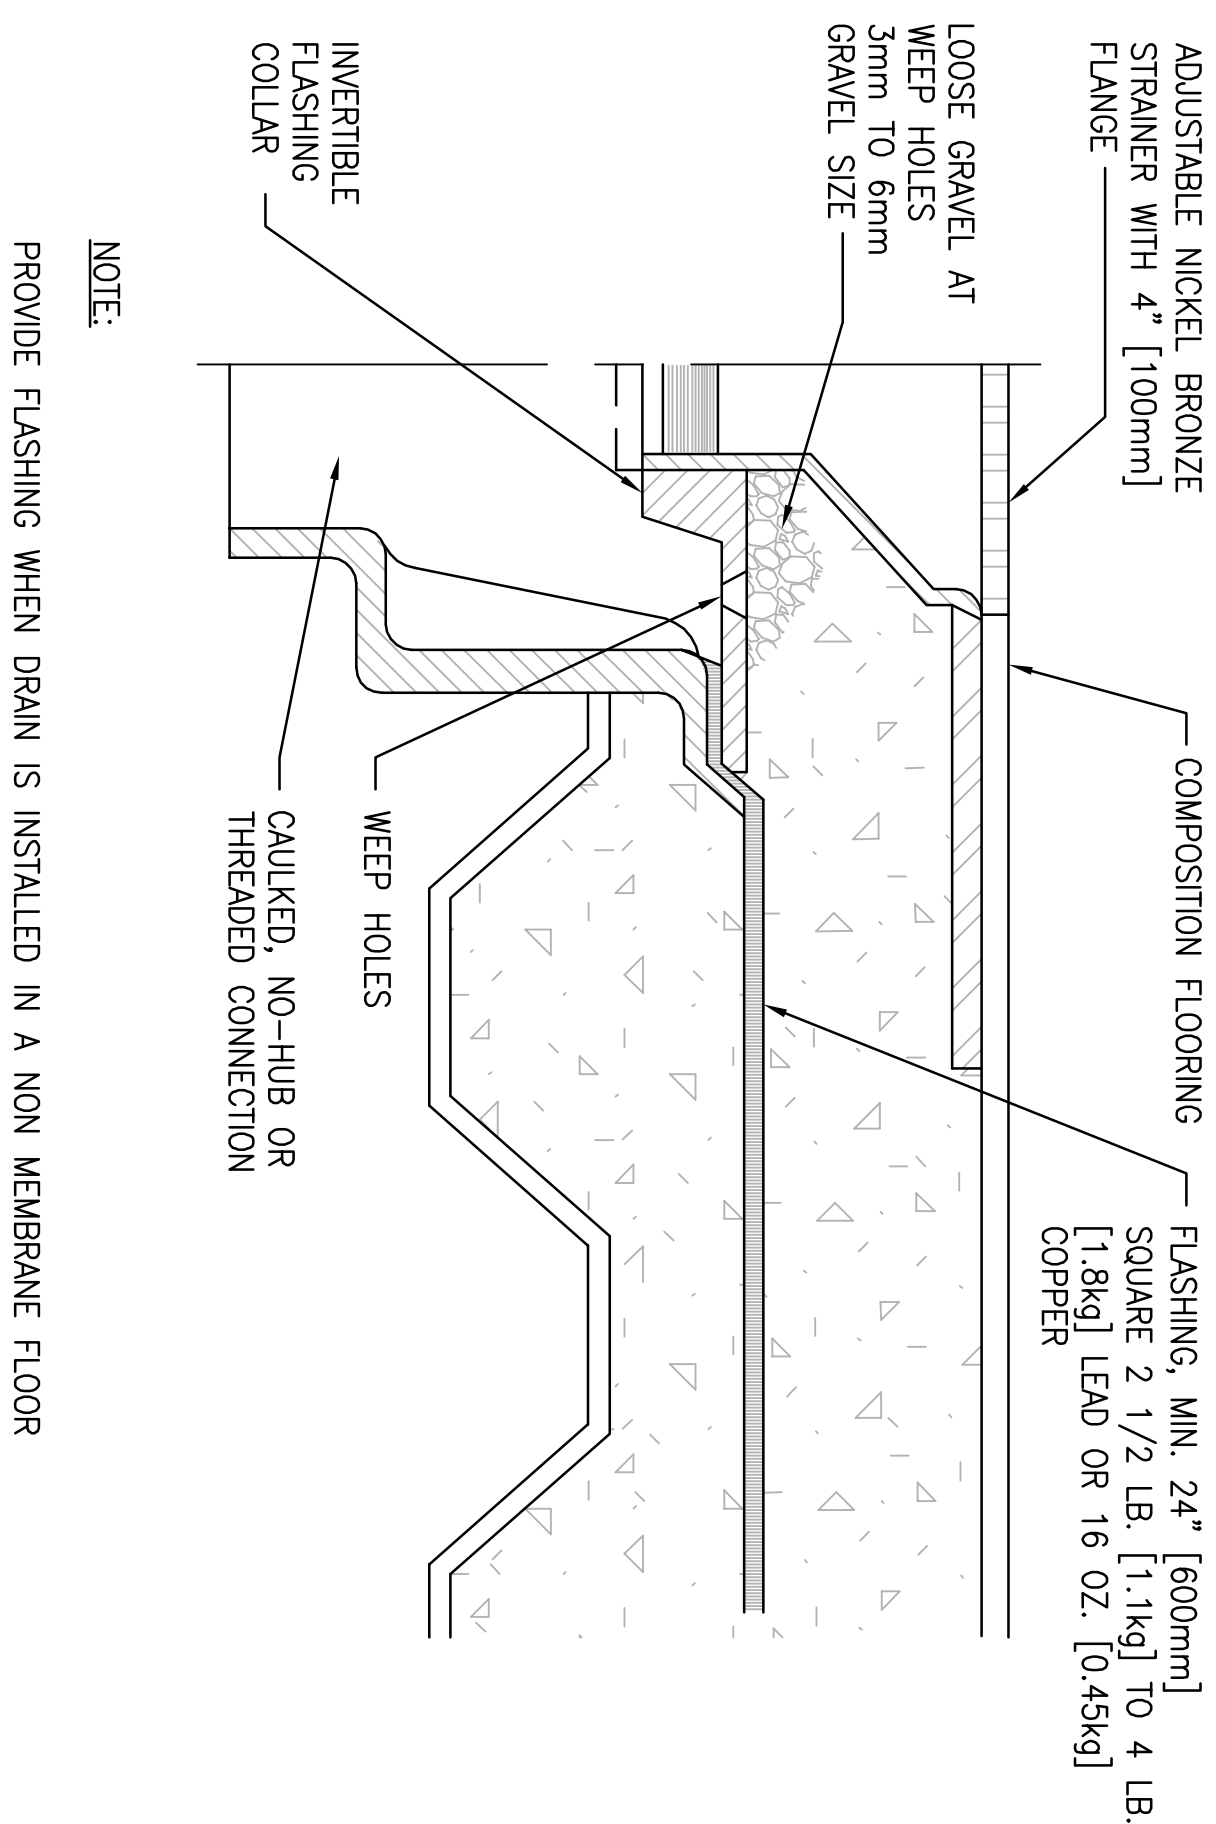

6 TYPE 'D' FLOOR DRAIN DETAIL
SCALE: NONE

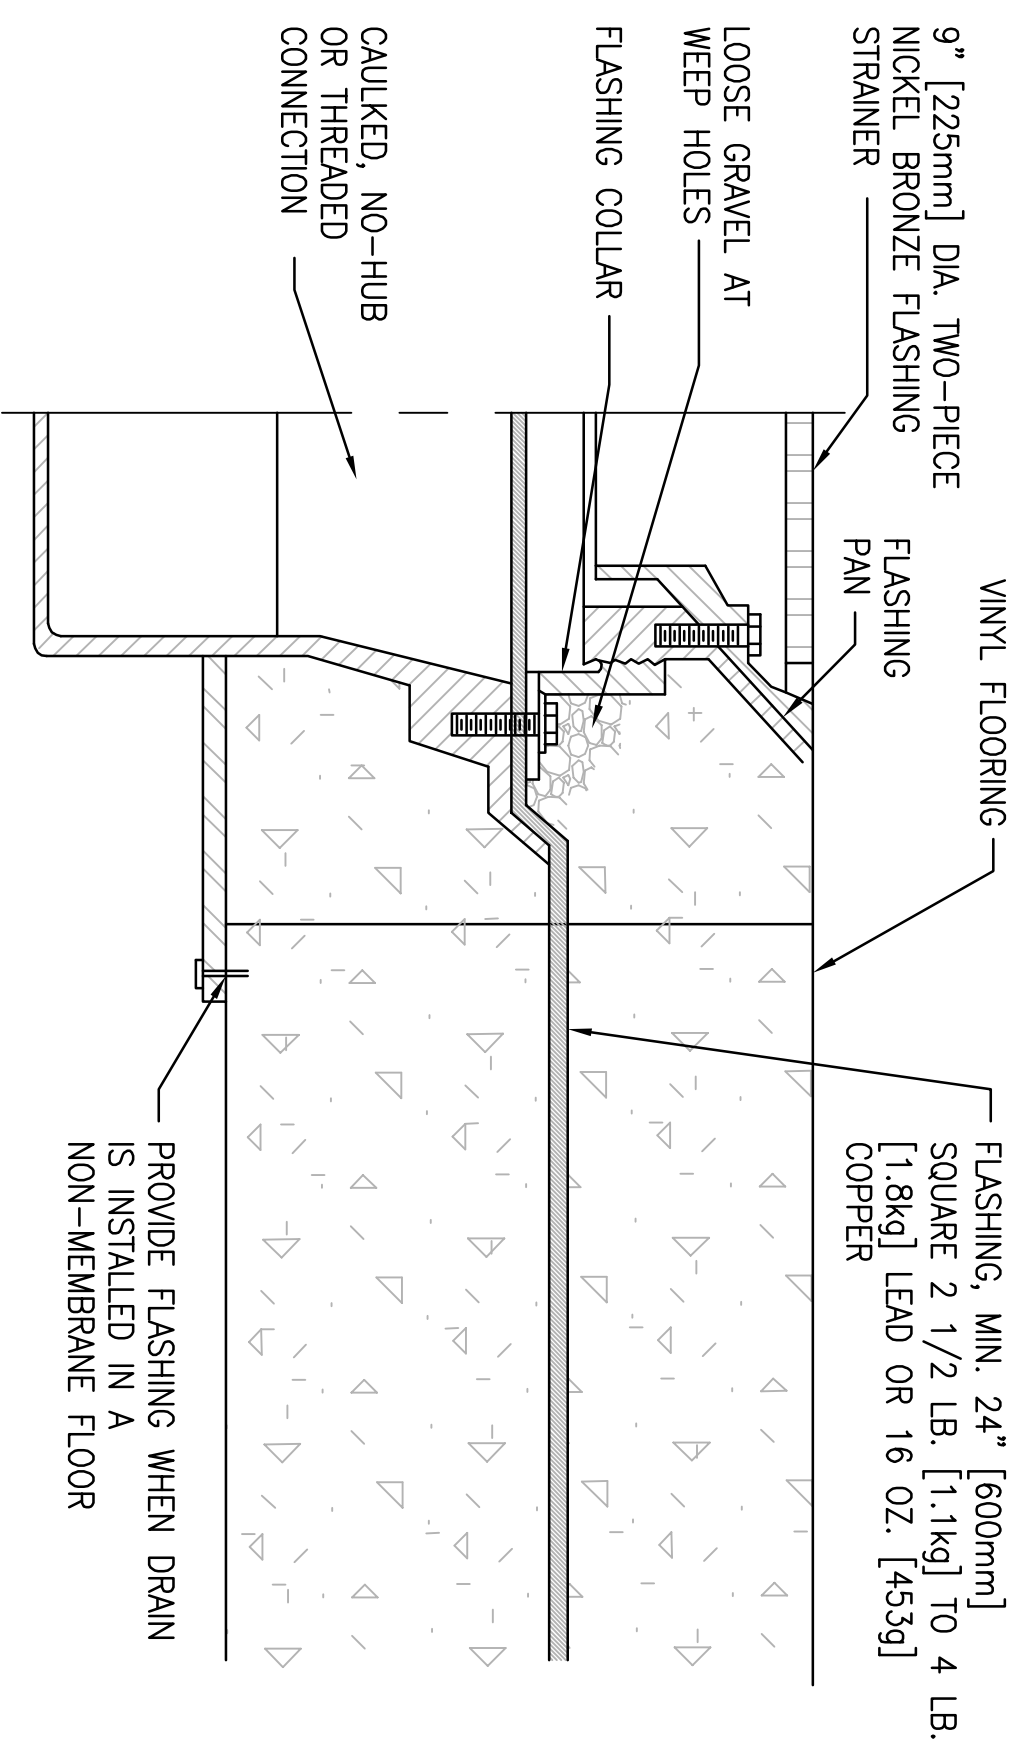



7 TYPE 'F' FLOOR DRAIN DETAIL
SCALE: NONE

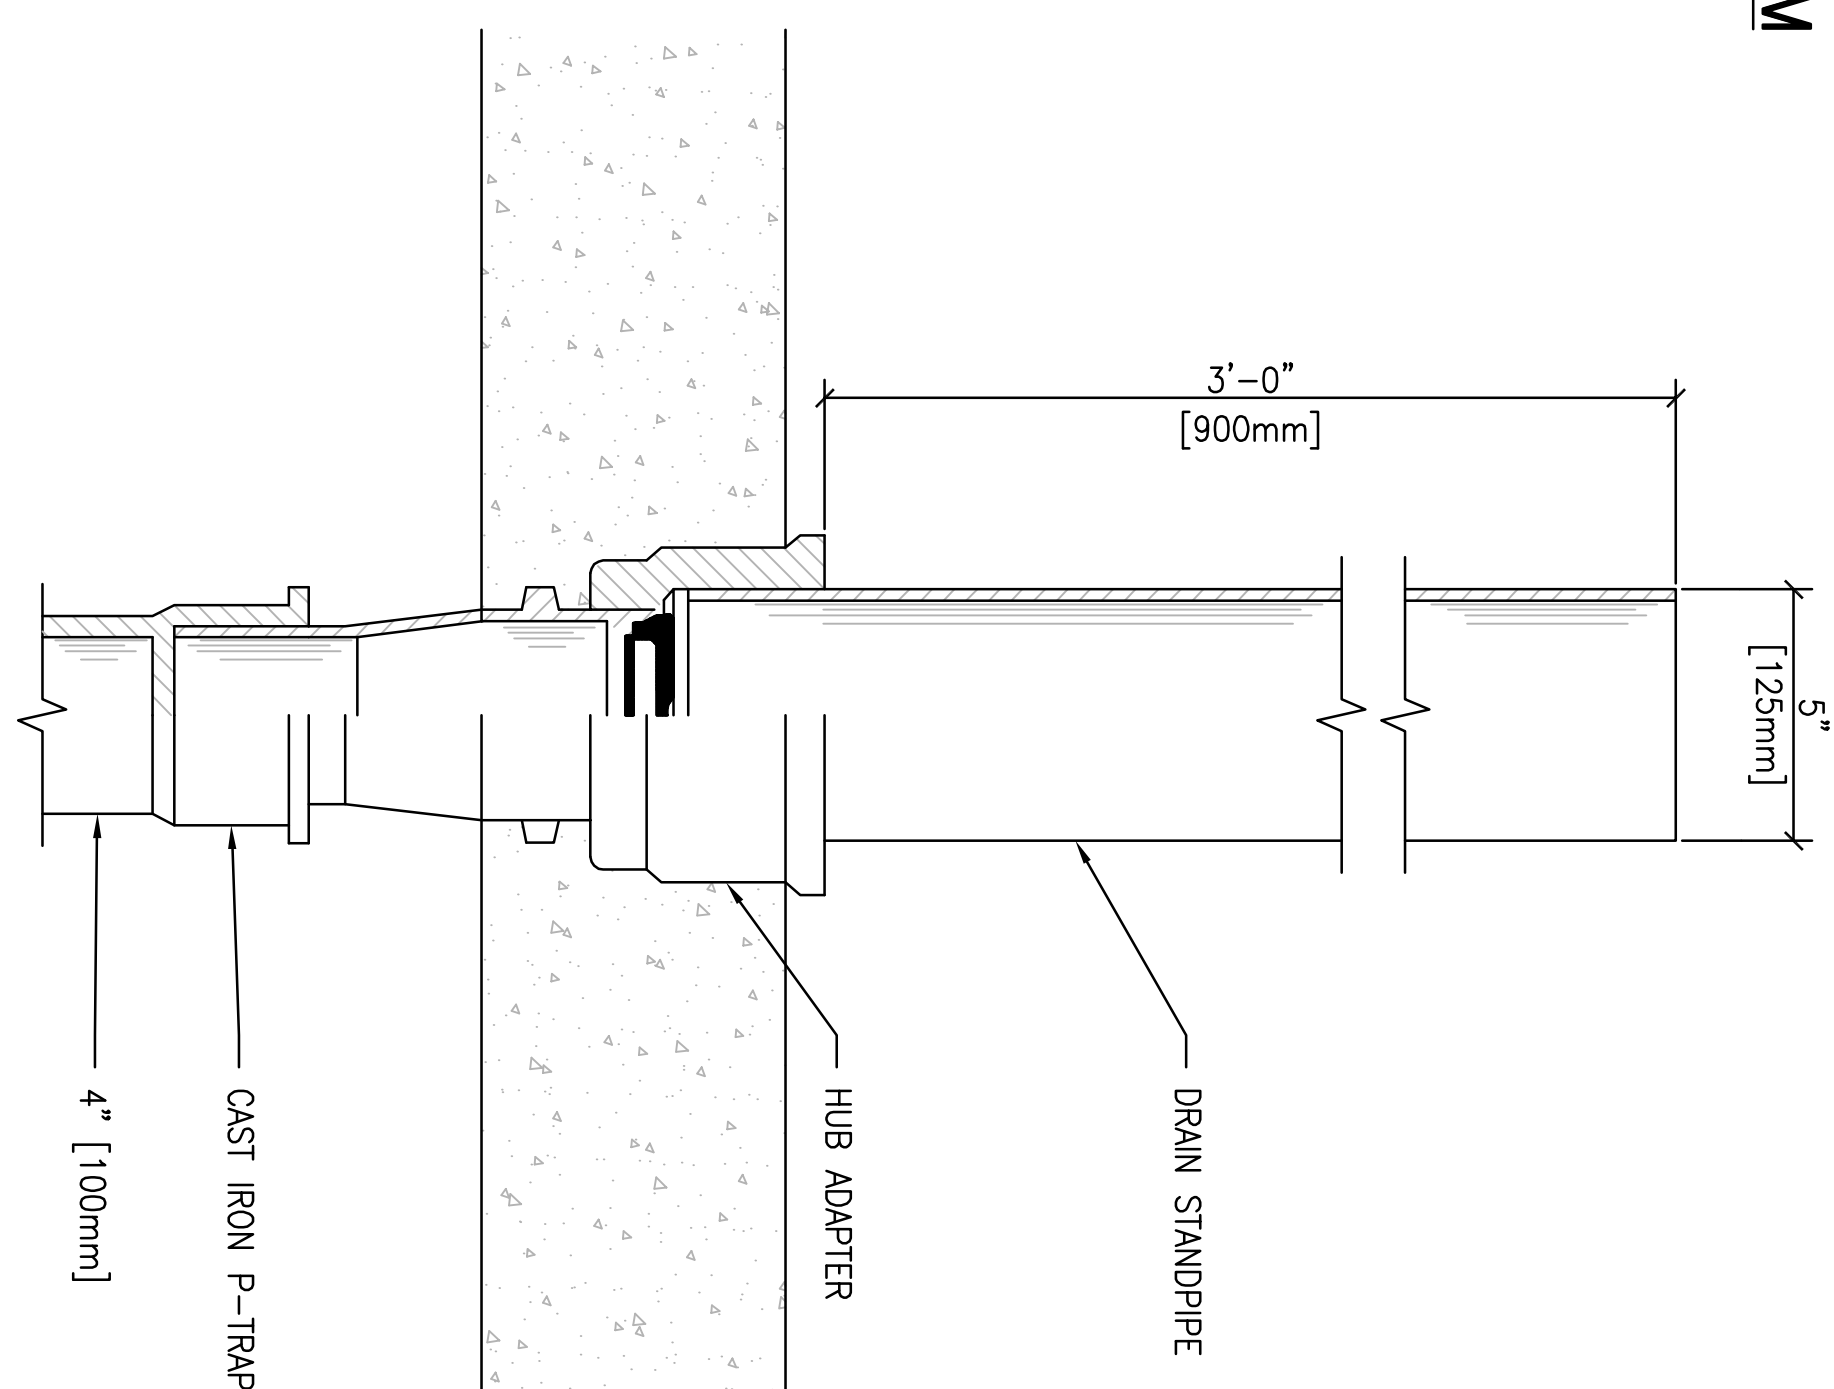



8 HUB DRAIN AND STANDPIPE
SCALE: NONE

FINAL SUBMISSION
APRIL 6, 2012

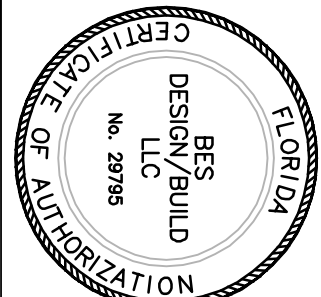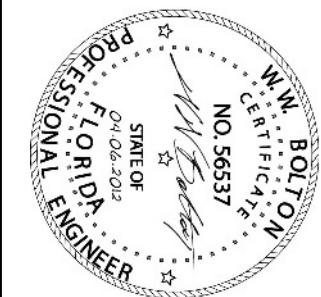P500



		P.W. DWG. NO.		DEPARTMENT OF THE NAVY NAVAL FACILITIES ENGINEERING COMMAND PANAMA CITY, FLORIDA	
NATURAL RESOURCES & ENVIRONMENTAL AFFAIRS		SAFETY DEPARTMENT		PANAMA CITY JOINT OUTPATIENT CLINIC	
TO DATE		DRAWN BY JILL		NAVAL GULF COAST HEALTH CARE	
376 MOORE ST. FORT LAUDERDALE, FL 33301 251-980-5778		CHECKED BY WMB		PLUMBING DETAILS	
ARCH. & ENGR. SEAL		SUPERVISOR WMB			
		APPROVED		N/A	
TO DATE		DATE			
FIRE DEPARTMENT					
PUBLIC WORKS SUPERVISOR					
TO DATE					
CONTRACT NO.		SIZE		SCALE	
PUBLIC WORKS OFFICER		F		N/A	
		CONSTR. CONTR. NO.		SHEET 6 OF 8	
		T.O.#			
		MACC.			
		SCALE NONE			