

A

B

C

D

E

F

F

A

B


C

D

E

F

three inches = one foot
one and one half inches = one foot
one inch = one foot
three quarters inch = one foot
one half inch = one foot
three eighths inch = one foot
one quarter inch = one foot
one eighth inch = one foot

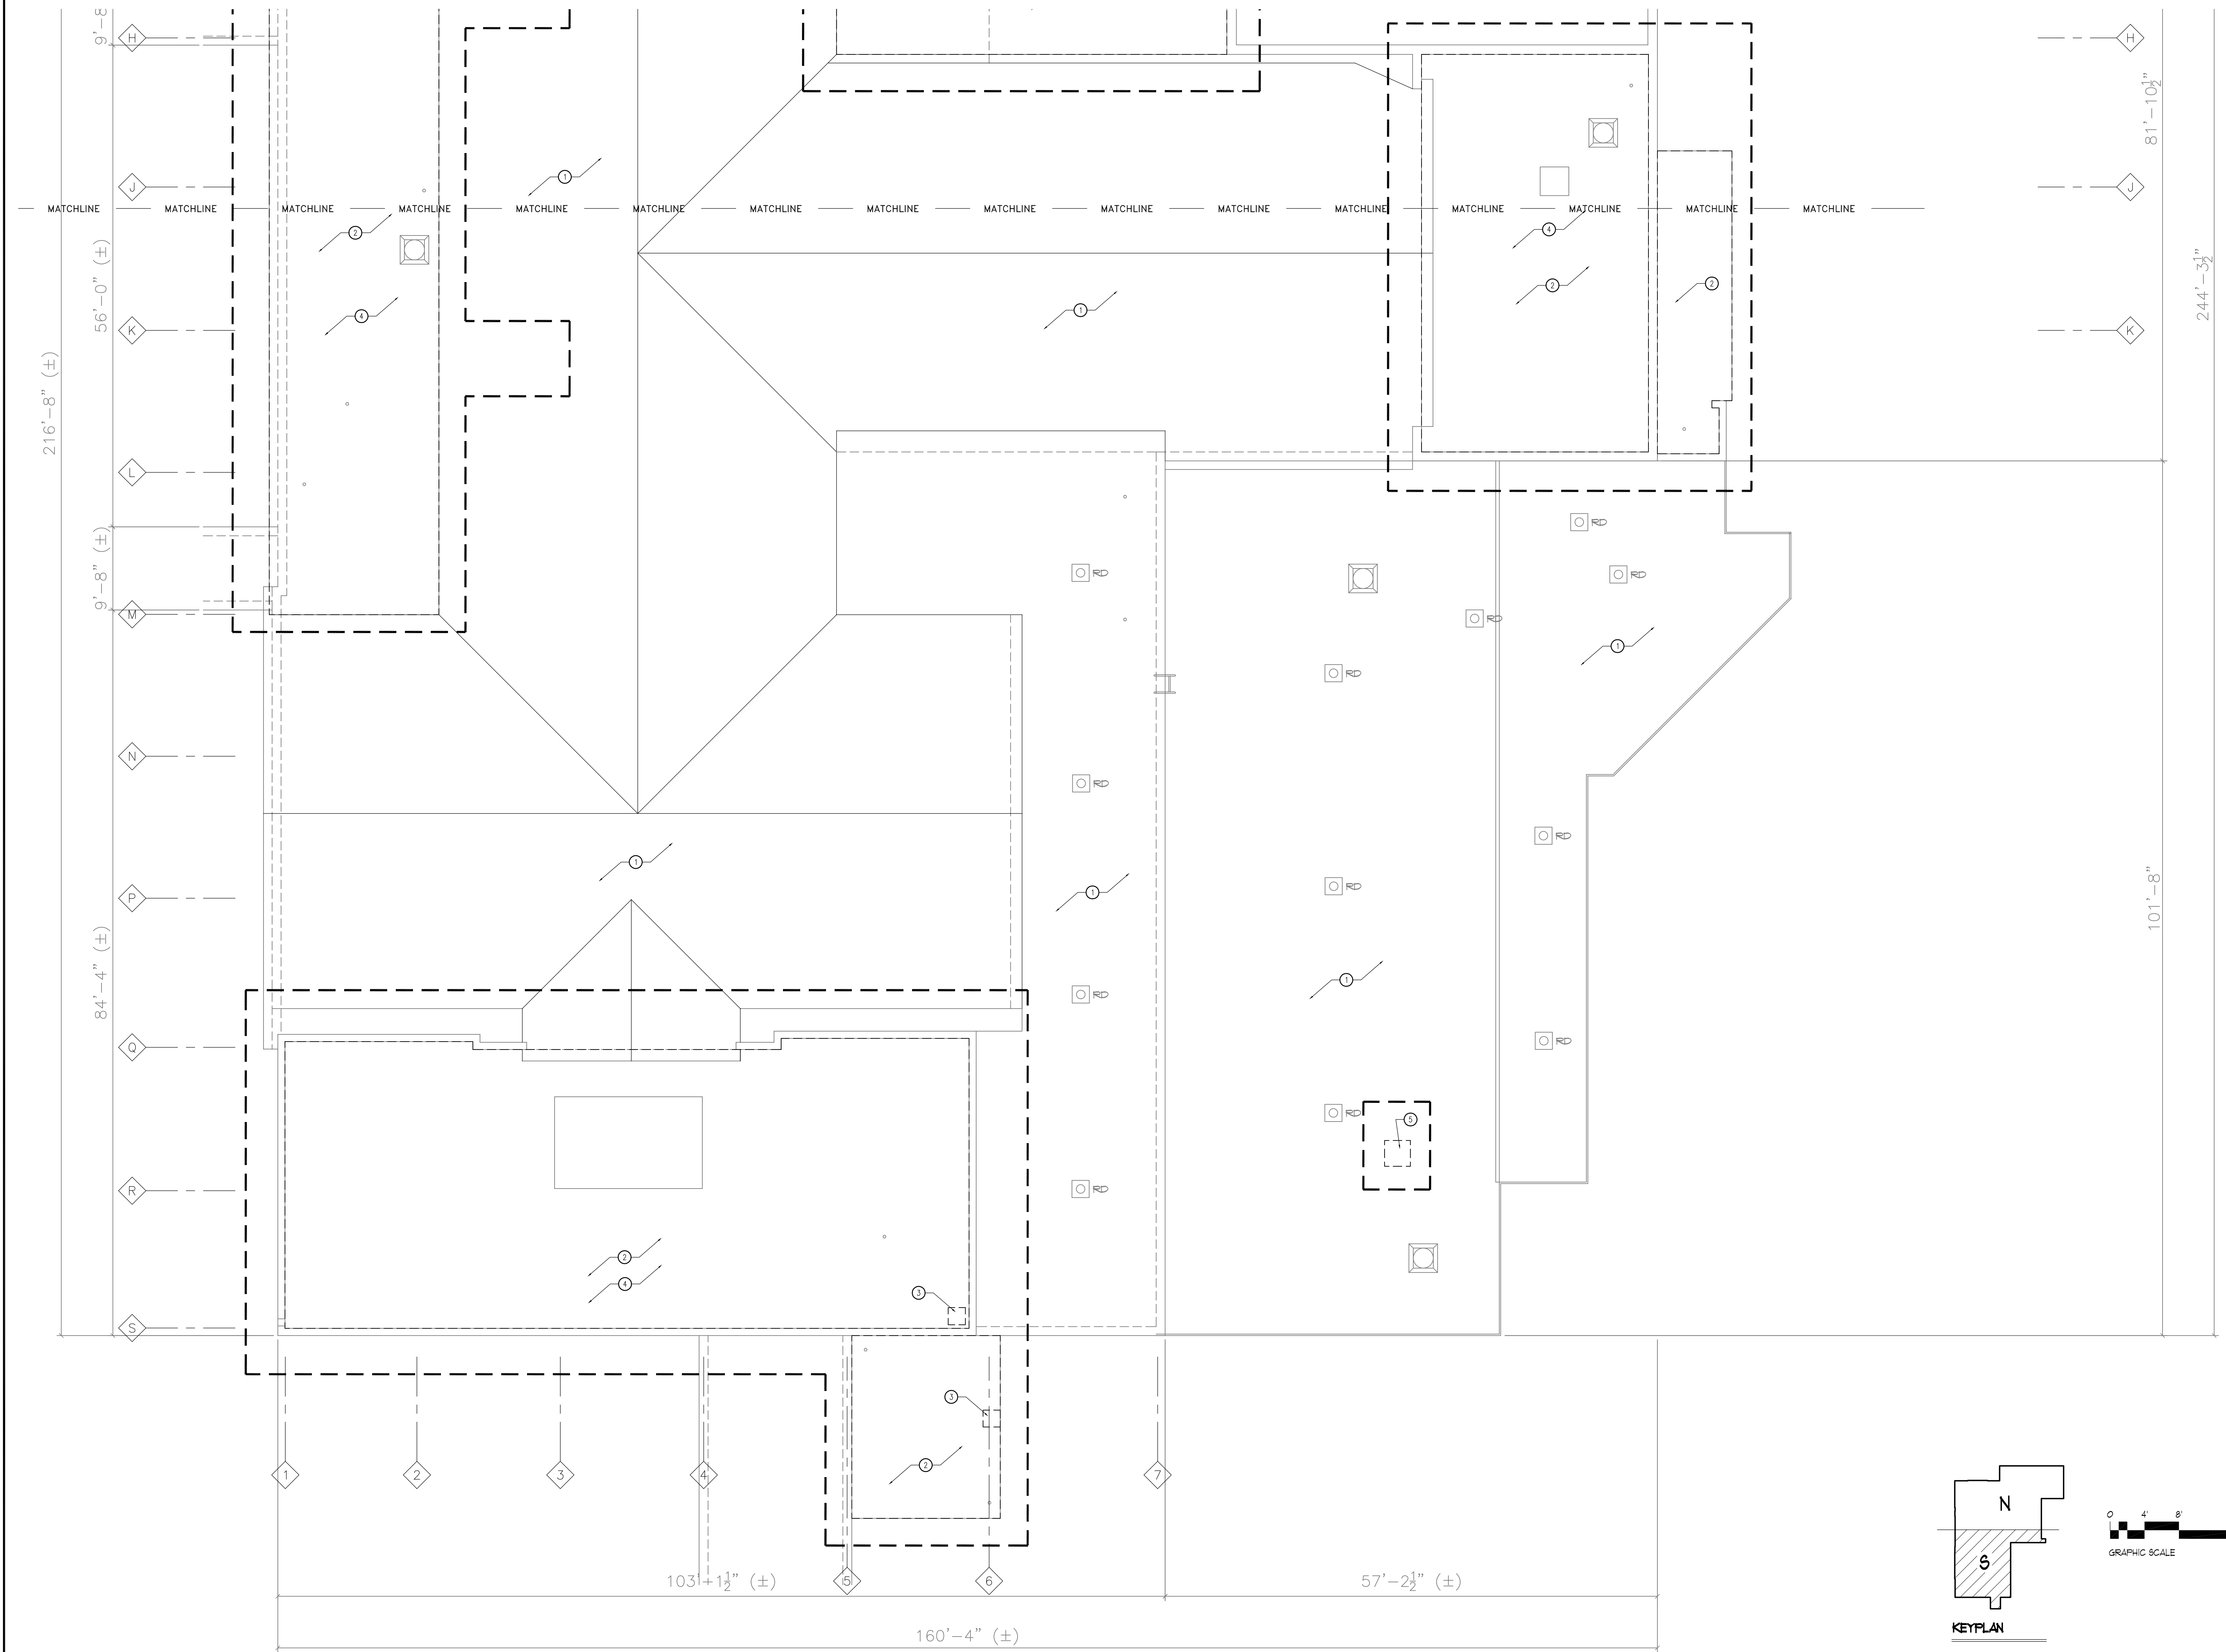

ROOF DEMOLITION PLAN - SYMBOLS LEGEND




- 1 ROOF PLAN DEMOLITION NOTE
- 2 EXISTING ROOF DRAIN TO REMAIN
- 3 CONSTRUCTION LIMITS

ROOF DEMOLITION PLAN - GENERAL NOTES

- A. PERFORM ROOF DEMOLITION PER SPEC SECTION 01 14 19 AND 01 01 50.19
- B. "DEMOLISH EXISTING ROOF SYSTEM" INCLUDING ROOFING INSULATION, CURBS, FLASHINGS, COPINGS AND ALL MATERIAL REQUIRED TO PROVIDE CLEAN SUBSTRATE FOR NEW ROOFING SPECIFIED.

ROOF DEMOLITION PLAN NOTES

- 1 PORTION OF ROOF NOT IN CONTRACT.
- 2 DEMOLISH EXISTING ROOF SYSTEM TO TOP OF DECK FOR ALL ROOF AREAS IN SCOPE OF WORK.
- 3 REMOVE EXISTING ROOF DRAIN.
- 4 REMOVE EXISTING LIGHTNING PROTECTION SYSTEM AND SALVAGE FOR REUSE.
- 5 EXISTING MECHANICAL EQUIPMENT TO BE REMOVED.

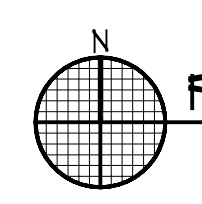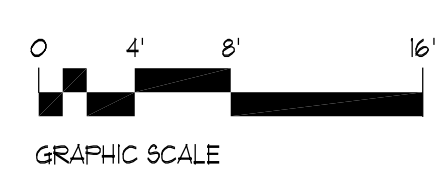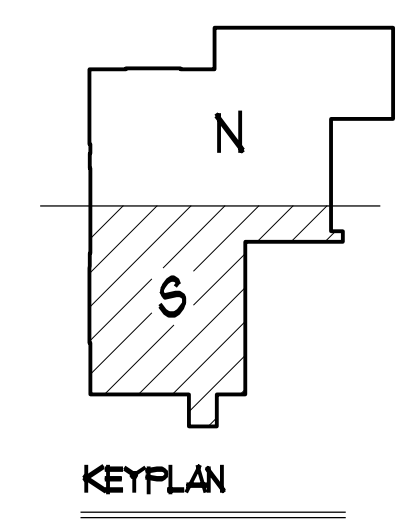

PARTIAL ROOF DEMOLITION PLAN

1/8"=1'-0"

FINAL BID DOCUMENTS	06-26-12
90% CONSTRUCTION DOCUMENTS SUBMISSION	05-17-12
50% CONSTRUCTION DOCUMENTS SUBMISSION	04-06-12
35% DOCUMENTS SUBMISSION	02-22-12
SCHEMATIC DESIGN SUBMISSION	11-21-11
Revisions:	Date

Federal Health Care Center
U.S. Department of Veterans Affairs | U.S. Department of Defense

Captain James A. Lovell
Federal Health Care Center
3001 Green Bay Road
North Chicago, IL, 60064



CONSULTANTS:

ARNOLD & O'SHERIDAN
Consulting Engineers

CHEQUAMEGON BAY ENGINEERING, INC.

MACKESEY AND ASSOCIATES, LLC

PROJECT LEADER:

Plunkett Raysich Architects
11000 West Park Place • Milwaukee WI 53224 • Tel 414 359-3060 • Fax 414 359-3070

Intelligent Designs

Inspired Results
www.p r a r c h . c o m
PRA Job No. 110172-01

Drawing Title
Partial Roof Demolition Plan - South
Approved: Project Director

Project Title
AE SCIP for Building 6 FHCC
Location
North Chicago, IL
Date
June 26, 2012
Checked By:
PRA
Drawn By:
RLS

Project Number
556-11-119
Building Number
6
Drawing Number
AD-203S

Office of Facilities Management

Department of Veterans Affairs

FINAL BID DOCUMENTS