


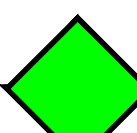
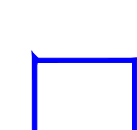

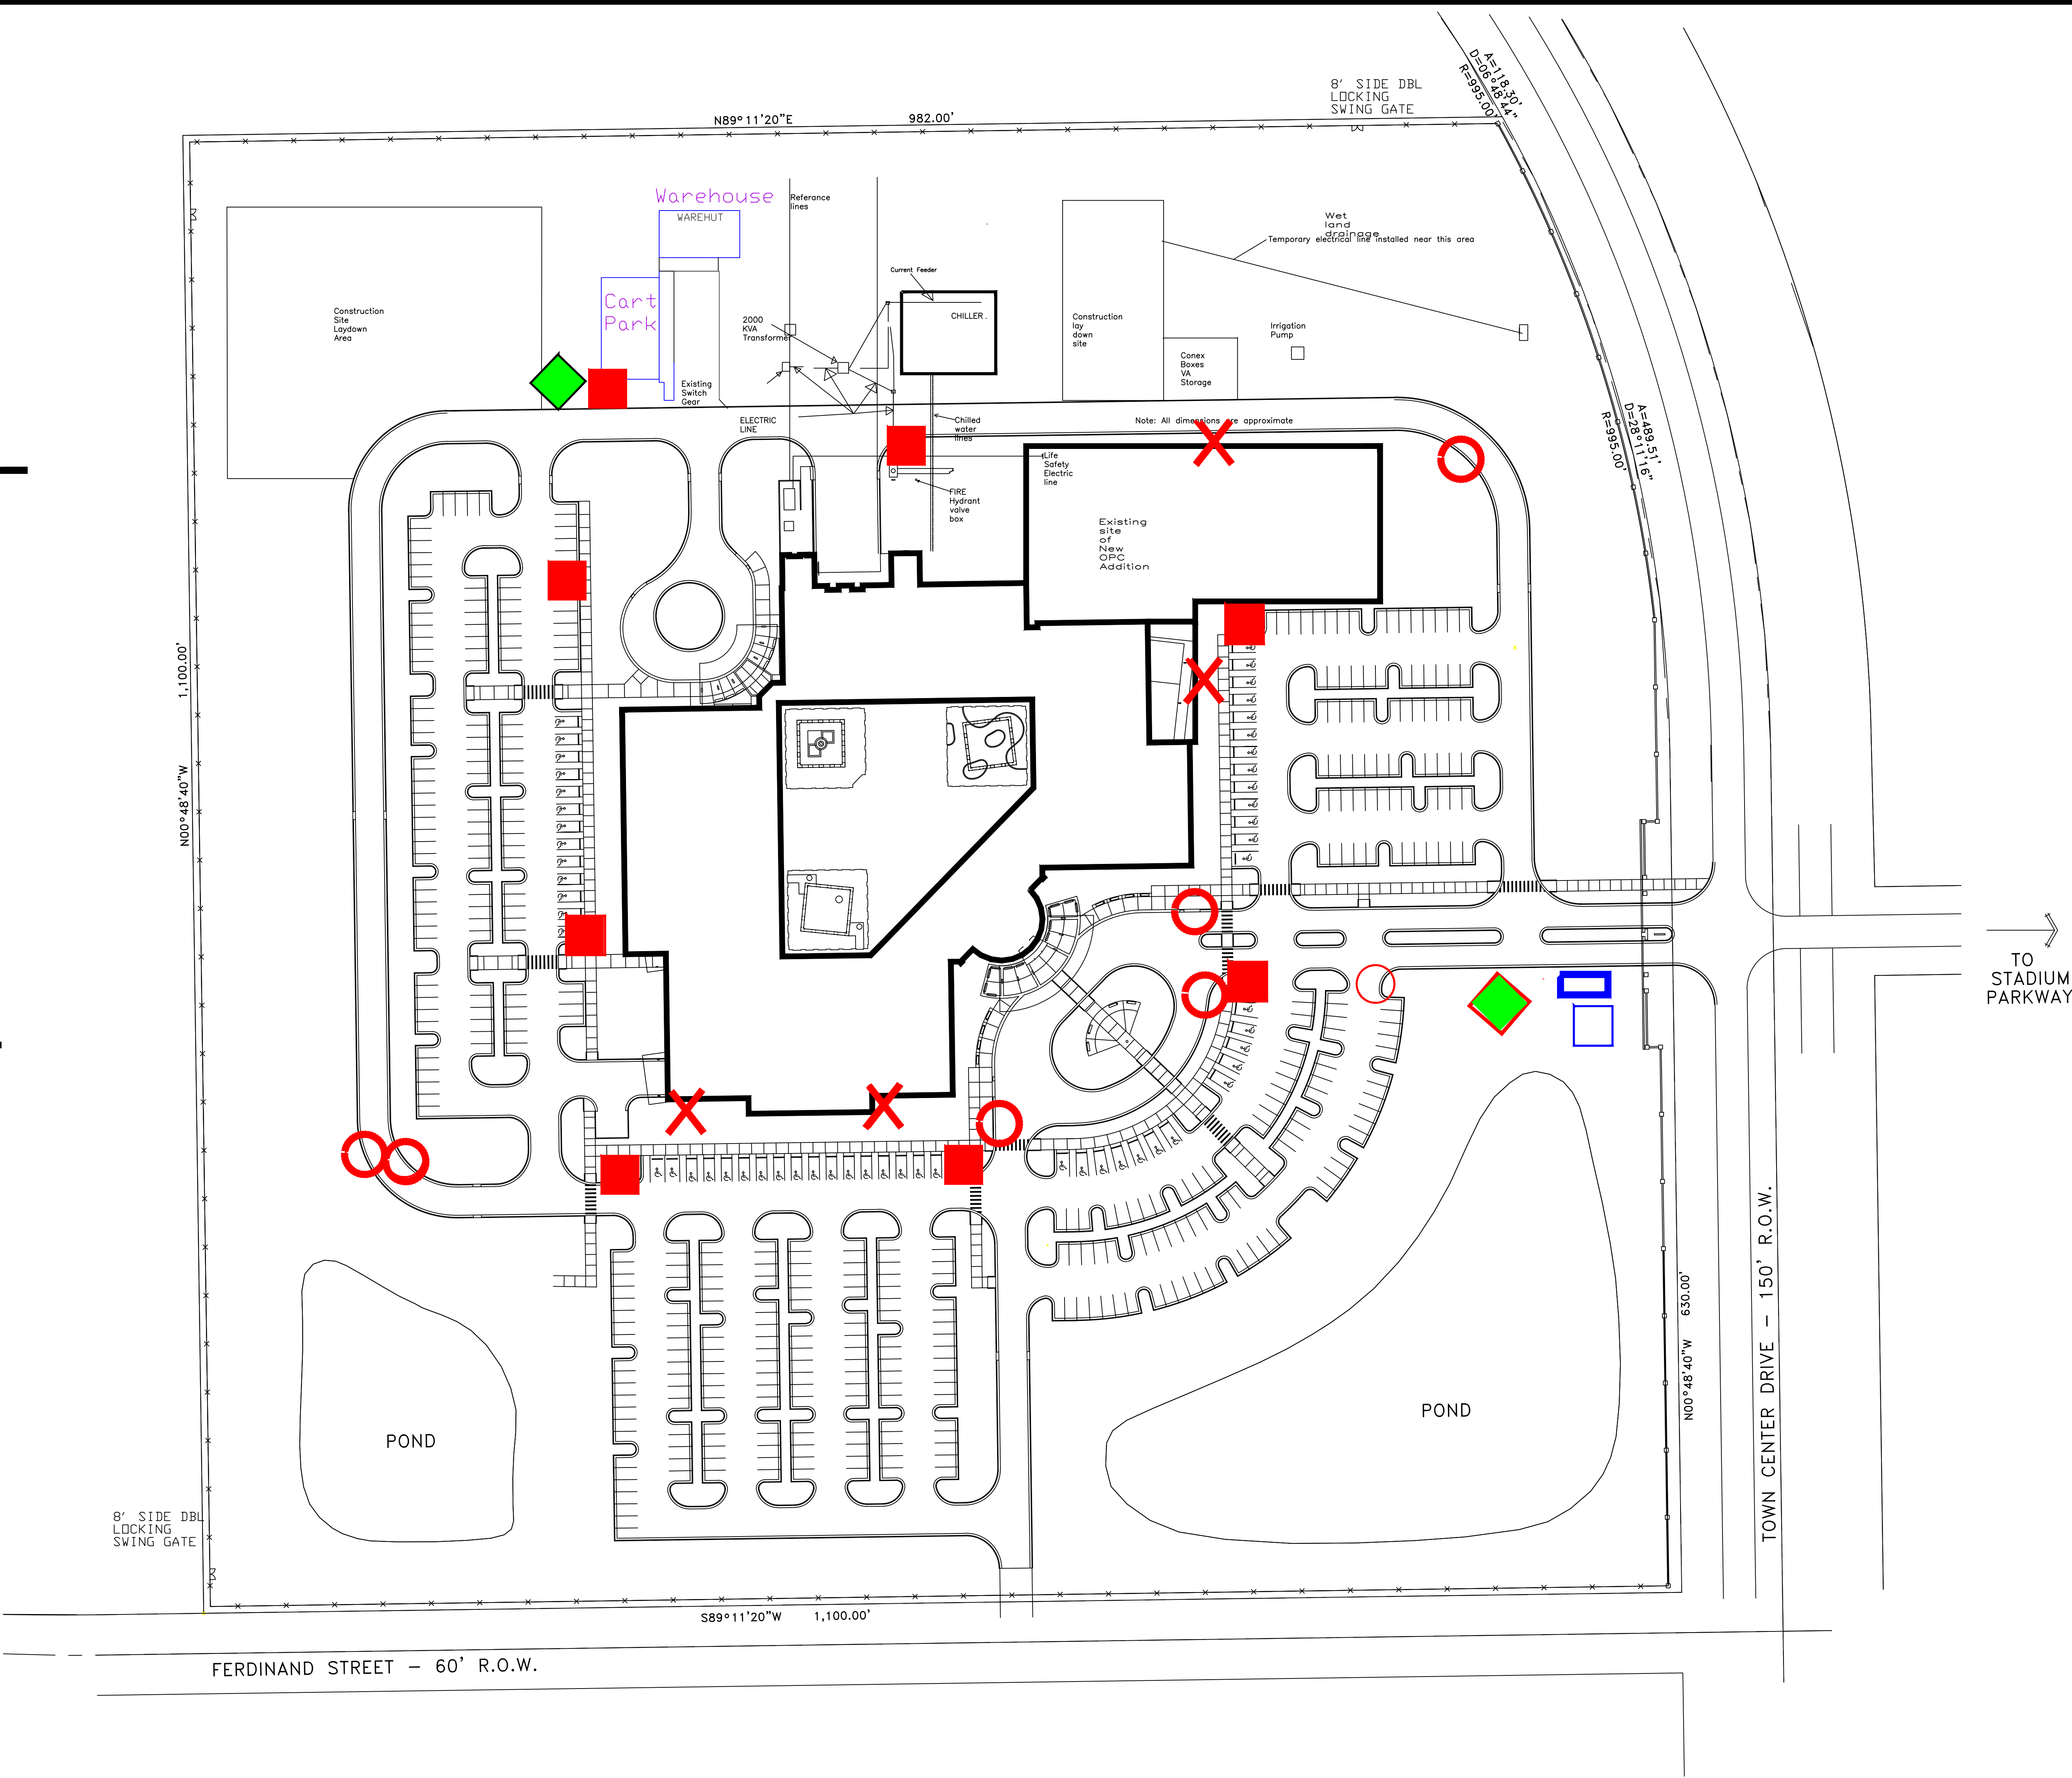



LIST FOR VARIOUS SYSTEMS

-  DAMAGED STORM DRAINS
-  FIRE HYDRANT
-  PIV (POST INDICATOR VALVE)
-  FDC (FIRE DEPARTMENT CONNECTION)
-  CITY OWNED FIRE HYDRANT - NOT IN CONTRACT
-  CITY OWNED BACKFLOW - NOT IN CONTRACT



VA MEDICAL CENTER ORLANDO, FLORIDA
Viera Outpatient Clinic
VHA NRM 675-16-652 Correct Water & Access Deficiencies - Viera

**Site Plan
DWG 1 of 2**

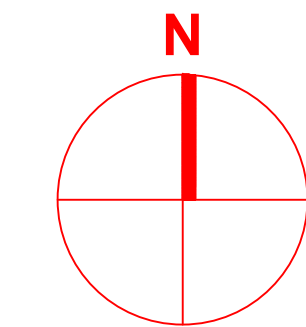


Scale: N.T.S.


Office of Construction & Facilities Management



Department of Veterans Affairs

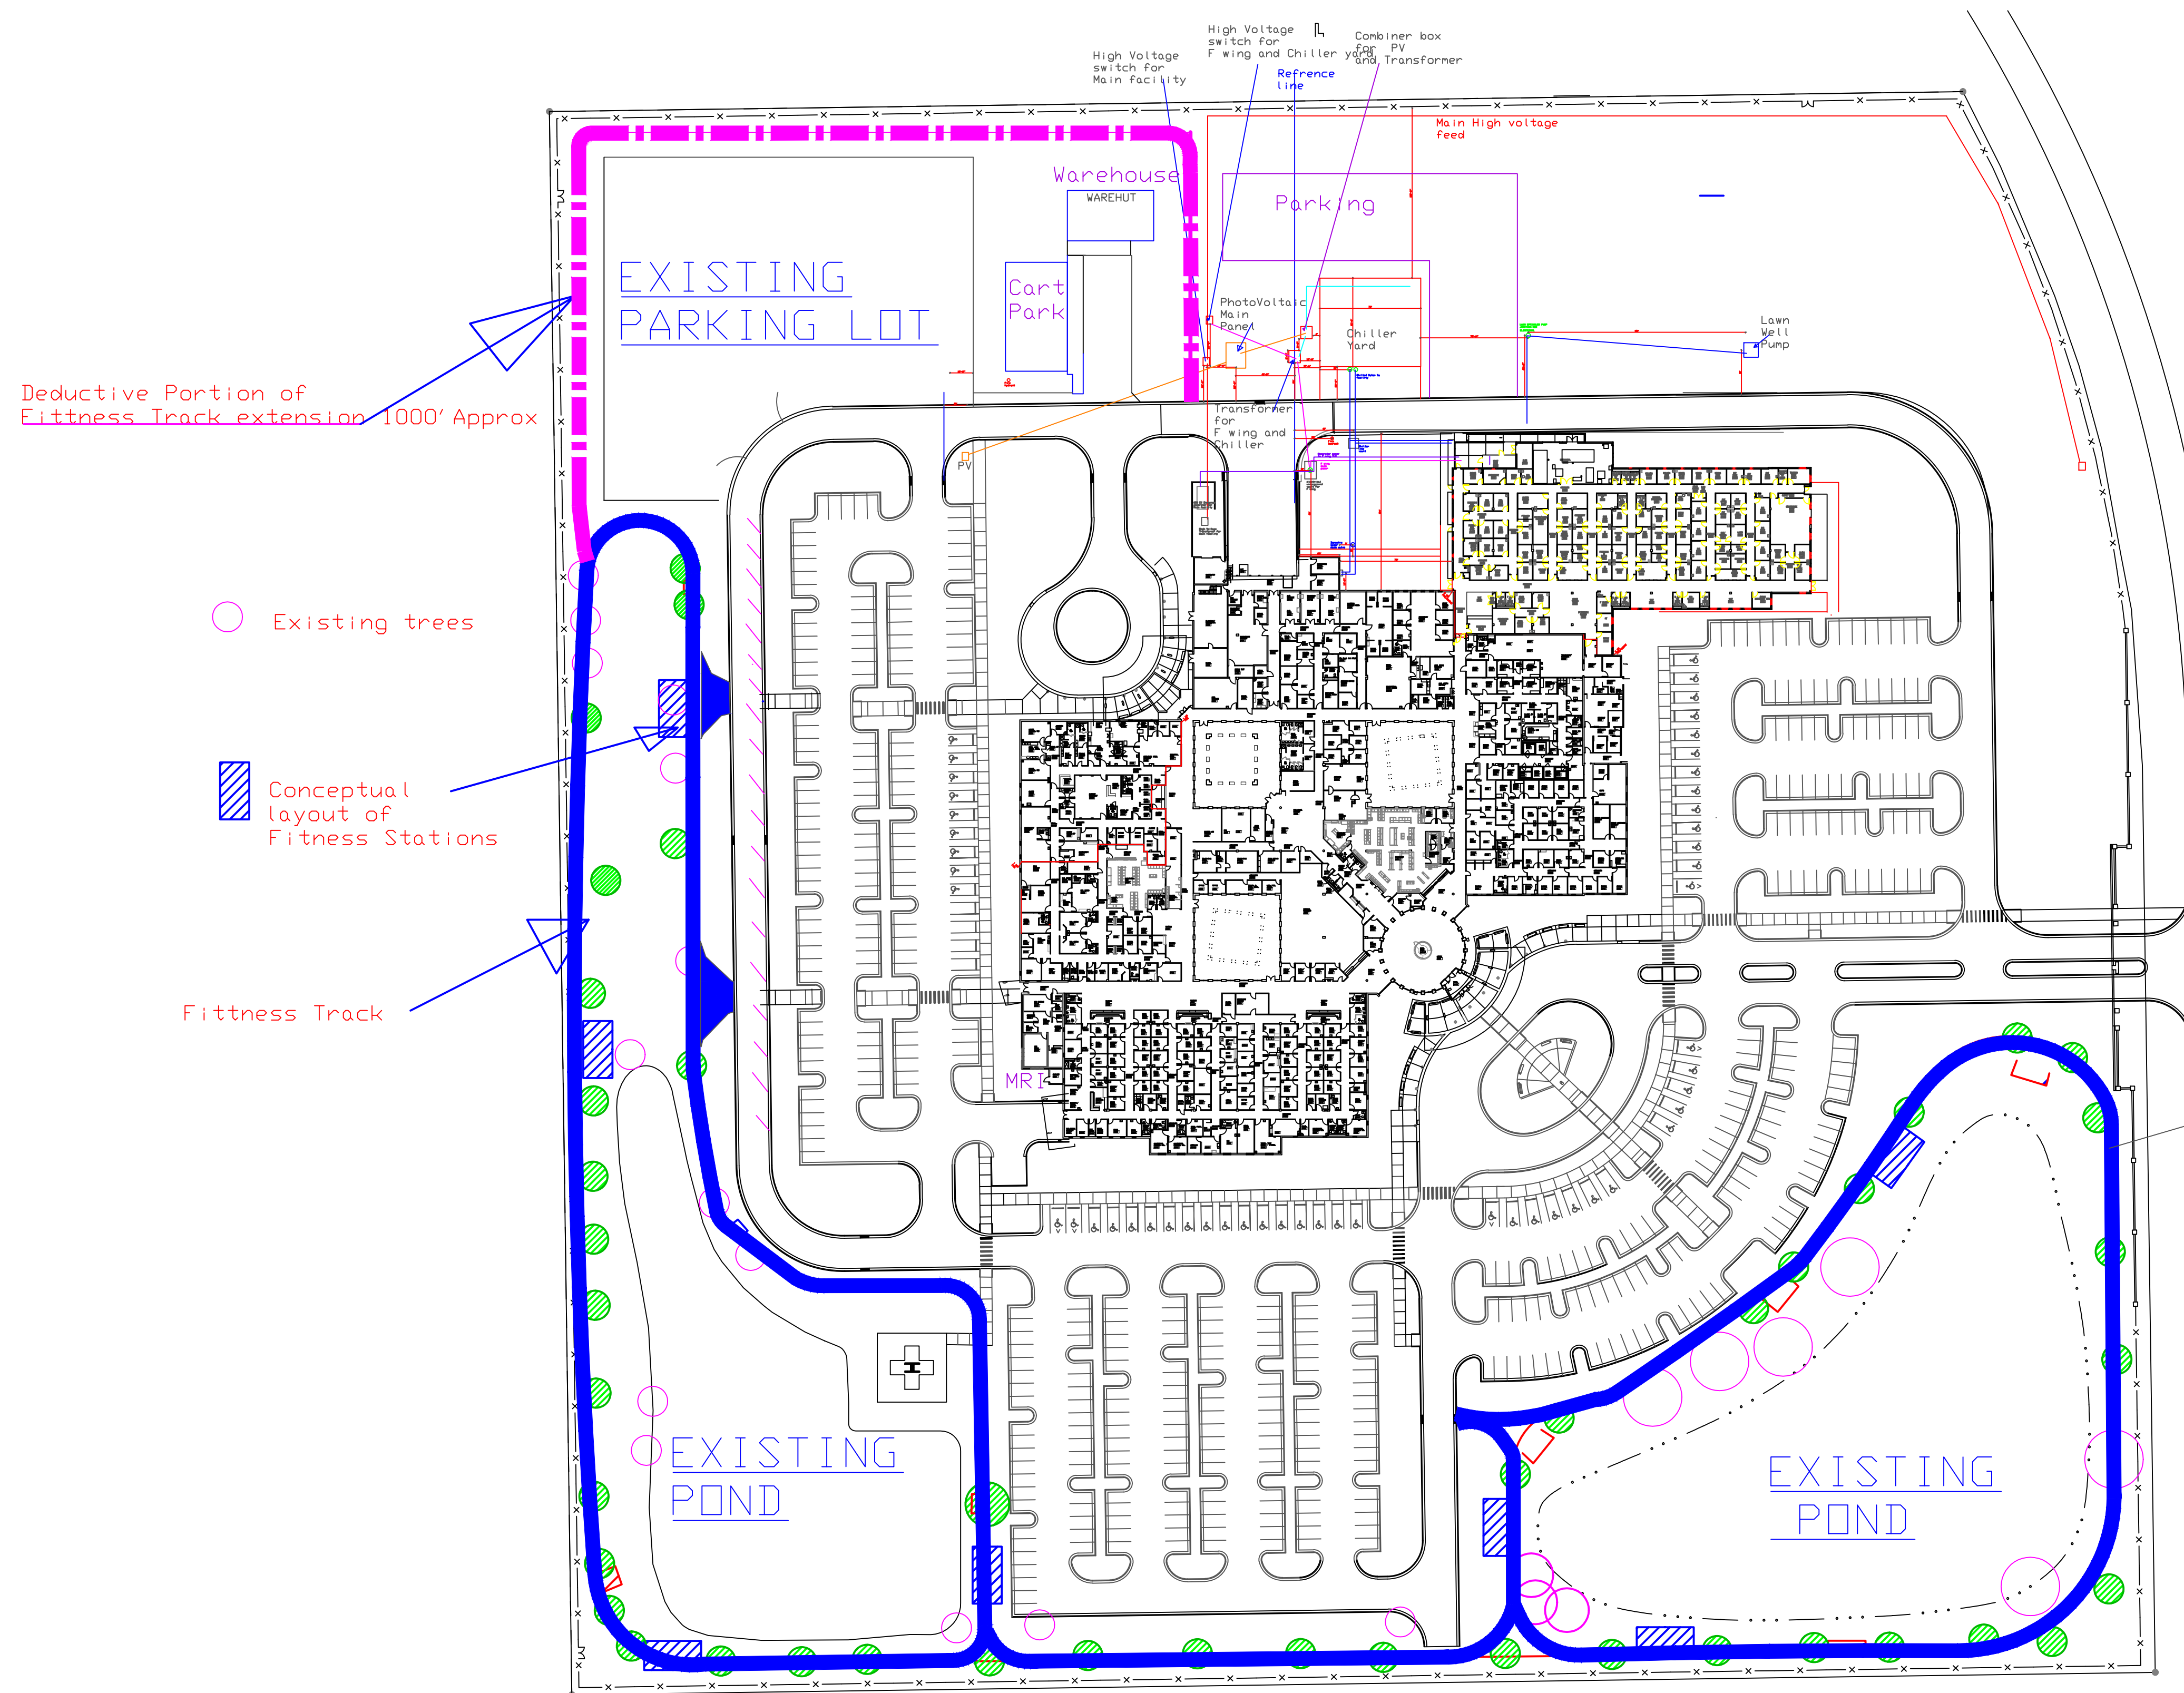

Conceptual Idea of
Walking Path Location

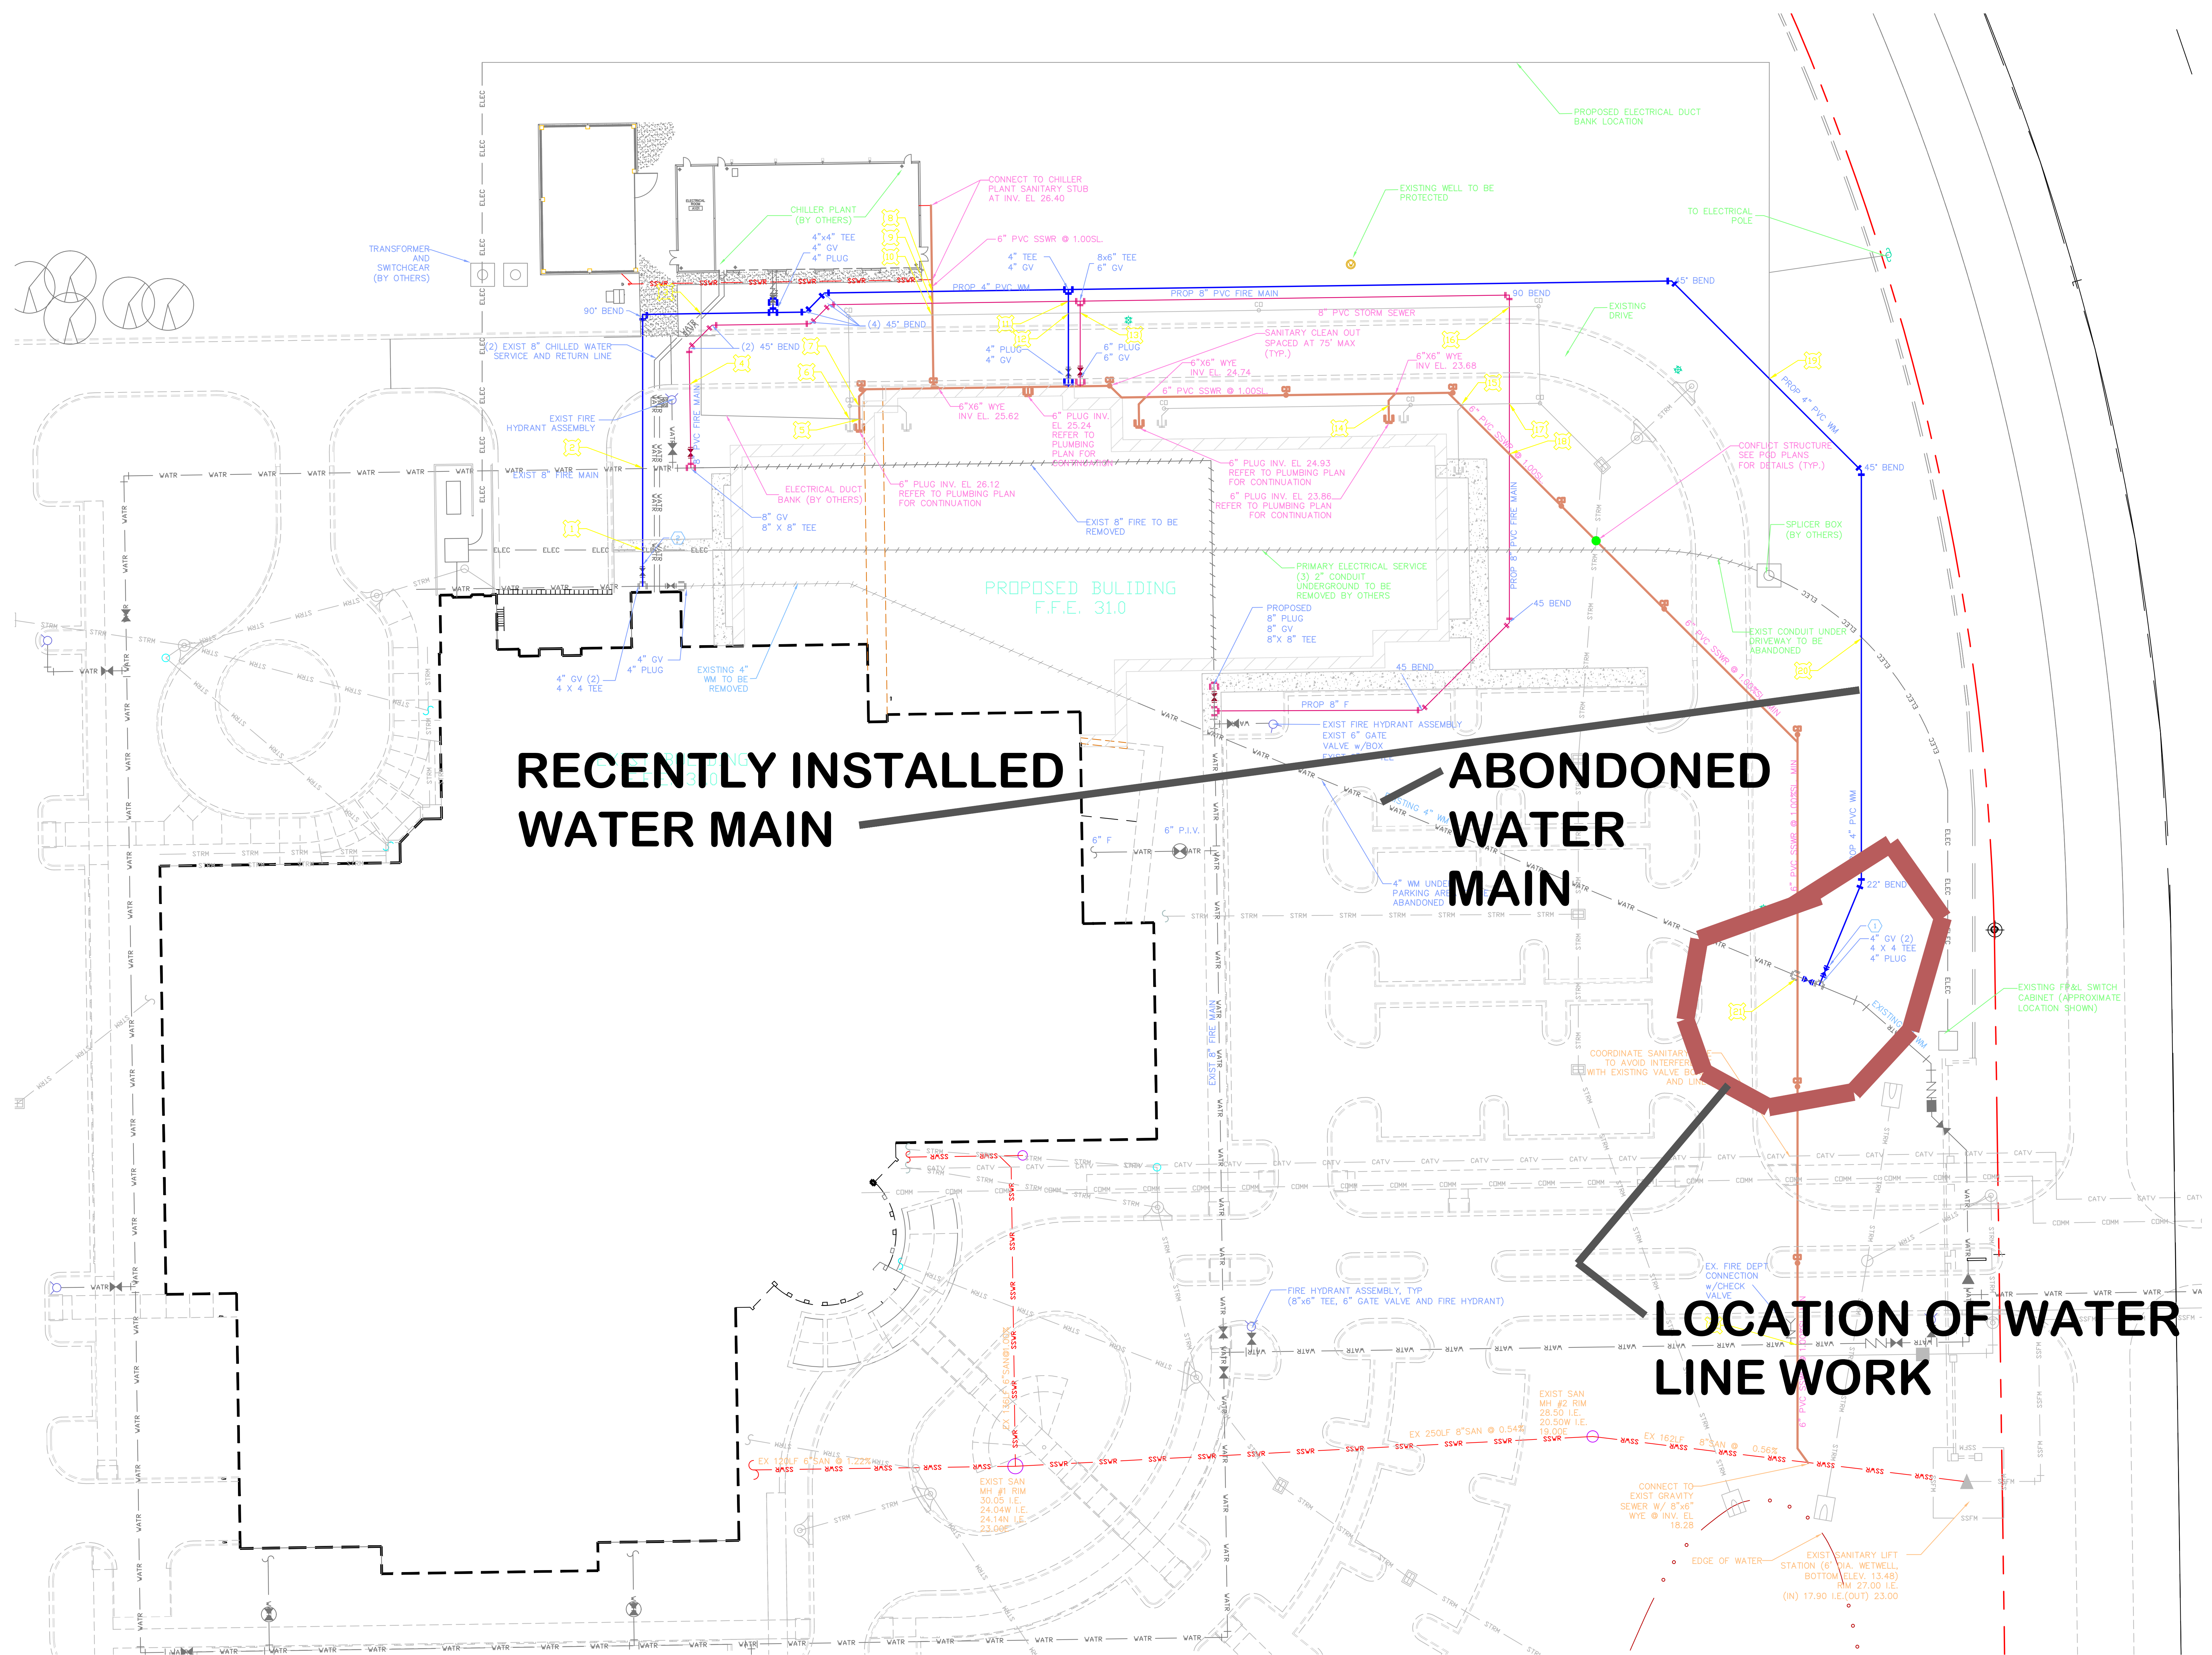

WATER MAIN