

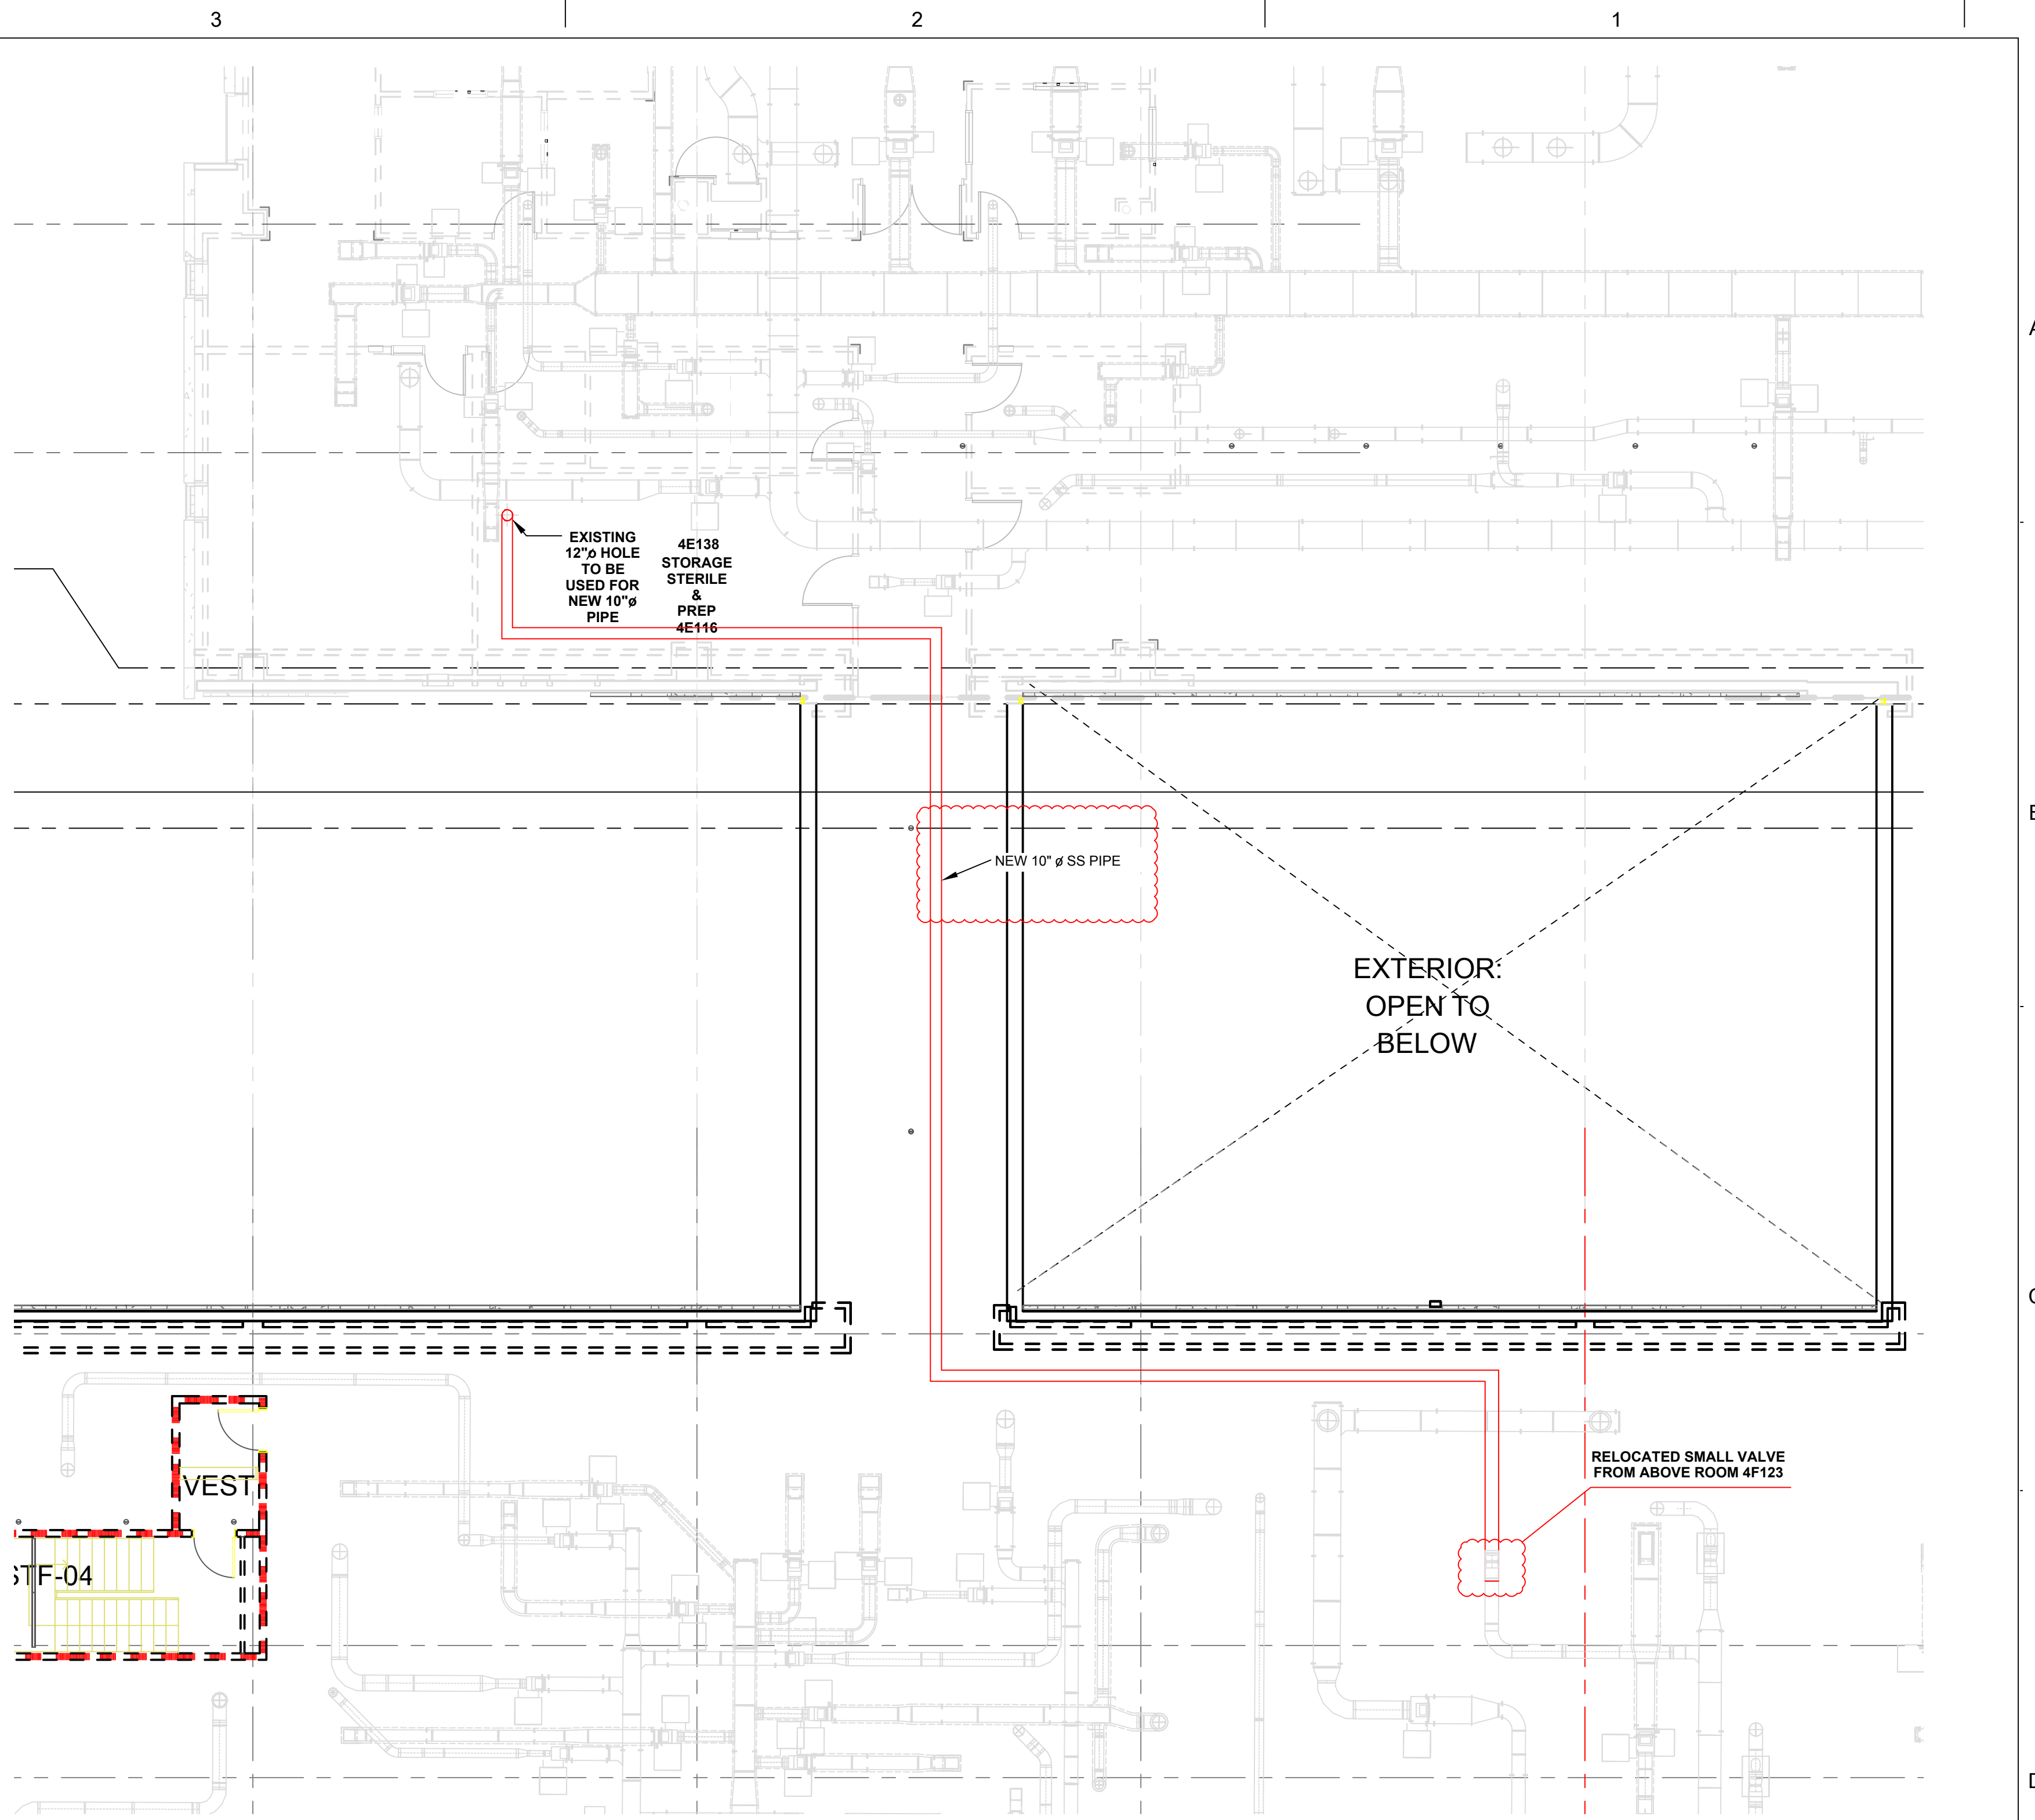


PARTIAL EXISTING INTERSTITIAL AREA-- AC DUCTS
DIAGNOSTIC AND TREATMENT BUILDING
BLDG 2 -FOURTH FLOOR PLAN - AREAS E AND F
SCALE: 1/8" = 1'-0"

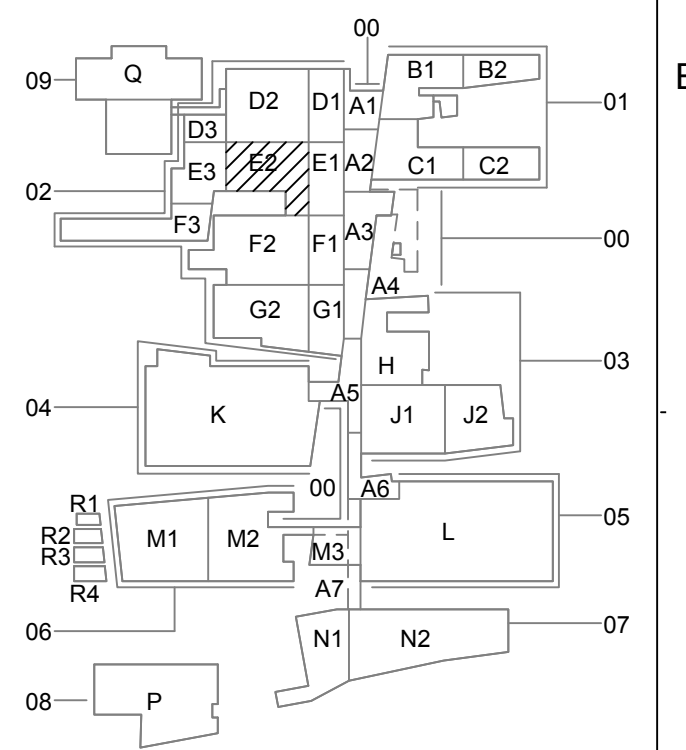

PARTIAL EXISTING INTERSTITIAL AREA-- PROPOSED RELOCATION BSC- PROJECT 629-17-107
DIAGNOSTIC AND TREATMENT BUILDING
BLDG 2 -FOURTH FLOOR PLAN - AREAS E AND F
SCALE: 1/8" = 1'-0"

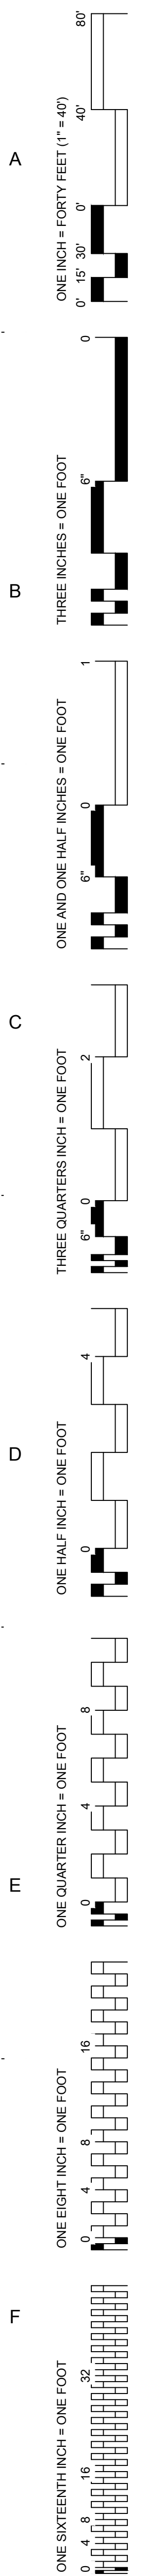

DRAWING TITLE BLDG 2 4TH FLR- PARTIAL INTERSTITIAL FLOOR		PROJECT TITLE SLVHCS REPLACEMENT MEDICAL CENTER PROJECT		PROJECT NUMBER 629-17-107		BUILDING NUMBER 02		FULLY SPRINKLERED OFFICE OF CONSTRUCTION AND FACILITIES MANAGEMENT Department of Veterans Affairs	
APPROVED: PROJECT DIRECTOR		LOCATION NEW ORLEANS, LOUISIANA		DOCUMENT SET PACKAGE		DRAWING NUMBER A1			
DATE Nov. 1, 2017		CHECKED K.W.		DRAWN E.B.					
REVISIONS:		DATE							