

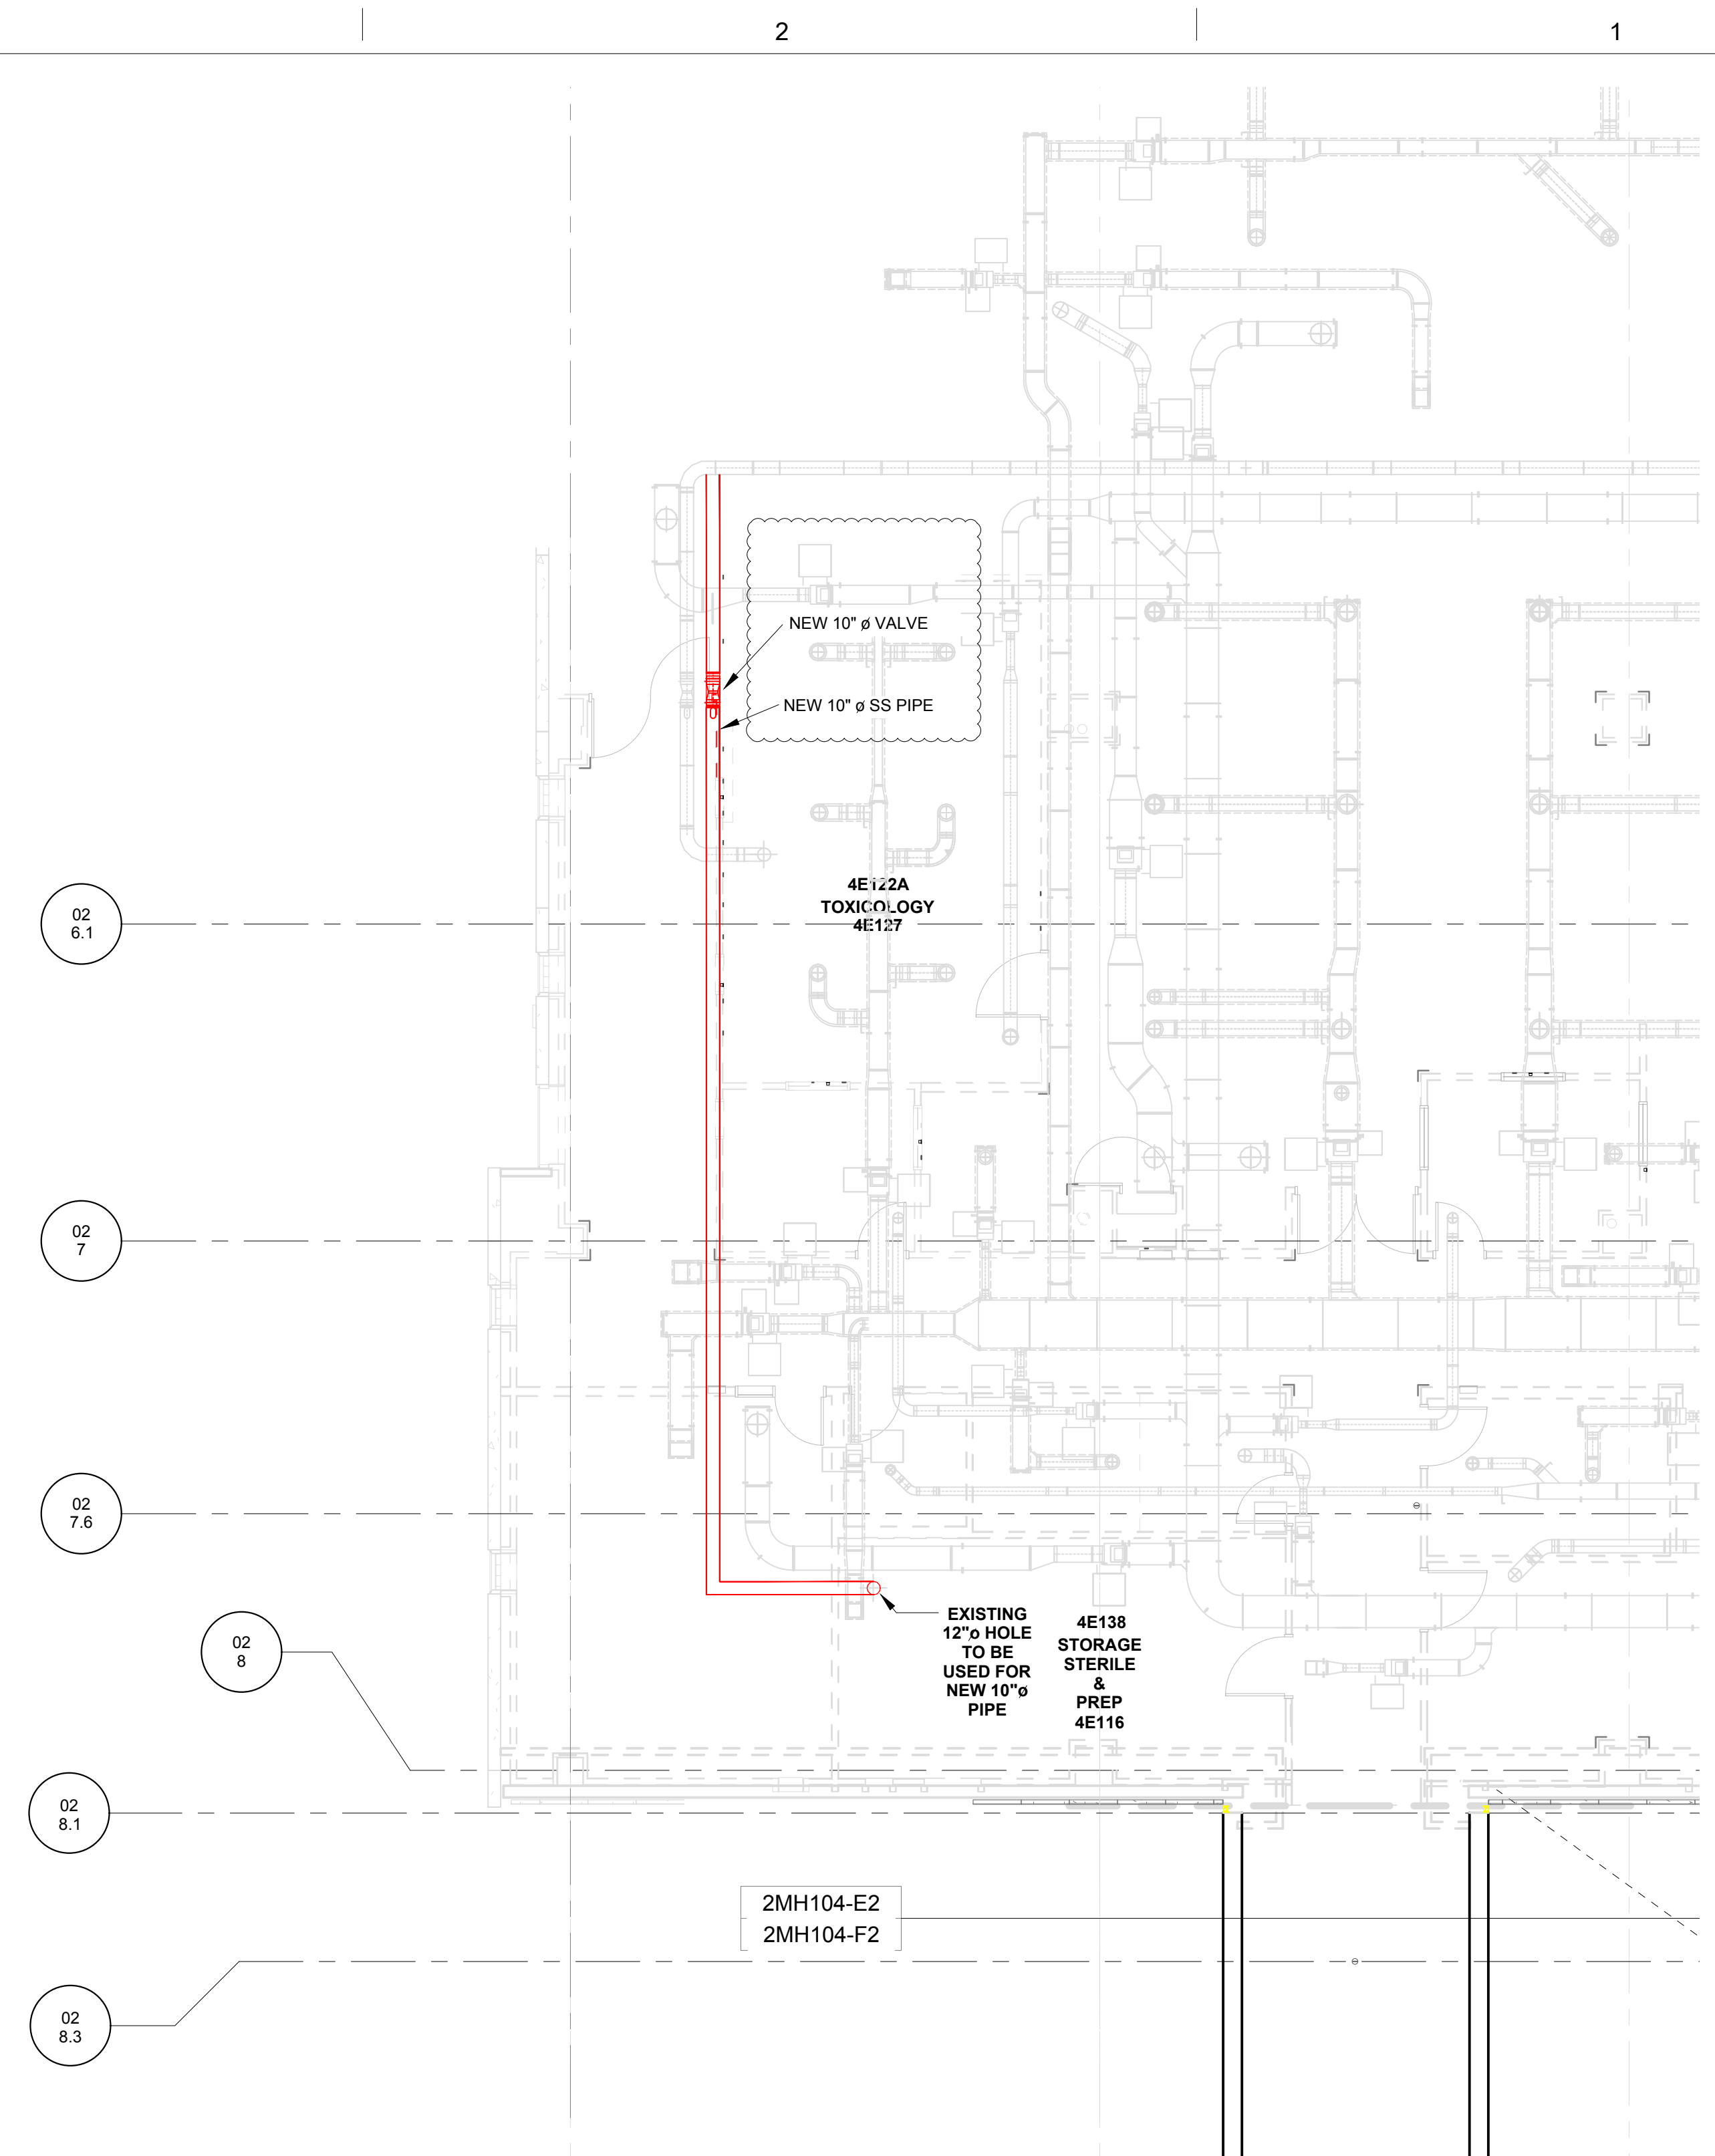


PARTIAL EXISTING INTERSTITIAL AREA-- AC DUCTS
DIAGNOSTIC AND TREATMENT BUILDING
BLDG 2 -FOURTH FLOOR PLAN - AREAS E1 AND E2
SCALE: 1/8" = 1'-0"

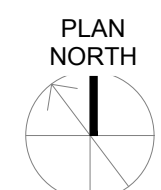

 
PARTIAL EXISTING INTERSTITIAL AREA-- PROPOSED RELOCATION BSC- PROJECT 629-17-107
DIAGNOSTIC AND TREATMENT BUILDING
BLDG 2 -FOURTH FLOOR PLAN - AREAS E1 AND E2


SCALE: 1/8" = 1'-0"

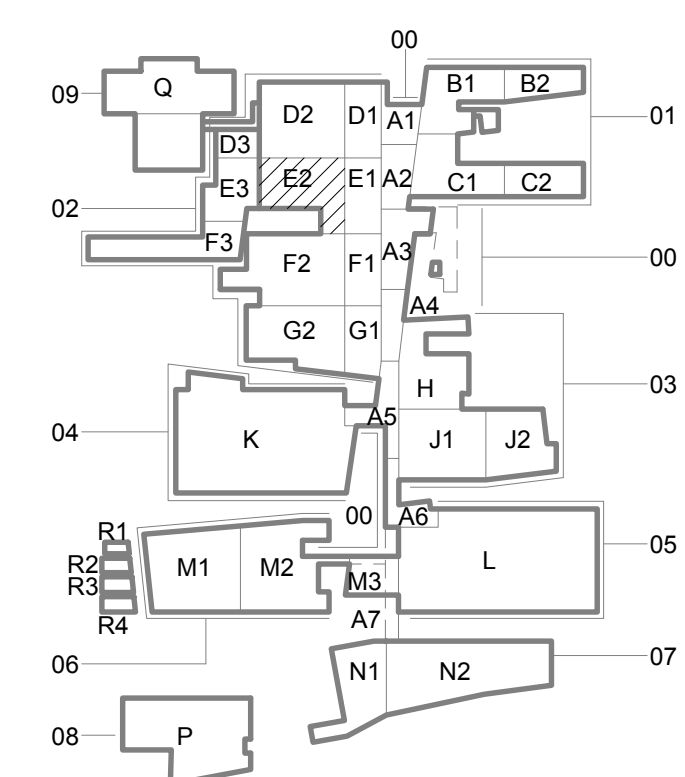

FULLY SPRINKLERED

OFFICE OF
CONSTRUCTION
AND FACILITIES
MANAGEMENT



DRAWING TITLE BLDG 2 4TH FLR- PARTIAL INTERSTITIAL FLOOR		PROJECT TITLE SLVHCS REPLACEMENT MEDICAL CENTER PROJECT		PROJECT NUMBER 629-17-107		BUILDING NUMBER 02	
APPROVED: PROJECT DIRECTOR		LOCATION NEW ORLEANS, LOUISIANA		DOCUMENT SET PACKAGE		<div>OFFICE OF CONSTRUCTION AND FACILITIES MANAGEMENT</div> <div>  <div>Department of Veterans Affairs</div> </div>	
		<div>DATE Oct. 27 2017</div> <div>CHECKED K.W</div> <div>DRAWN E.B</div>		DRAWING NUMBER A1			