



EXISTING VALVES LOCATIONS AFFECTED BY THIS PROJECT-629-17-107
PARTIAL EXISTING INTERSTITIAL AREA-- AC DUCTS
DIAGNOSTIC AND TREATMENT BUILDING
BLDG 2 -FOURTH FLOOR PLAN - AREAS E AND F
SCALE: 1/8" = 1'-0"

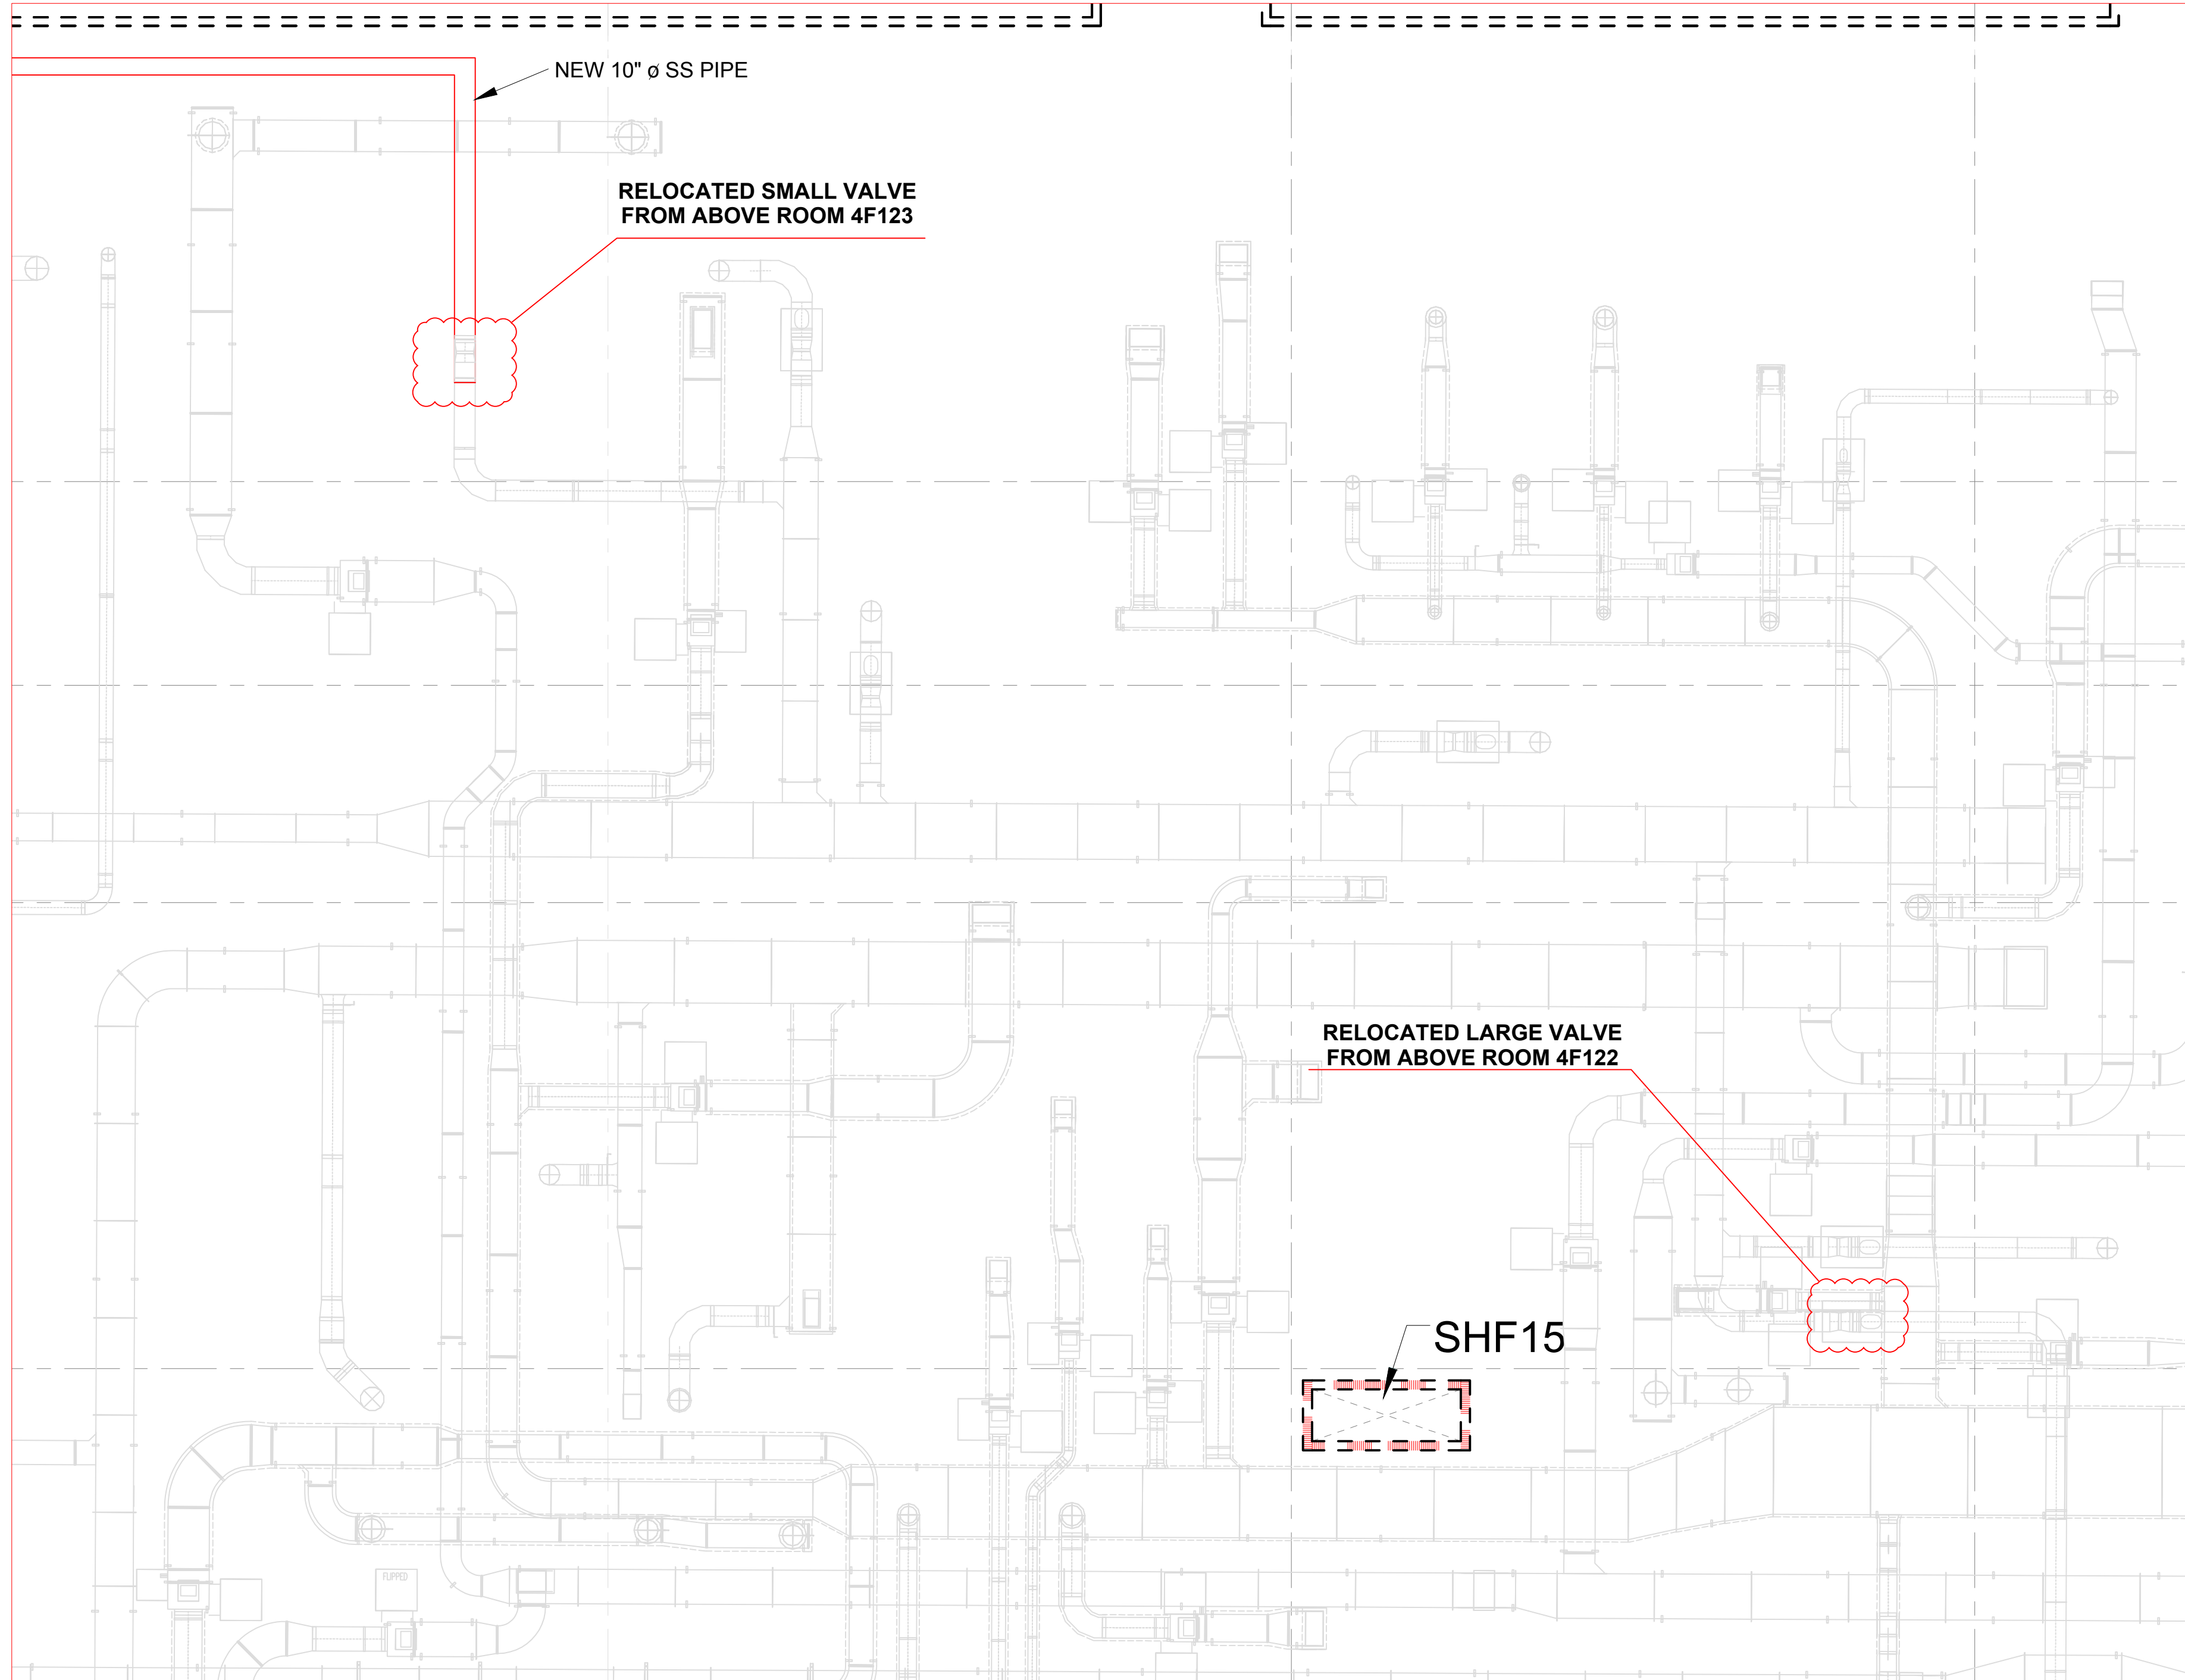

PROPOSED CHANGES TO INDICATED VALVES--
PARTIAL EXISTING INTERSTITIAL AREA-- PROPOSED RELOCATION BSC- PROJECT 629-17-107
DIAGNOSTIC AND TREATMENT BUILDING
BLDG 2 -FOURTH FLOOR PLAN - AREAS E AND F
SCALE: 3/16" = 1'-0"

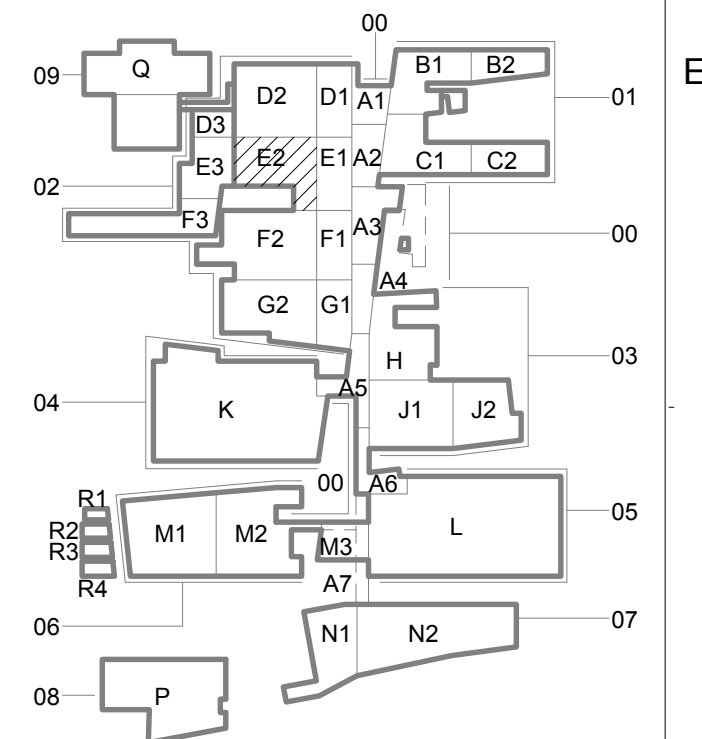

CONSTRUCTION DOCUMENTS 1
FULLY SPRINKLERED

OFFICE OF
CONSTRUCTION
AND FACILITIES
MANAGEMENT



DRAWING TITLE BLDG 2 4TH FLR-PARTIAL INTERSTITIAL FLOOR		PROJECT TITLE SLVHCS REPLACEMENT MEDICAL CENTER PROJECT		PROJECT NUMBER 629-17-107	BUILDING NUMBER 02
APPROVED: PROJECT DIRECTOR		LOCATION NEW ORLEANS, LOUISIANA		DOCUMENT SET PACKAGE	
DATE Nov. 1, 2017		CHECKED K.W	DRAWN E.B	DRAWING NUMBER A2	

REVISIONS:	DATE
------------	------