


COATESVILLE VETERANS AFFAIRS MEDICAL CENTER
1400 BLACKHORSE HILL RD.
COATESVILLE, PENNSYLVANIA 19320
SPS SATELLITE STORAGE ROOMS
PROJECT NO. VA 542-17-102



VA APPROVAL

Contracting Officer's Representative	Date
Projects Section Supervisor	Date
Utilities / HVAC Supervisory Engineer	Date
VP of Facilities Management Service	Date
Deputy Director	Date
Director	Date

COATESVILLE VAMC

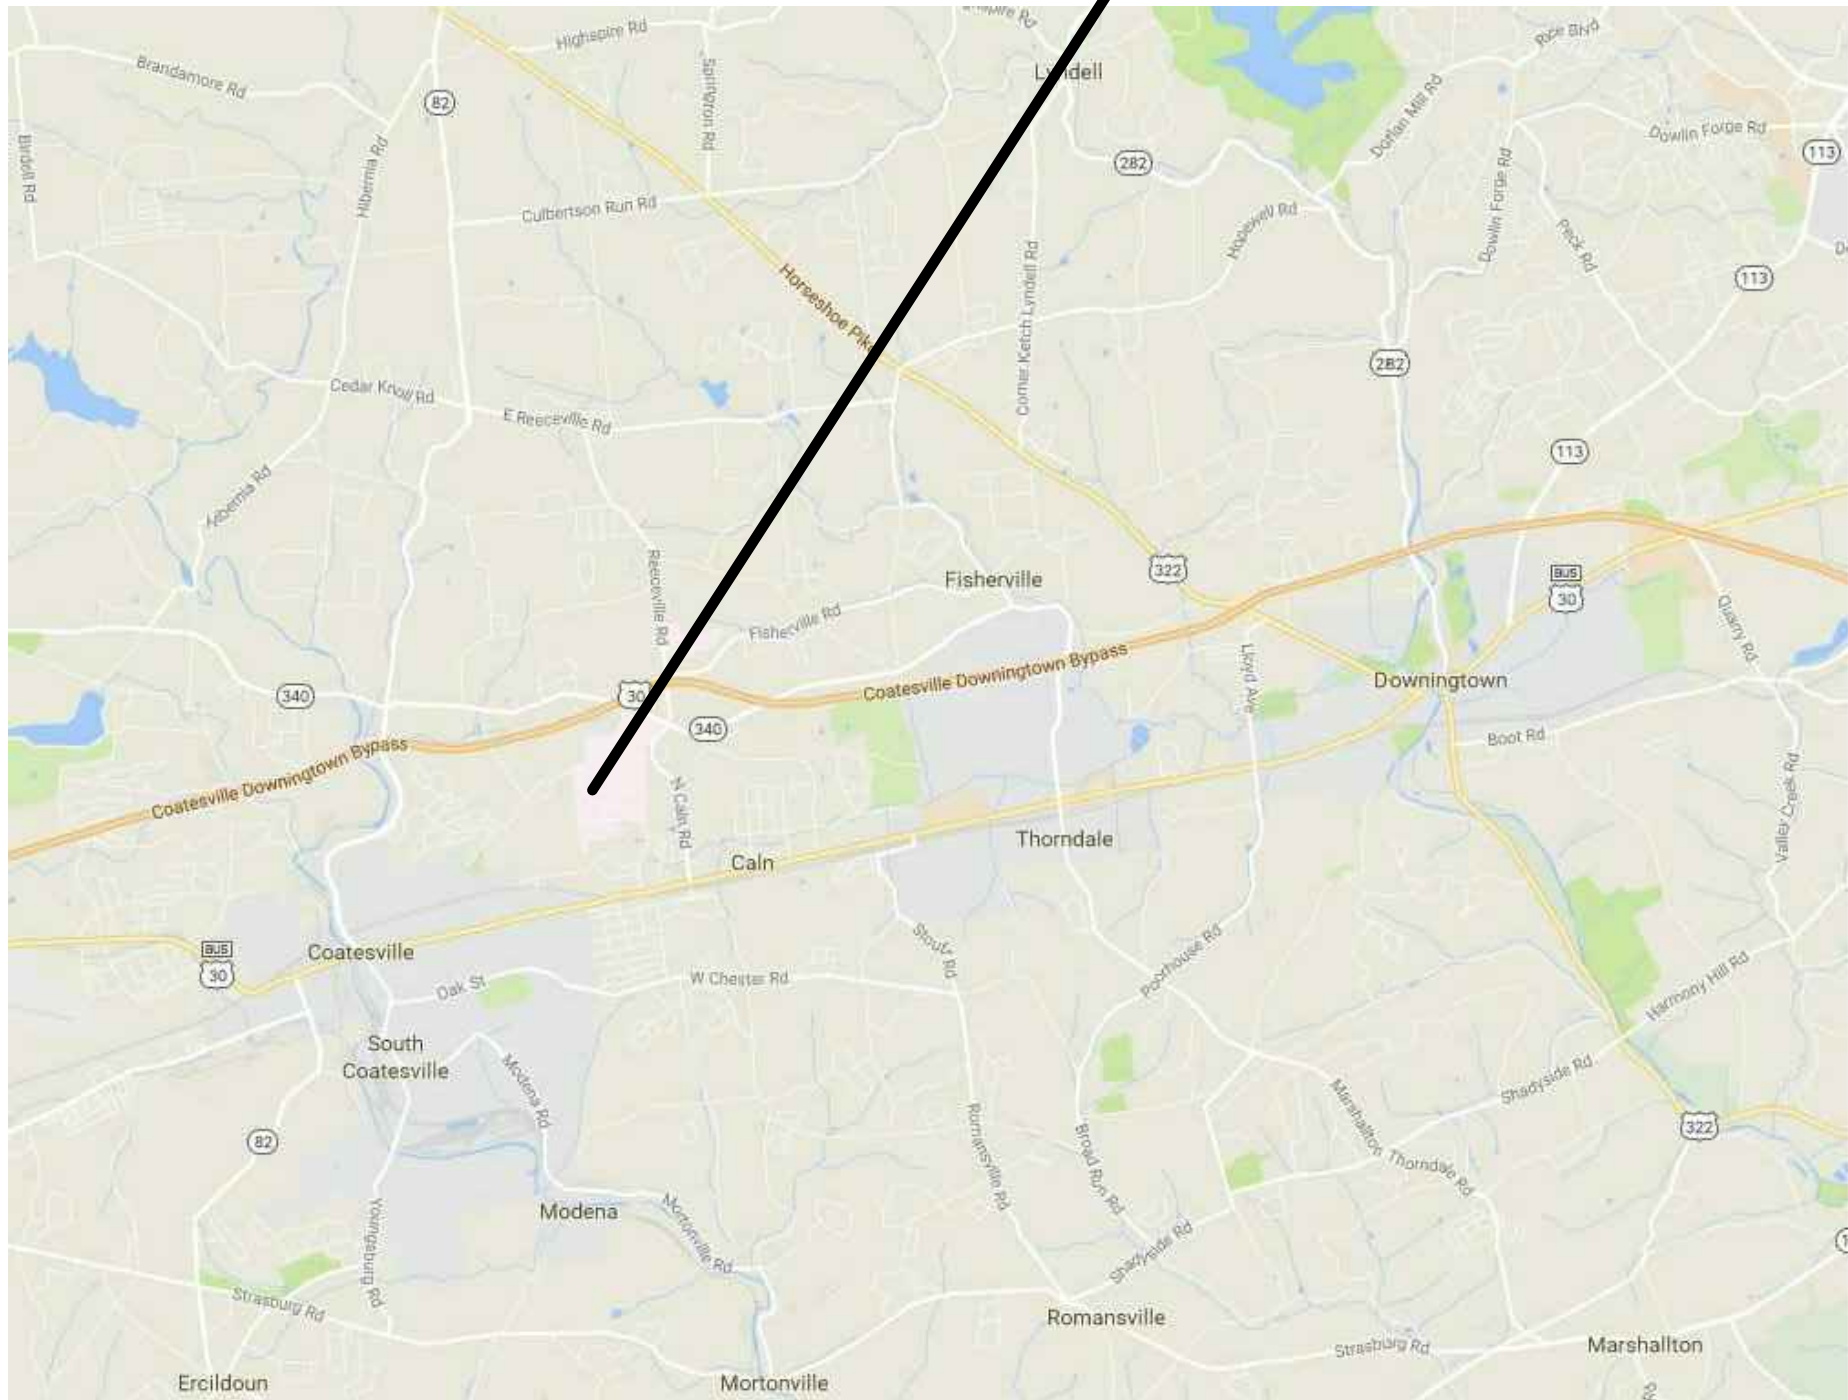

DRAWING LIST

GENERAL:

GI101 COVER SHEET

ARCHITECTURAL:

AE001	ARCHITECTURAL NOTES, SYMBOLS, AND ABBREVIATIONS
AE101	BUILDING 1 & 2 ARCHITECTURAL PLANS
AE102	BUILDING 3 ARCHITECTURAL PLANS
AE103	BUILDING 4 ARCHITECTURAL PLANS
AE104	BUILDING 6 & 7 ARCHITECTURAL PLANS
AE105	BUILDING 8, 38, 39, & 57 ARCHITECTURAL PLANS
AE106	BUILDING 13 ARCHITECTURAL PLANS
AE107	BUILDING 58 & 59 ARCHITECTURAL PLANS
AE108	BUILDING 69 & 139 ARCHITECTURAL PLANS
AE 5 0 0	ARCHITECTURAL DETAILS

MECHANICAL:

M-001	MECHANICAL NOTES, SYMBOLS, AND ABBREVIATIONS
MH101	BUILDING 1 & 2 MECHANICAL PLANS
MH102	BUILDING 3 MECHANICAL PLANS
MH103	BUILDING 4 MECHANICAL PLANS
MH104	BUILDING 6 & 7 MECHANICAL PLANS
MH105	BUILDING 8, 38, 39, & 57 MECHANICAL PLANS
MH106	BUILDING 13 MECHANICAL PLANS
MH107	BUILDING 58 & 59 MECHANICAL PLANS
MH108	BUILDING 69 & 139 MECHANICAL PLANS
MH200	BUILDING 1 COMMISSIONING PLANS
MH201	BUILDING 2 COMMISSIONING PLANS
MH202	BUILDING 3 COMMISSIONING PLANS
MH203	BUILDING 4 COMMISSIONING PLANS
MH204	BUILDING 6 COMMISSIONING PLANS
MH205	BUILDING 7 COMMISSIONING PLANS

MECHANICAL (CONTINUED):


MH206	BUILDING 8 COMMISSIONING PLANS
MH207	BUILDING 38 COMMISSIONING PLANS
MH208	BUILDING 39 COMMISSIONING PLANS
MH209	BUILDING 57 COMMISSIONING PLANS
MH210	BUILDING 58 COMMISSIONING PLANS
MH211	BUILDING 59 COMMISSIONING PLANS
MH212	BUILDING 69 COMMISSIONING PLANS
MH213	BUILDING 138 COMMISSIONING PLANS
M-401	BUILDING 3 ENLARGED MECHANICAL PLANS
M-501	MECHANICAL DETAILS
M-601	MECHANICAL SCHEDULES
M-602	MECHANICAL SCHEDULES
M-701	MECHANICAL CONTROLS
M-702	MECHANICAL CONTROLS
M-703	MECHANICAL CONTROLS
M-704	MECHANICAL CONTROLS

ELECTRICAL:

E-001	ELECTRICAL NOTES, SYMBOLS, AND ABBREVIATIONS
E-101	BUILDING 1 & 2 ELECTRICAL PLANS
E-102	BUILDING 3 ELECTRICAL PLANS
E-103	BUILDING 4 ELECTRICAL PLANS
E-104	BUILDING 6 & 7 ELECTRICAL PLANS
E-105	BUILDING 8, 38, 39, & 57 ELECTRICAL PLANS
E-106	BUILDING 58 & 59 ELECTRICAL PLANS
E-107	BUILDING 69 & 139 ELECTRICAL PLANS
E-501	ELECTRICAL DETAILS

VICINITY MAP


SCALE: NTS

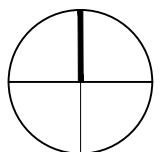

CAMPUS MAP


SCALE: NTS

NORTH

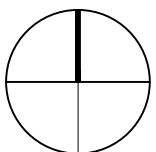

CONSULTANT ENGINEER:

SEAL:

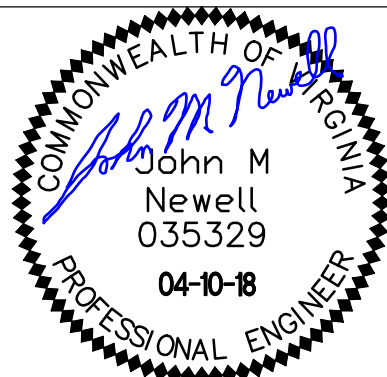

PROJECT MANAGER:



Raleigh, NC
Indianapolis, IN
Pittsburgh, PA
Virginia Beach, VA
Atlanta, GA
Fort Collins, CO

Drawing Title
COVER SHEET

Approved Project Director

Project Title
SPS SATELLITE STORAGE ROOMS

Location
COATESVILLE, PENNSYLVANIA

Date
04.10.18

Checked
SJP

Drawn
JMN

Project Number
542-17-102

Building Number

Drawing Number
GI001

Dwg. 1 of 1

Office of
Construction
and Facilities
Management

