


three eighths inch = one foot
one and one half inch = one foot
one inch = one foot
three quarters inch = one foot
one half inch = one foot
one quarter inch = one foot
one eighth inch = one foot

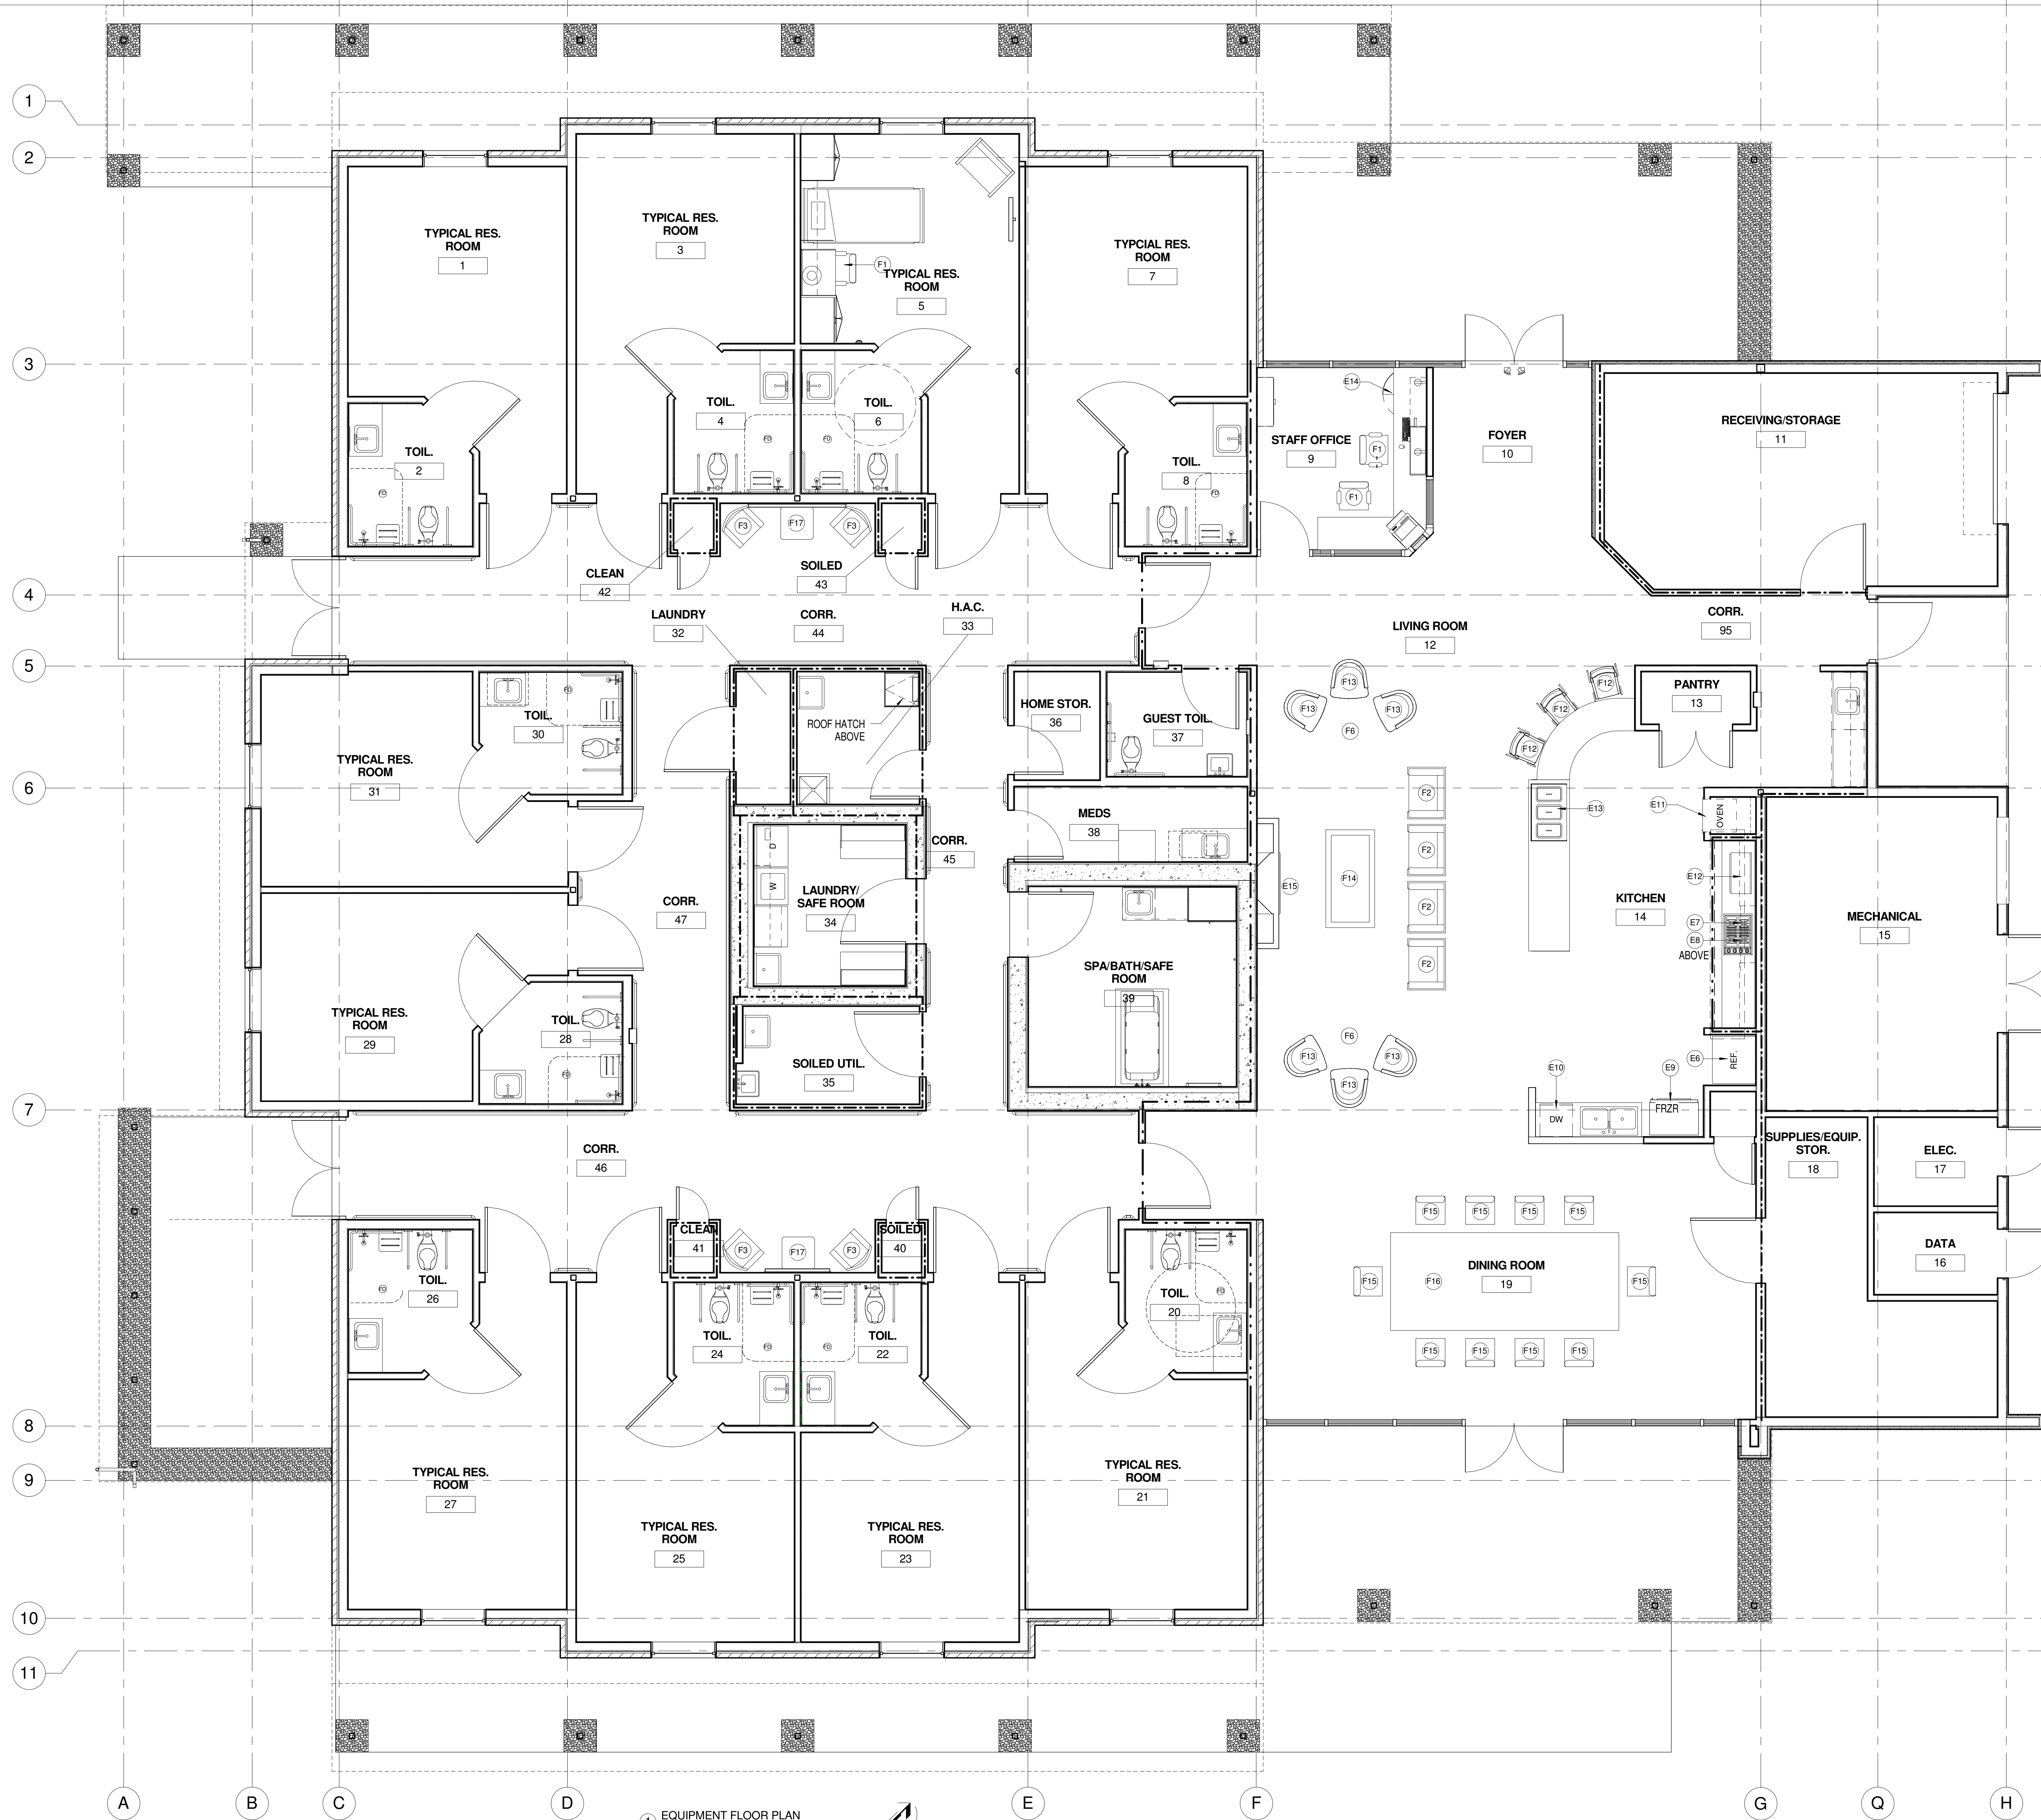


1 EQUIPMENT FLOOR PLAN
1/4" = 1'-0"

EQUIPMENT LIST		NOT ALL EQUIPMENT APPLY TO THIS SHEET PROVIDED BY: VOLTAGE NOTES		
NO.	DESCRIPTION			
E1	SHAMPOO SINK, ADJUST SINK	CC		1,3
E2	STYLING CHAIR, ACCESS HYDRAULIC ALL PURPOSE CHAIR, COLLINS	CC		
E3	STYLING CHAIR 1800 HYDRAULIC CHAIR, COLLINS	CC		
E4	HAIR DRYER, PORTABLE COLLINS 1433 S	CC	120V	
E5	UNDER COUNTER REF; GE GML049GAEB5	CC	120V	
E6	REFRIGERATOR, WHIRLPOOL WRS342FIAM	CC	120V	6
E7	STOVE TOP, ELECT. 4 BURN(INDUCTION) WHIRLPOOL GC3061XB	CC	208V	
E8	HOOD, WHIRLPOOL GXW7330DX3	CC	120V	
E9	FREEZER,WHIRLPOOL UPRIGHT EV188NYWS	CC	120V	
E10	DISHWASHER, WHIRLPOOL WDF550SAAS	CC	120V	2,3
E11	BUILT-IN OVEN, WHIRLPOOL WOS92EC0AS	CC	208V	
E12	MICROWAVE COUNTERTOP WHIRLPOOL, WMC50522AS	CC	120V	
E13	WELL STEAM TABLE VOLLRATH 3040500 WISNEEZEGUARD	CC	208V	1,3
E14	UNDER COUNTER REF. KENMORE 4692489	CC	120V	
E15	ELECT. FIRE PLACE DIMPLEX BF45DXP W/BLACK TRIM, BI-FOLD GLASS AND REMOTE	CC	120V	
E16	SPEED QUEEN FTSAOAWN	CC	120V	1,3
E17	SPEED QUEEN FES17AWF	CC	208V	

FURNITURE LIST		NO. DESCRIPTION PROVIDED BY: VOLTAGE NOTES		
NO.	DESCRIPTION			
F1	DESK CHAIR	VV		
F2	MEDIUM SOFA CHAIR	VV		
F3	SMALL SOFA CHAIR	VV		
F4	SMALL COFFEE TABLE	VV		
F5	END TABLE	VV		
F6	ROUND TABLE	VV		
F7	FOLDABLE CHAIR	VV		
F8	CONFERENCE TABLE	VV		
F9	CONFERENCE CHAIR	VV		
F10	POOL TABLE	VV		
F11	STACKABLE CHAIR	VV		
F12	LOW COUNTER SEATING	VV		
F13	ROUND BACK CHAIR	VV		
F14	LARGE COFFEE TABLE	VV		
F15	DINING CHAIR	VV		
F16	DINING TABLE	VV		
F17	SMALL END TABLE	VV		

EQUIPMENT LIST NOTES
1 HOT & COLD WATER
2 COLD WATER
3 DRAIN

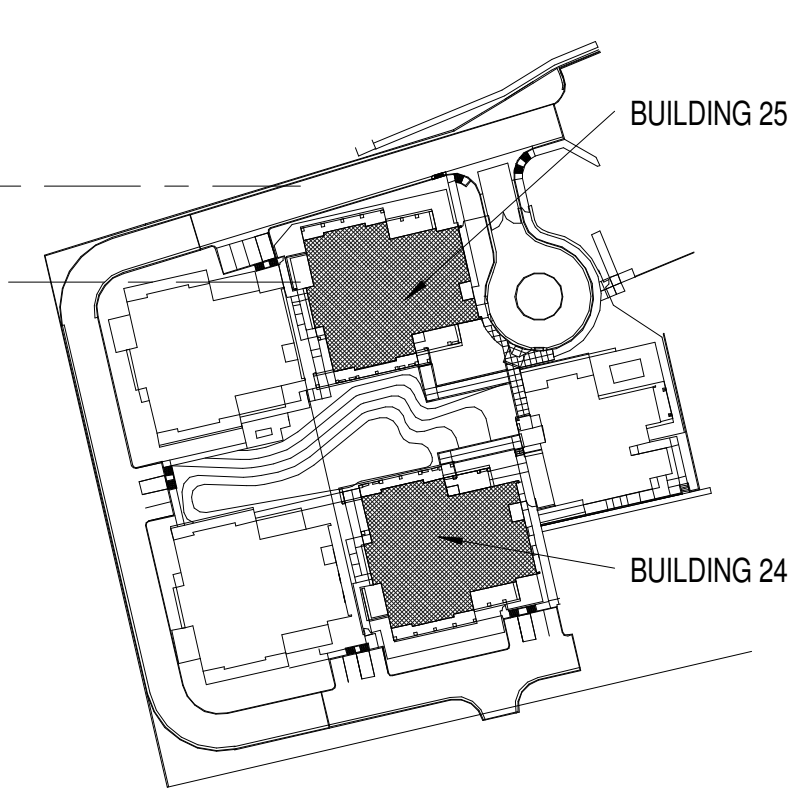

KEY PLAN

COTTAGE BLDGS. 24 & 25 - EQUIPMENT SCHEDULE

Office of Construction and Facilities Management
Department of Veterans Affairs
ARCHITECT OF RECORD:
Hayden Horn
REGISTERED ARCHITECT
12/15/14
STATE OF TEXAS
ARCHITECTURE & PLANNING
15 E. PENNINGTON STREET
TUCSON, AZ 85701
T: 520.620.0265
E: SBBL@SBBL.BIZ

CONSTRUCT NEW CLC, PHASE 1
WEST TEXAS VA HEALTH CARE SYSTEM,
BIG SPRING, TEXAS

Approved: VA Area Proj. Mgr.

V.A. PROJECT NO: 519-368
SBBL PROJECT NO: 11023
DRAWN BY: GDR
CHECKED BY: KRI
DATE: 12/15/14

△	Date	Revision

Approved: Med. Ctr. Director

Approved: Asst. Admin Engineering Service

Approved: Asst. VA Medical Director

Approved: Chief of Engineering

Approved: Chief of Projects

SHEET 62 OF 123
24-AS9.1
CAD FILE # 24-AS9.1.dwg