

VA CBOC Portland

U.S. Department of
Veterans Affairs

PROJECT NO. 36C10F18N3251
07/03/2018
FINAL SUBMISSION

SHEET INDEX	
GENERAL	
G001	COVER SHEET
A-101	OVERALL PLAN - ABOA SUMMARY
A-102	OVERALL PLAN
A-103	ENLARGED PLAN - AREA A
A-104	ENLARGED PLAN - AREA B
A-105	ENLARGED PLAN - AREA C
A-106	ENLARGED PLAN - AREA D

PLANNING
ARCHITECTURE
ENGINEERING
INTERIORS

EST. 1915
ABU DHABI
ATLANTA
AUSTIN
CHICAGO
COLLEGE STATION
CORPUS CHRISTI
DALLAS
FLINT
FORT WORTH
HOUSTON
LAN - MONTGOMERY COUNTY
LANSING
LAREDO
LAS VEGAS
LOS ANGELES
MIAMI
MIDWEST
MILPITAS
MINNEAPOLIS
NORMAN
OMAHA
ORANGE
SACRAMENTO
SAN ANTONIO
SAN MARCOS
TAMPA
WACO
WASHINGTON, DC
WEST PALM BEACH

VA U.S. Department
of Veterans
Affairs




LEO A DALY



DEPARTMENT LEGEND

01 - LOBBY / RECEPTION AREA	11 - CLINIC MANAGEMENT	22 - HOME BASED PRIMARY CARE
02 - AUDIOLOGY AND SPEECH PATHOLOGY	13 - ENGINEERING SERVICE	23 - EDUCATION
02 - PACT SPACE - 4 MODULES, 16 TEAMLETS	14 - LOGISTICS SERVICE	24 - OIT AREA
03 - DENTAL	15 - POLICE SERVICE	25 - ENVIRONMENTAL MANAGEMENT (EMS)
04 - EYE CLINIC	16 - CANTEN SERVICE	26 - ADMIN AREA
05 - MENTAL HEALTH CLINIC	17 - STAFF SUPPORT AREA	
06 - PHYSICAL MEDICINE AND REHABILITATION (PM&R) CLINIC	18 - SUPPORT AREA	
07 - PROSTHETICS AND SENSORY AIDS CLINIC	19 - BUILDING SUPPORT	
08 - RADIOLOGY SERVICE	20 - STAFF ONLY CIRC.	
09 - PATHOLOGY AND LABORATORY MEDICINE (PLM) SERVICE	21 - VOLUNTARY SERVICE	

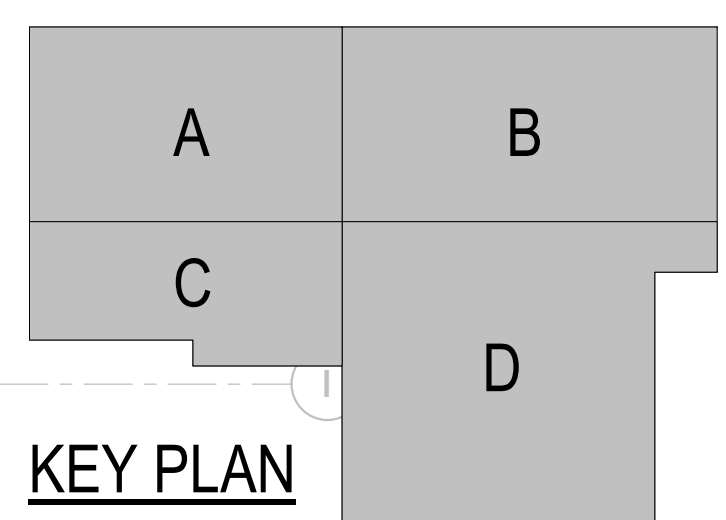

ABOA SQUARE FOOTAGE: 62,300 SF

OVERALL PLAN
SCALE: 3/32" = 1'-0"

Revisions:	Date:

CONSULTANT
LEO A DALY
730 2nd Ave. South #1100
Minneapolis, MN 55402
(612) 338-8741

ARCHITECT/ENGINEER OF RECORD
F F E Inc
Engineering and Technical Services
420 Springfield Pike
Wyoming, OH 45215
513-522-0956

STAMP
Engineering and Facilities Management Services
U.S. Department of Veterans Affairs

Drawing Title
OVERALL PLAN
Approved:

Phase
FINAL SUBMISSION
TBD SPRINKLERED

Project Title
PORTLAND, ME CBCC

Location
PORTLAND, ME

Issue Date
07/03/2018

Checked
KDC

Drawn
AFG

Project Number
36C10F18N3251


Building Number
C.B.O.C

Drawing Number
A-102

7/26/2018 10:38:38 AM
C:\Users\afg\Documents\AutoCAD\Revit\2018\Projects\CBCC\04-Portland-Submission_3.dwg\sheet.rvt




1 ENLARGED FLOOR PLAN - AREA A
SCALE: 1/8" = 1'-0"

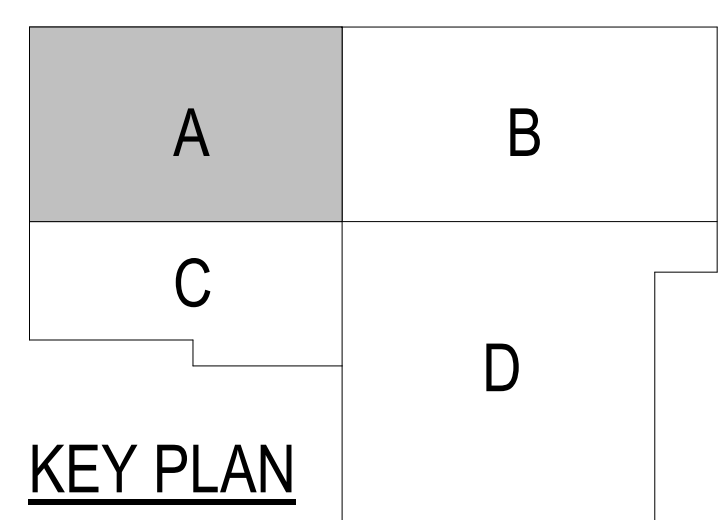


C:\Users\ajb\Documents\AutoCAD\Revit\2018\Projects\CBOC\04-Portland-Submission_3_ajb\Revit.rvt

CONSULTANT LEO A DALY 730 2nd Ave. South #1100 Minneapolis, MN 55402 (612) 338-8741 LEO A DALY	ARCHITECT/ENGINEER OF RECORD F F E Inc Engineering and Technical Services 420 Springfield Pike Wyoming, OH 45215 513-522-0956 FFE Inc Engineering and Technical Services	STAMP Engineering and Facilities Management Services VA U.S. Department of Veterans Affairs	Drawing Title ENLARGED PLAN - AREA A	Phase FINAL SUBMISSION	Project Title PORTLAND, ME CBOC	Project Number 36C10F18N3251		
			Approved:	TBD SPRINKLERED	Location PORTLAND, ME	Building Number C.B.O.C		
Revisions:	Date:				Issue Date 07/03/2018	Checked KDC	Drawn AFG	Drawing Number A-103

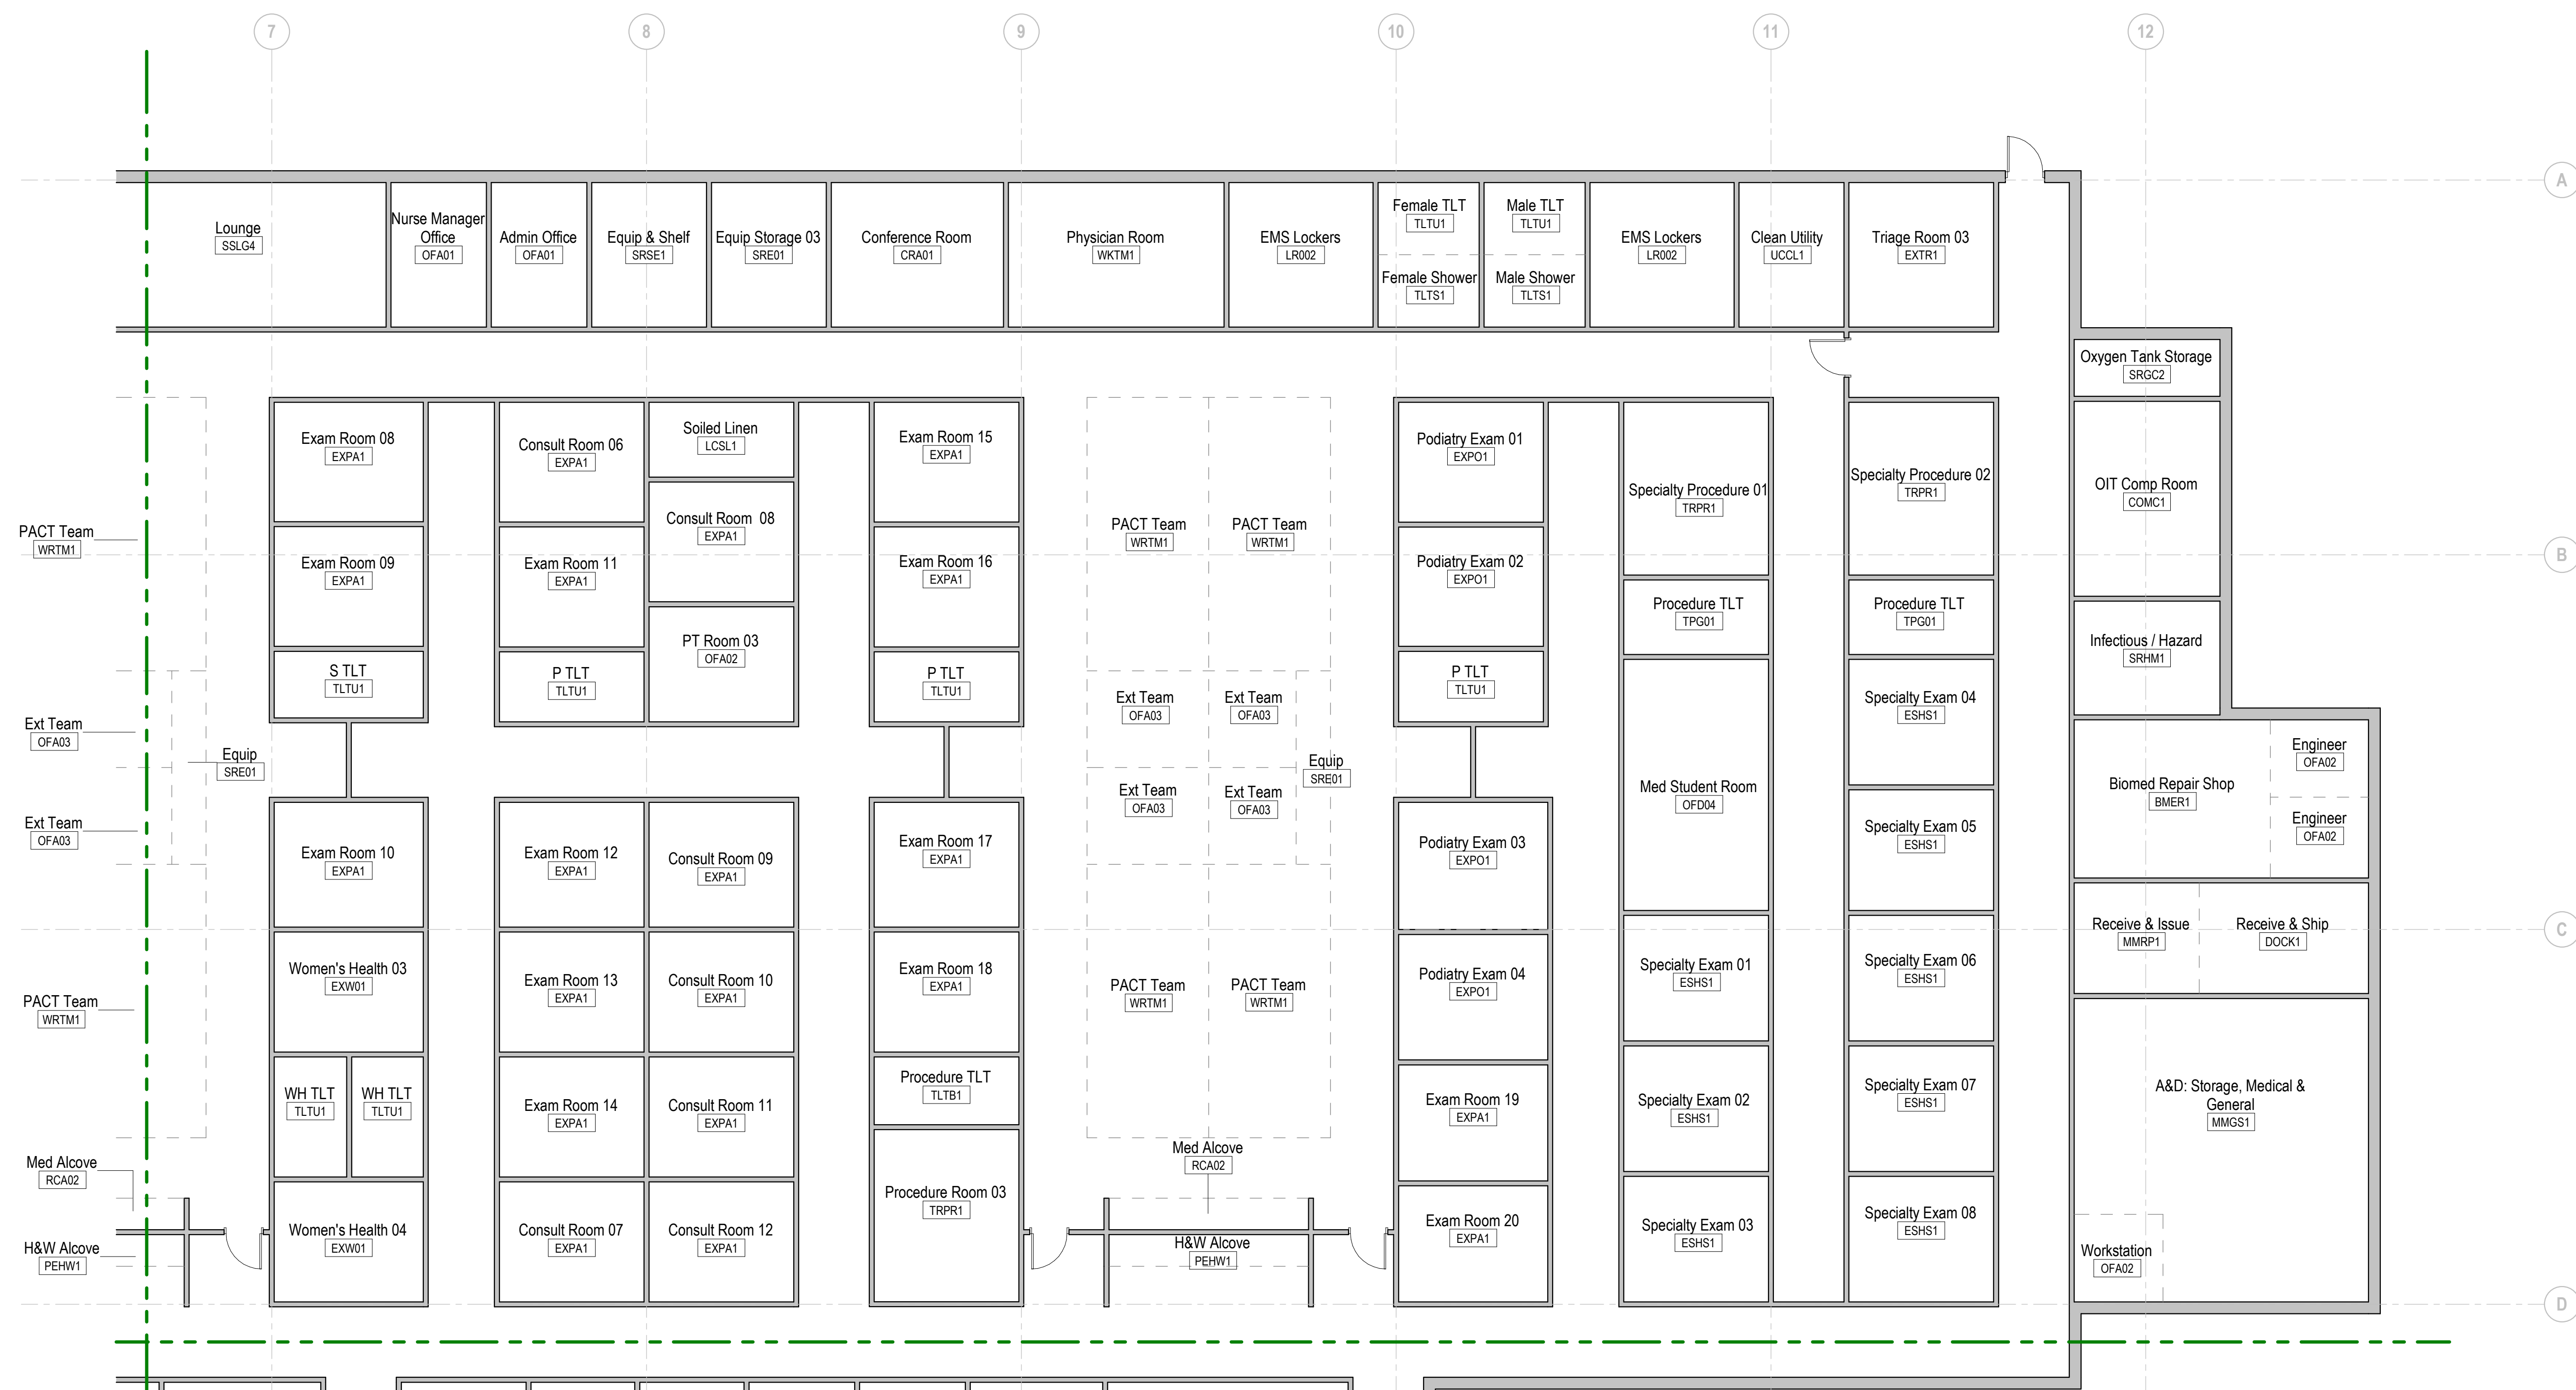

1 ENLARGED FLOOR PLAN - AREA B
SCALE: 1/8" = 1'-0"

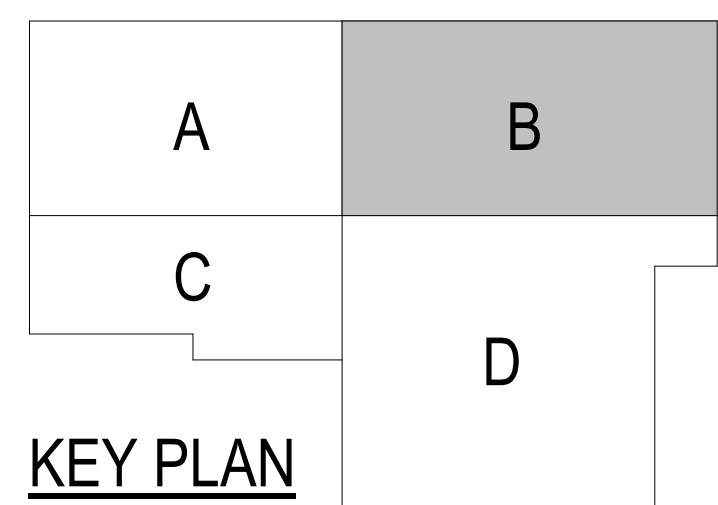

7/26/2018 10:38:16 AM C:\Users\ajf\OneDrive\Documents\AutoCAD\Revit\2018\Projects\CBOC\04-Portland-Submission_3.dwg\sheet.rvt

Revisions:	Date:

CONSULTANT
LEO A DALY
730 2nd Ave. South #1100
Minneapolis, MN 55402
(612) 338-8741

ARCHITECT/ENGINEER OF RECORD
F F E Inc
Engineering and Technical Services
420 Springfield Pike
Wyoming, OH 45215
513-522-0956

STAMP


Engineering and Facilities Management Services
VA U.S. Department of Veterans Affairs

Drawing Title
ENLARGED PLAN - AREA B
Approved:


Phase
FINAL SUBMISSION
TBD SPRINKLERED

Project Title
PORTLAND, ME CBOC
Location
PORTLAND, ME
Issue Date
07/03/2018
Checked
KDC
Drawn
AFG

Project Number
36C10F18N3251
Building Number
C.B.O.C
Drawing Number
A-104

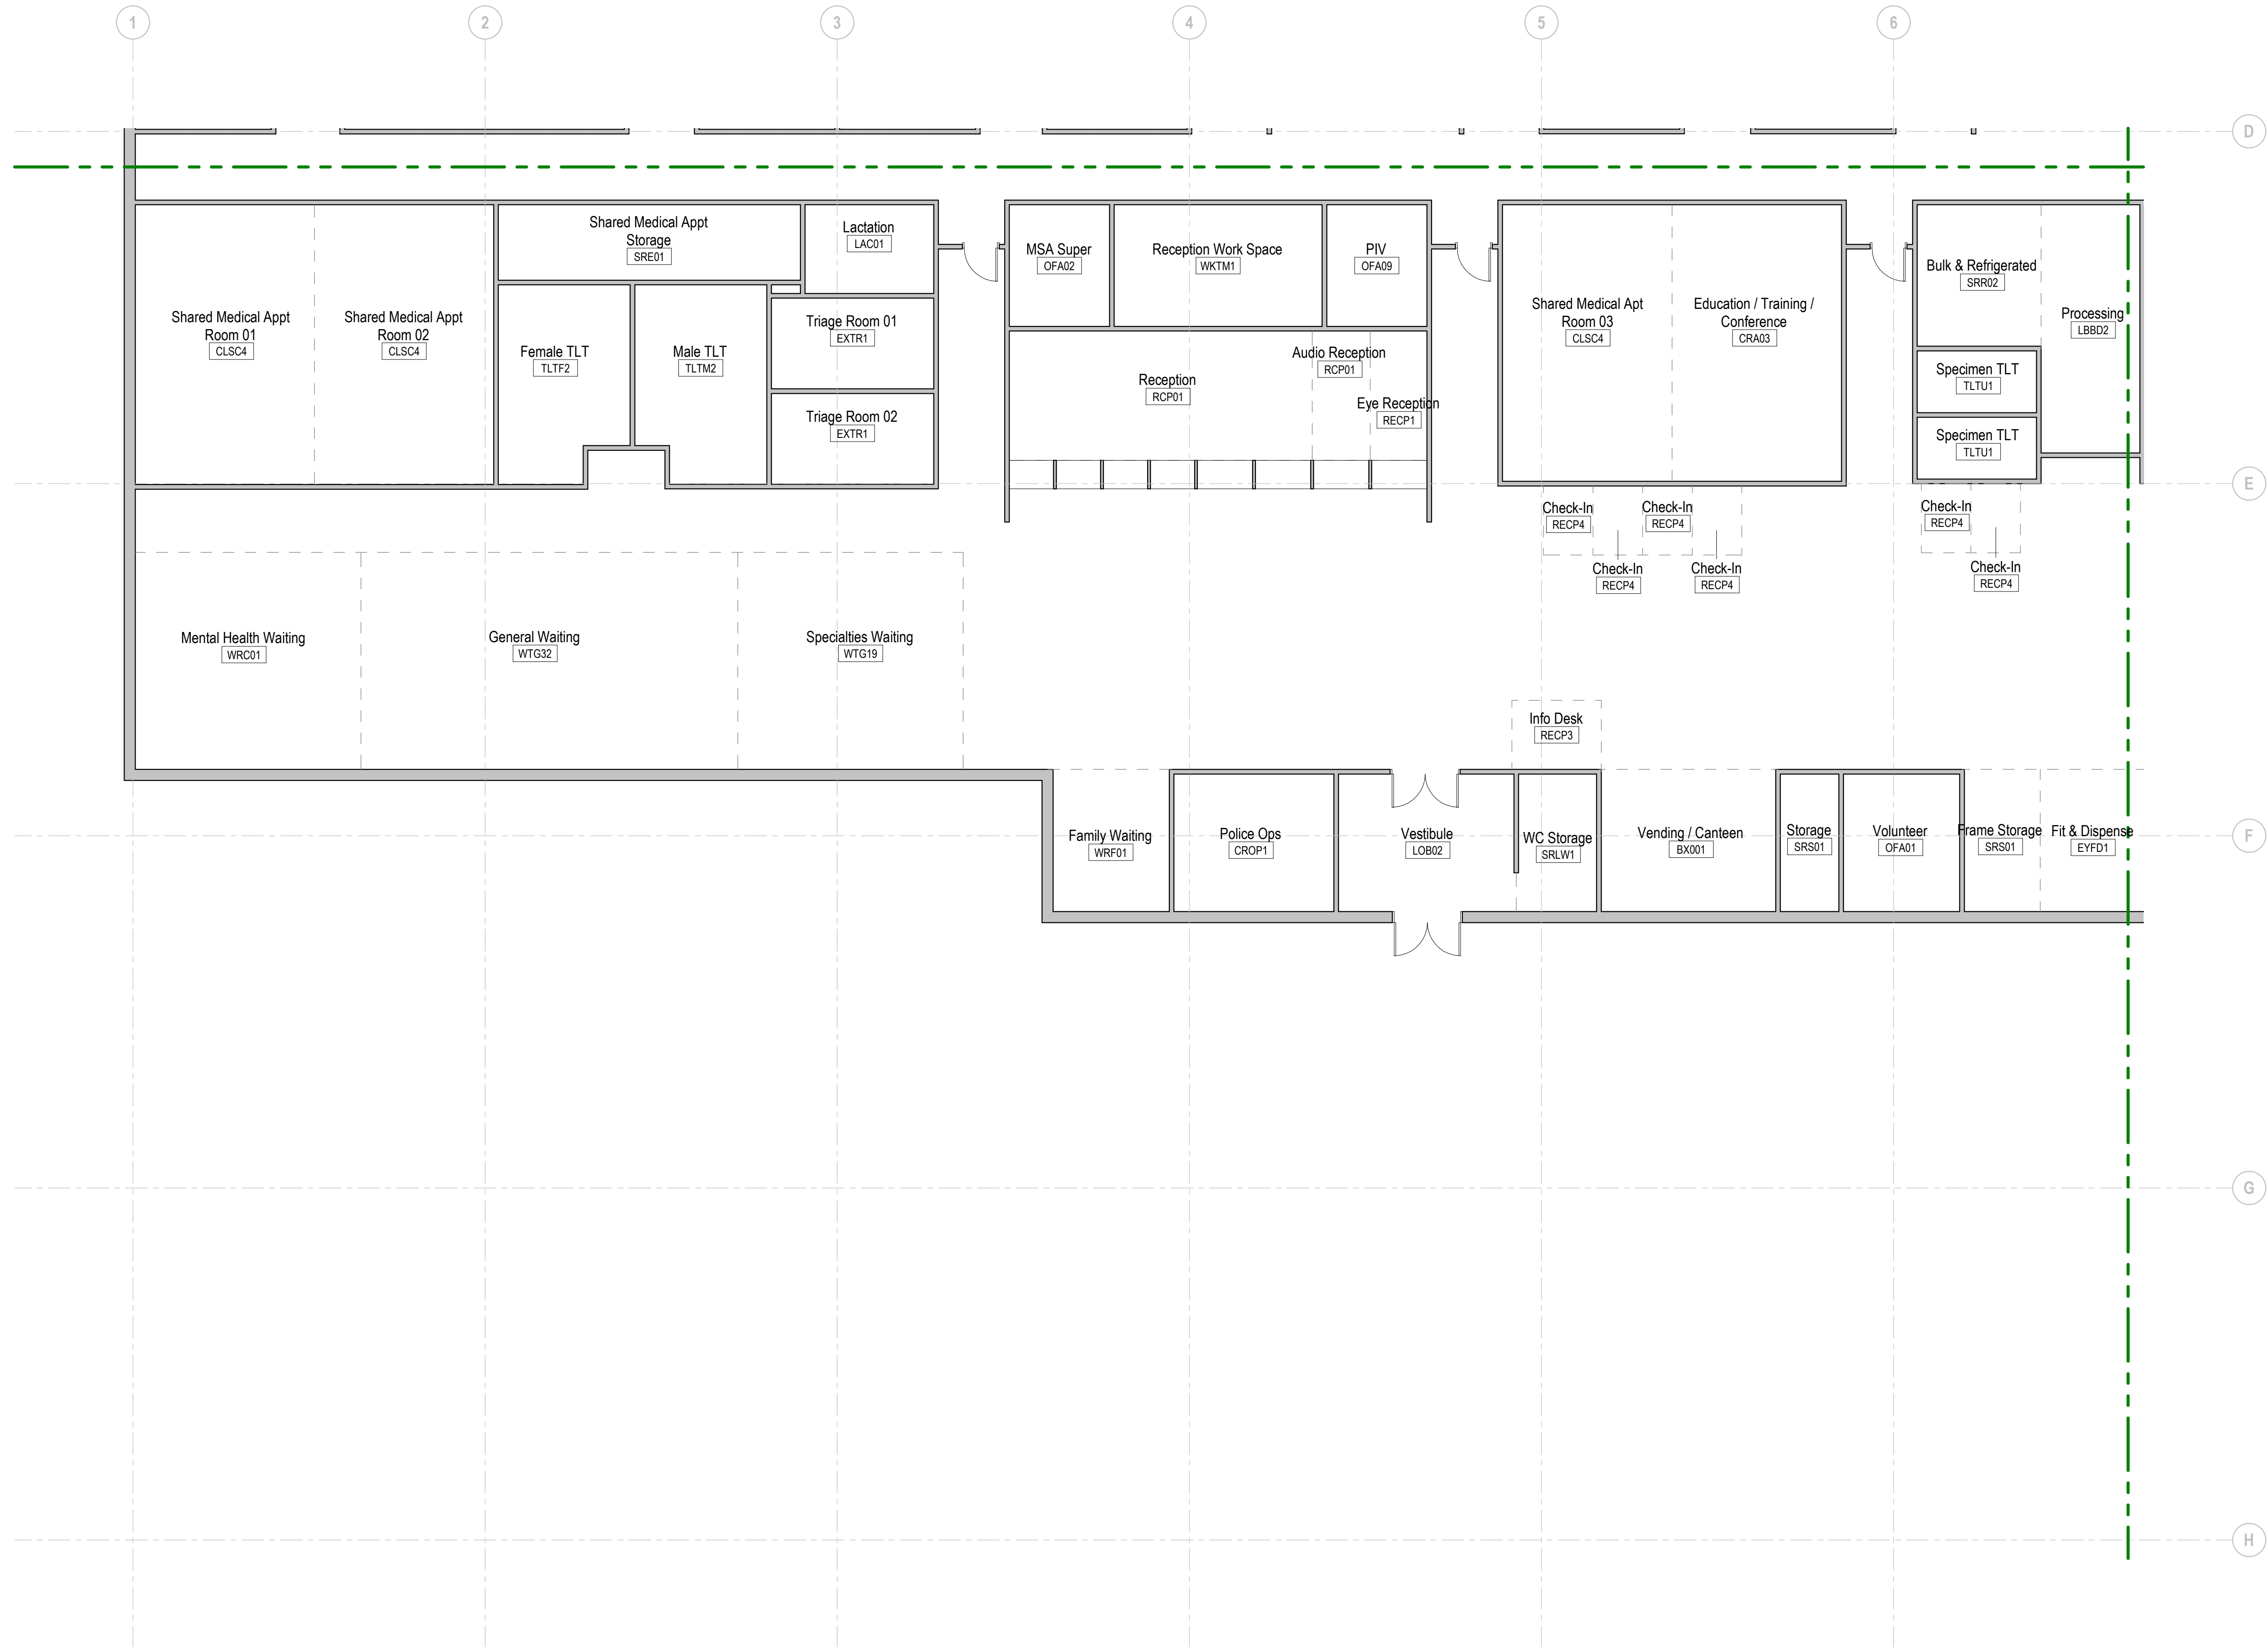

1 ENLARGED FLOOR PLAN - AREA C
SCALE: 1/8" = 1'-0"

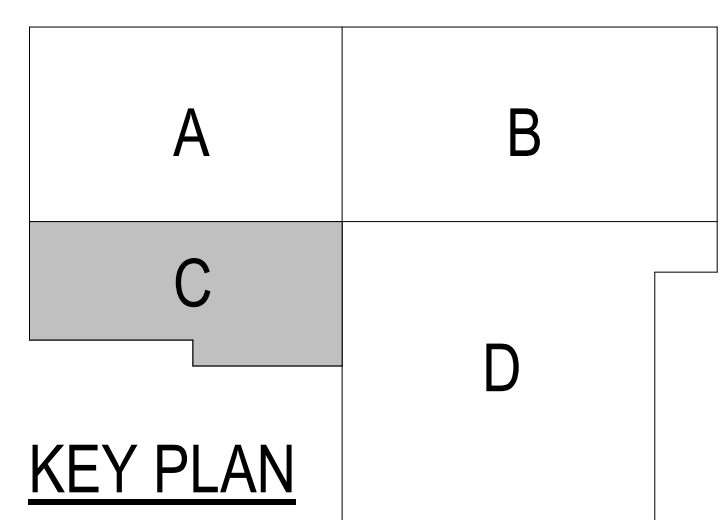

Revisions:	Date:

CONSULTANT

LEO A DALY
730 2nd Ave. South #1100
Minneapolis, MN 55402
(612) 338-8741

ARCHITECT/ENGINEER OF RECORD

FF E Inc
Engineering and Technical Services
420 Springfield Pike
Wyoming OH 45215
513-522-0956

STAMP

Engineering and Facilities Management Services

Drawing Title
ENLARGED PLAN - AREA C

Approved:

Phase
FINAL SUBMISSION

TBD SPRINKLERED

Project Title
PORTLAND, ME CBOC

Location
PORTLAND, ME

Issue Date
07/03/2018


Checked
KDC

Drawn
AFG


Project Number
36C10F18N3251

Building Number
C.B.O.C

Drawing Number
A-105

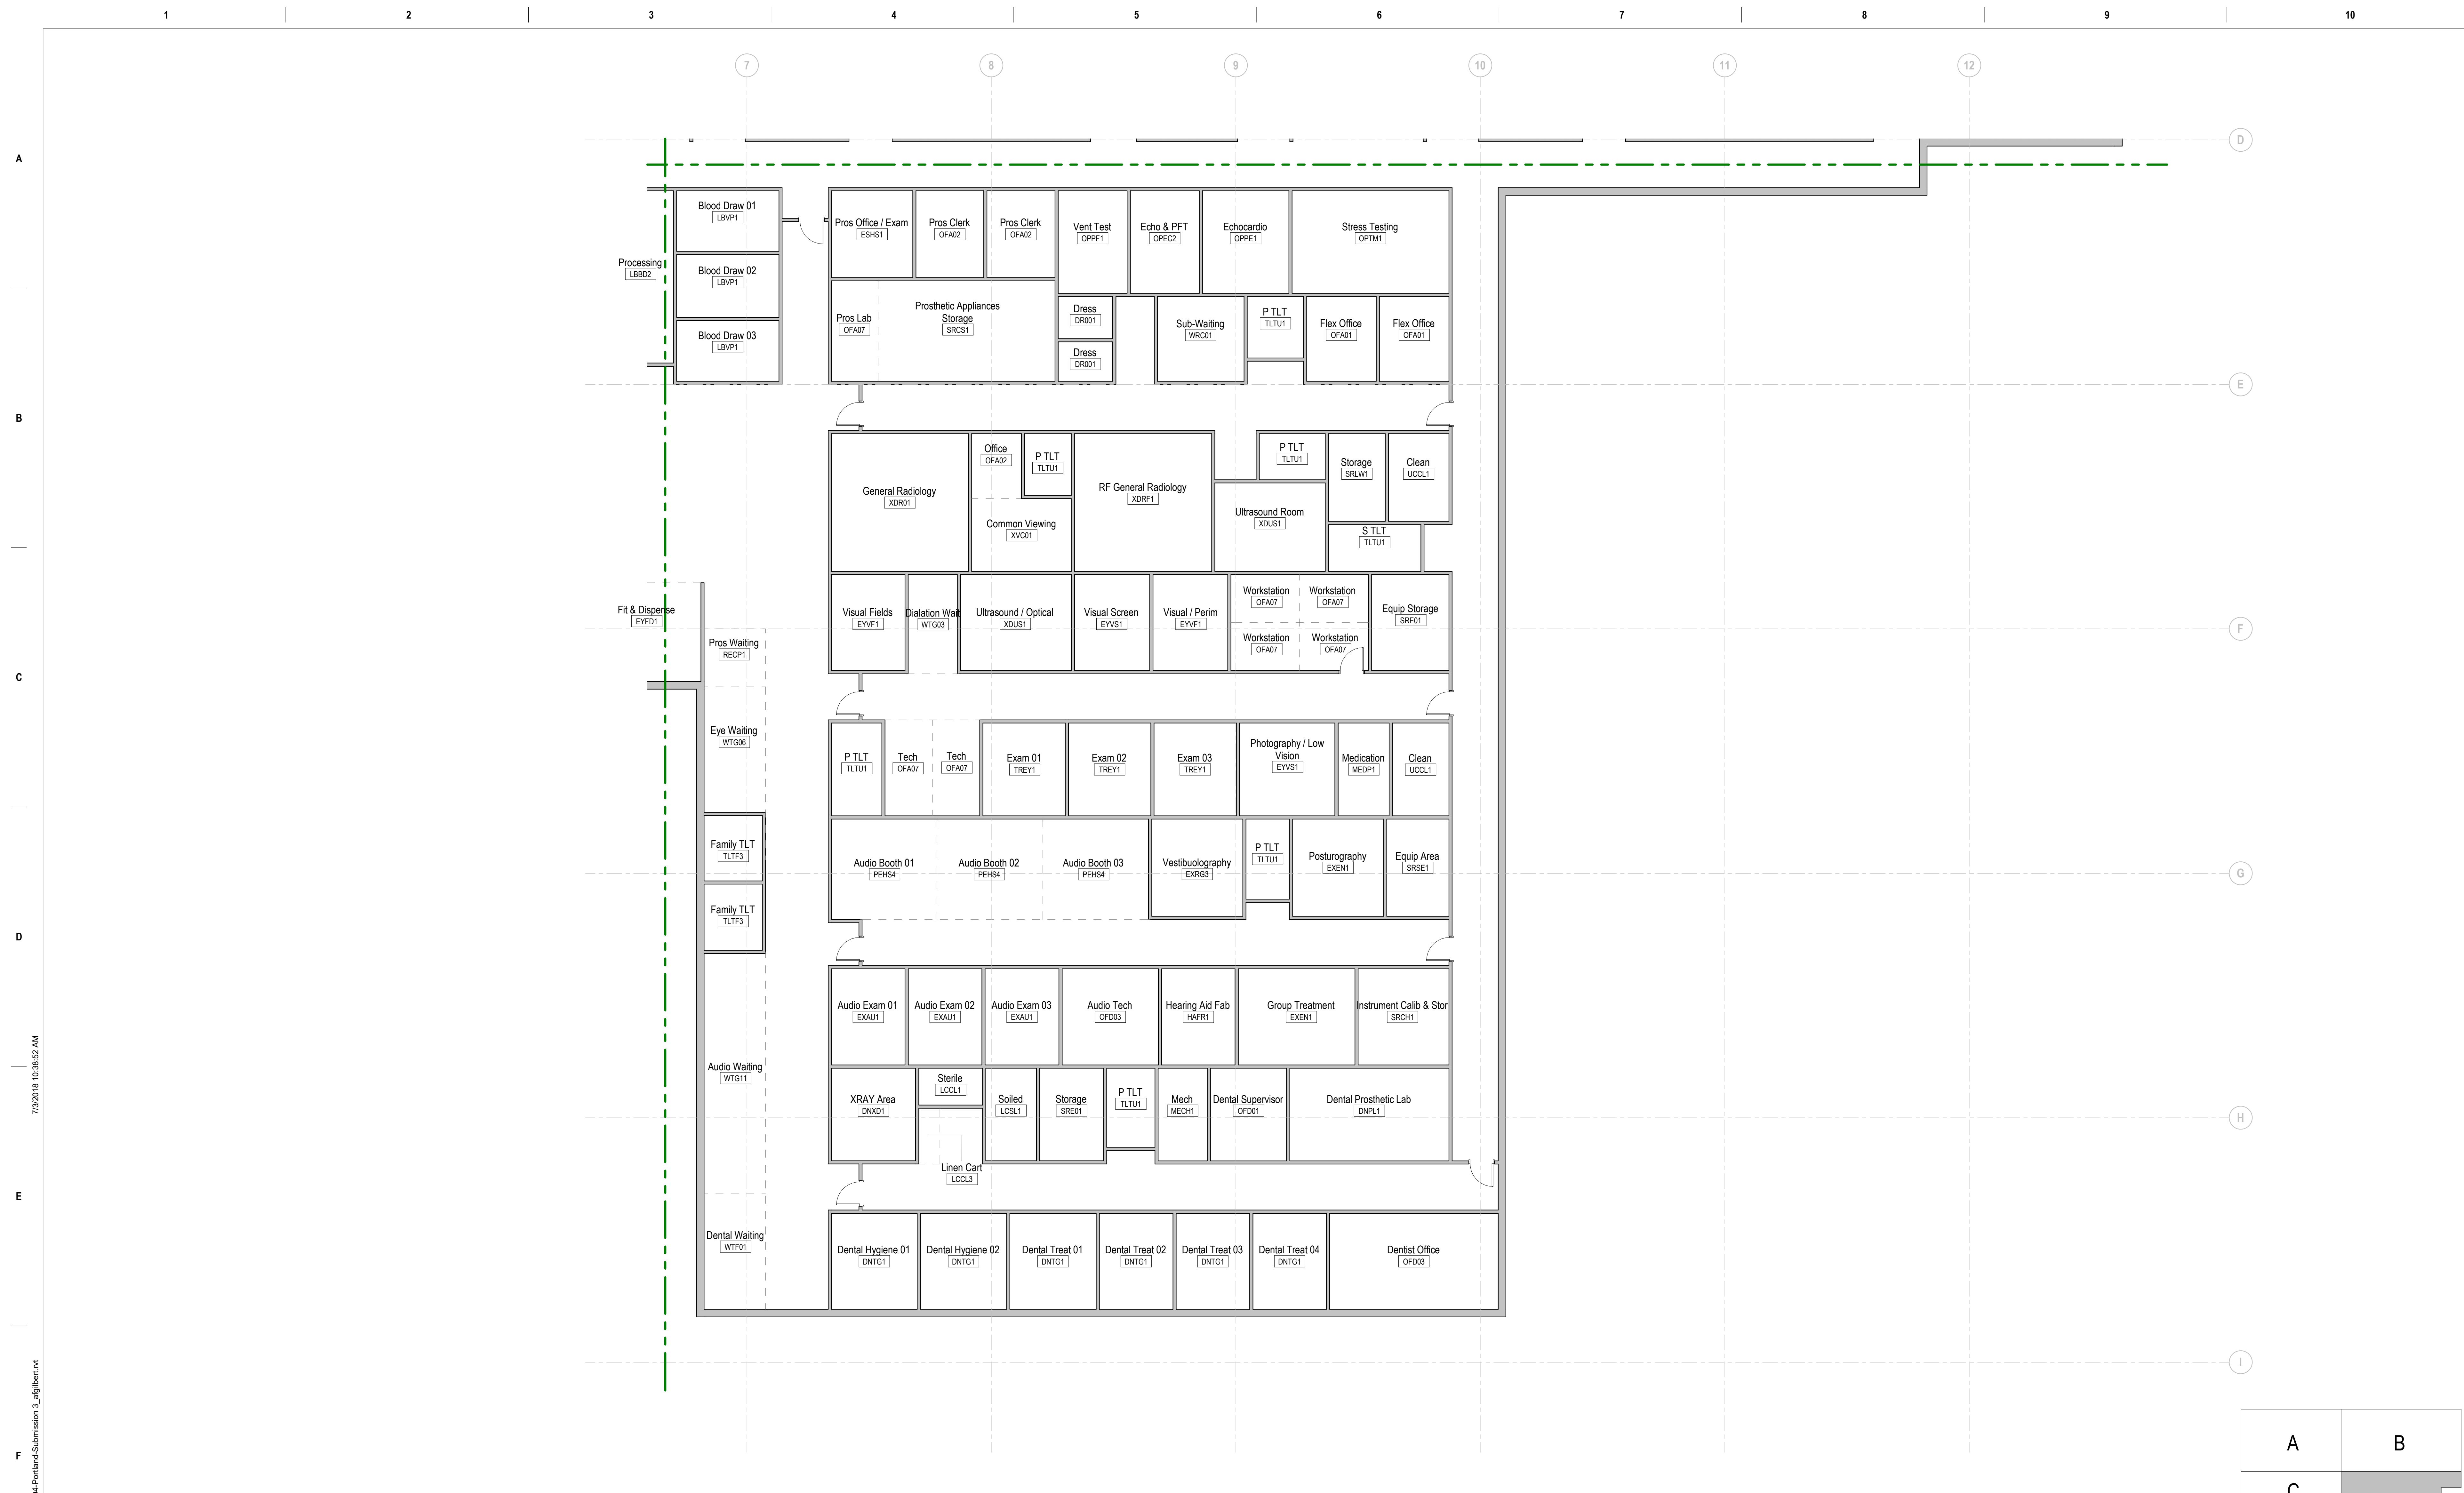

1 ENLARGED FLOOR PLAN - AREA D
SCALE: 1/8" = 1'-0"

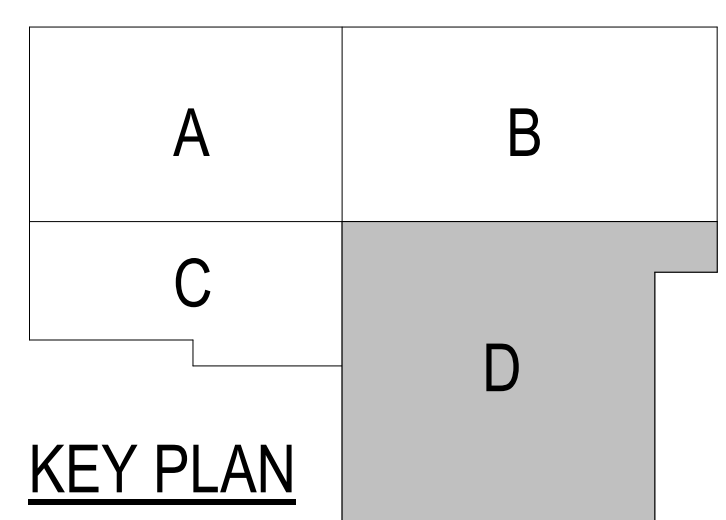

7/26/2018 10:38:52 AM
C:\Users\jgibbert\Documents\AutoCAD\Revit\2018\Projects\CBOC-304-Portland-Submission_3_alj\sheet.rvt

Revisions:	Date:

CONSULTANT
LEO A DALY
730 2nd Ave. South #1100
Minneapolis, MN 55402
(612) 338-8741

ARCHITECT/ENGINEER OF RECORD
F F E Inc
Engineering and Technical Services
420 Springfield Pike
Wyoming, OH 45215
513-522-0956

STAMP

Engineering and Facilities Management Services
VA U.S. Department of Veterans Affairs

Drawing Title
ENLARGED PLAN - AREA D
Approved:

Phase
FINAL SUBMISSION
TBD SPRINKLERED

Project Title
PORTLAND, ME CBOC
Location
PORTLAND, ME
Issue Date
07/03/2018
Checked
KDC
Drawn
AFG

Project Number
36C10F18N3251
Building Number
C.B.O.C
Drawing Number
A-106