


three inches = one foot
one and one half inches = one foot
one inch = one foot
three quarters inch = one foot
one half inch = one foot
three eighths inch = one foot
one quarter inch = one foot
one eighth inch = one foot

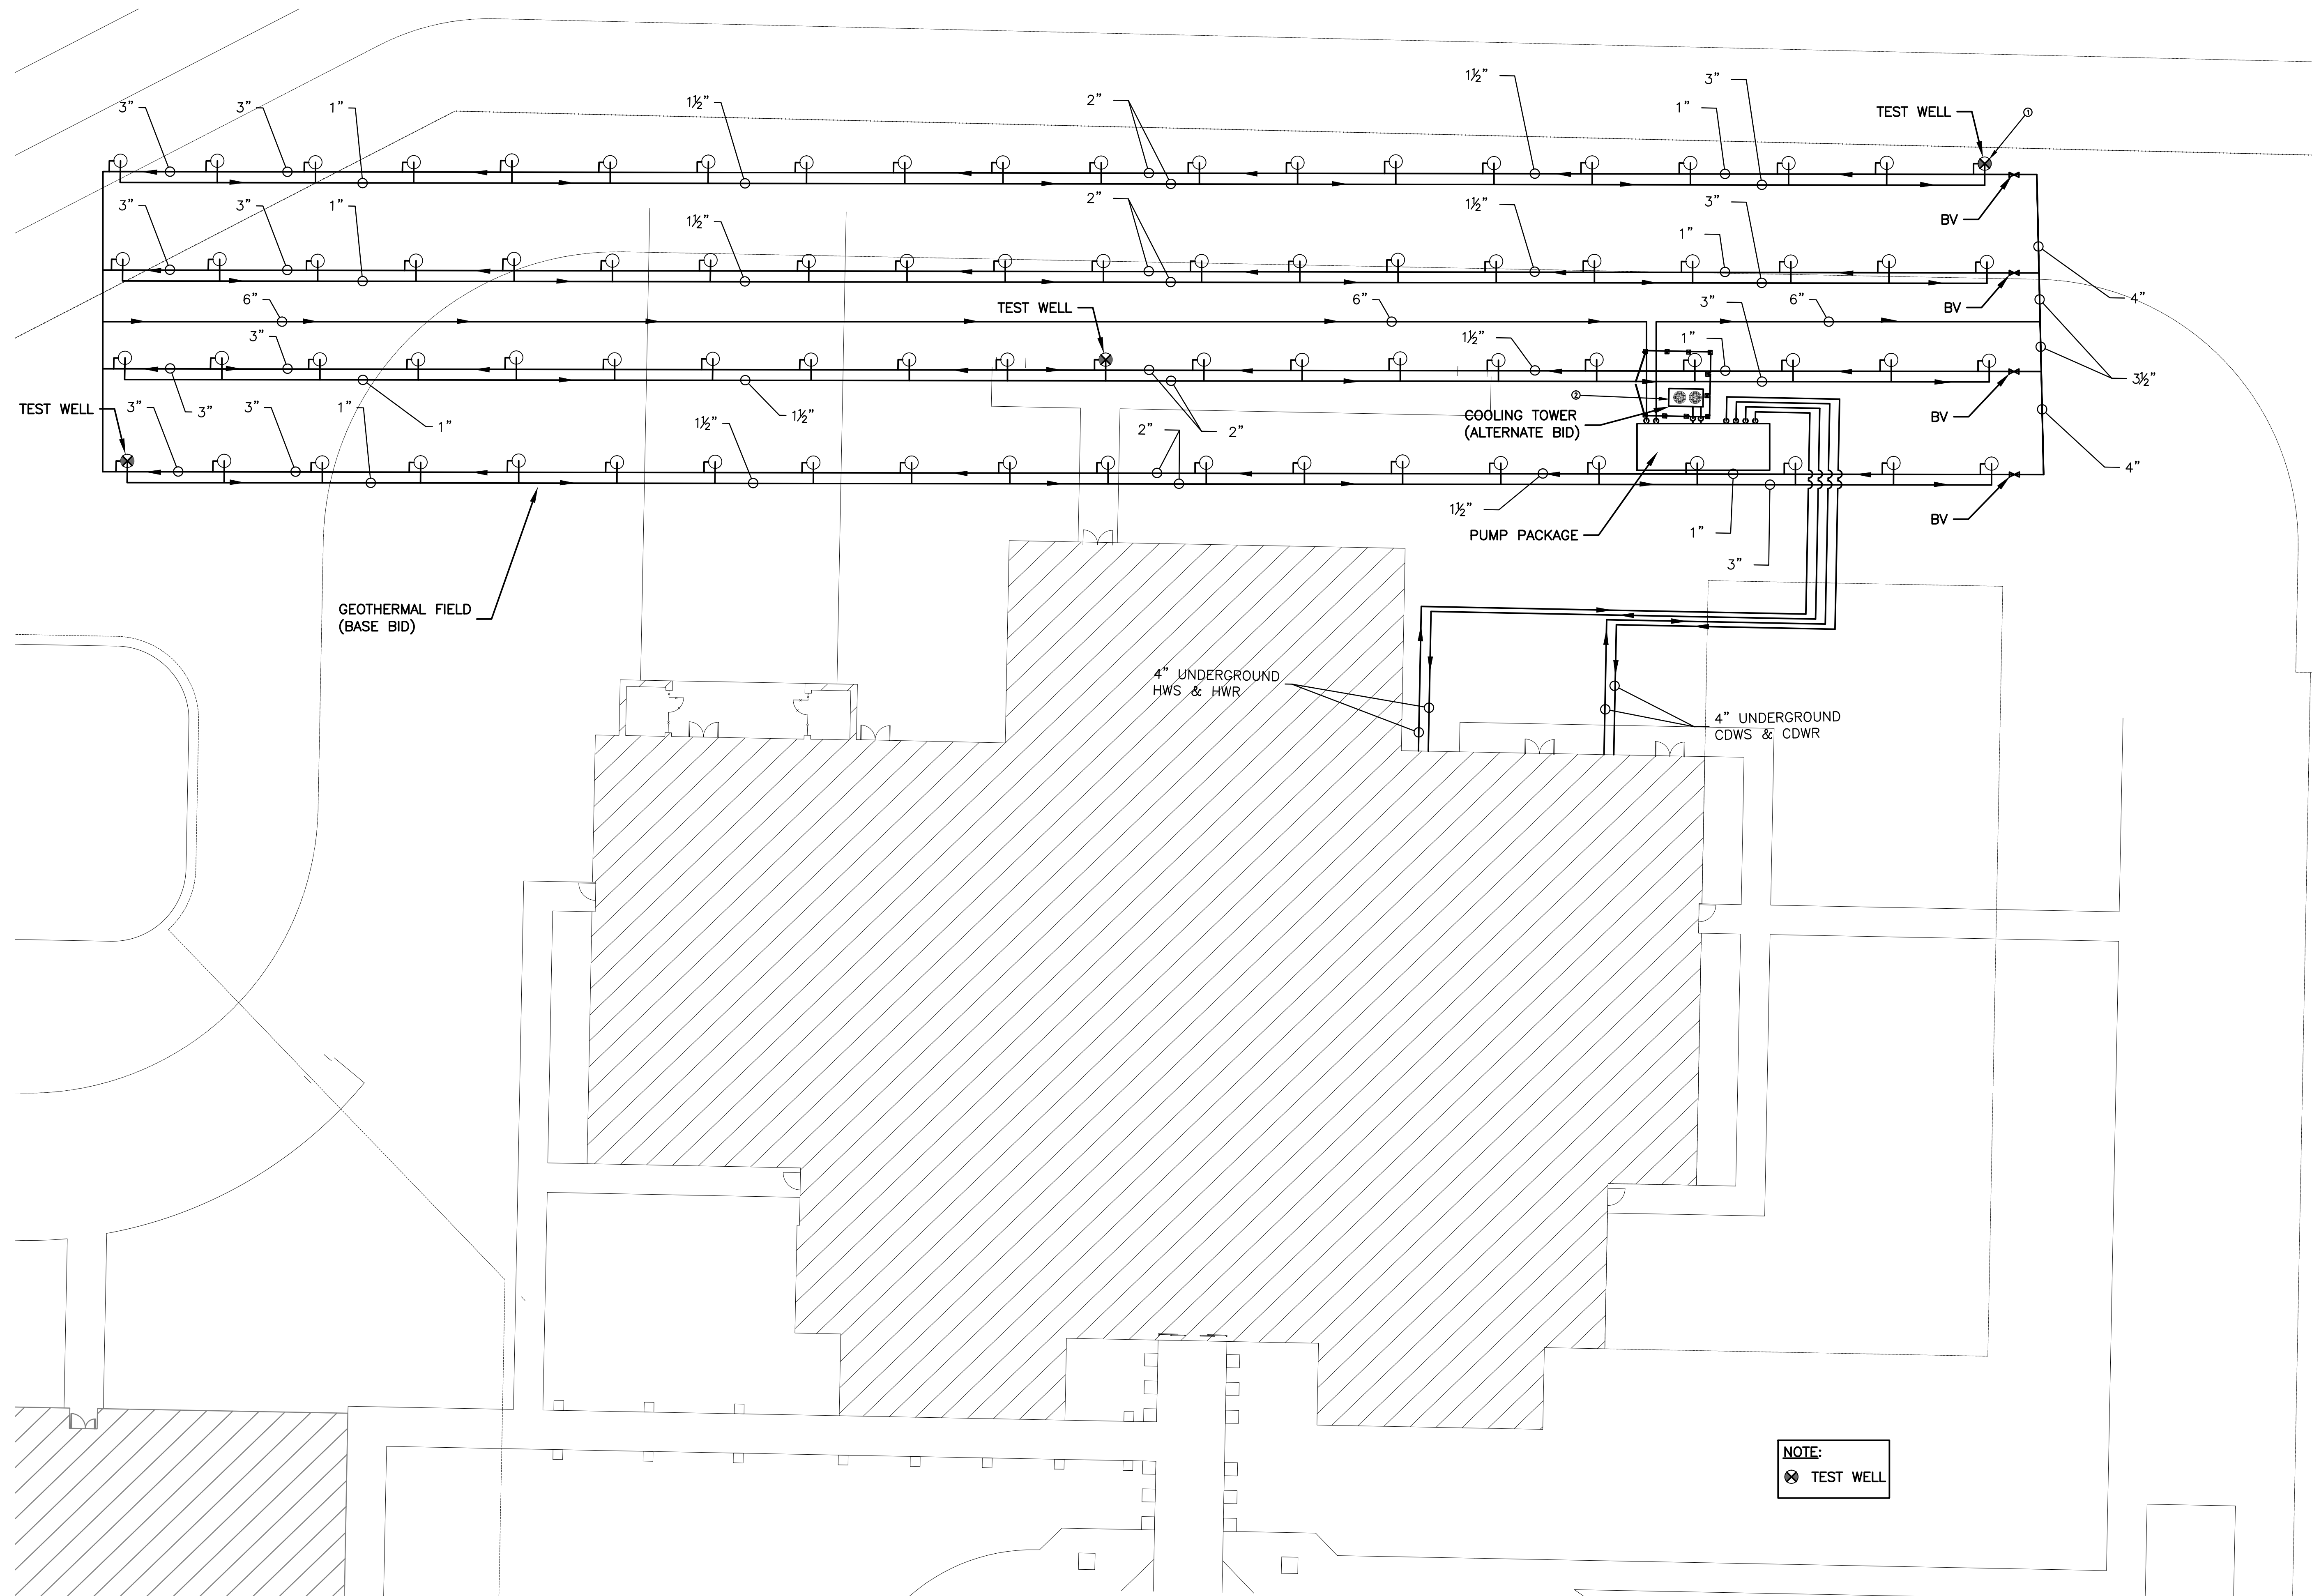


NEW WORK NOTE SCHEDULE	
①	WELLS SHALL BE 300 FEET DEEP
②	PROVIDE 1" MAKE UP WATER LINE AND 2" DRAIN TO SEWER FOR COOLING TOWER. REFER TO PLUMBING AND CIVIL FOR LOCATION.

HVAC SITE PLAN
SCALE: 1/16" = 1'-0"

NOTE:
⊗ TEST WELL

Revisions	Date

CONSULTANTS:		
CIVIL: KENNETH HORNE & ASSOCIATES 7201 NORTH 9TH AVENUE, STE. 8 PENSACOLA, FLORIDA 32504 PH (850) 471-9005 FX (850) 471-0099	COMMENTS: SCHMIDT CONSULTING GROUP, INC. 40 S. PALMVIEW PLACE, STE. 300 PENSACOLA, FLORIDA 32502 PH (850) 438-0050 FX (850) 432-9531	SURVEYORS: KGI TECHNOLOGIES, INC. 10401 HIGHLAND MANOR DRIVE, SUITE 120 TAMPA, FLORIDA 33610 PH (813) 740-2300 FX (813) 740-2300
LANDSCAPE ARCHITECT: CSA GROUP, INC. 6500 POCADONLY SQUARE DRIVE MOBILE, ALABAMA 36608 PH (251) 344-4023 FX (251) 344-4082	ARCHITECTURE: BILLOCK TICE ASSOCIATES, INC. 909 EAST CERVANTES STREET PENSACOLA, FL. 32501 PH (850) 434-5444 FX (850) 432-6208	

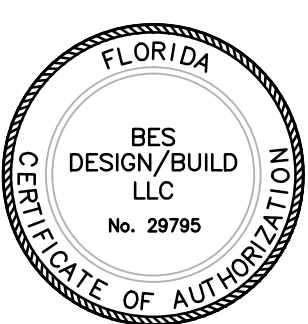

ARCHITECT/ENGINEERS:	
	BES DESIGN/BUILD, LLC 766 Middle St, Fairhope, AL 36532 Phone: 251.990.5778 Fax: 251.990.3716

Drawing Title MECHANICAL SITE PLAN
Approved Project Director

Project Title PANAMA CITY JOINT OUTPATIENT CLINIC VA GULF COAST HEALTH CARE
Location PANAMA CITY, FLORIDA
Date 16 APRIL 2012
Checked RL
Drawn RL

Project Number 520-326
Building Number -
Drawing Number MS001
Dwg. 13 of 13

Office of
Construction
and Facilities
Management

Department of
Veterans Affairs

FINAL SUBMISSION