

CONSULTANTS:


CONV./CONSULTING GROUP, INC.
7201 NORTH 9TH AVENUE, STE. 6
PH. (650) 471-3005
FX. (650) 471-0093

LANDSCAPE ARCHITECT:
6300 PROCEALITY SQUARE DRIVE
PH. (251) 344-4023
FX. (251) 344-4052


SCDM/CONSULTING GROUP, INC.
40 S. PALMWAY PLACE, STE. 300
TAMPA, FL 33609
PH. (850) 438-0502
FX. (850) 432-8631

ARCHITECTURE ASSOCIATES, INC.
909 EAST CRAWFORD STREET
PH. (850) 434-4444
FX. (850) 432-5208

SUPPLEMENTARY:
201 TECHNOLOGIES, INC.
10401 HIGHLAND AVENUE, SUITE 120
PH. (813) 746-2200

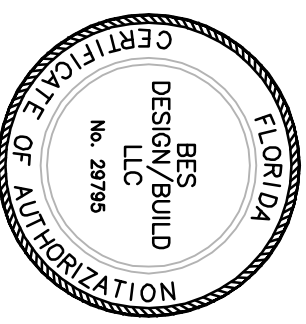

ARCHITECT/ENGINEERS:

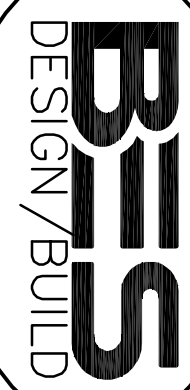


BES DESIGN/BUILD, LLC
766 Middle St., Fairhope, AL 36532
Phone: 251.990.5778 Fax: 251.990.3716

1 PLUMBING RISER DIAGRAM HOT/COLD WATER

- NOTES:
1. RISER DIAGRAM IS INTENDED AS A SCHEMATIC AND MAY NOT REPRESENT THE ACTUAL PHYSICAL LOCATION OR CORRECT GRAPHIC REPRESENTATION OF FIXTURES TO BE INSTALLED. PLEASE REFER TO THE PLUMBING PLANS AND SCHEDULE FOR MORE INFORMATION.
 2. PLUMBING ISOLATION ZONE VALVE LOCATIONS SHALL BE REPRESENTED BY BLUE DOT LABELS ON THE CEILING.
 3. ALL COLD, HOT AND RECIRC. PIPING TO BE INSTALLED ABOVE THE CEILING.

FINAL SUBMISSION

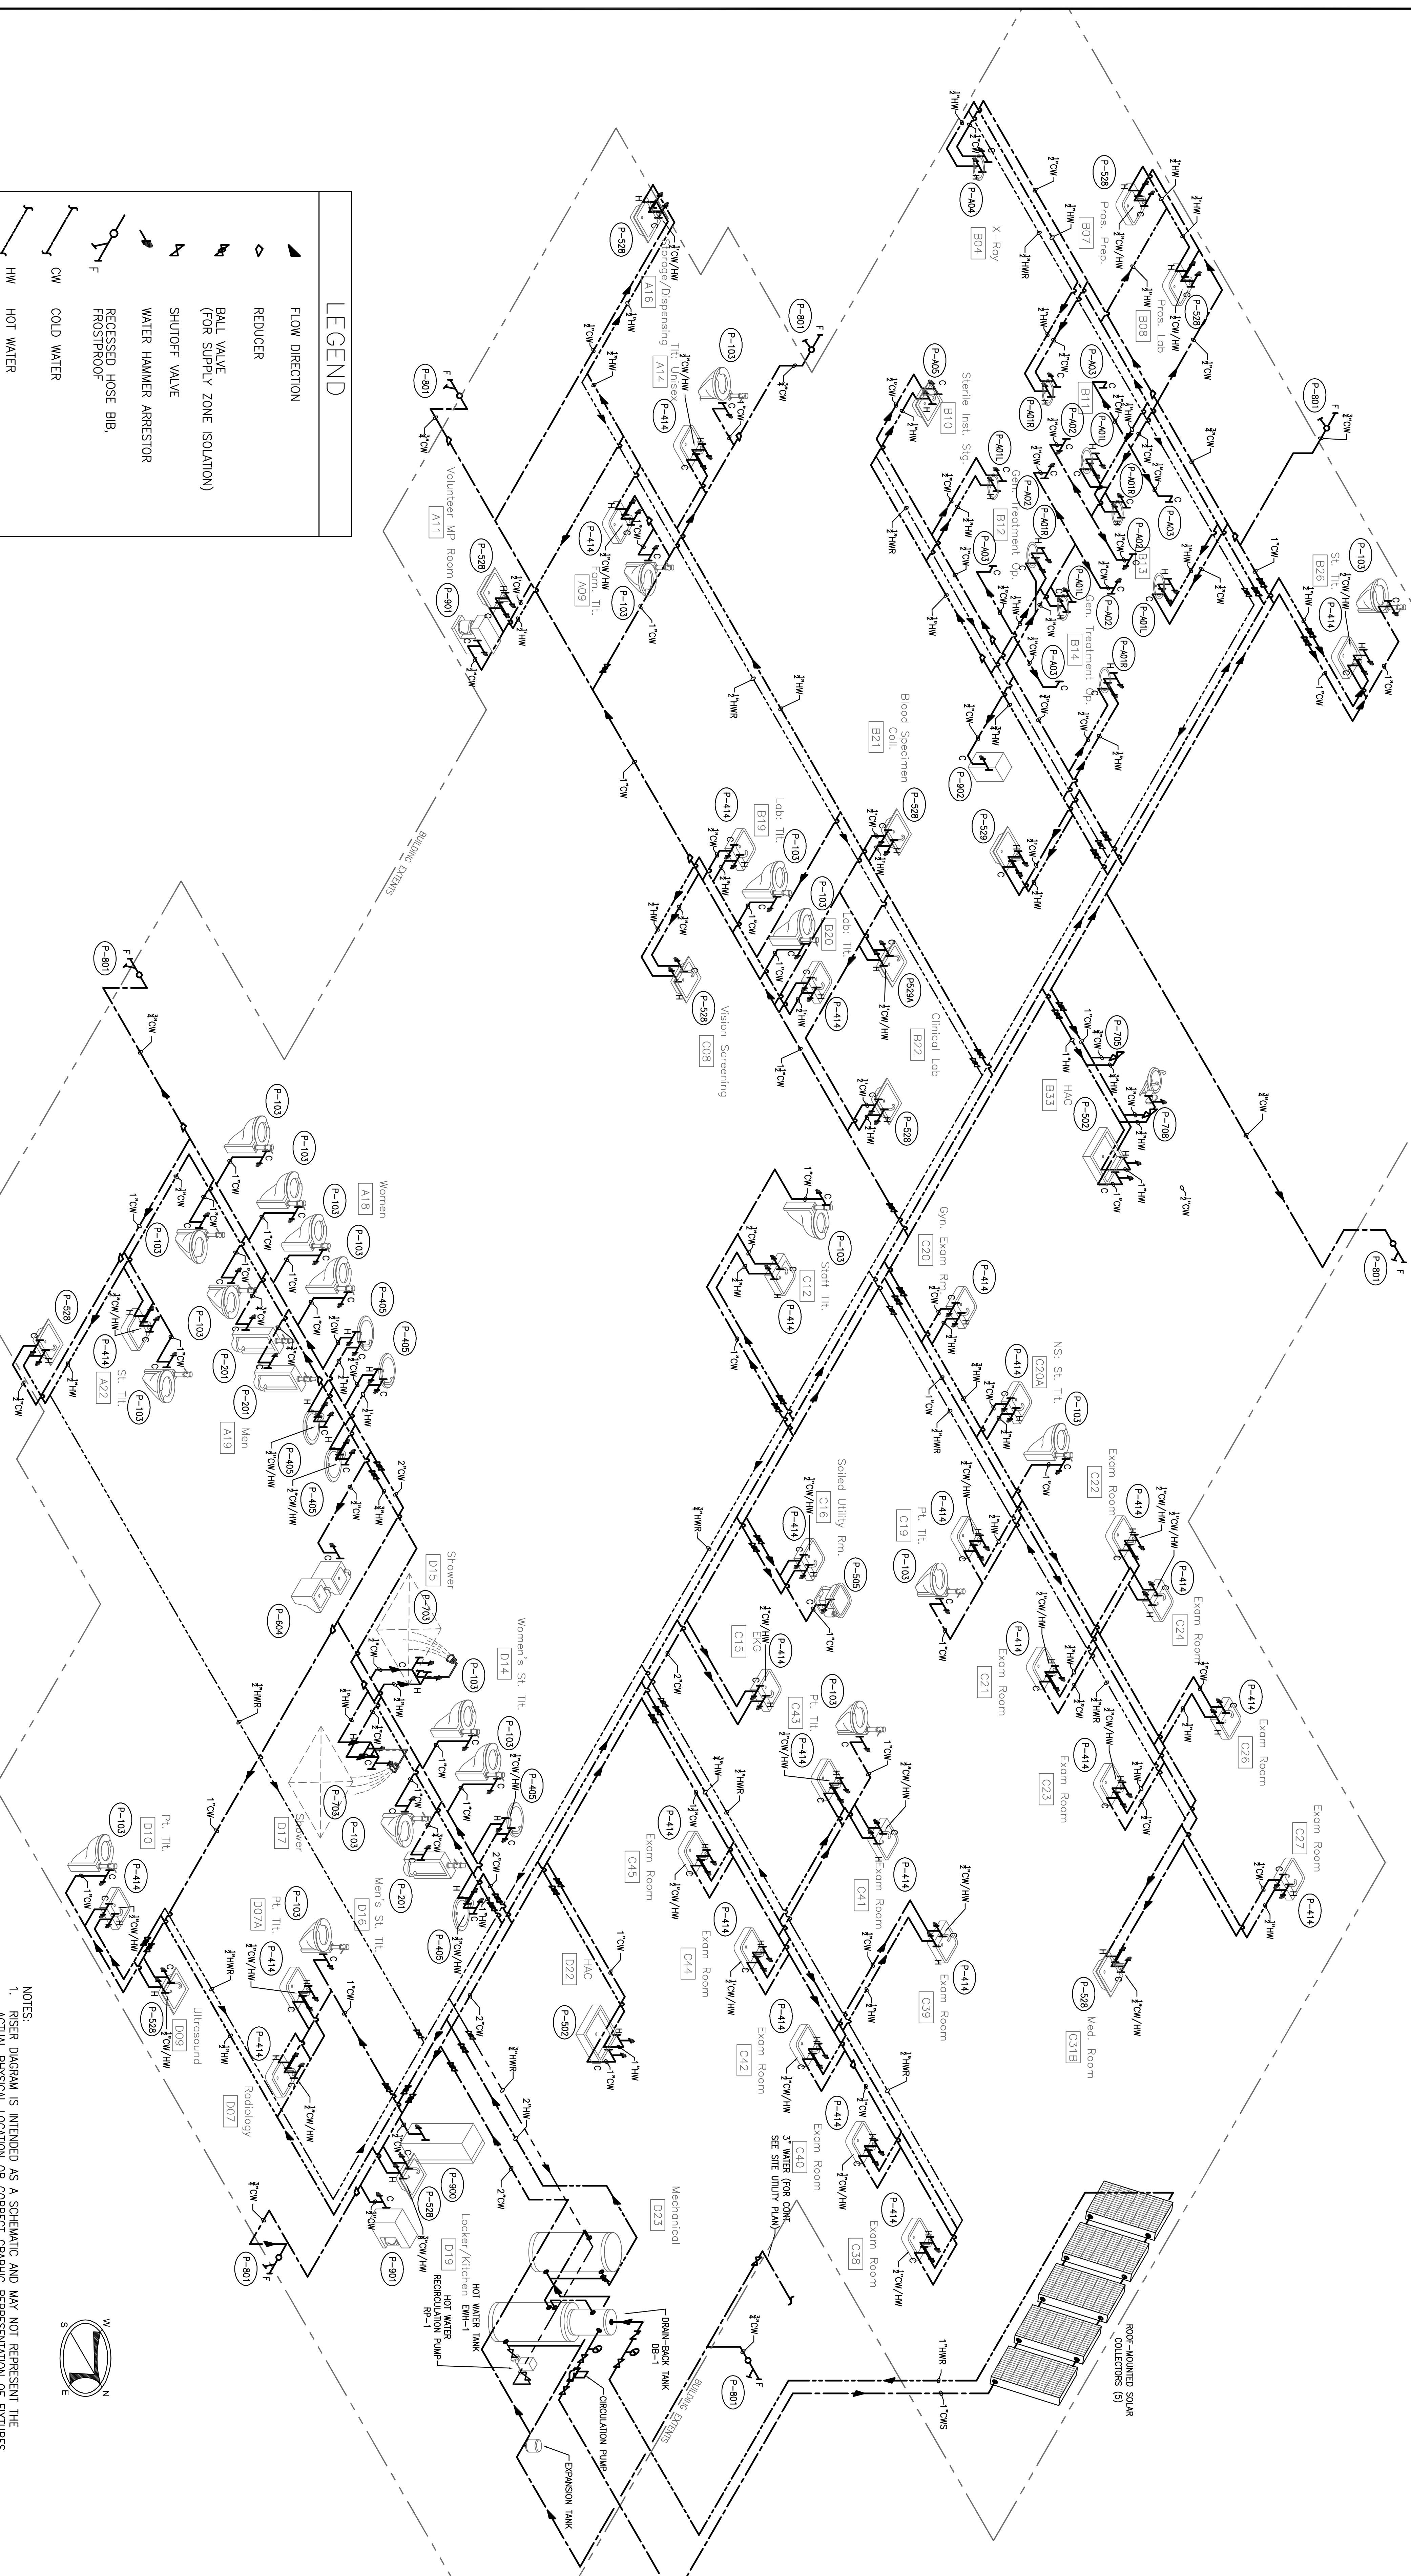

Project Title		Project Title	
PLUMBING RISER DIAGRAM COLD AND HOT WATER		PANAMA CITY JOINT OUTPATIENT CLINIC VA GULF COAST HEALTH CARE	
Approved Project Director		Checked	
Location		Drawing Number	
PANAMA CITY, FLORIDA		PL503	
Date		Dwg 14 of 16	
MARCH 202		Office of Construction and Facilities Management	
WMB		Department of Veterans Affairs	
ALL			