

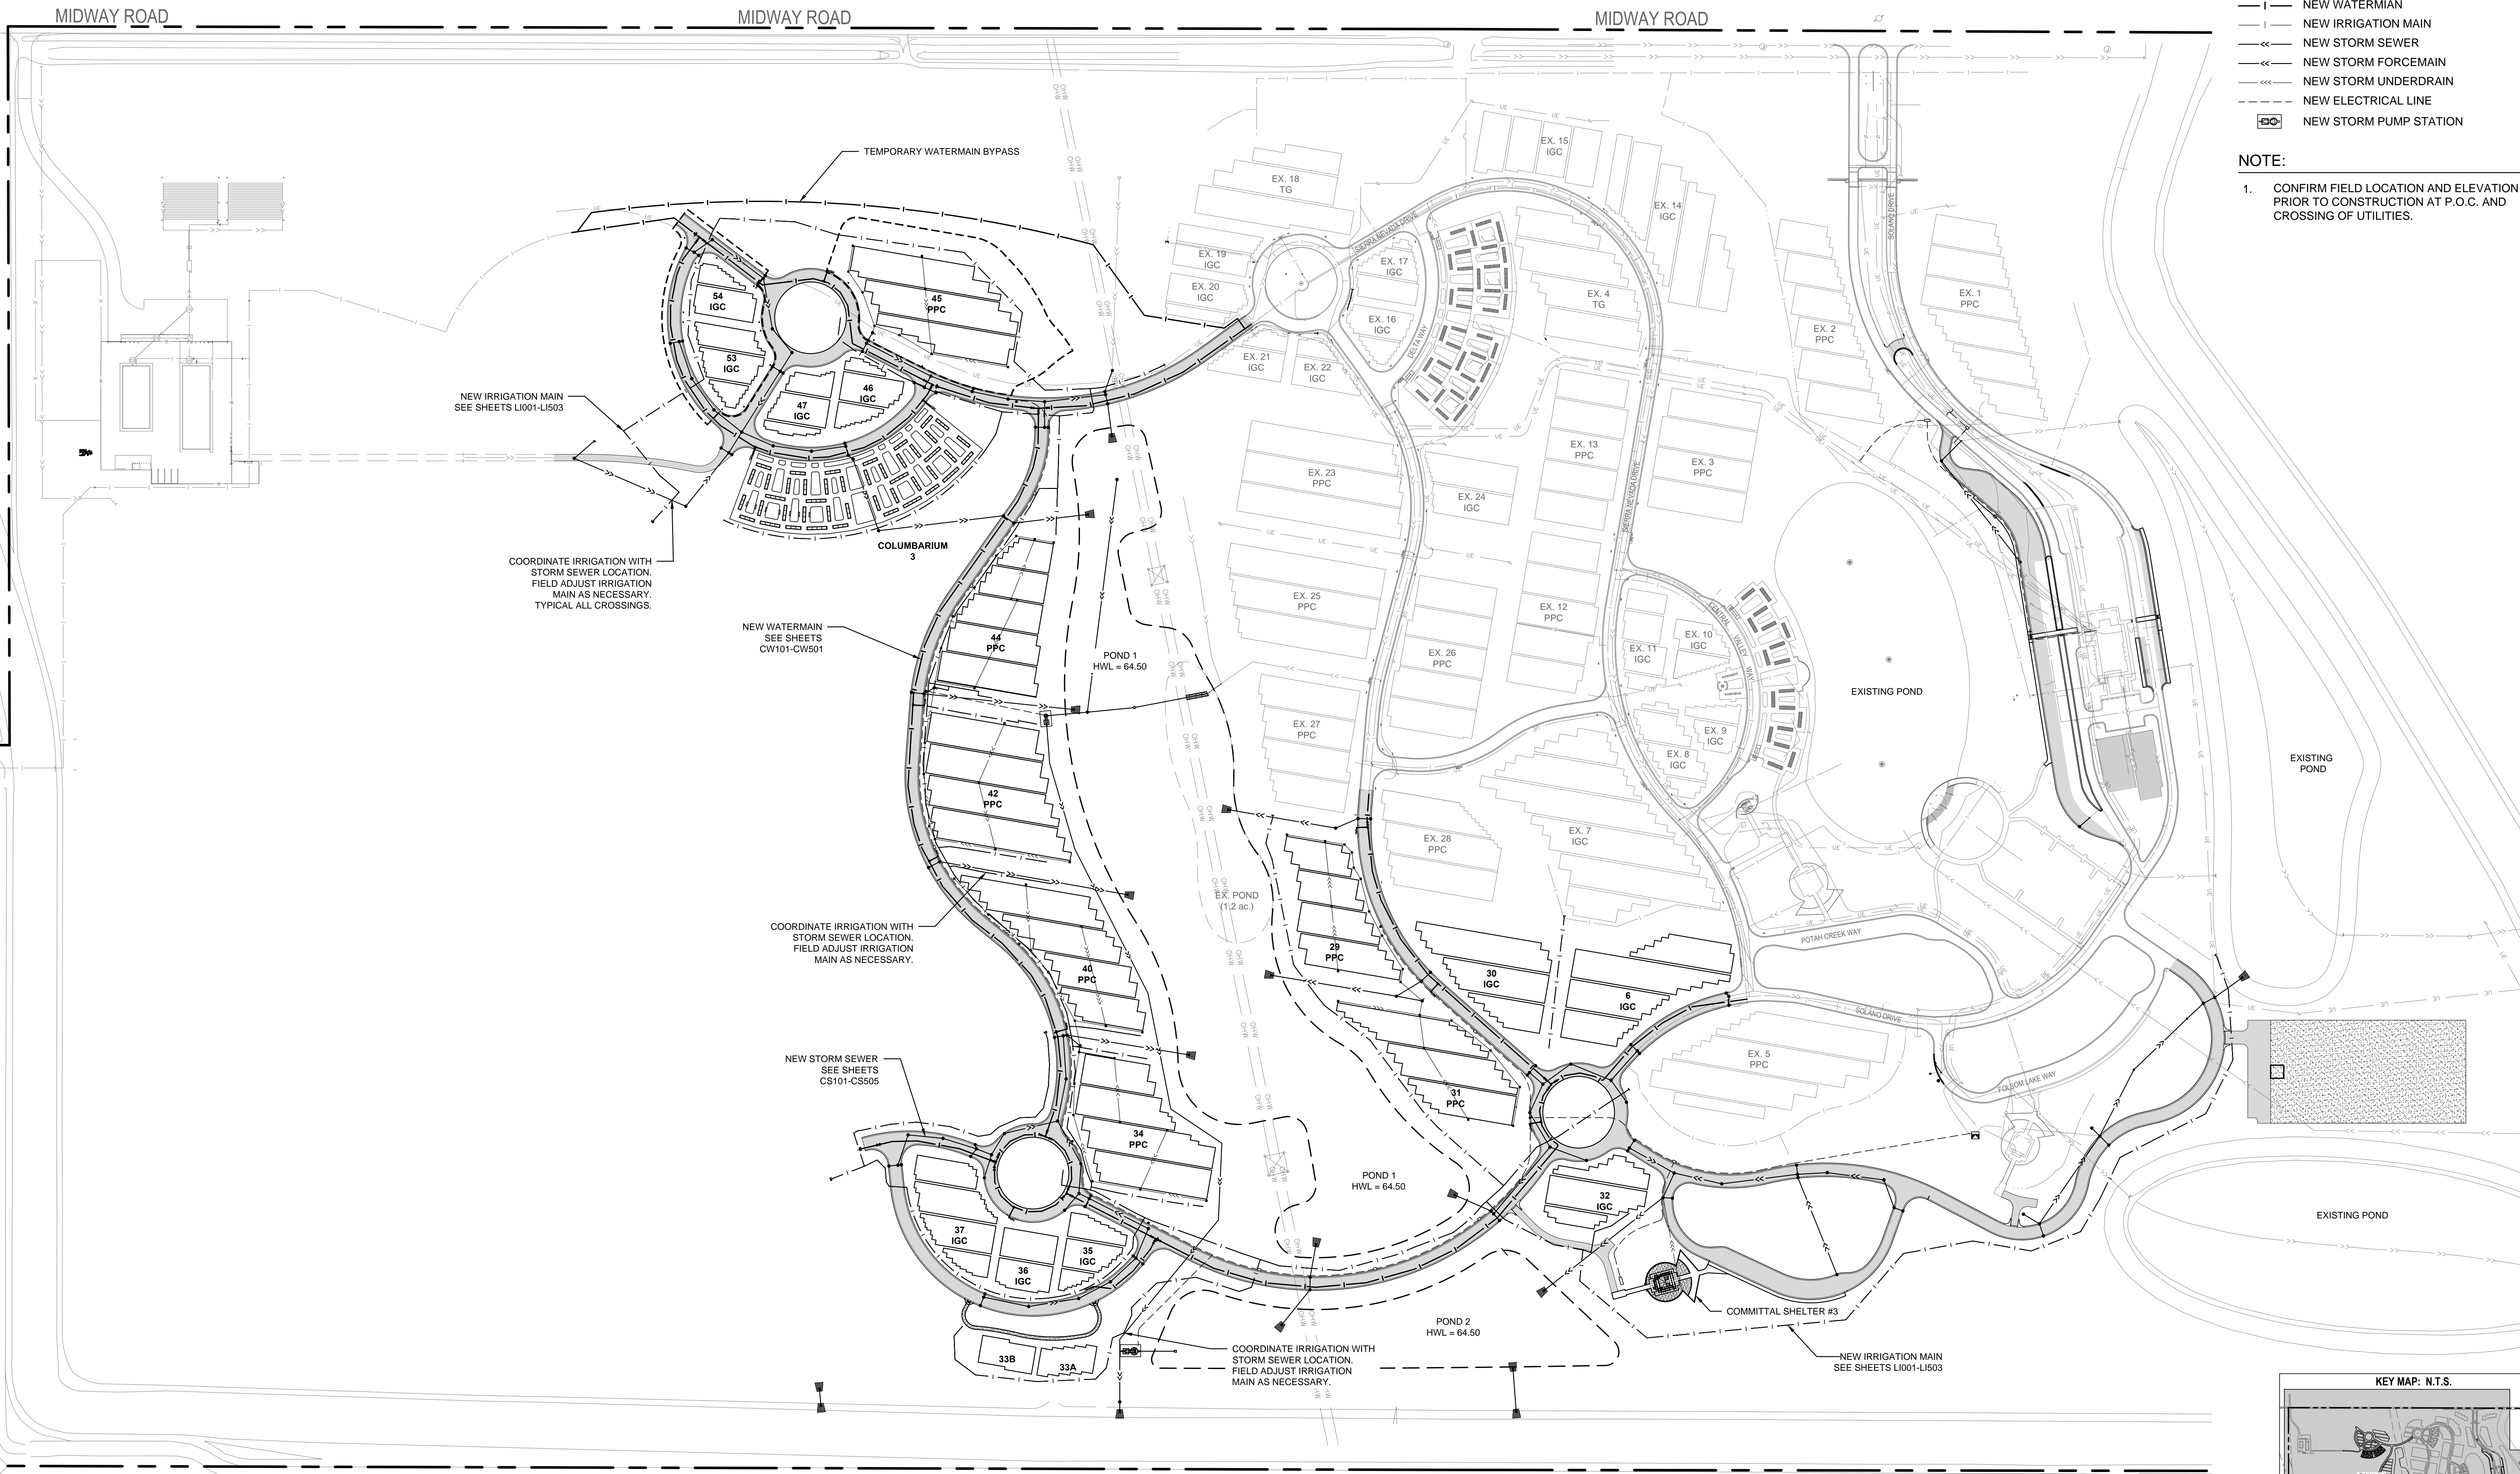


- LEGEND
- NEW WATERMAIN
  - NEW IRRIGATION MAIN
  - NEW STORM SEWER
  - NEW STORM FORCEMAIN
  - NEW STORM UNDERDRAIN
  - NEW ELECTRICAL LINE
  - NEW STORM PUMP STATION

- NOTE:
- CONFIRM FIELD LOCATION AND ELEVATION PRIOR TO CONSTRUCTION AT P.O.C. AND CROSSING OF UTILITIES.

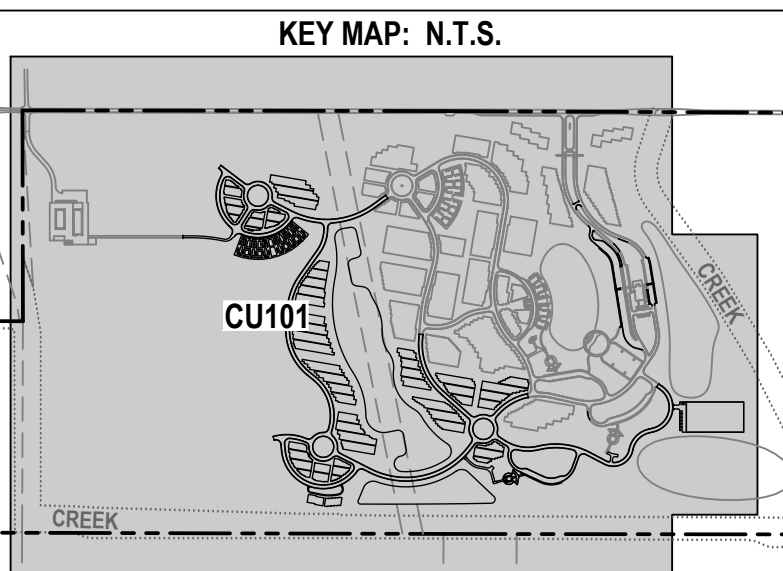

1 UTILITY PLAN - OVERALL  
SCALE: 1" = 120' (30" x 42" PAPER SIZE)

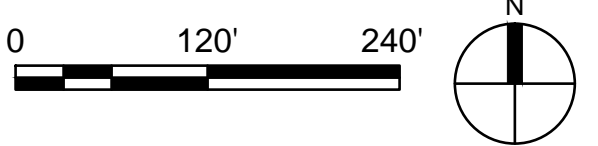

		<div>CONSULTANTS</div> <div><div>Structural Engineering, Electrical Engineering: HDR Engineering, Inc. 2365 Iron Point Rd. #300 Folsom, CA 95630 (916)-817-4924 Duane Hodgins</div><div>Irrigation: Aqua Engineering, Inc. 375 Horseshoe Rd. Bldg. 2-202 Fort Collins, CO 80525 (970)-372-6104 Robert Beccard</div><div>Cost Estimating: CPMI, Inc. 3265 Northwood Cir., Ste. 170 Eagan, MN 55121 (952)-854-3663 Bryan Bertrand</div><div>Geotechnical Engineering: Terracon Consultants, Inc. 50 Goldenland Ct., Ste. 100 Sacramento, CA 95834 (916)-928-4590 Robert Holmer</div></div>				<div>ARCHITECT/ENGINEER OF RECORD</div> <div><div>Project Management, Architecture, Landscape Architecture, Cemetery Planning, Civil Engineering, Land Survey: Anderson Engineering of MN, LLC 13605 1st Ave. N., Ste. 100 Plymouth, MN 55441 (763)-412-4000 Michael Brandvold, Project Manager</div><div><div>ANDERSON ENGINEERING</div><div>ENGINEERING • ARCHITECTURE • LAND SURVEYING ENVIRONMENTAL SERVICES • LANDSCAPE ARCHITECTURE</div></div></div>		<div>STAMP</div> <div><div>MINNESOTA PROFESSIONAL ENGINEER No. 00261 Bo A. Anderson 09/10-10/16 06/27/2018 CIVIL STATE OF CALIFORNIA</div></div>		<div>Office of Construction and Facilities Management</div> <div>VA U.S. Department of Veterans Affairs</div>		<div>Drawing Title</div> <div>UTILITY PLAN - OVERALL</div> <div>Approved: Project Director</div>		<div>Phase</div> <div>BID DOCUMENTS</div>		<div>Project Title</div> <div>Sacramento Valley National Cemetery Phase 2 Development</div> <div>Location 5810 Midway Rd, Dixon, CA 95620</div>		<div>Project Number</div> <div>921CM2007</div> <div>Building Number</div> <div></div> <div>Drawing Number</div> <div>CU101 164 OF 262</div>	
<div>Revisions:</div>		<div>Date:</div>																	