



three inches = one foot
one and one-half inch = one foot
one inch = one foot
three-quarters inch = one foot
one-half inch = one foot
three-eighths inch = one foot
one-quarter inch = one foot
one-eighth inch = one foot

LEGEND	
	DECOMPOSED GRANITE
	CONTROL JOINT
	EXPANSION JOINT
	DETECTABLE WARNING PANEL


COMMITTAL SERVICE SHELTER POINT TABLE			
Point #	Northing	Easting	Description
P 1	1911378.1922	6596964.6775	INTERSECTION OF GRID LINE A1
P 2	1911384.4039	6596987.8598	INTERSECTION OF GRID LINE B1
P 3	1911355.0110	6596970.8889	INTERSECTION OF GRID LINE A2
P 4	1911361.2216	6596994.0714	INTERSECTION OF GRID LINE B2
P 5	1911369.7069	6596979.3745	RADIUS POINT
P 6	1911345.3789	6596988.5793	CONTROL POINT
P 7	1911373.1440	6596992.1995	CONTROL POINT
P 8	1911386.9177	6597043.6038	CONTROL POINT
P 9	1911401.0749	6597096.4388	CONTROL POINT
P 10	1911428.9885	6597007.1630	CONTROL POINT
P 11	1911332.2628	6597033.0805	CONTROL POINT

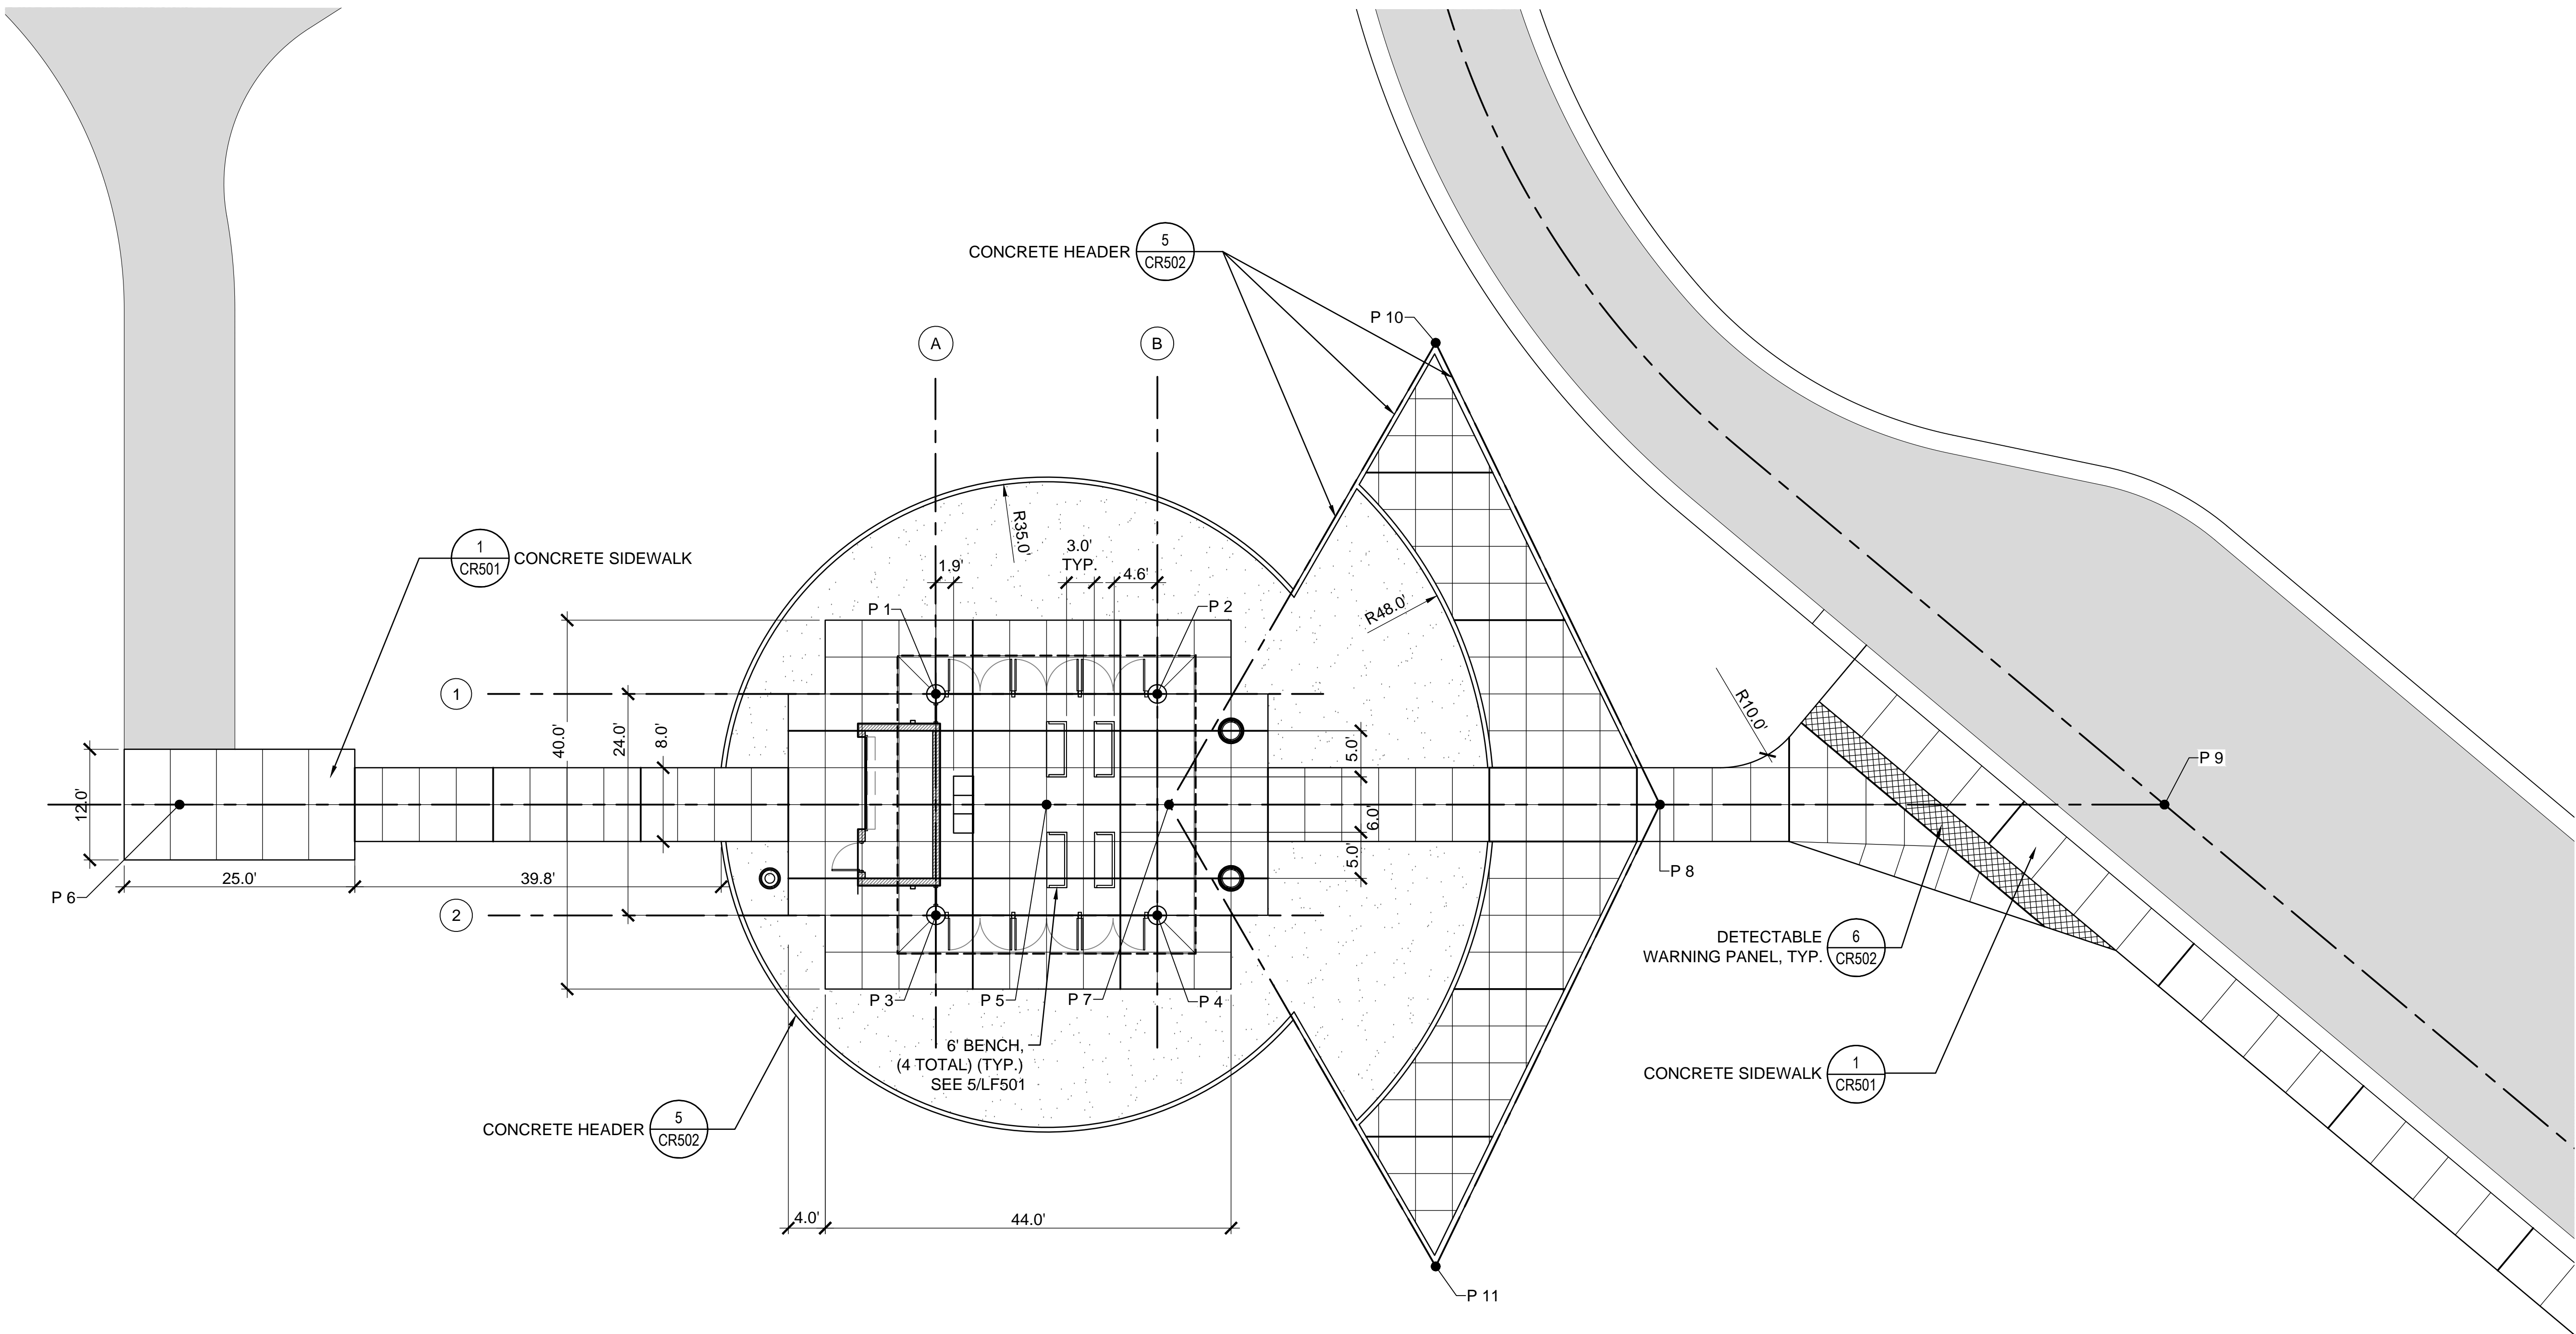

1 BUILDING 4803 SITE PLAN
SCALE: 1" = 20' (30"x42" PAPER)

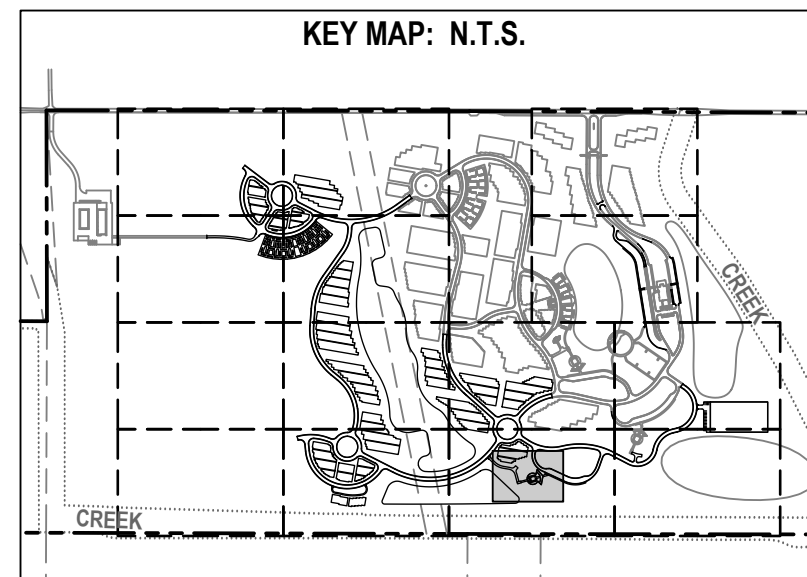


CONSULTANTS		ARCHITECT/ENGINEER OF RECORD		Office of Construction and Facilities Management		Project Title Sacramento Valley National Cemetery Phase 2 Development		Project Number 921CM2007	
Structural Engineering, Electrical Engineering: HDR Engineering, Inc. 2365 Iron Point Rd. #500 Folsom, CA 95630 (916)-817-4924 Duane Hodgins		Irrigation: Aqua Engineering, Inc. 373 Horseshoe Rd., Bldg. 2-202 Fort Collins, CO 80525 (970)-372-6104 Robert Beccard		Cost Estimating: CPMI, Inc. 3265 Northwood Cir., Ste. 170 Eagan, MN 55121 (952)-854-3663 Bryan Bertrand		Geotechnical Engineering: Terracon Consultants, Inc. 50 Goldenland Ct., Ste. 100 Sacramento, CA 95834 (916)-928-4690 Robert Holmer		Location 5810 Midway Rd, Dixon, CA 95620	
Revisions:		Date:		Approved: Project Director		Issue Date JUNE 27, 2018		Checked Drawn Drawing Number A-101	
VA FORM 08 - 6231		1		2		3		4	







 


	REQUIRED	PROVIDED
ASSEMBLY AREA -	200 FEET MAX	43 FEET
STORAGE AREA -	300 FEET MAX	22 FEET

E

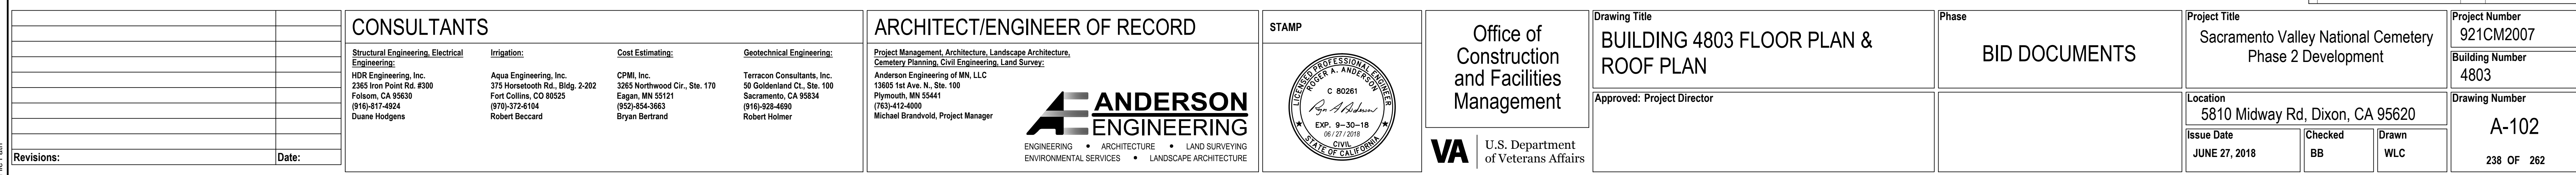


three inches = one foot
one and one-half inch = one foot
one inch = one foot
three-quarters inch = one foot
one-half inch = one foot
three-eighths inch = one foot
one-quarter inch = one foot
one-eighth inch = one foot

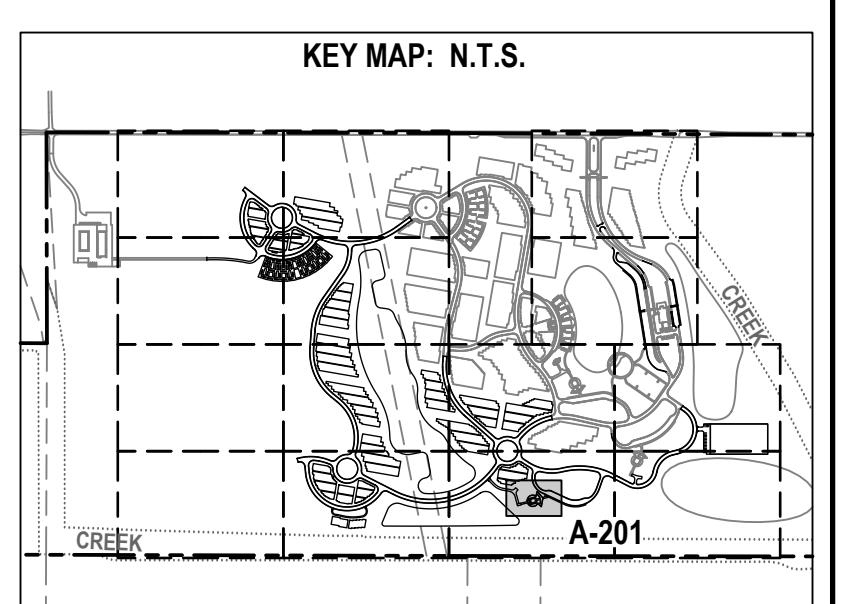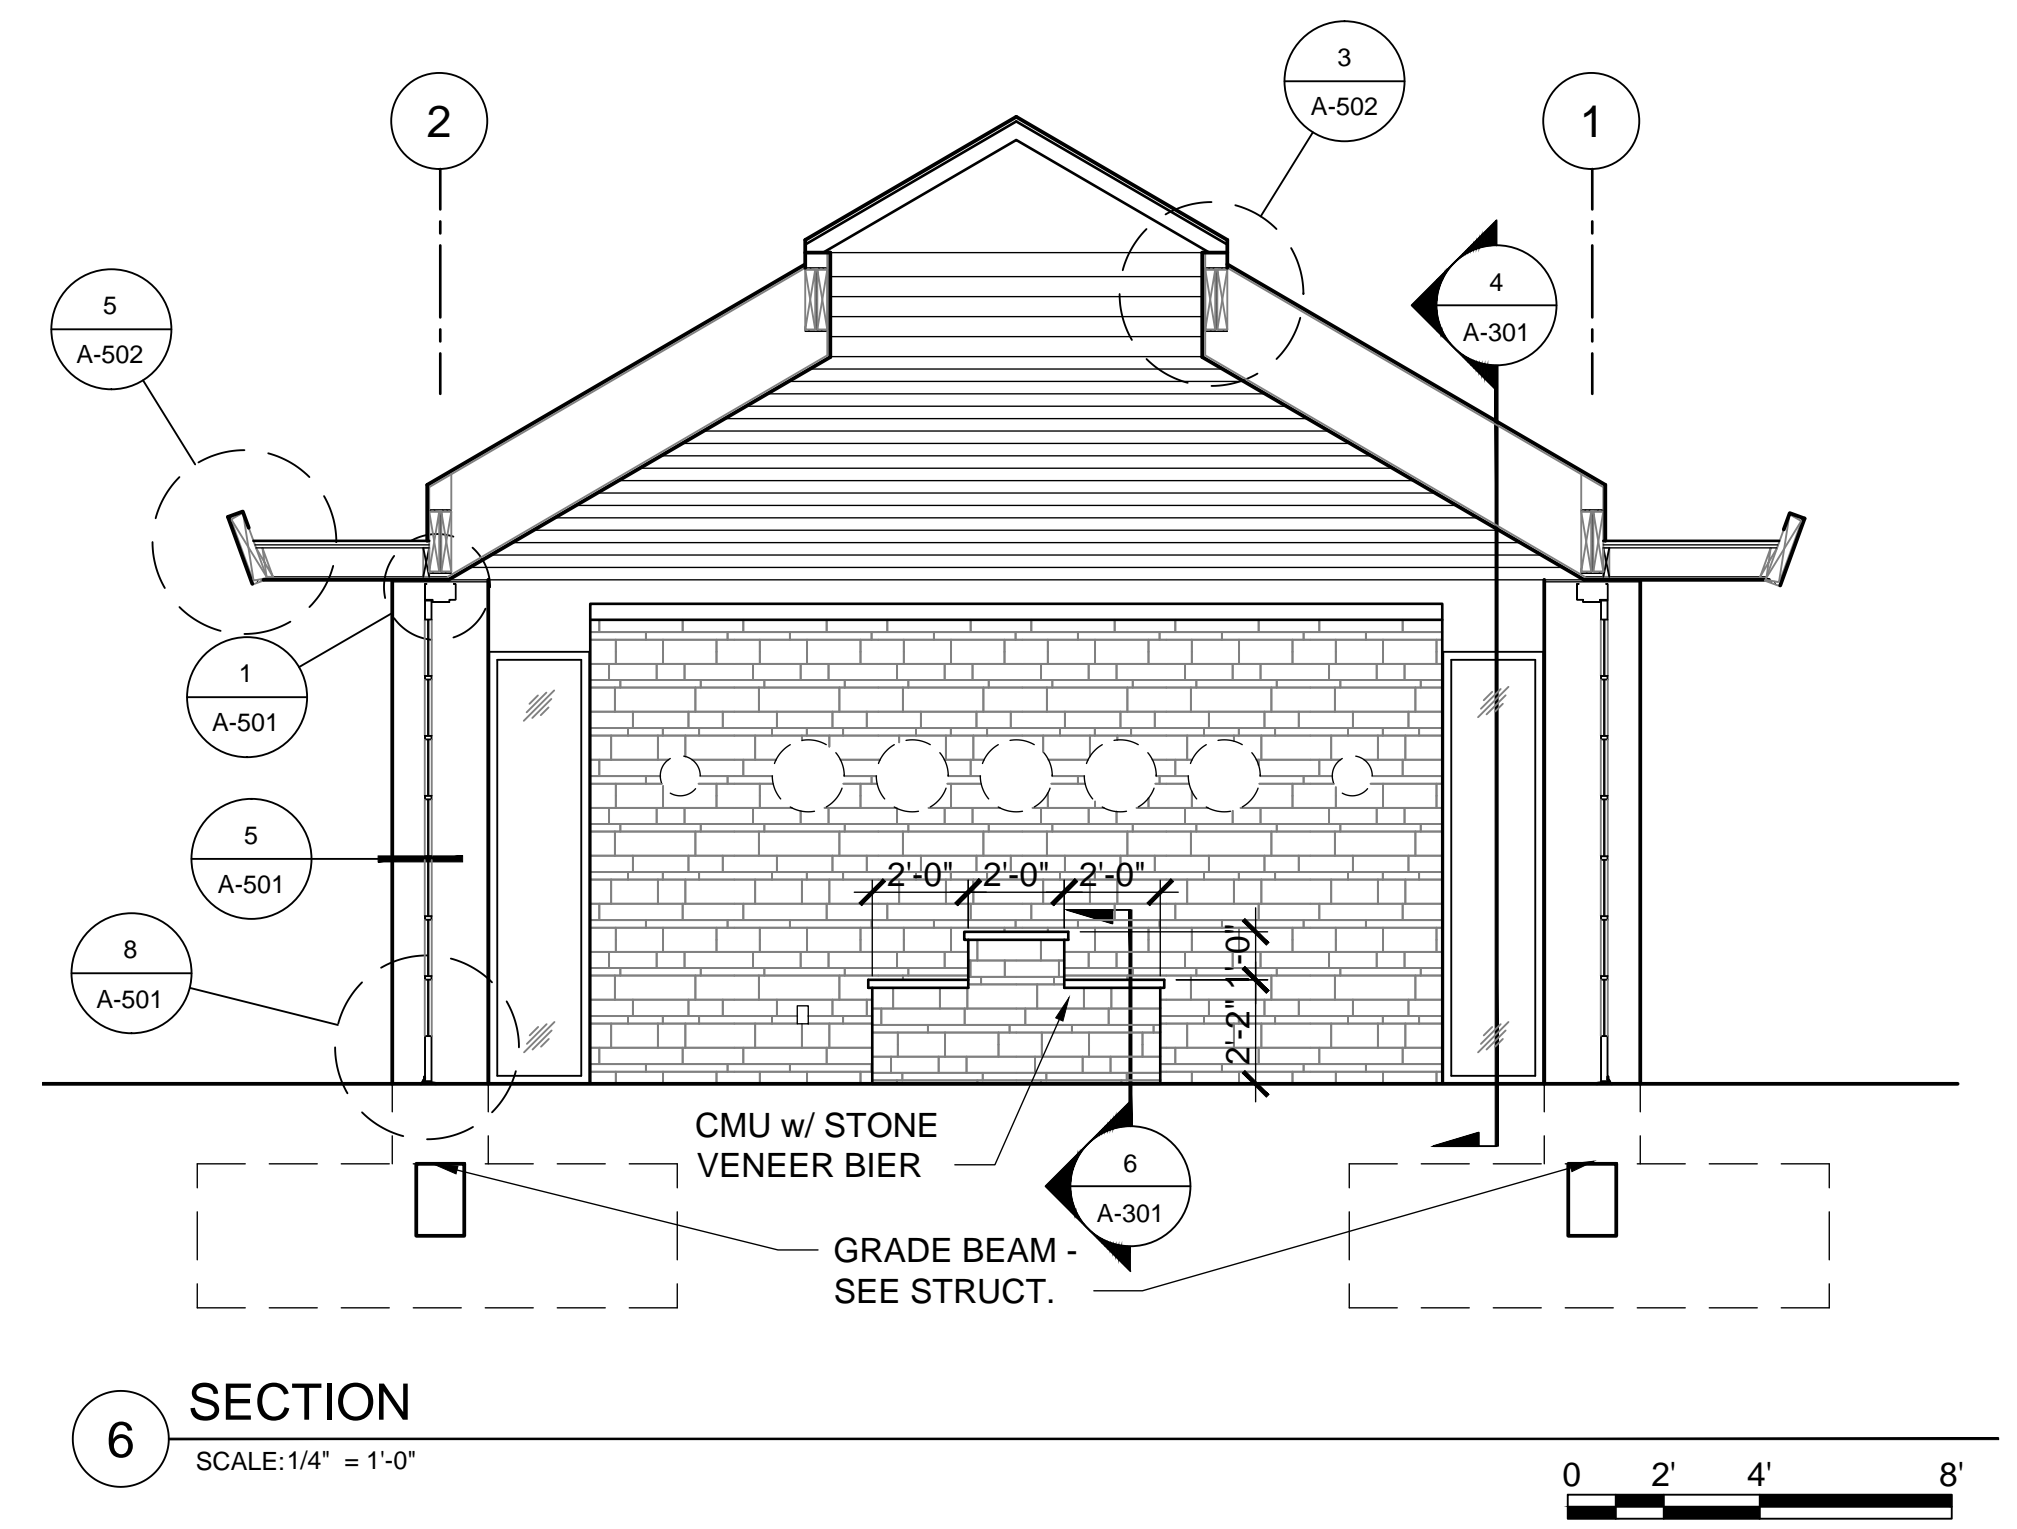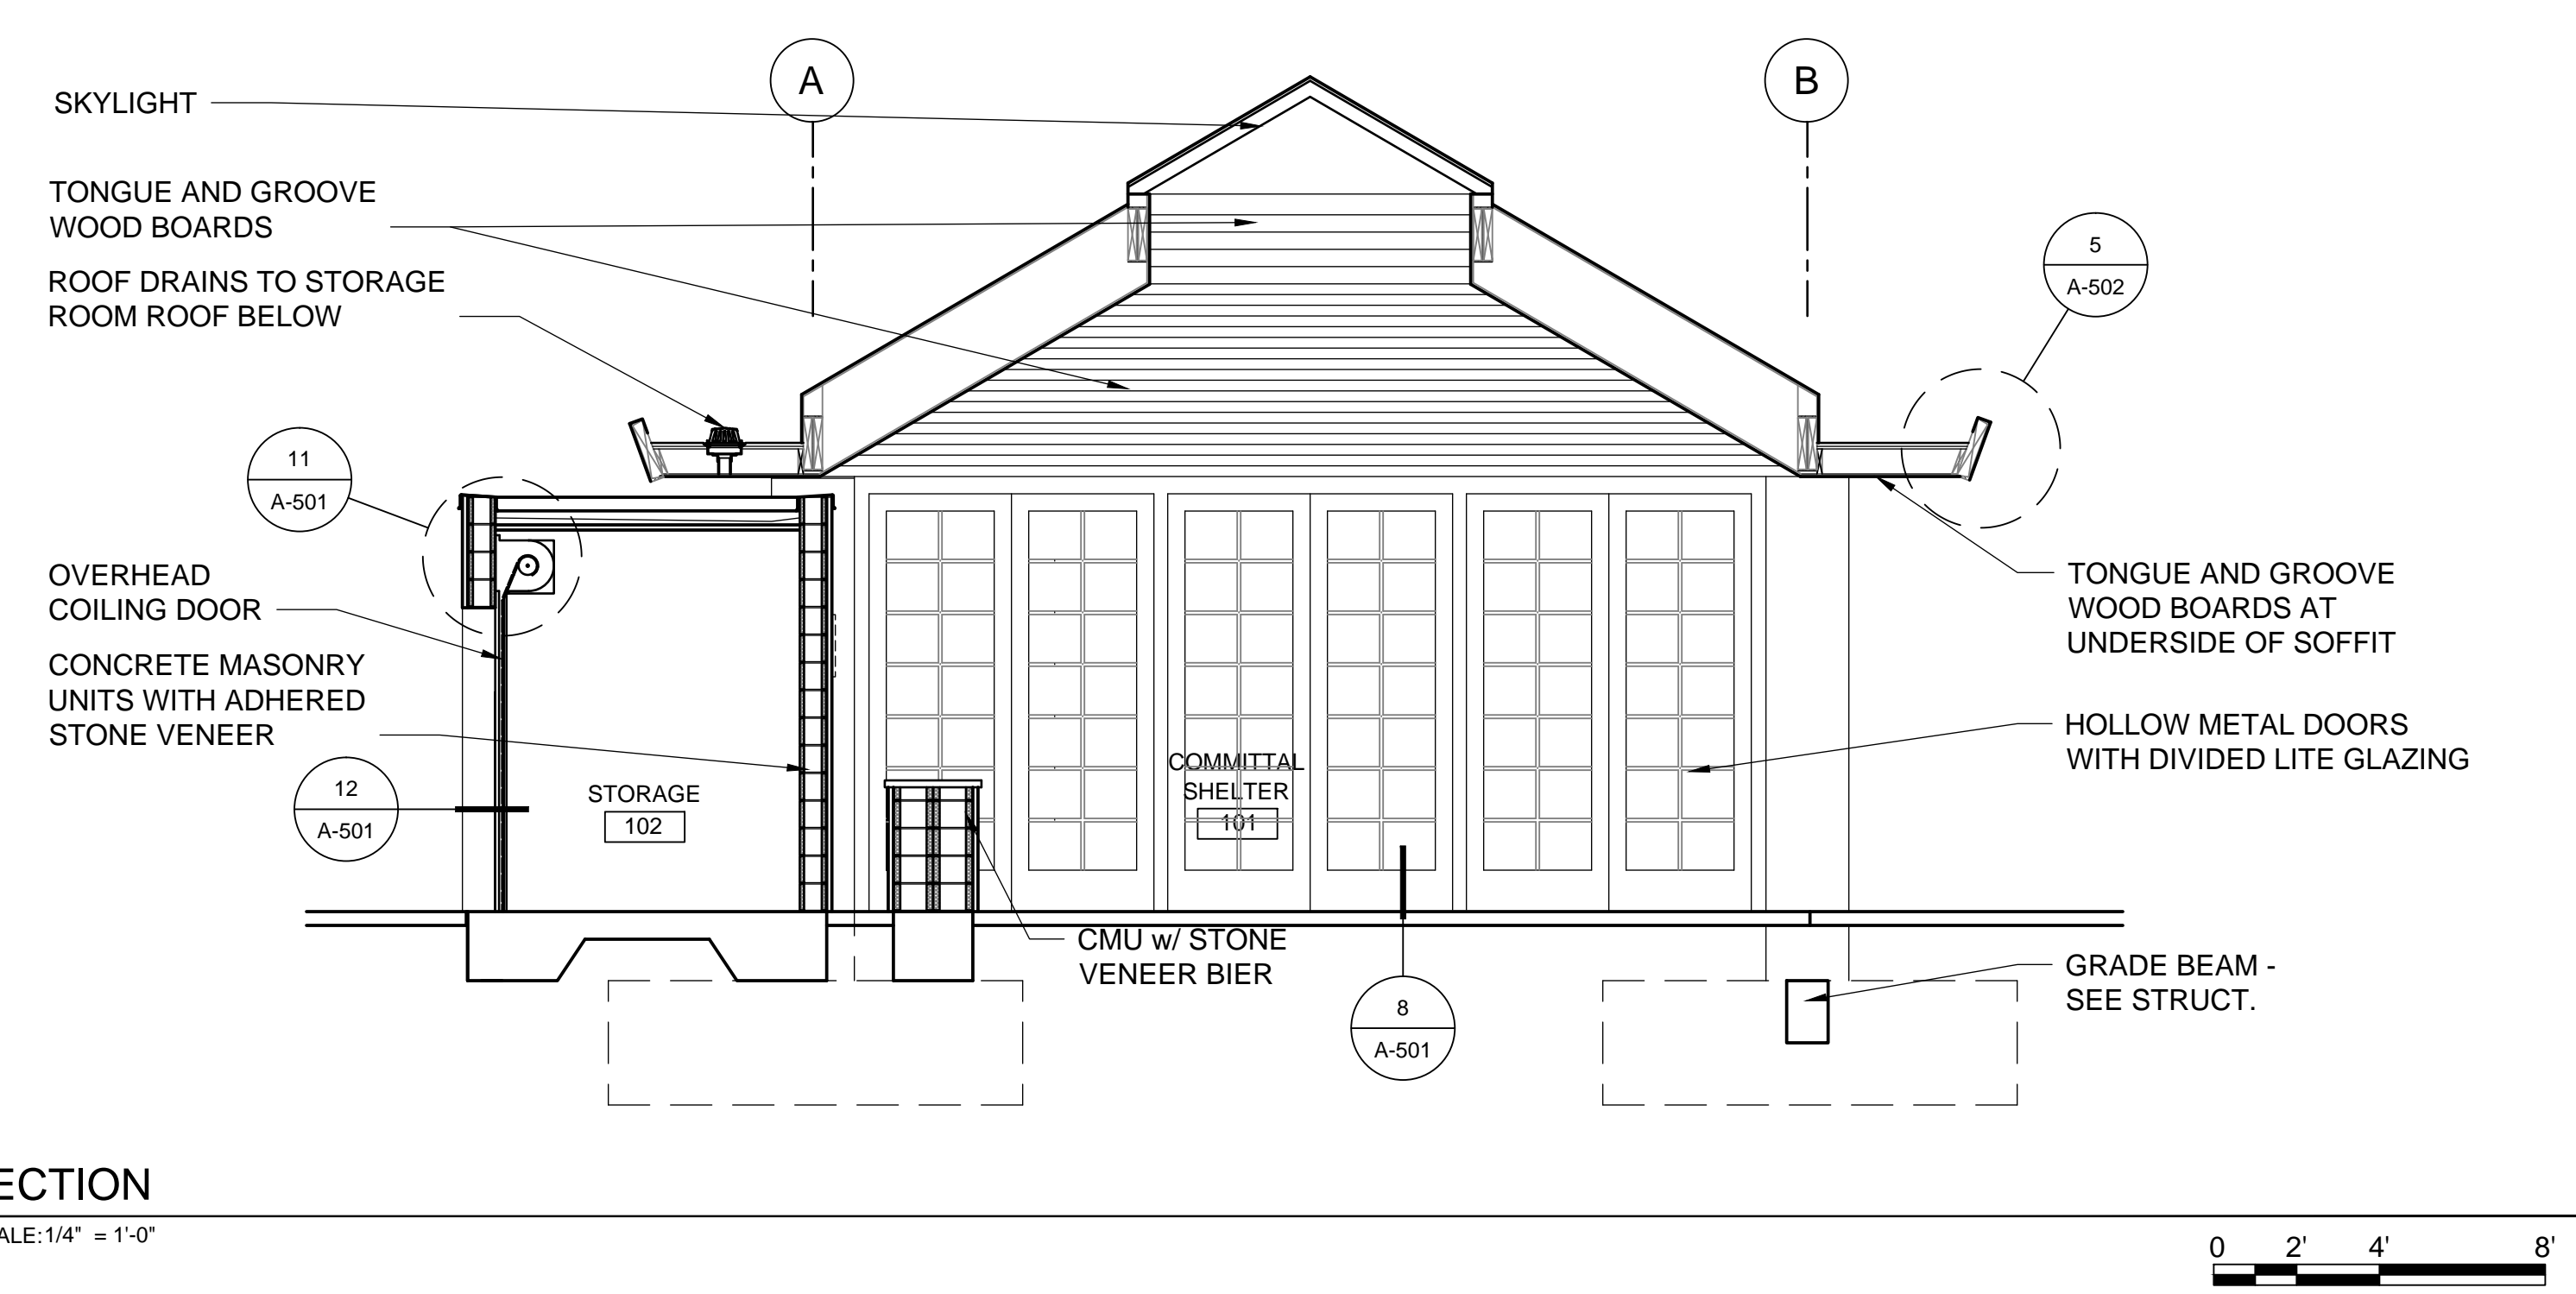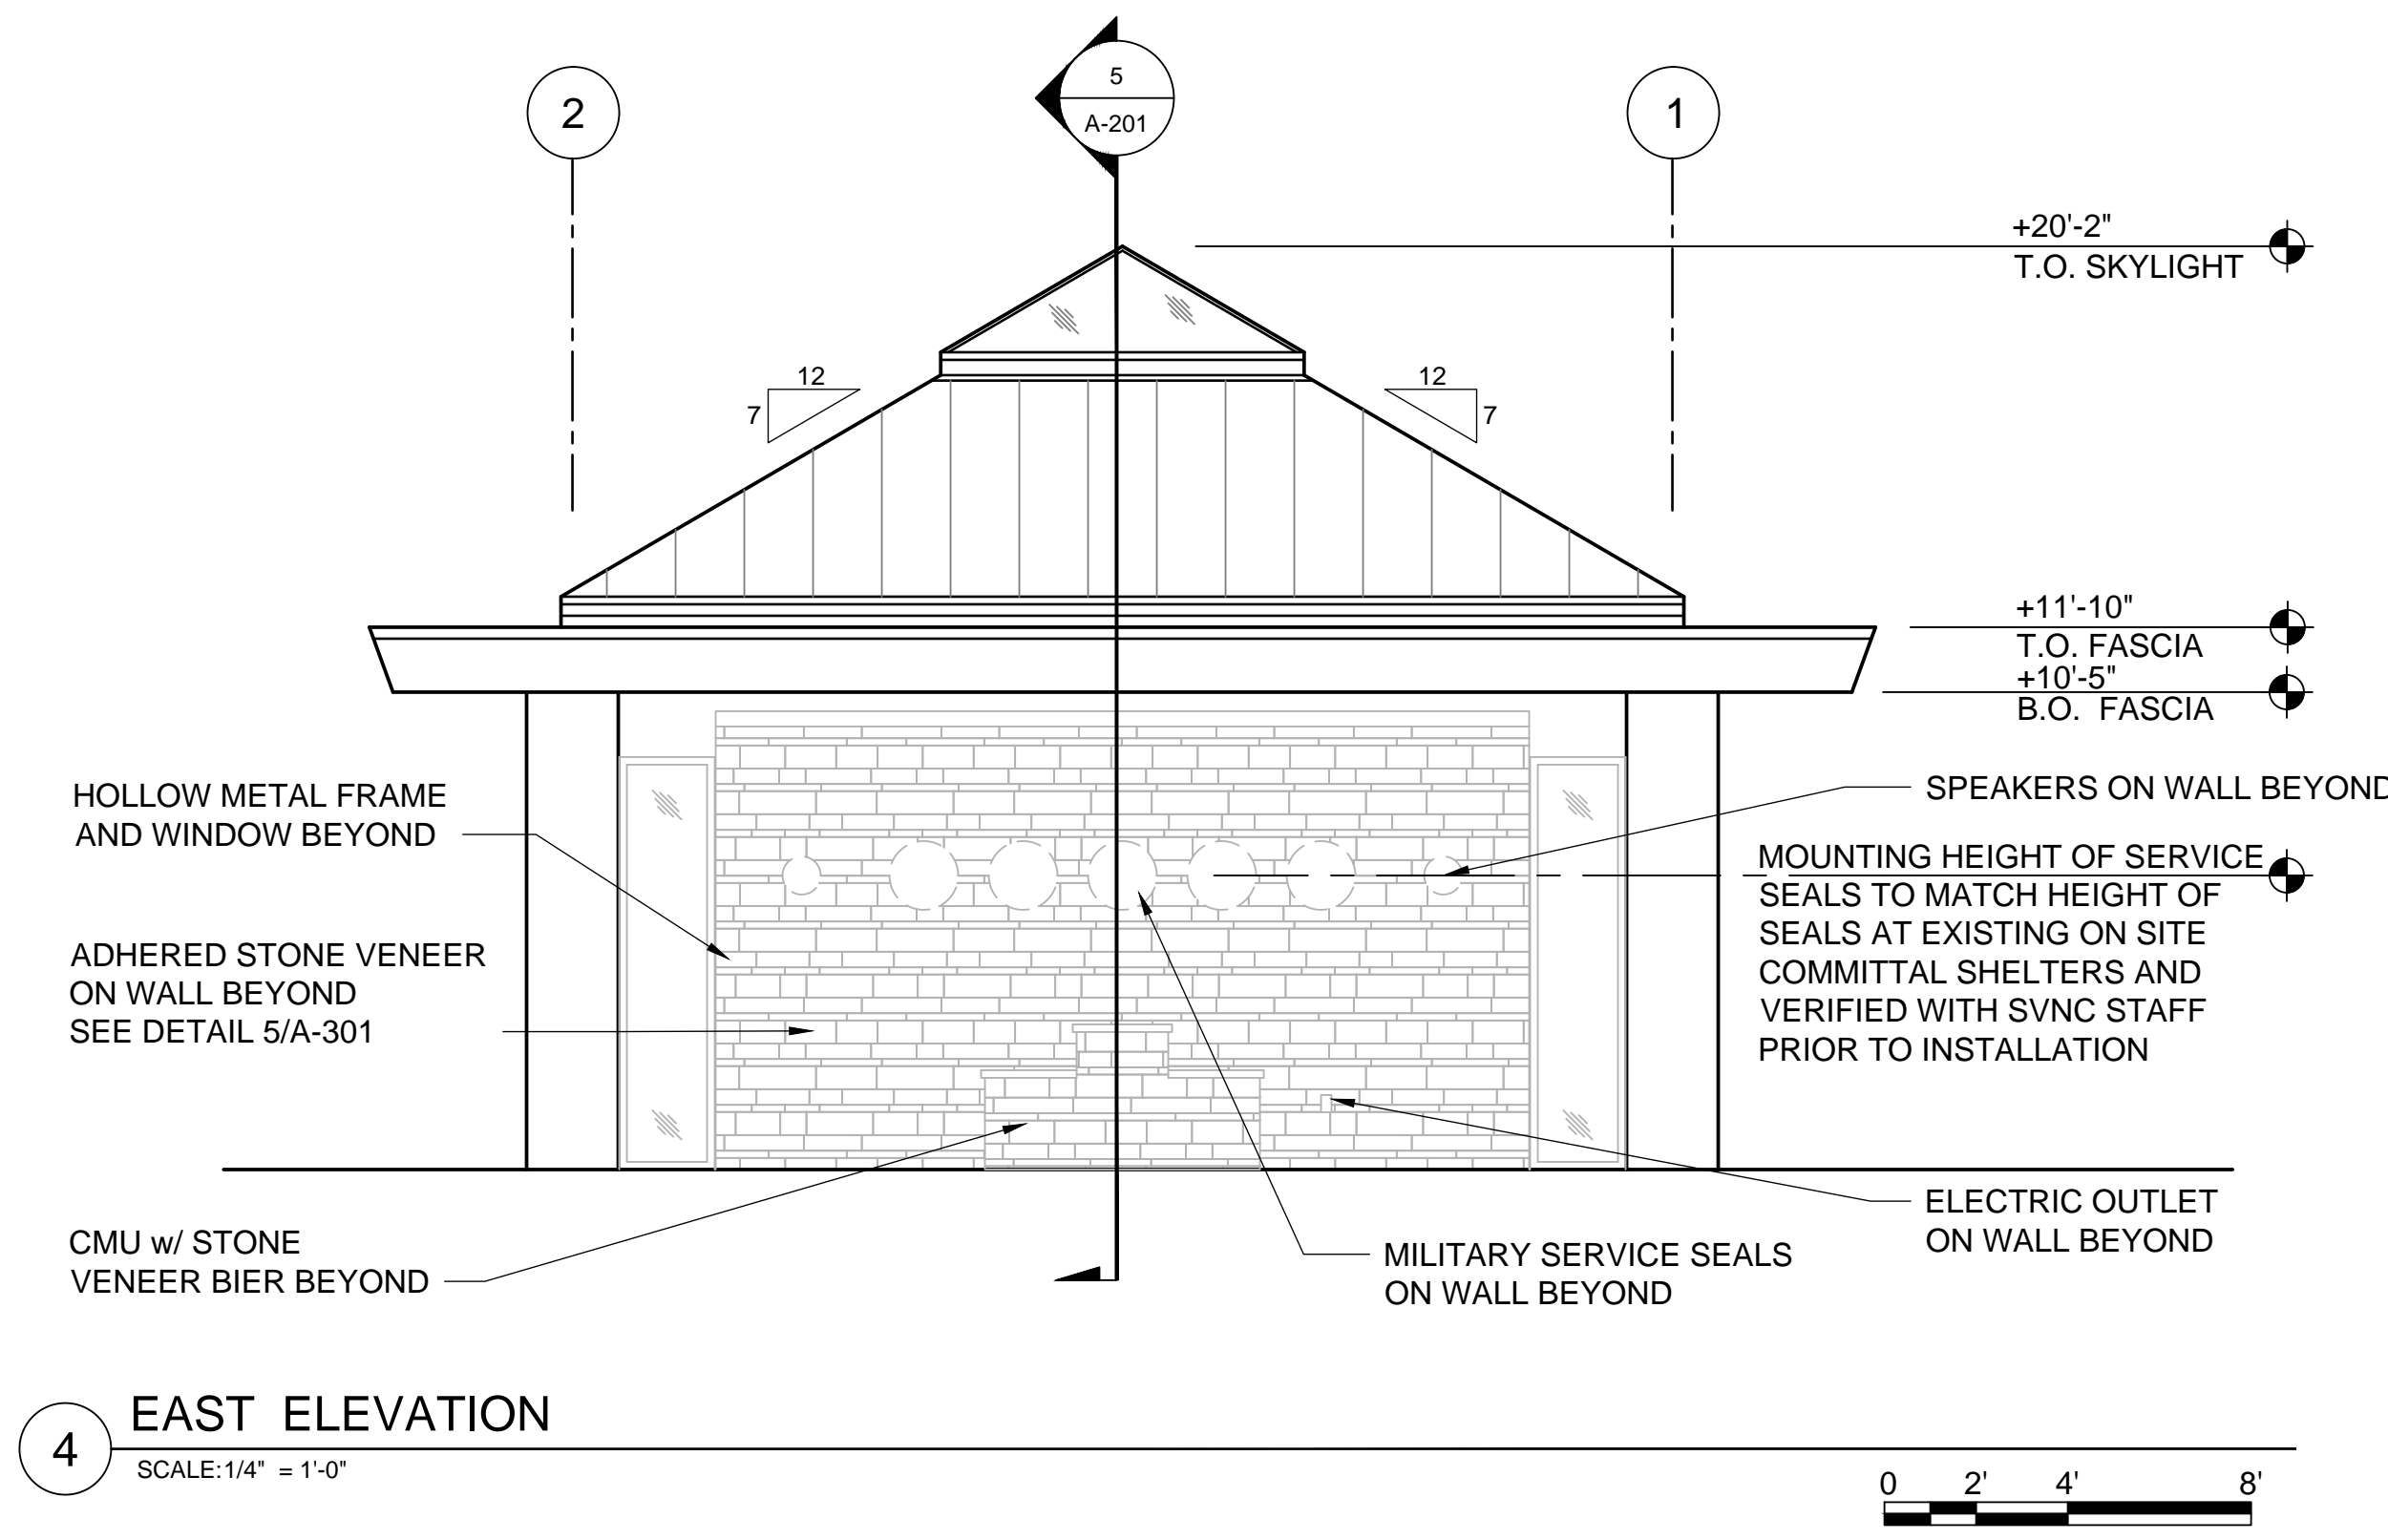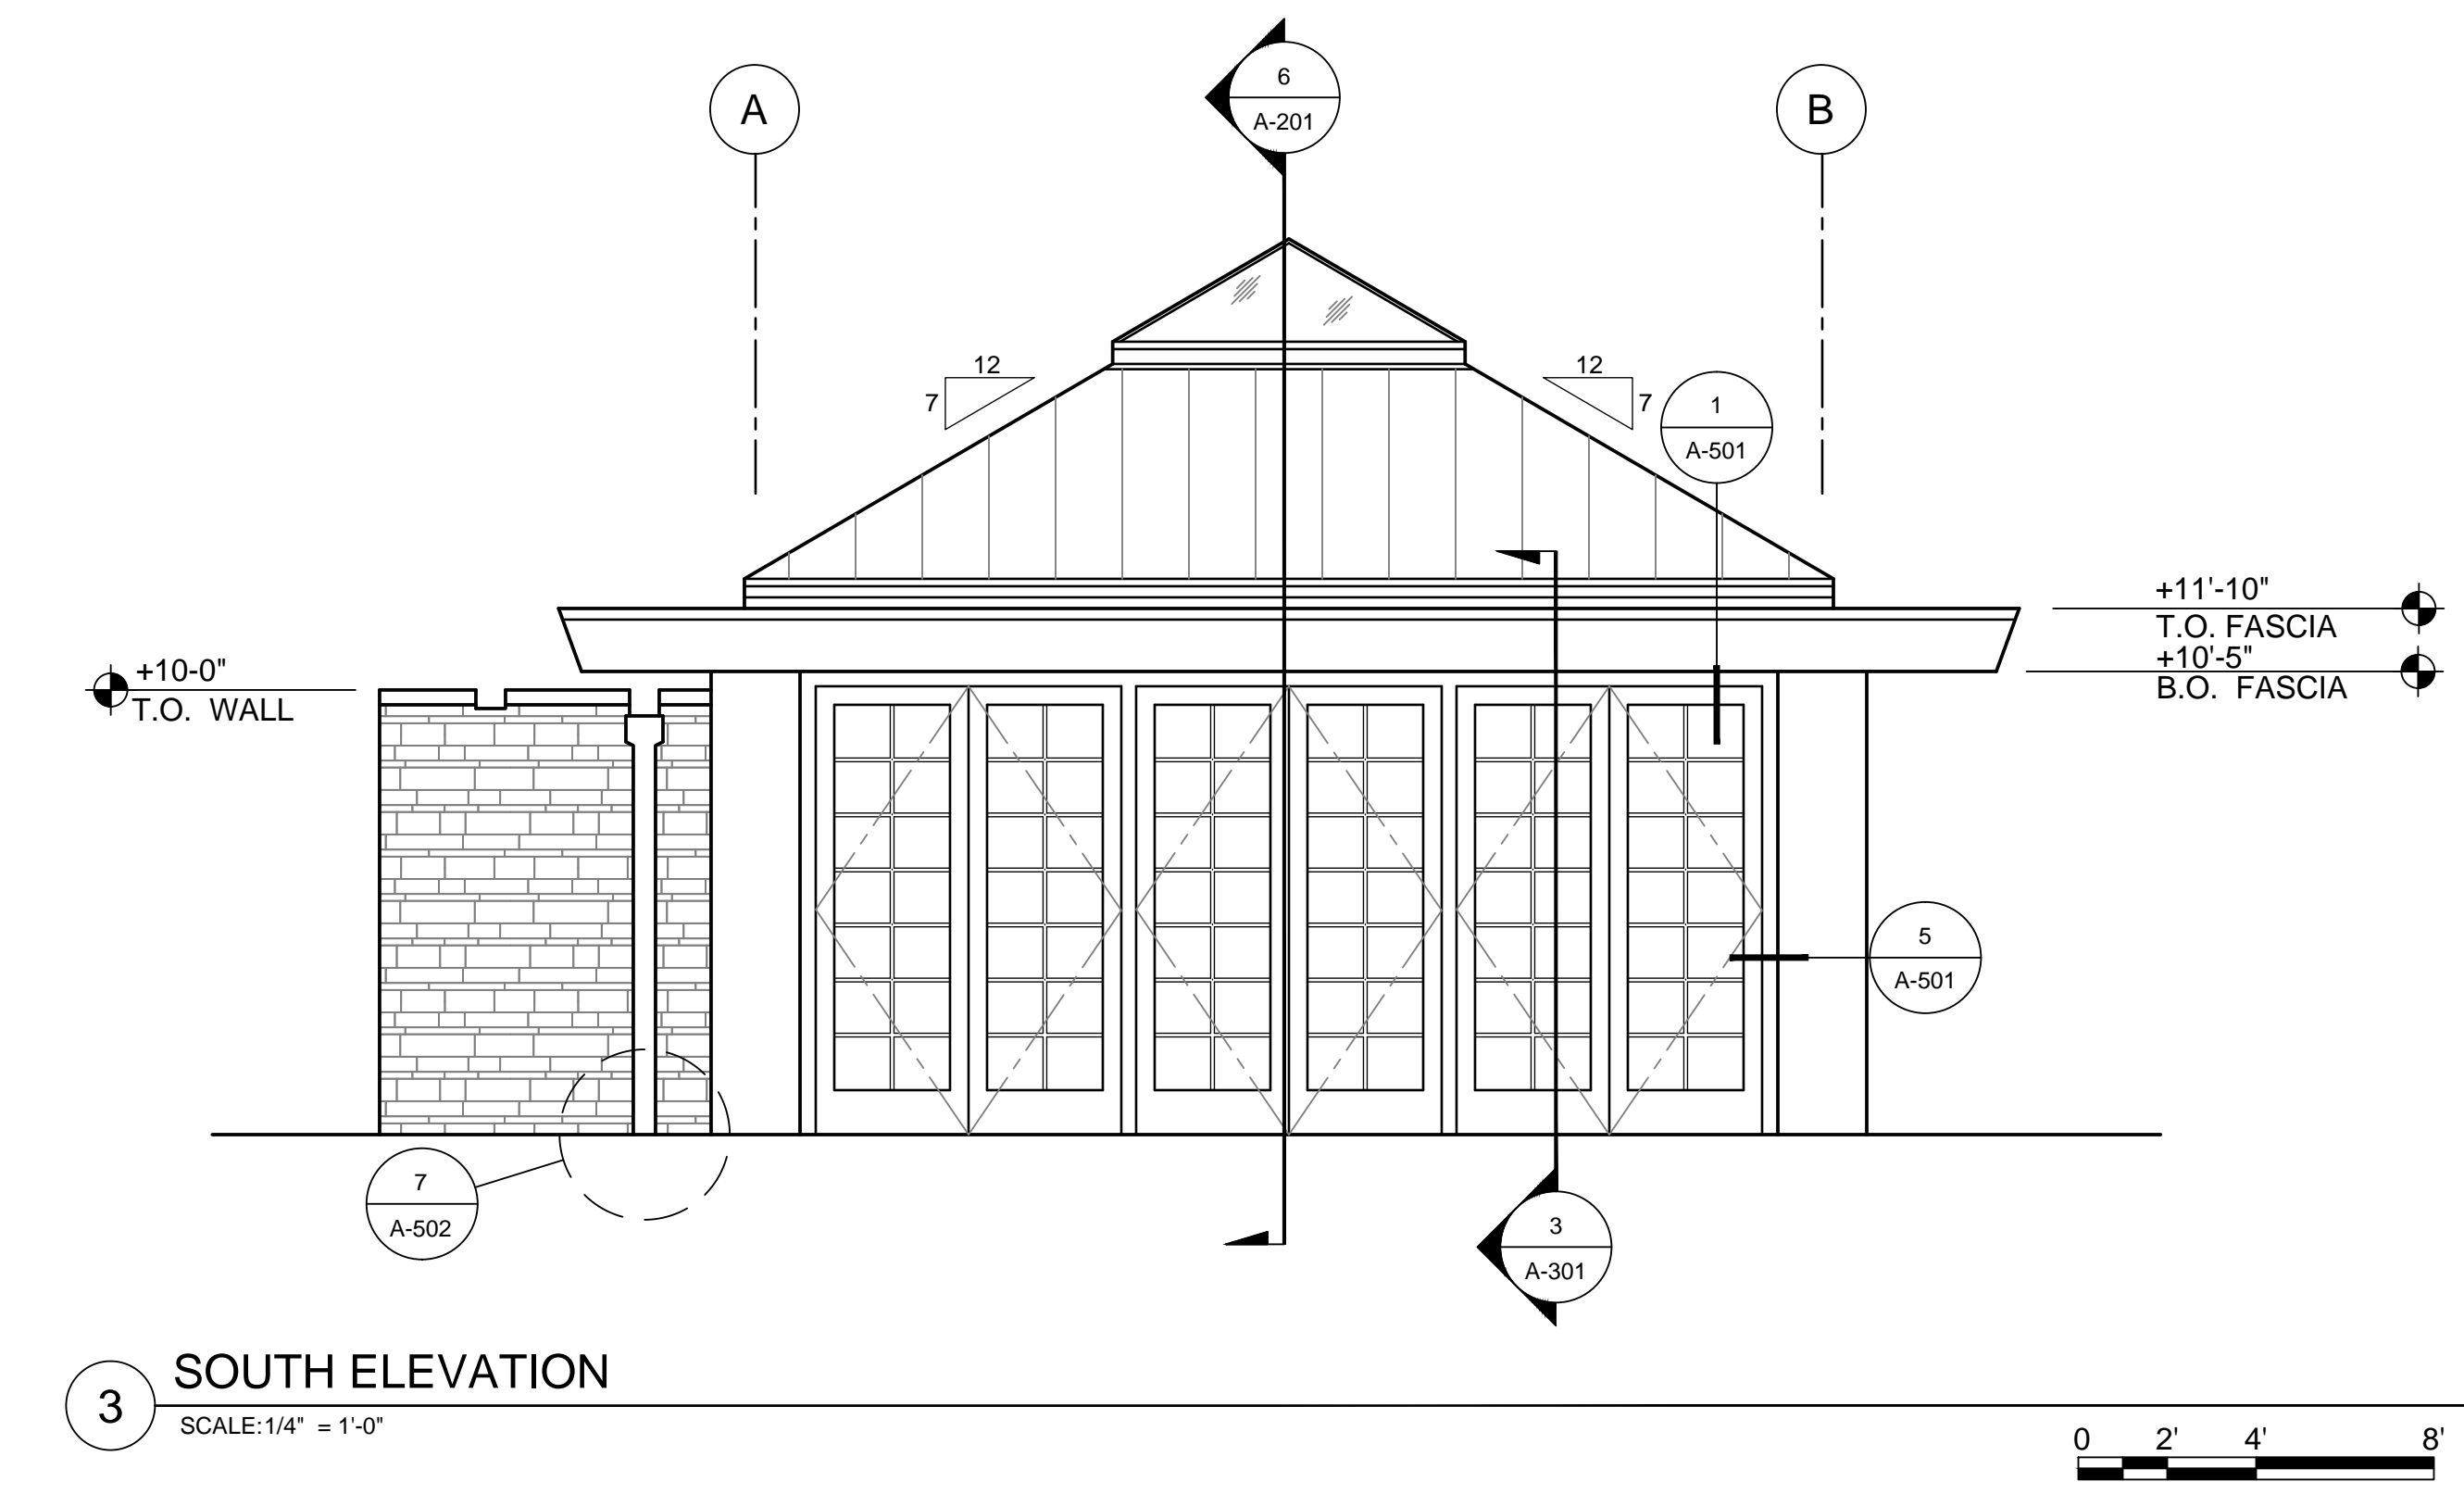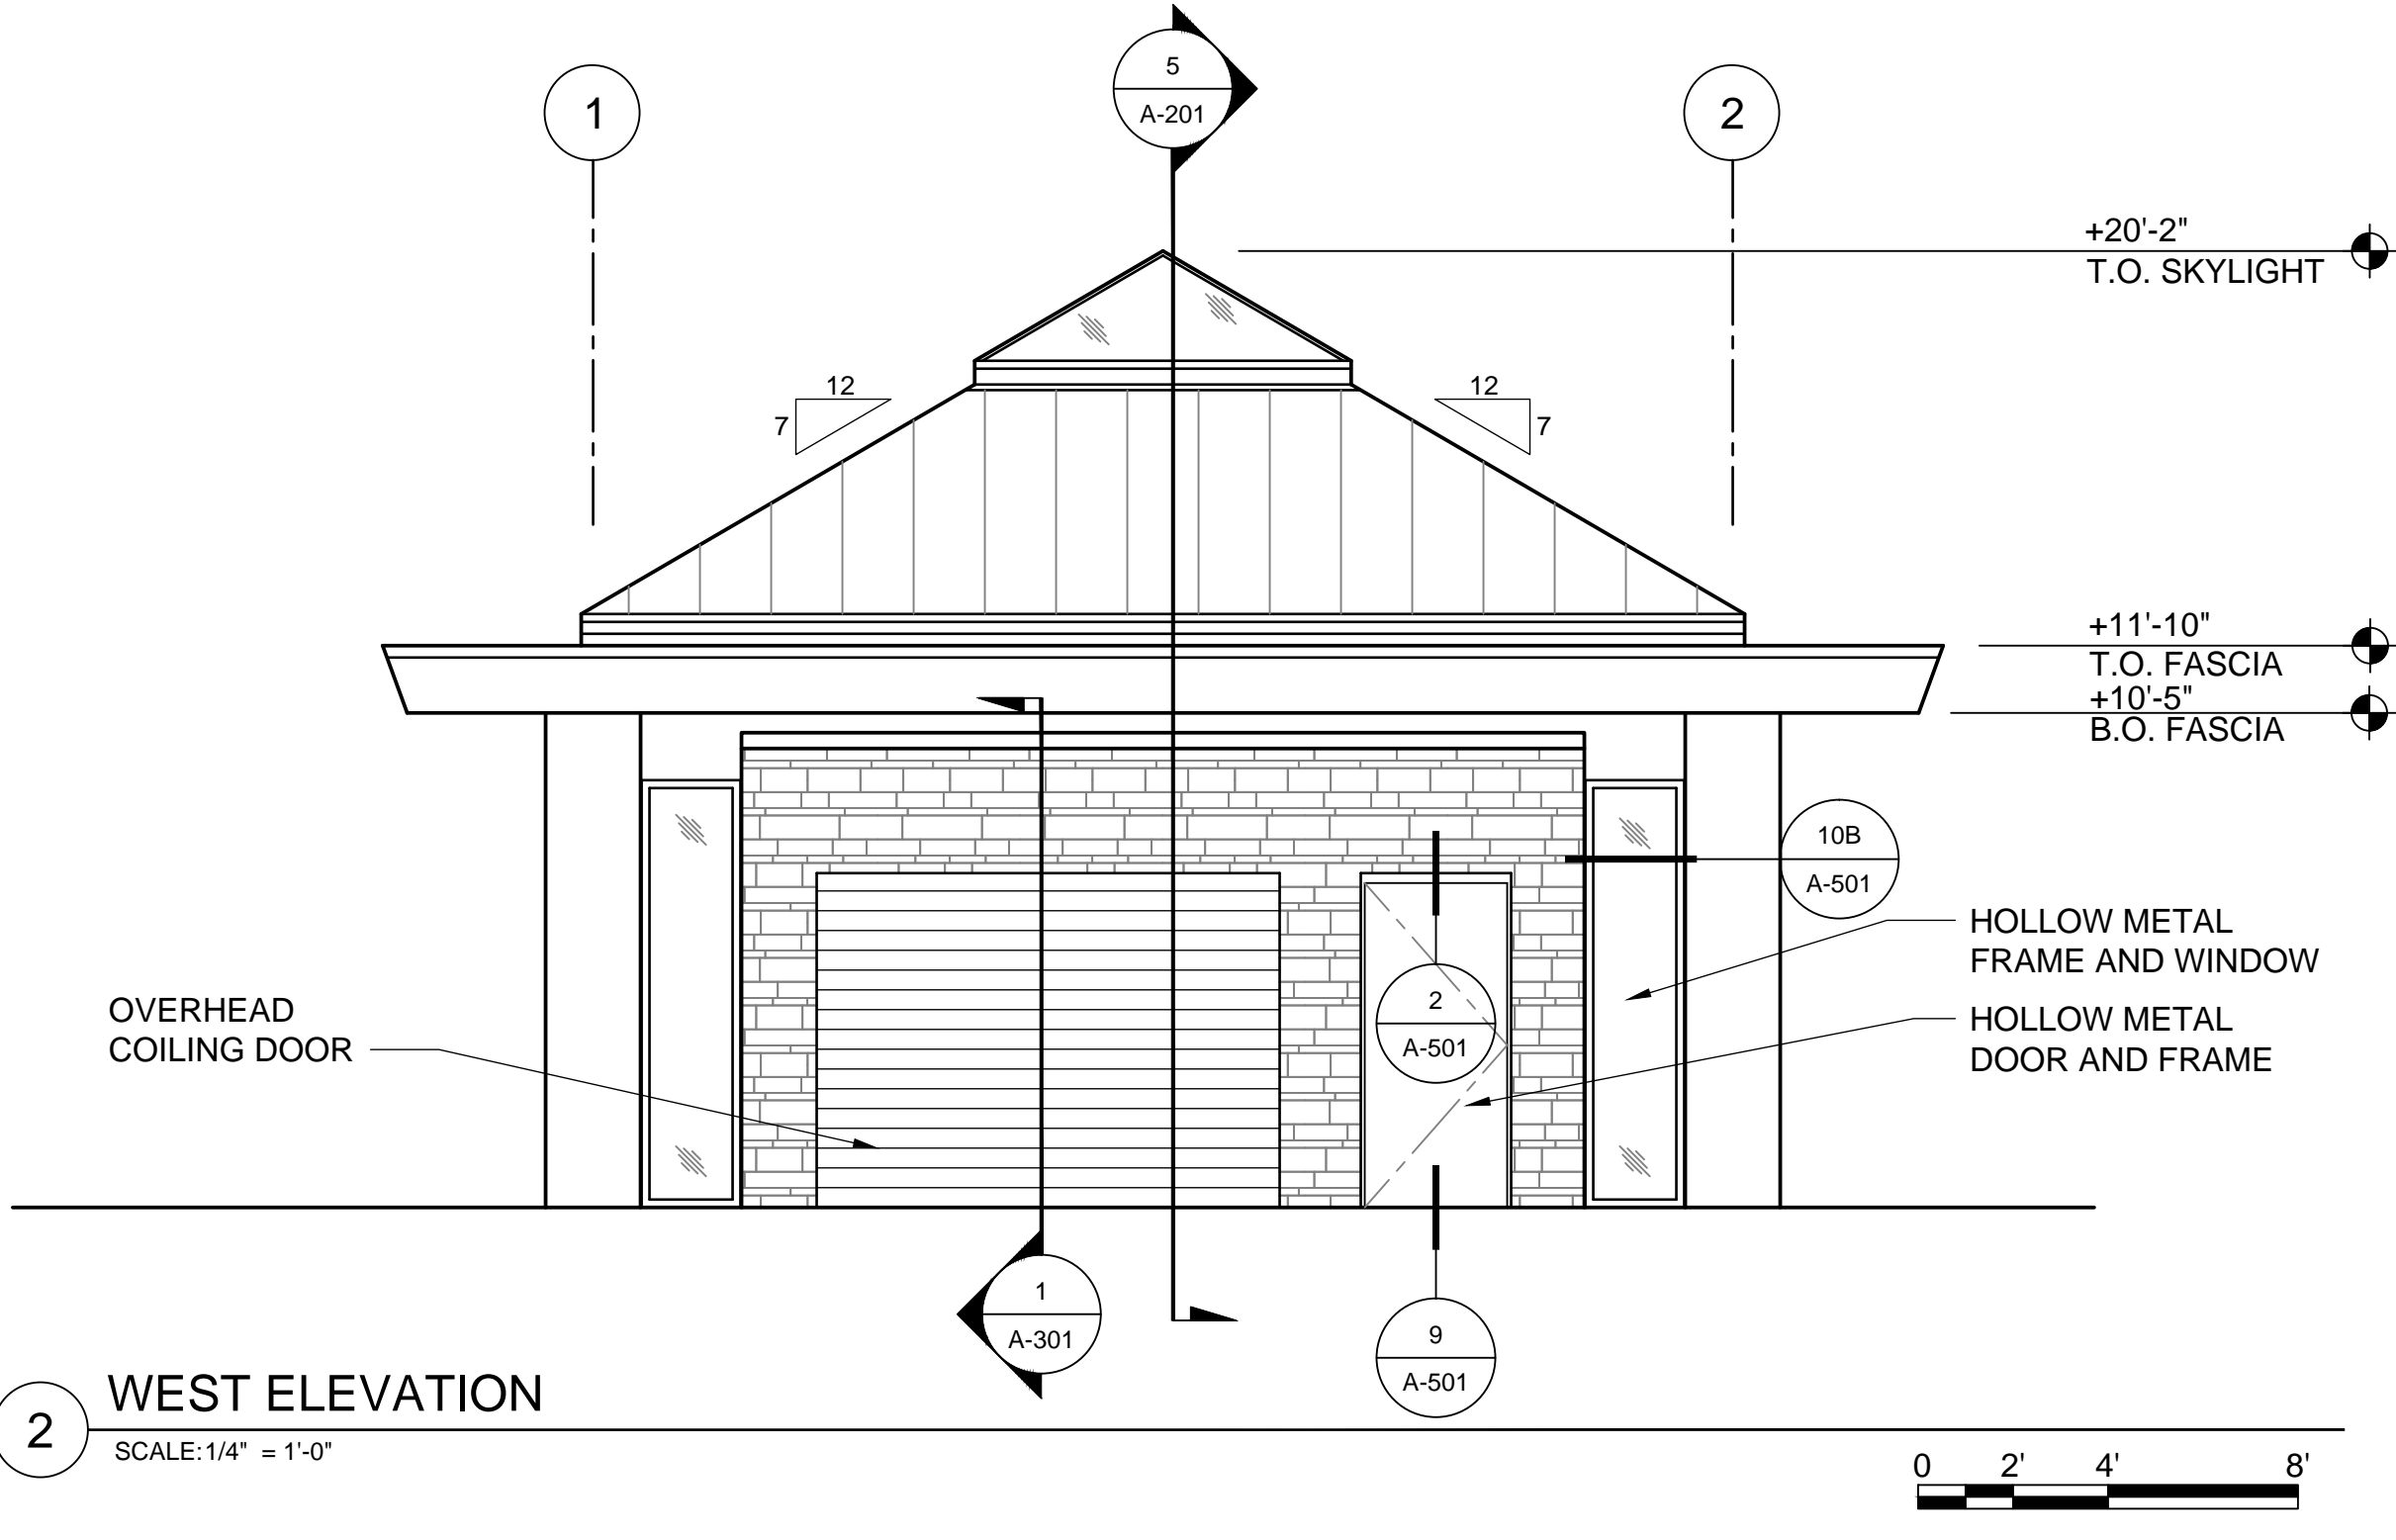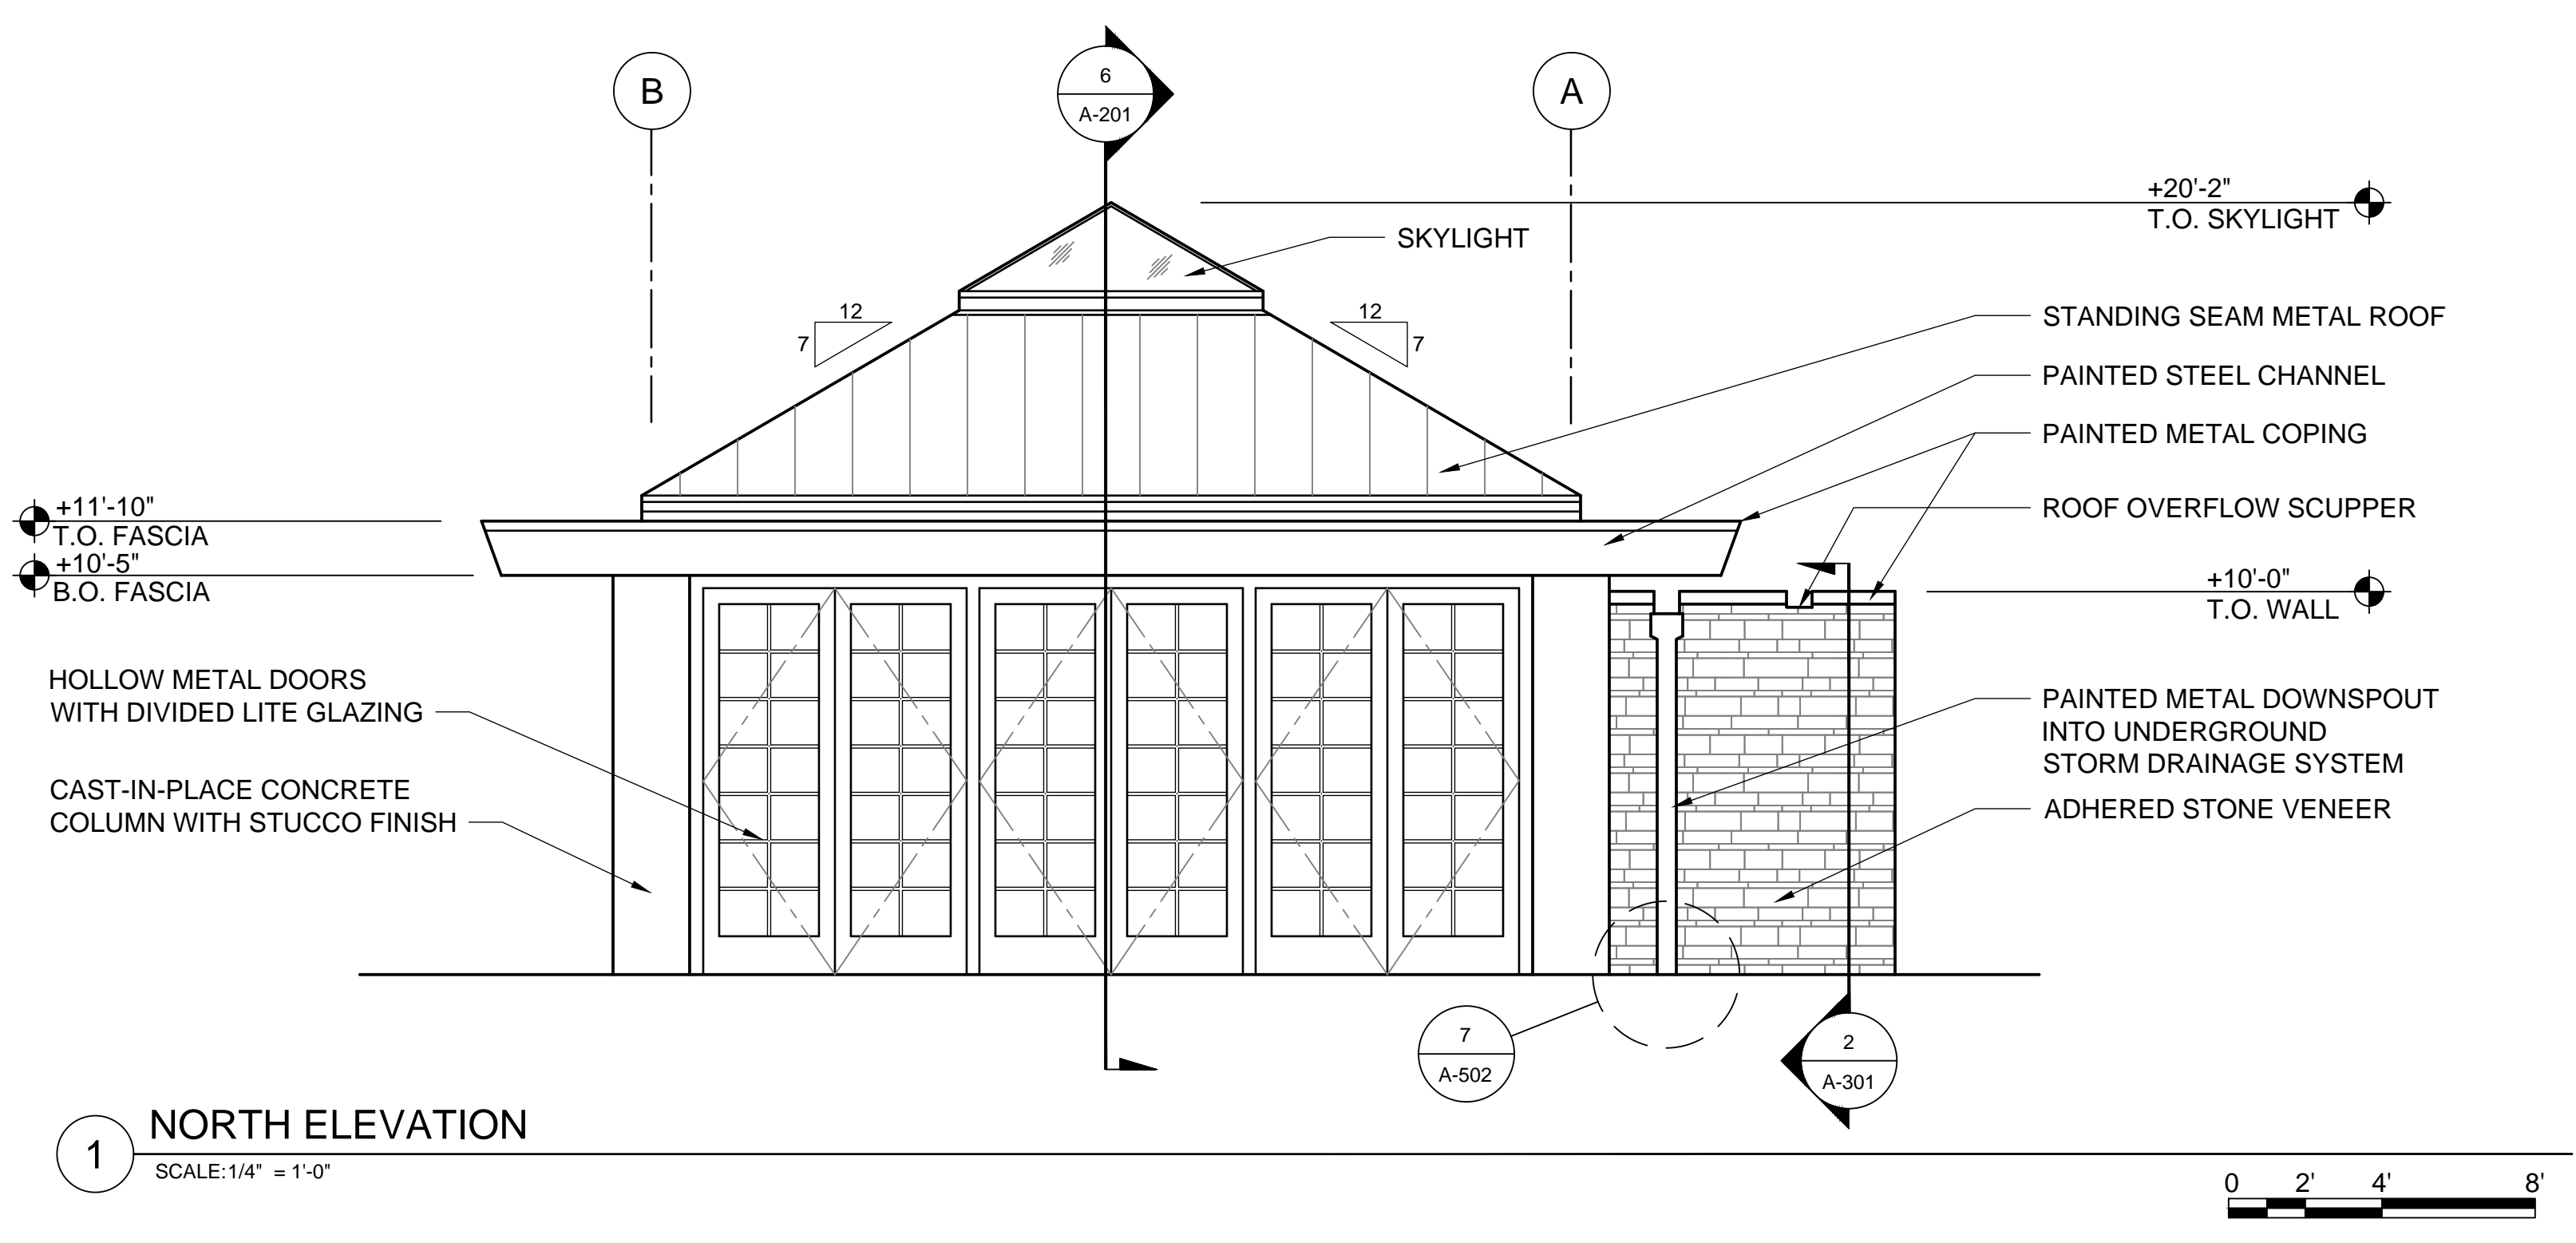


CONSULTANTS		ARCHITECT/ENGINEER OF RECORD		Office of Construction and Facilities Management		BUILDING 4803 ELEVATIONS & SECTIONS		BID DOCUMENTS		Project Title Sacramento Valley National Cemetery Phase 2 Development		Project Number 921CM2007	
Structural Engineering, Electrical Engineering: HDR Engineering, Inc. 2365 Iron Point Rd. #500 Folsom, CA 95630 (916)-817-4924 Duane Hodgins		Irrigation: Aqua Engineering, Inc. 375 Horseshoe Rd., Bldg. 2-202 Fort Collins, CO 80525 (970)-372-6104 Robert Beccard		Cost Estimating: CPMI, Inc. 3265 Northwood Cir., Ste. 170 Eagan, MN 55121 (952)-854-3663 Bryan Bertrand		Geotechnical Engineering: Terracon Consultants, Inc. 50 Goldenland Ct., Ste. 100 Plymouth, MN 55441 (763)-412-4000 Michael Brandvold, Project Manager		Drawing Title BUILDING 4803 ELEVATIONS & SECTIONS		Location 5810 Midway Rd, Dixon, CA 95620		Building Number 4803	
Revisions:		Date:		Approved: Project Director		Issue Date JUNE 27, 2018		Checked BB		Drawn WLC		Drawing Number A-201 239 OF 262	


three inches = one foot
one and one-half inch = one foot
one inch = one foot
three-quarters inch = one foot
one-half inch = one foot
three-eighths inch = one foot
one-quarter inch = one foot
one-eighth inch = one foot

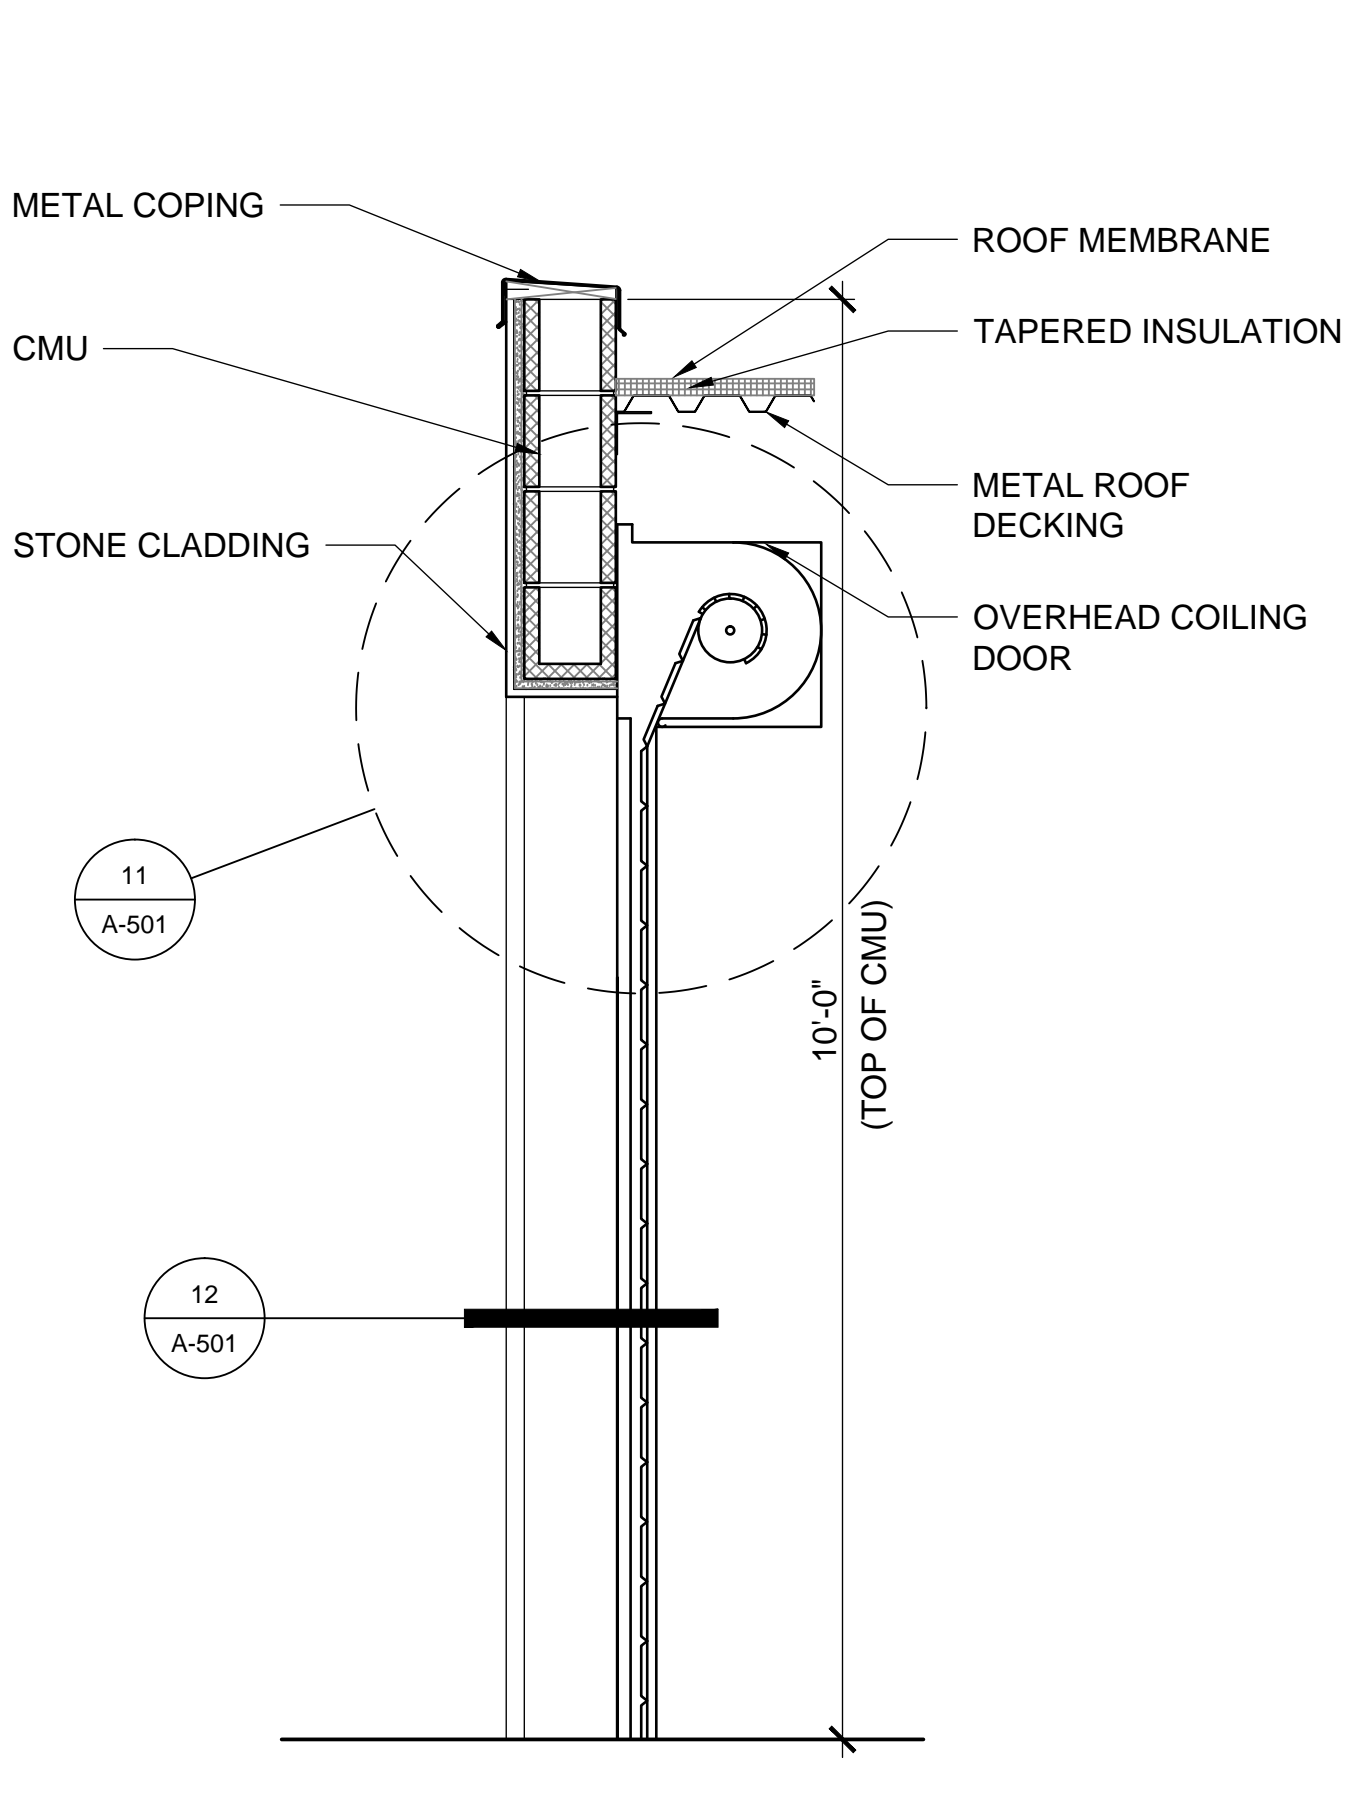


1 WALL SECTION @ STORAGE ROOM OVERHEAD DOOR
SCALE: 3/4" = 1'-0"

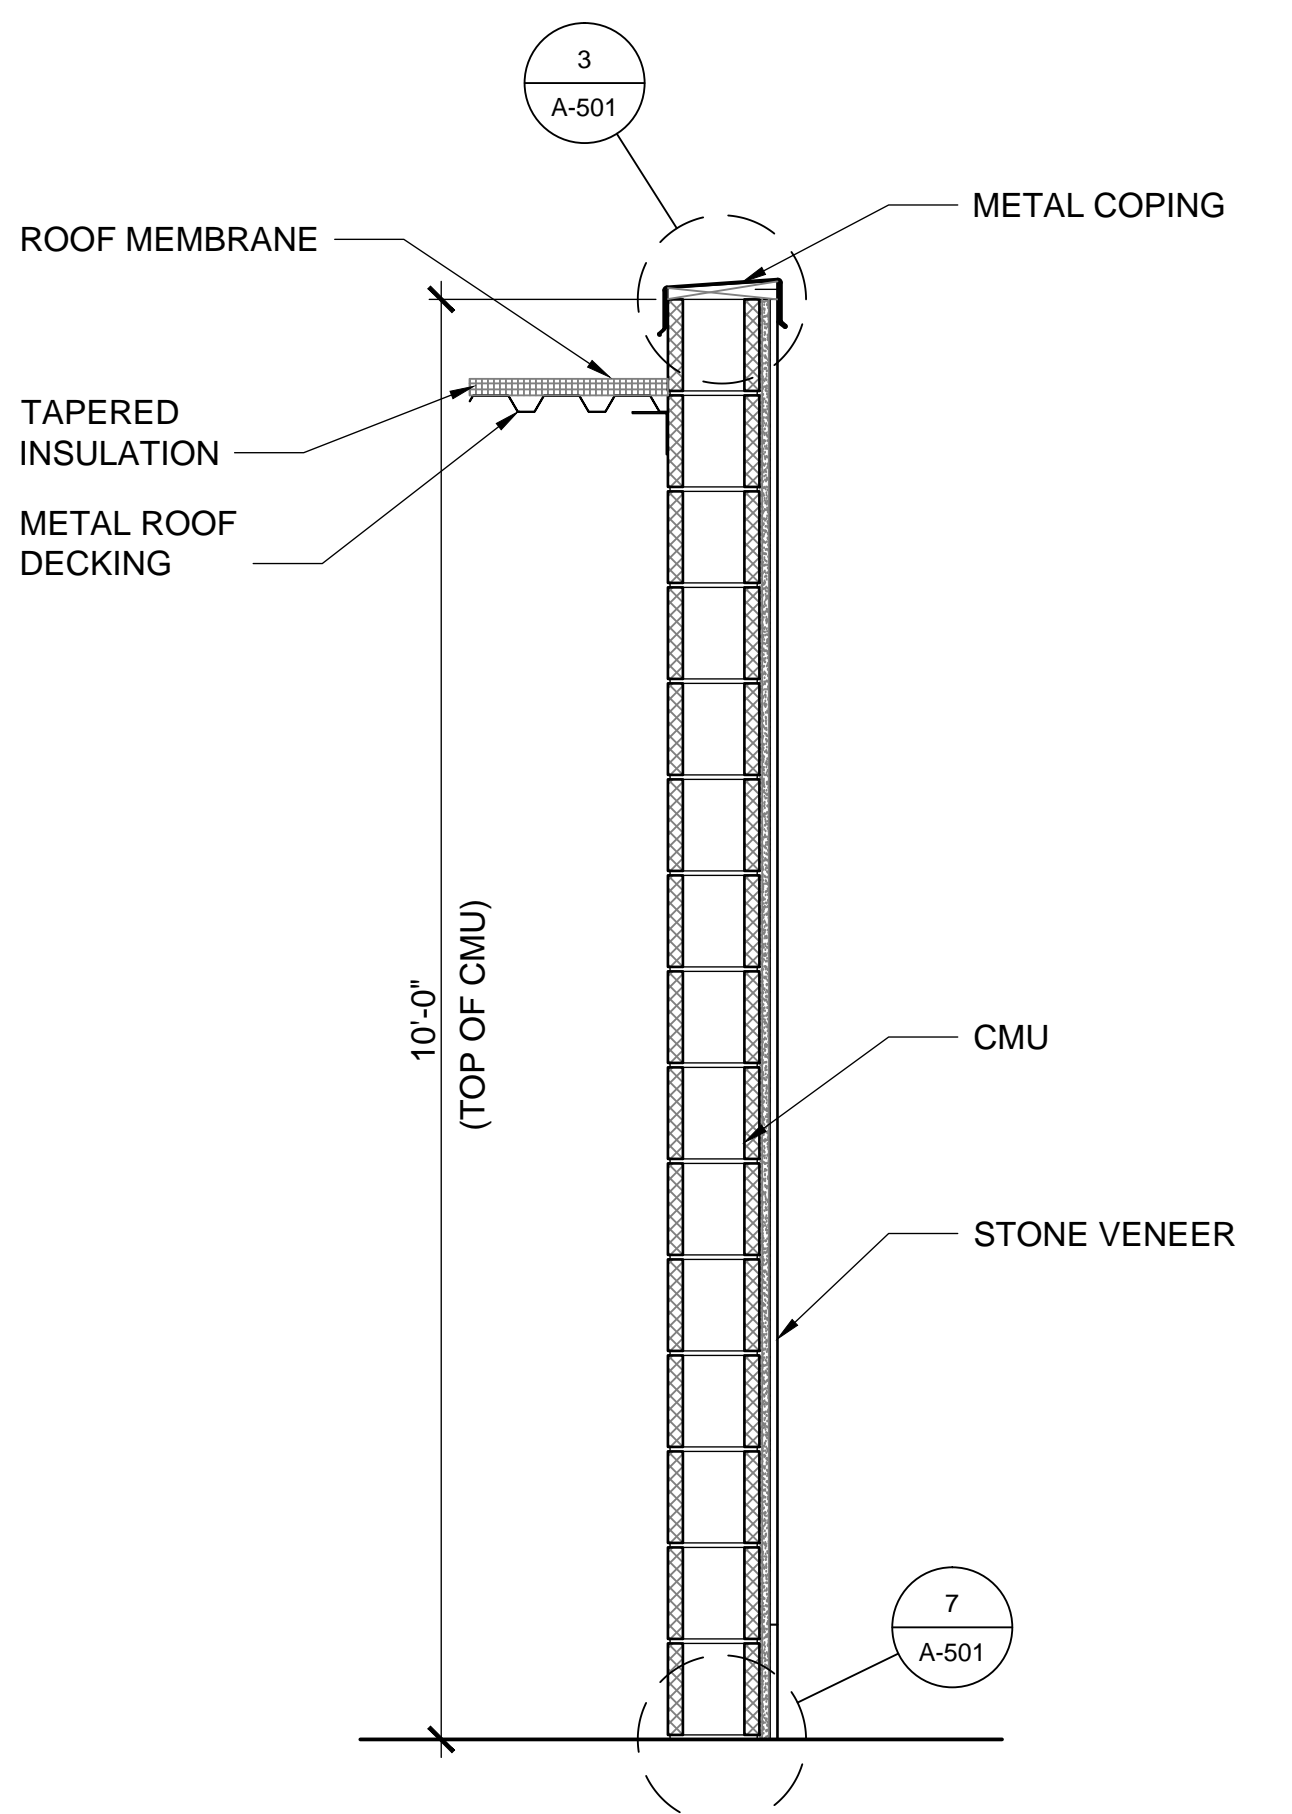


2 WALL SECTION @ STORAGE ROOM
SCALE: 3/4" = 1'-0"

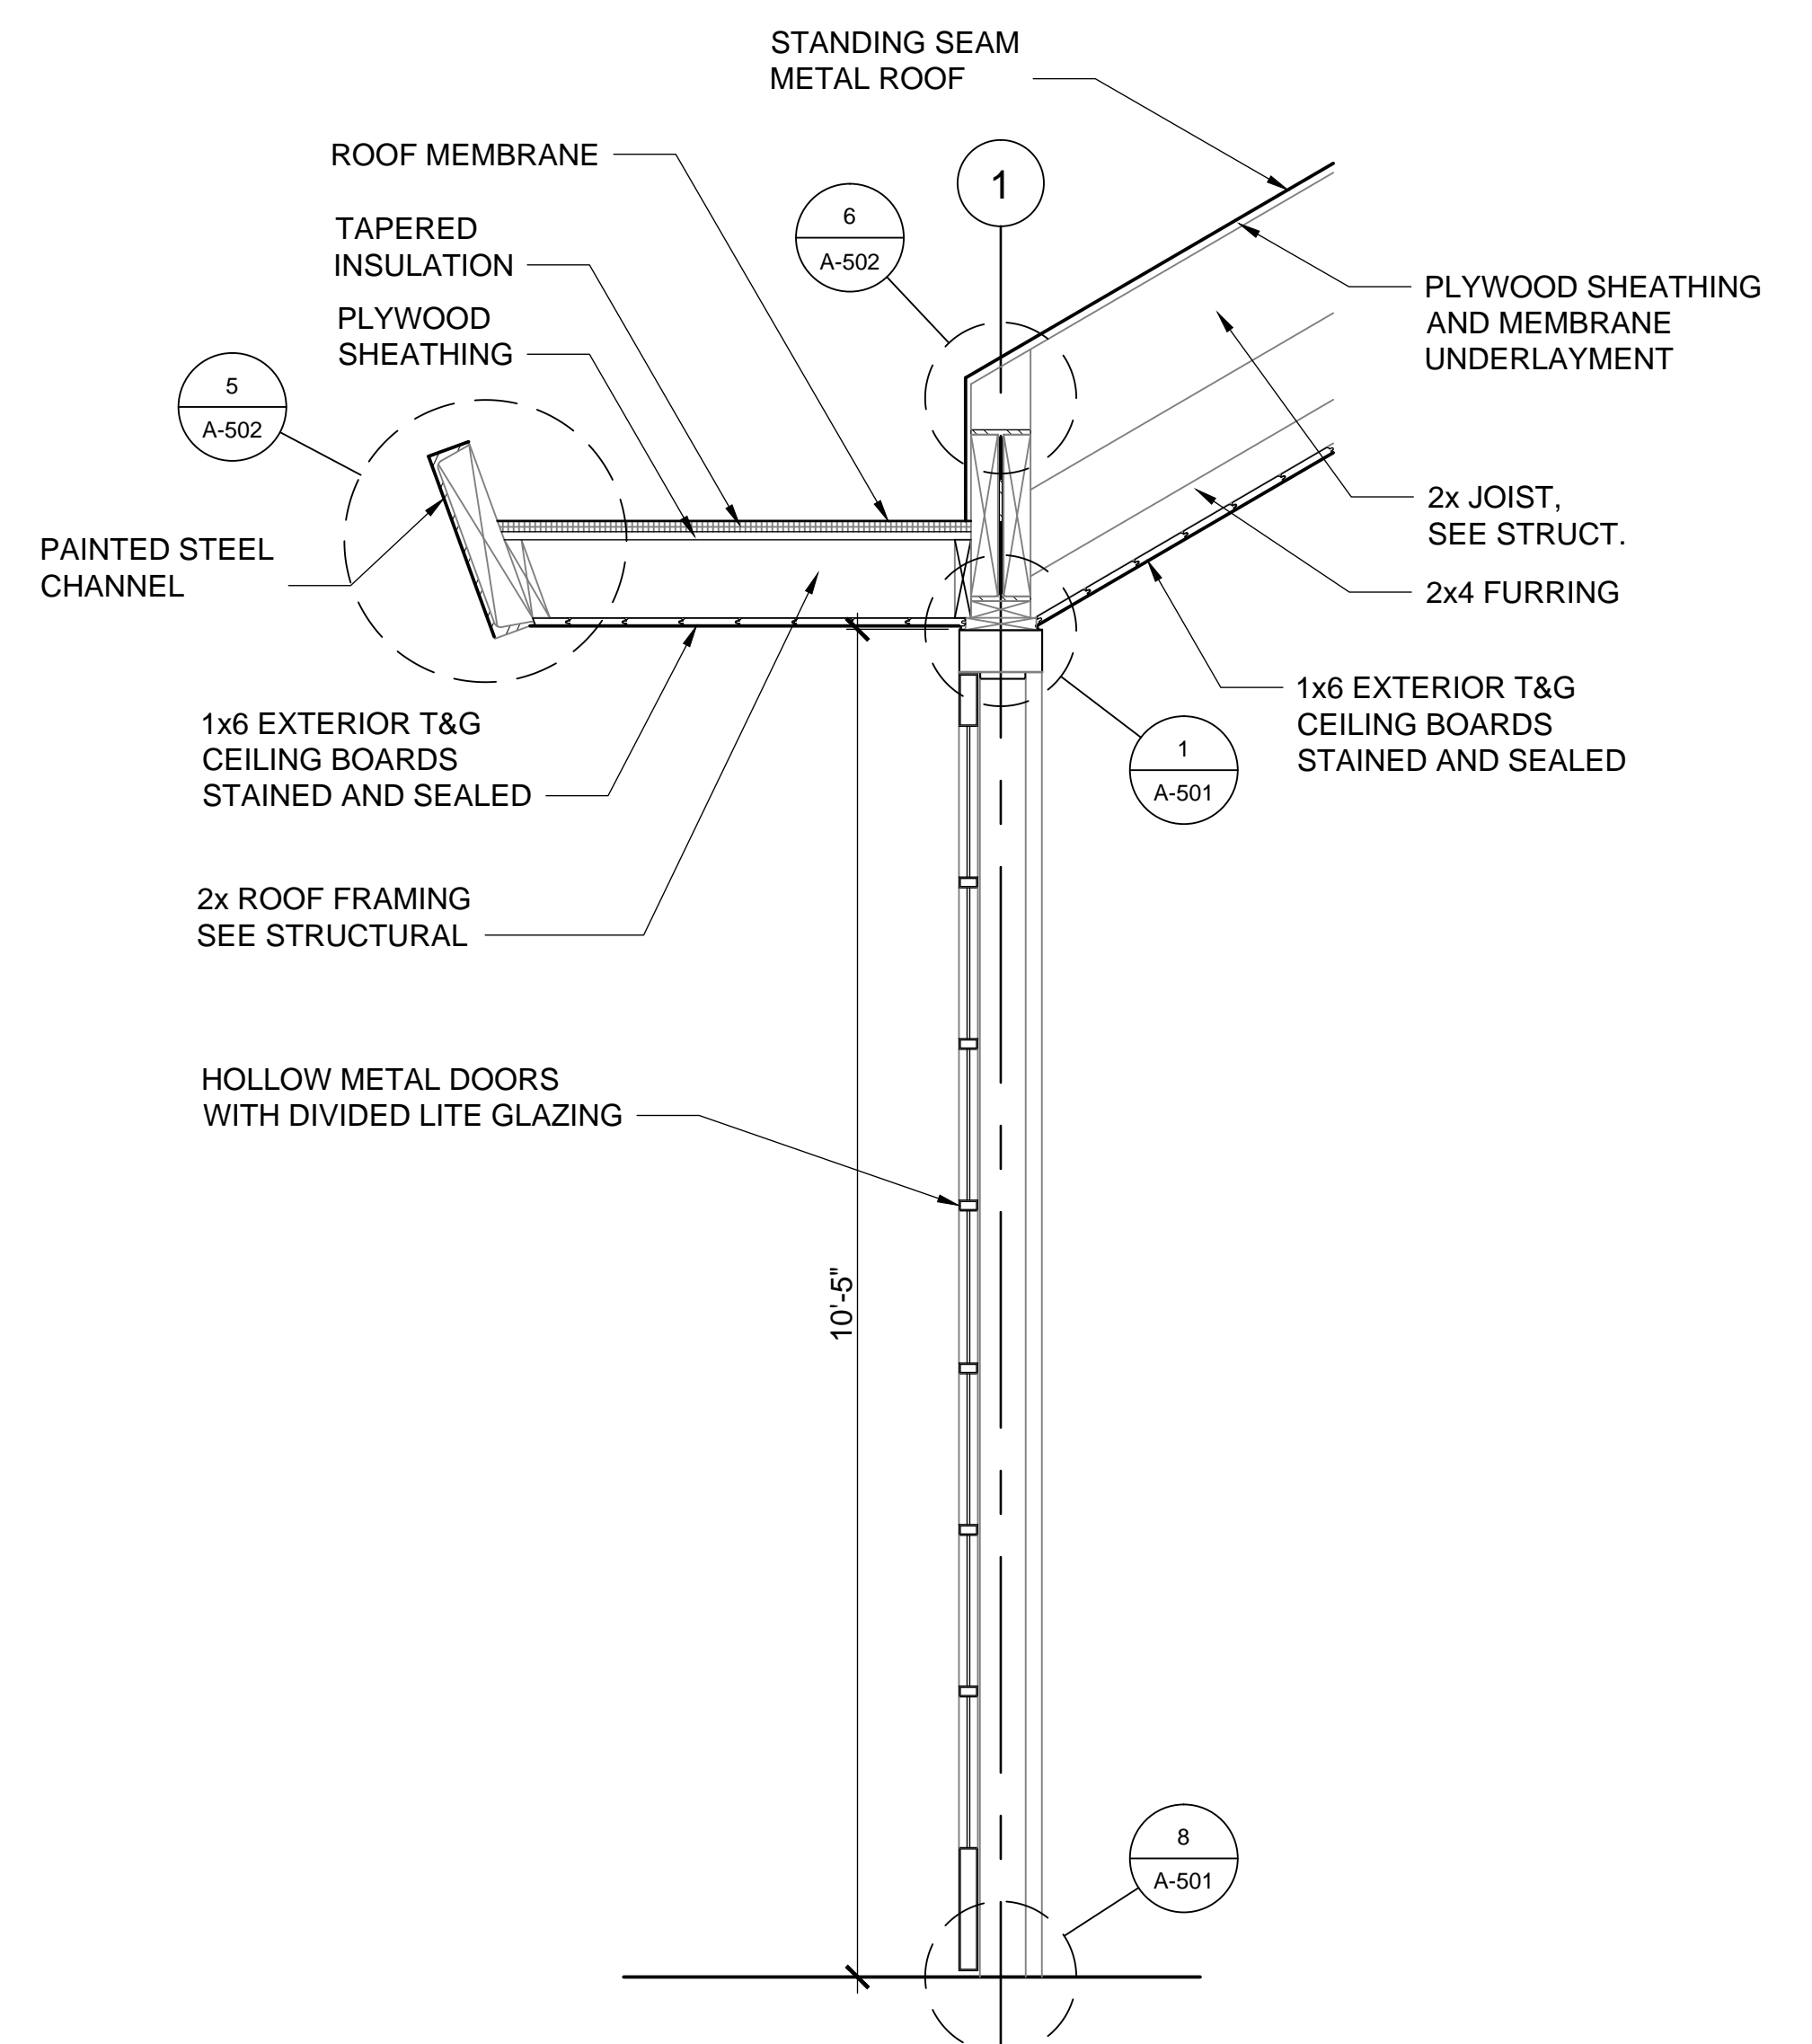


3 WALL SECTION @ HOLLOW METAL DOOR
SCALE: 3/4" = 1'-0"

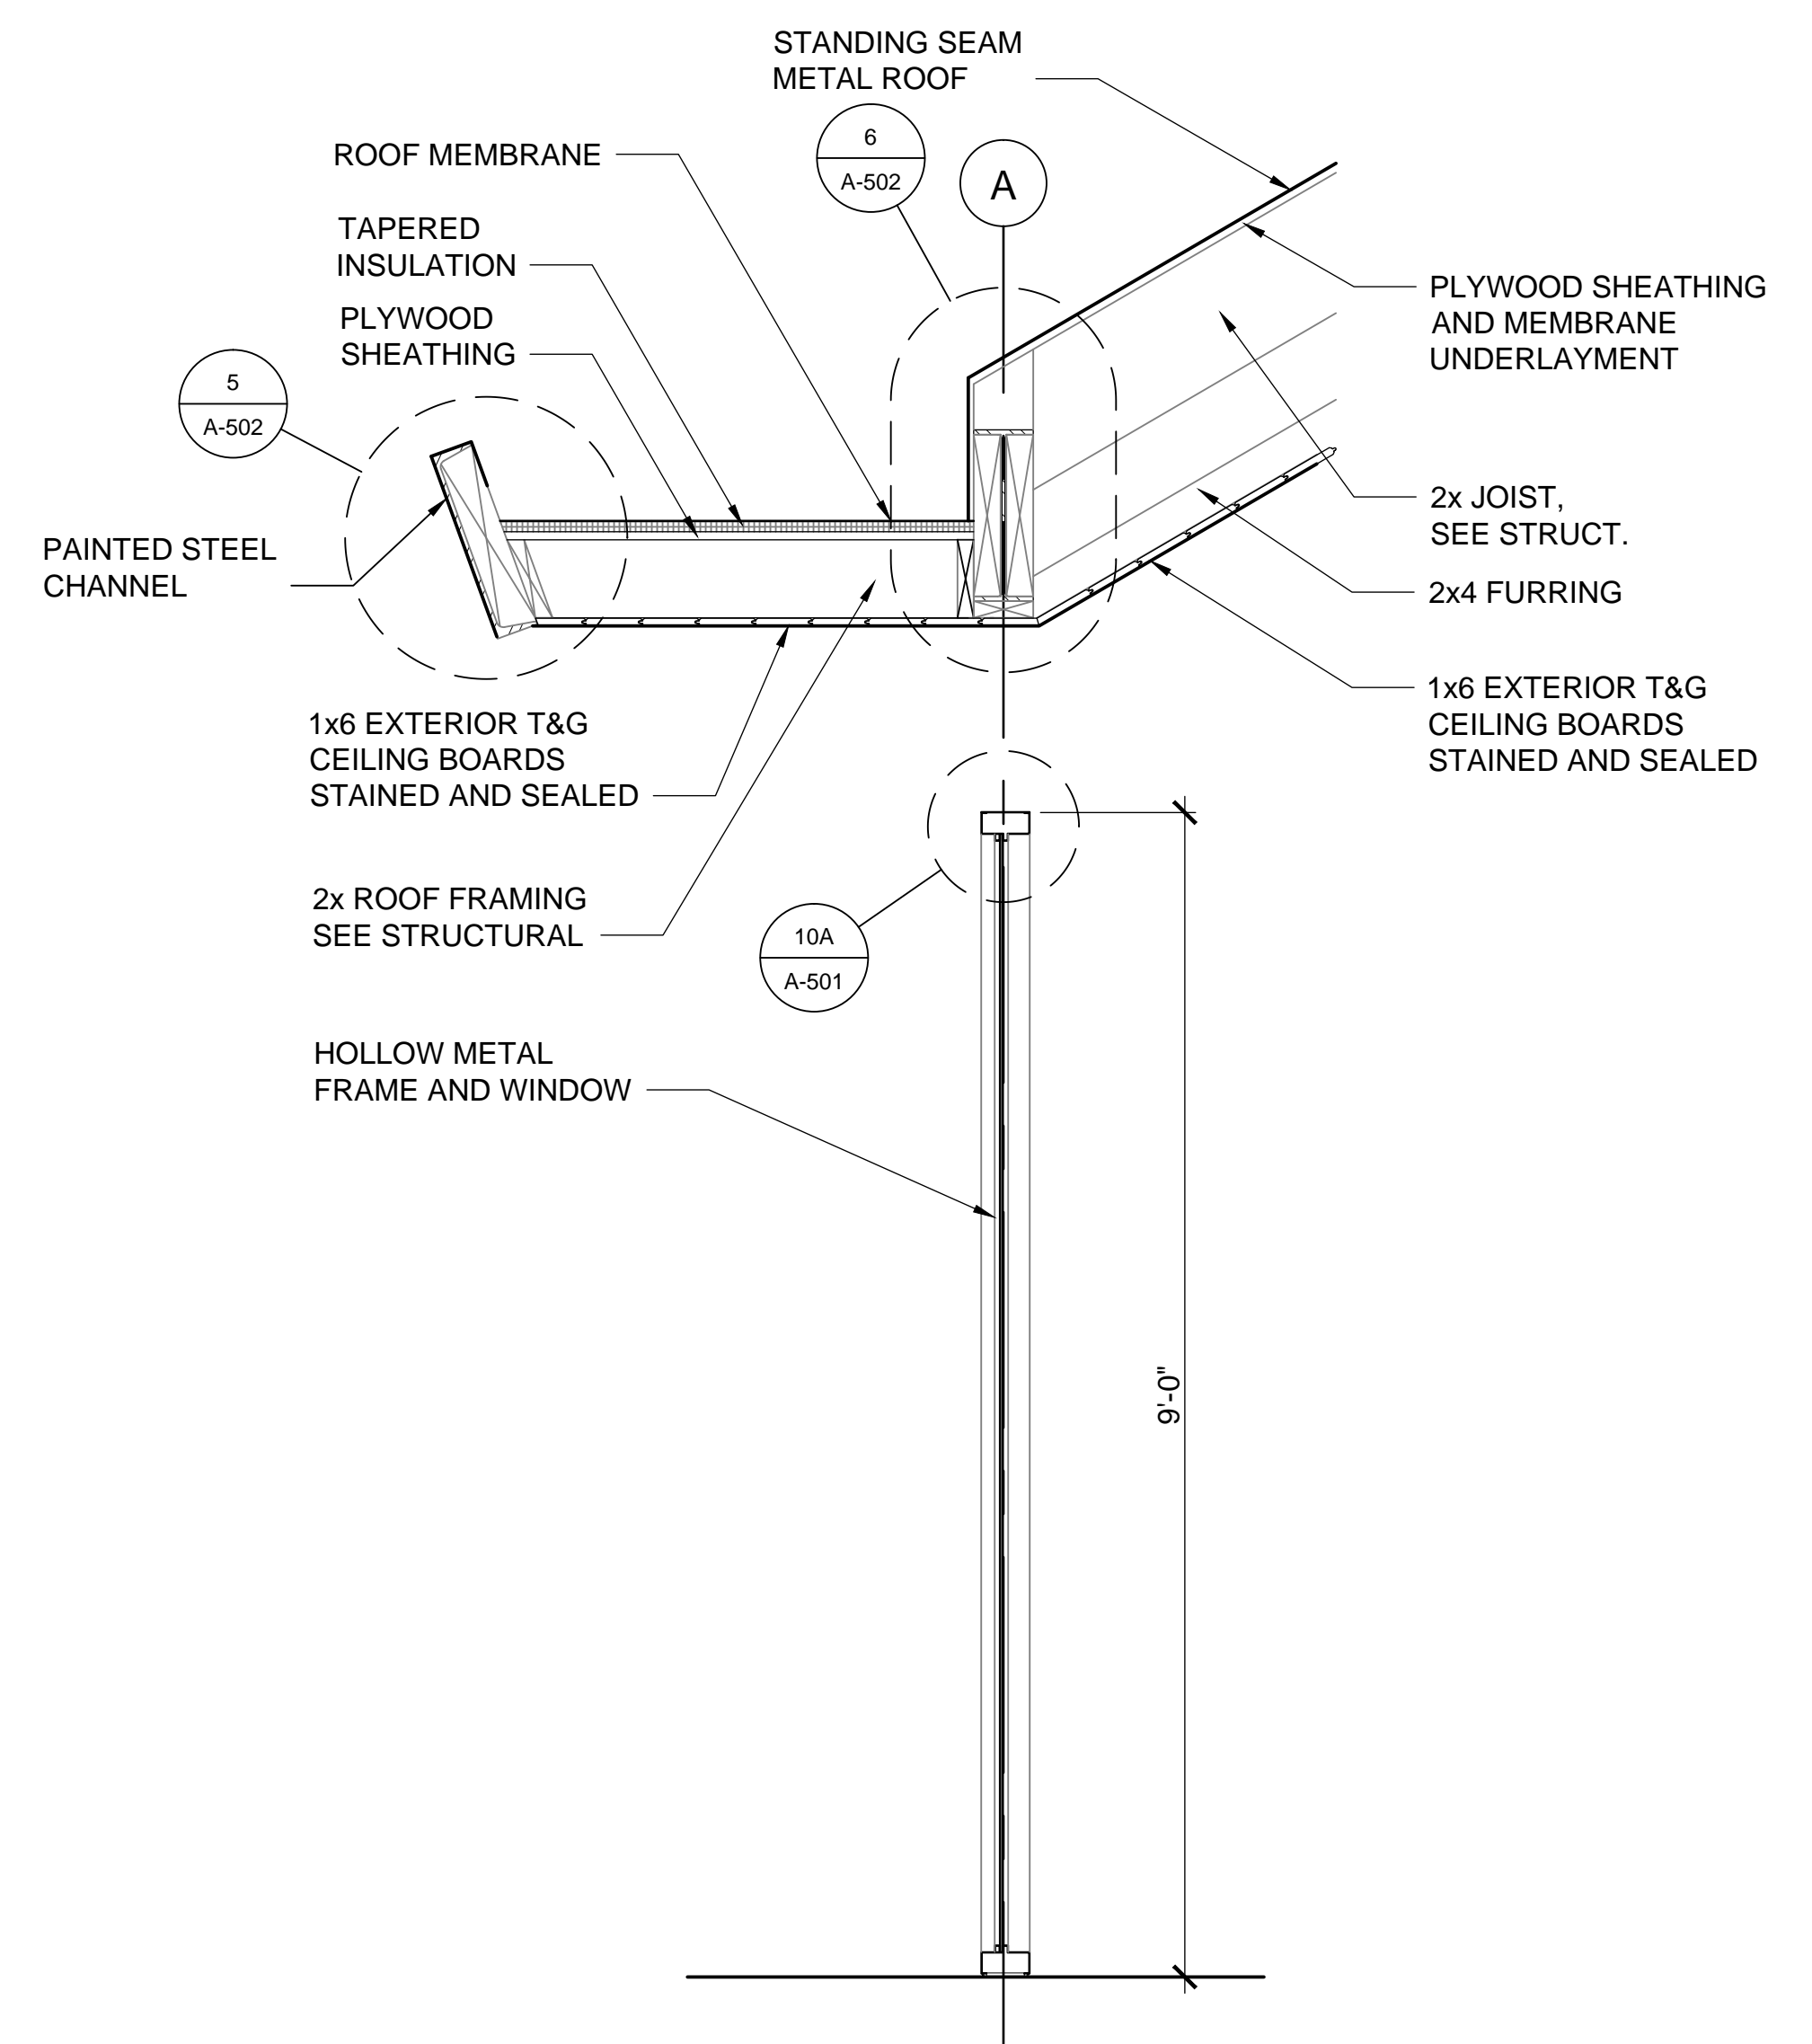

4 WALL SECTION @ HOLLOW METAL WINDOW
SCALE: 3/4" = 1'-0"



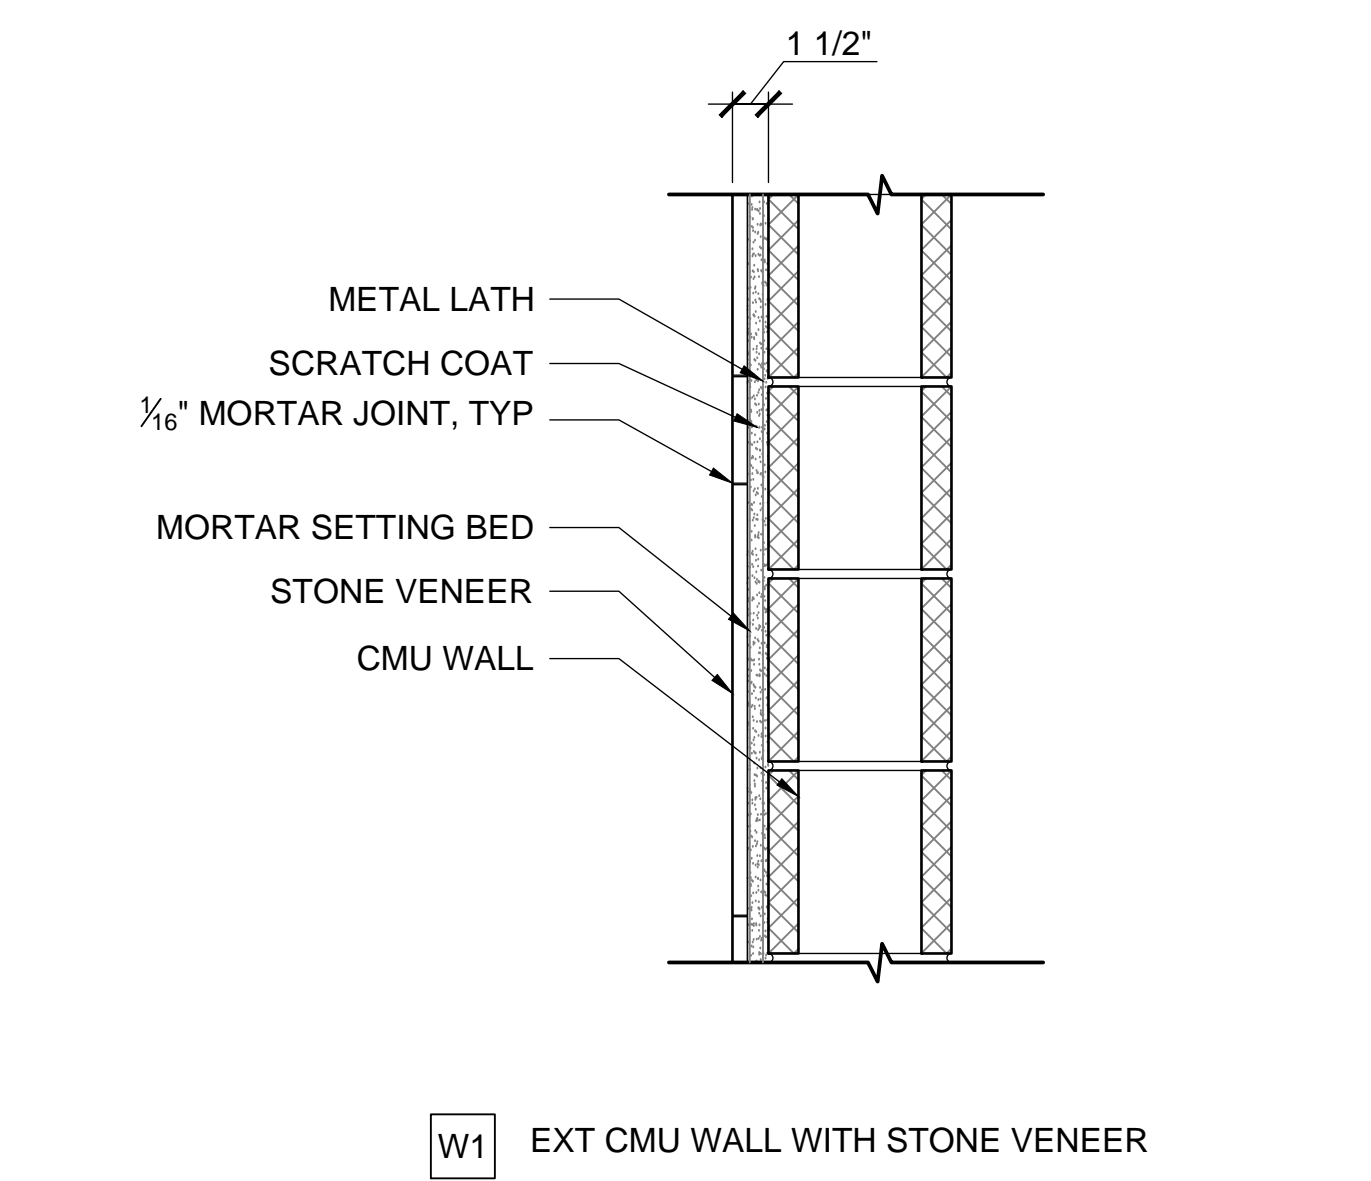


5 WALL TYPE
SCALE: 1 1/2" = 1'-0"



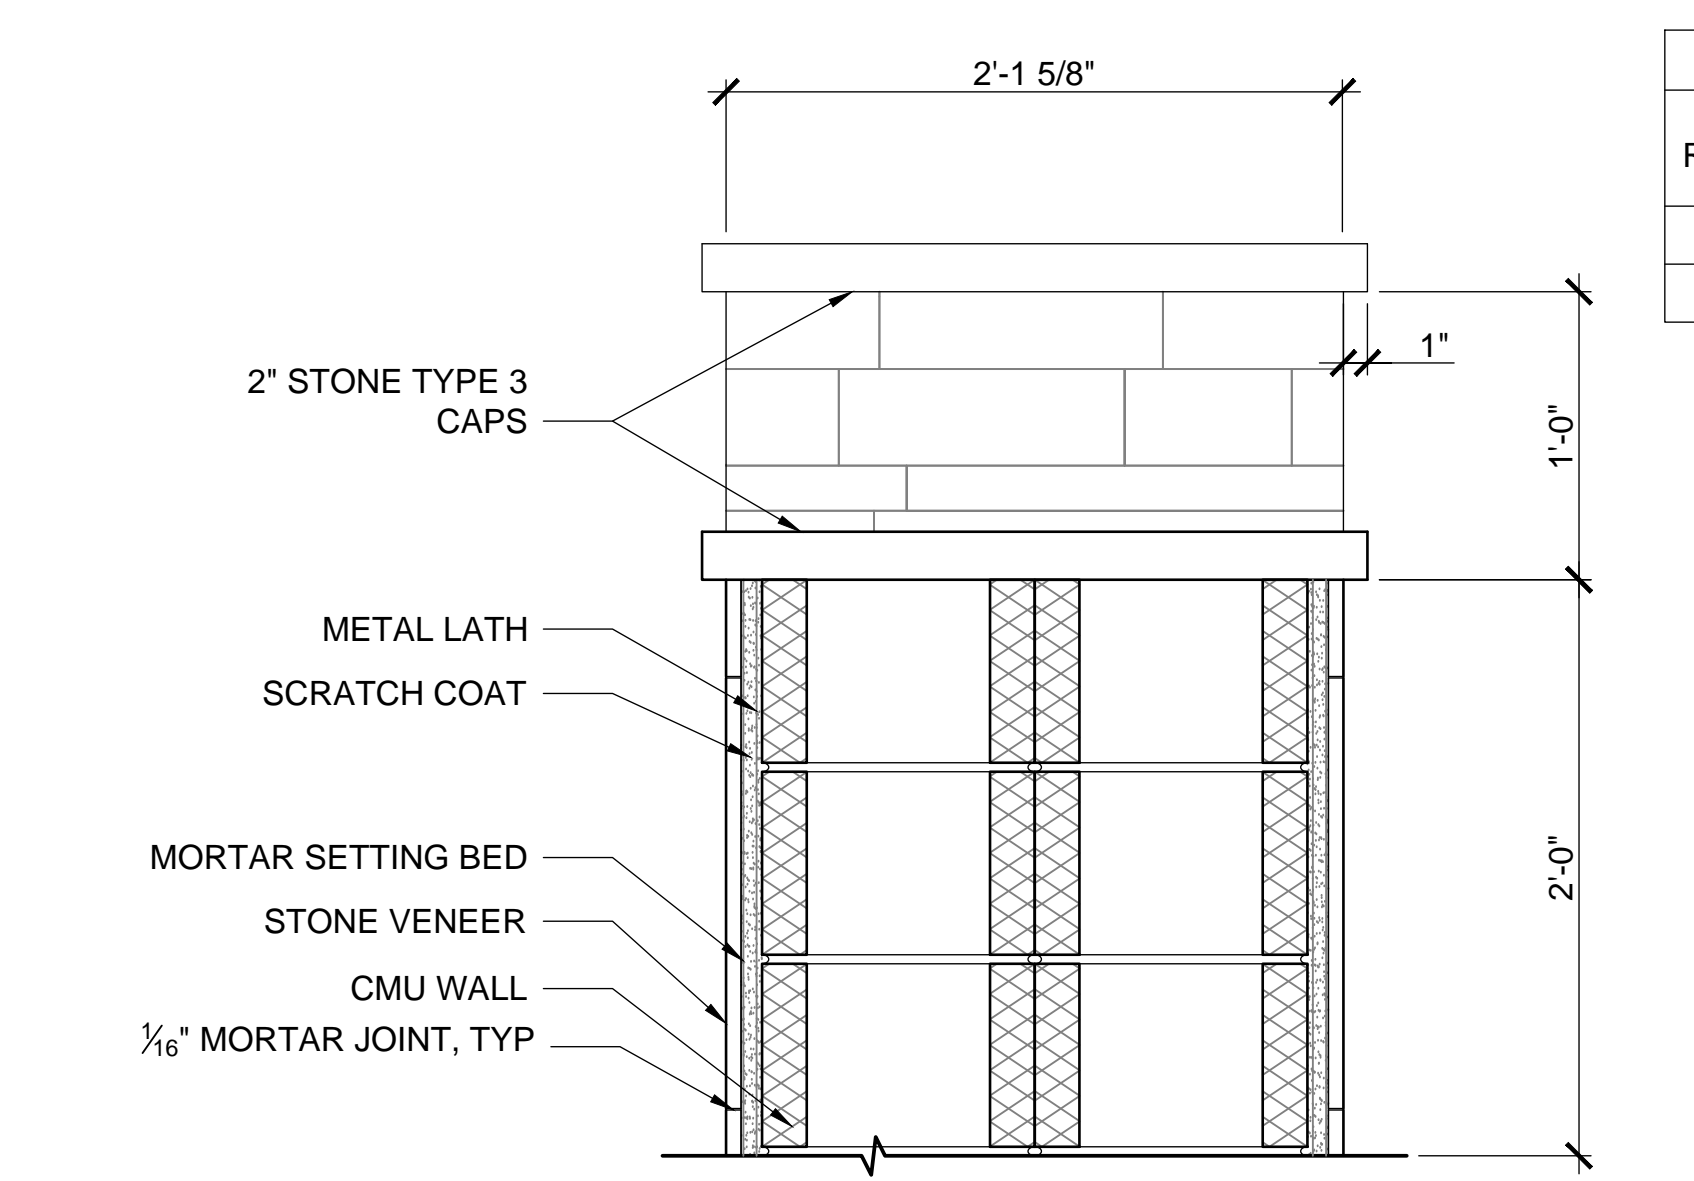


6 SECTION @ BIER
SCALE: 1 1/2" = 1'-0"

ROOM FINISH SCHEDULE														
ROOM NO.	ROOM NAME	FLOOR	BASE	NORTH WALL		EAST WALL		SOUTH WALL		WEST WALL		CEILING		REMARKS
				MATERIAL	FINISH	MATERIAL	FINISH	MATERIAL	FINISH	MATERIAL	FINISH	MATERIAL	FINISH	
101	COMMITTAL SHELTER	CONC	-	H.M. DOORS	PT	-	-	H.M. DOORS	PT	STONE	-	WD	STAIN AND SEAL	
102	STORAGE	CONC	-	CMU	-	CMU	-	CMU	-	CMU	-	STL DECK	-	

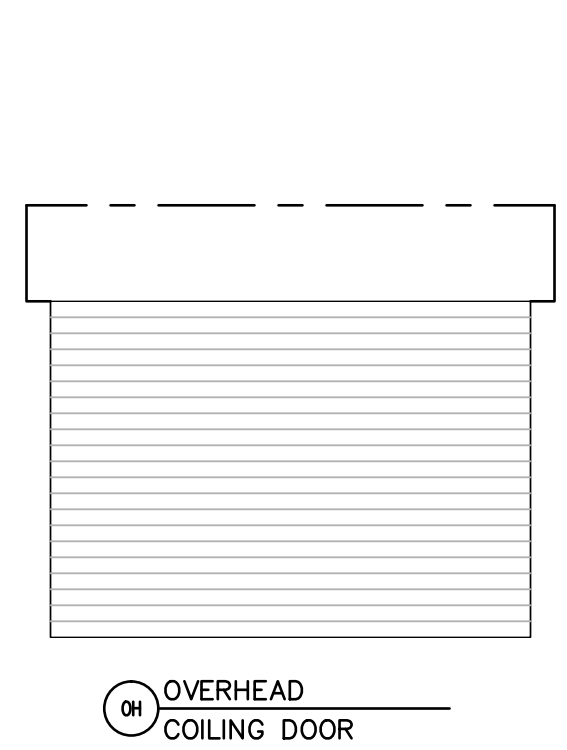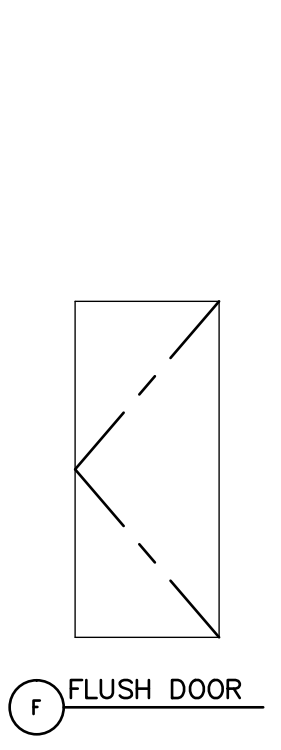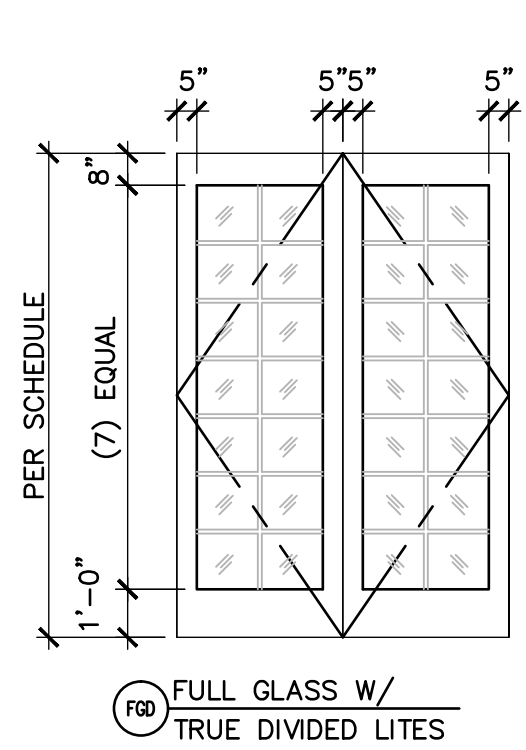


7 DOOR TYPES
SCALE: 1/4" = 1'-0"

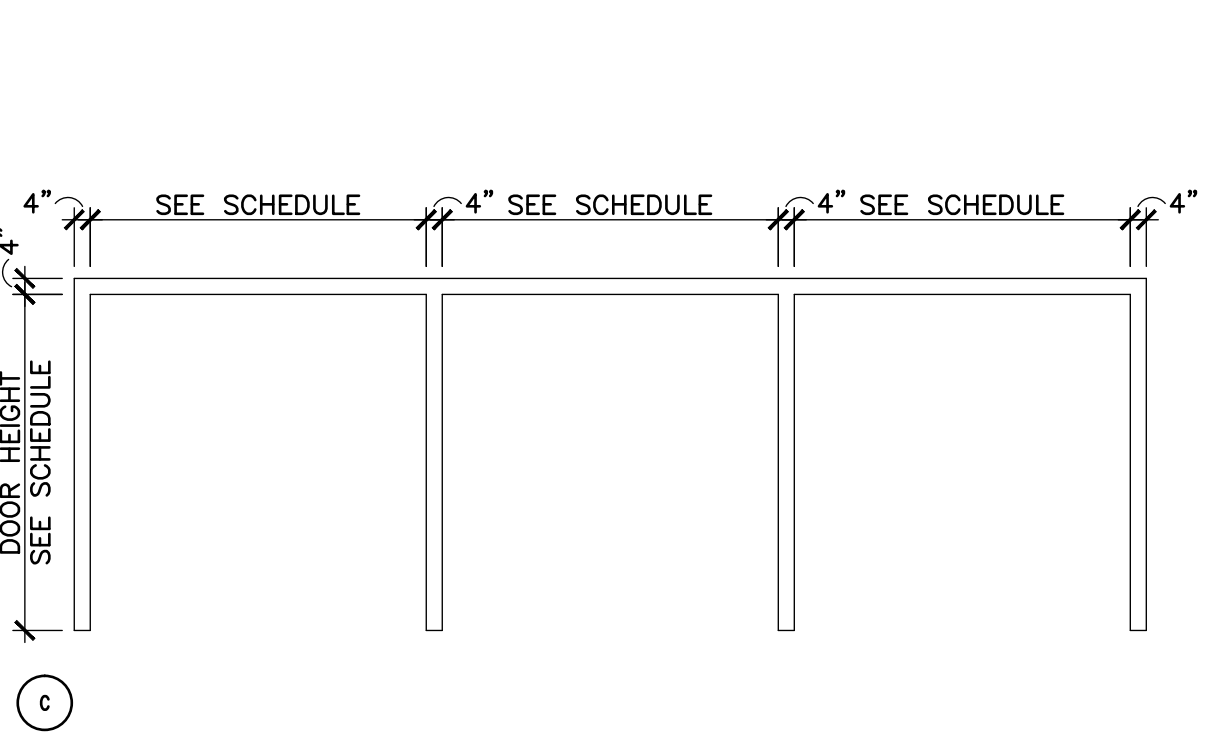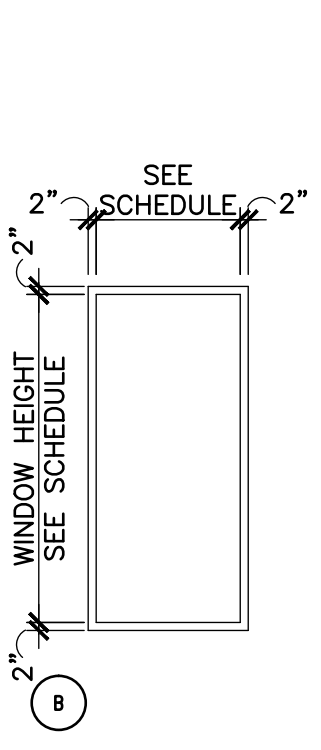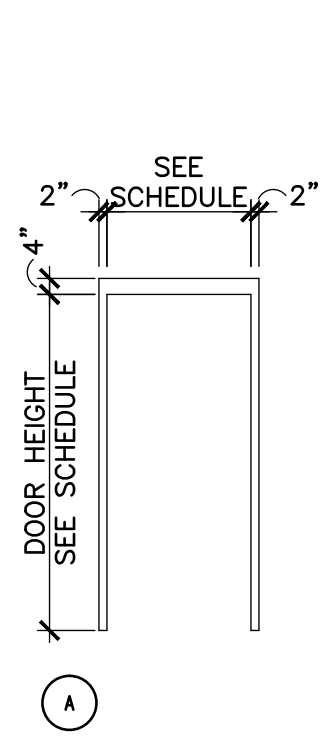


8 H.M. FRAME TYPES
SCALE: 1/4" = 1'-0"


OPENING SCHEDULE												
OPENING NUMBER	DOOR TYPE	WIDTH	HEIGHT	THICKNESS	MATERIAL	FIRE RATING	FRAME TYPE	FRAME MATERIAL	HARDWARE	HEAD / JAMB / SILL DETAILS / COMMENTS		
101A	FGD PAIR	6'-11"	10'-1"	1 3/4"	HM	--	C	HM	SET 01	1/A-501 / 5/A-501 / 8/A-501		
101B	FGD PAIR	6'-11"	10'-1"	1 3/4"	HM	--	C	HM	SET 01	1/A-501 / 5/A-501 / 8/A-501		
101C	FGD PAIR	6'-11"	10'-1"	1 3/4"	HM	--	C	HM	SET 01	1/A-501 / 5/A-501 / 8/A-501		
101D	FGD PAIR	6'-11"	10'-1"	1 3/4"	HM	--	C	HM	SET 01	1/A-501 / 5/A-501 / 8/A-501		
101E	FGD PAIR	6'-11"	10'-1"	1 3/4"	HM	--	C	HM	SET 01	1/A-501 / 5/A-501 / 8/A-501		
101F	FGD PAIR	6'-11"	10'-1"	1 3/4"	HM	--	C	HM	SET 01	1/A-501 / 5/A-501 / 8/A-501		
102A	F	3'-0"	7'-0"	1 3/4"	HM	--	A	HM	SET 02	2/A-501 / 5/A-501 / 9/A-501		
102B	OH	10'-0"	7'-0"	--	--	--	--	HM	--	11/A-501 / 12/A-501		
103	--	2'-2"	9'-0"	--	HM	--	B	HM	--	10A/A-501 / 10B/A-501		
104	--	2'-2"	9'-0"	--	HM	--	B	HM	--	10A/A-501 / 10B/A-501		

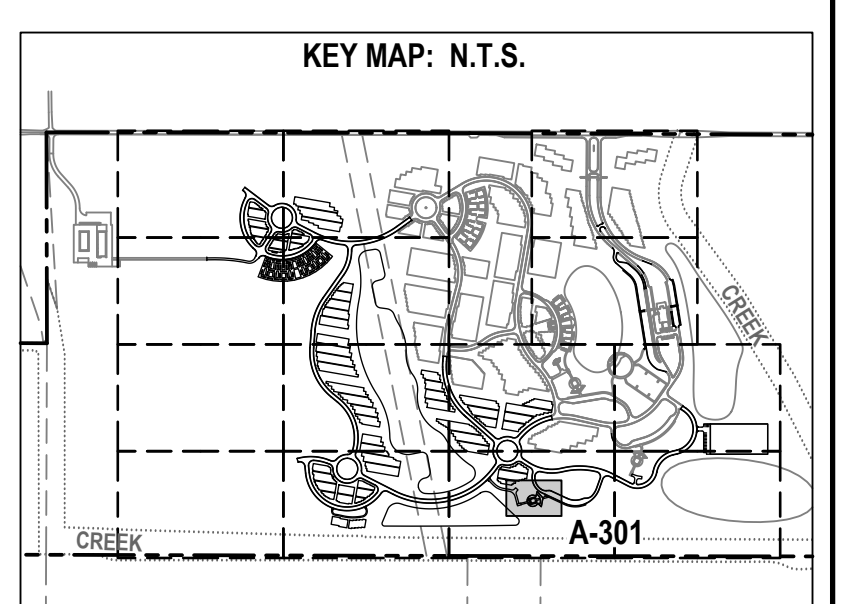



CONSULTANTS Structural Engineering, Electrical Engineering: HDR Engineering, Inc. 2365 Iron Point Rd. #500 Folsom, CA 95630 (916)-817-4924 Duane Hodgins Irrigation: Aqua Engineering, Inc. 375 Horseshoe Rd., Bldg. 2-202 Fort Collins, CO 80525 (970)-372-6104 Robert Beccard Cost Estimating: CPMI, Inc. 3265 Northwood Cir., Ste. 170 Eagan, MN 55121 (952)-854-3663 Bryan Bertrand Geotechnical Engineering: Terracon Consultants, Inc. 50 Goldenland Ct., Ste. 100 Sacramento, CA 95834 (916)-928-4690 Robert Holmer	ARCHITECT/ENGINEER OF RECORD Project Management, Architecture, Landscape Architecture, Cemetery Planning, Civil Engineering, Land Survey: Anderson Engineering of MN, LLC 13605 1st Ave. N., Ste. 100 Plymouth, MN 55441 (763)-412-4000 Michael Brandvold, Project Manager ANDERSON ENGINEERING ENGINEERING • ARCHITECTURE • LAND SURVEYING ENVIRONMENTAL SERVICES • LANDSCAPE ARCHITECTURE	STAMP Professional Engineer ROGER A. ANDERSON C 80261 EXP. 9-30-18 06/27/2018 STATE OF CALIFORNIA	Office of Construction and Facilities Management VA U.S. Department of Veterans Affairs	Drawing Title BUILDING 4803 SECTIONS Approved: Project Director	Phase BID DOCUMENTS	Project Title Sacramento Valley National Cemetery Phase 2 Development Location 5810 Midway Rd, Dixon, CA 95620 Issue Date JUNE 27, 2018 Checked BB Drawn WLC	Project Number 921CM2007 Building Number 4803 Drawing Number A-301 240 OF 262
-----------------------------------------------------------------------------------------------------------------------------------------------------------------------------------------------------------------------------------------------------------------------------------------------------------------------------------------------------------------------------------------------------------------------------------------------------------------------------------------------------------------------------------------------------------------------------------------------------------	-----------------------------------------------------------------------------------------------------------------------------------------------------------------------------------------------------------------------------------------------------------------------------------------------------------------------------------------------------------------------------------------------------------------------------------------	----------------------------------------------------------------------------------------------------------------------------	---------------------------------------------------------------------------------------------------	-------------------------------------------------------------------------------------	-------------------------------	-------------------------------------------------------------------------------------------------------------------------------------------------------------------------------------------------------------------------------	----------------------------------------------------------------------------------------------------------------------

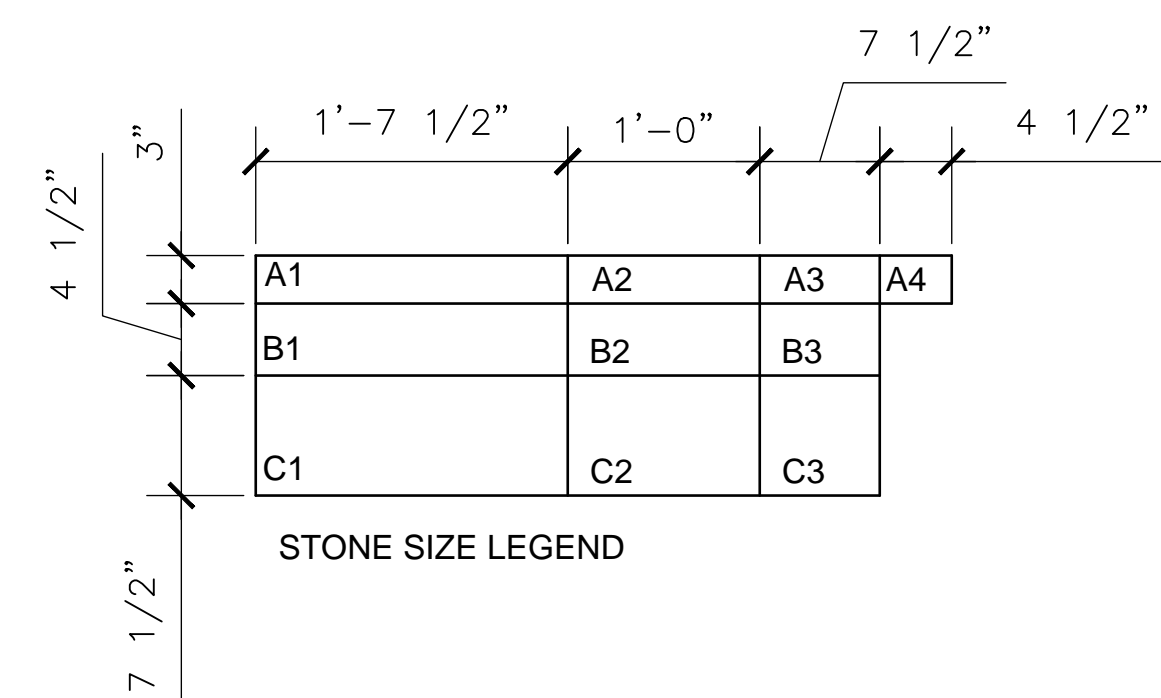

0 1/2' 1' 2'

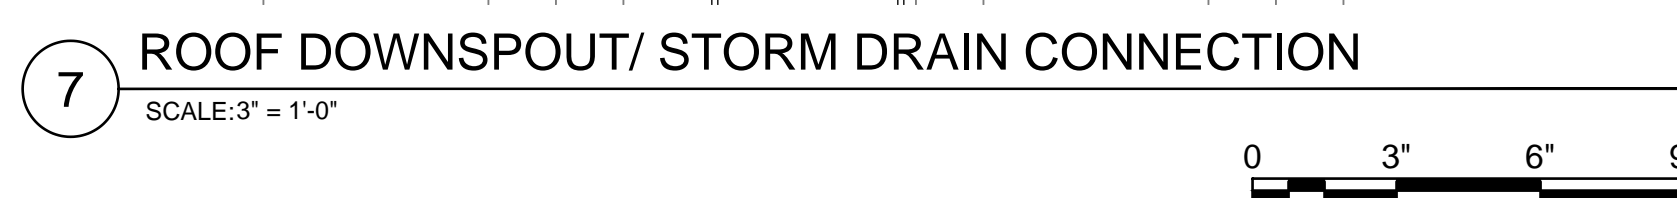

7 ROOF DOWNSPOUT/ STORM DRAIN CONNECTION
SCALE: 3" = 1'-0"

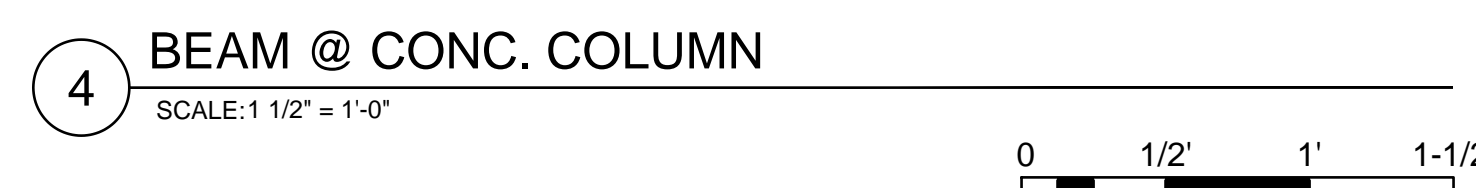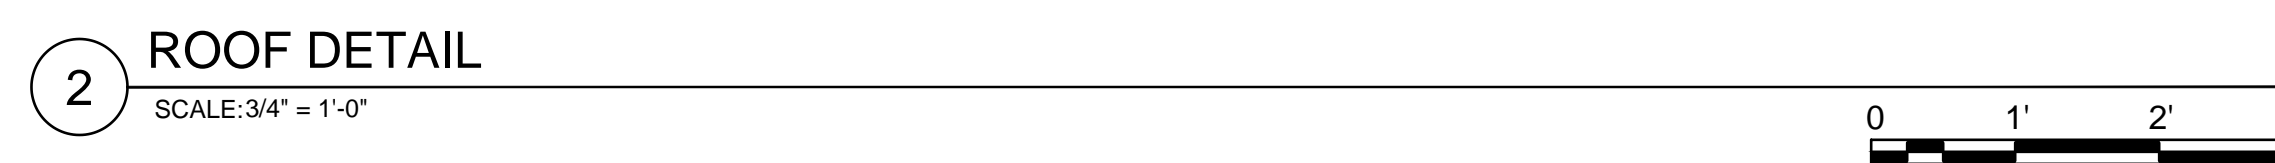


4 BEAM @ CONC. COLUMN

SCALE: 1 1/2" = 1'-0"

0 1/2' 1' 1-1/2'




5 STEEL CHANNEL FASCIA
SCALE: 3" = 1'-0"

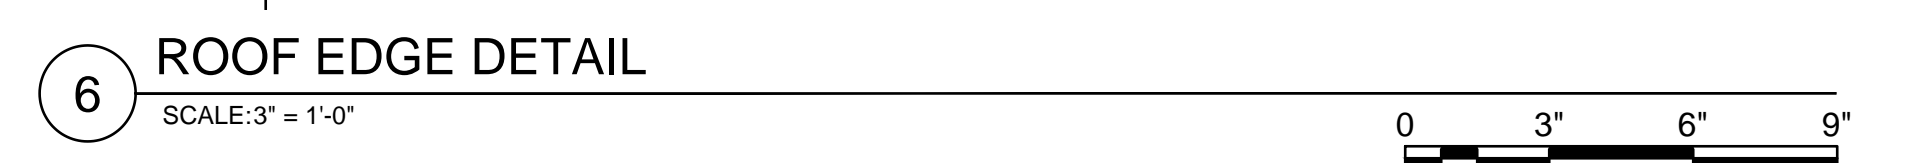

6 ROOF EDGE DETAIL

SCALE: 3" = 1'-0"

0 3' 6' 9'

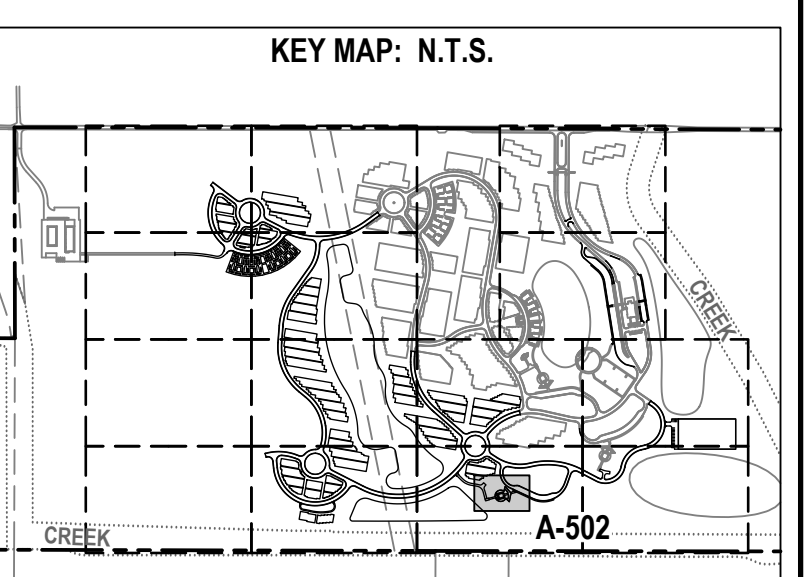[illegible]

