


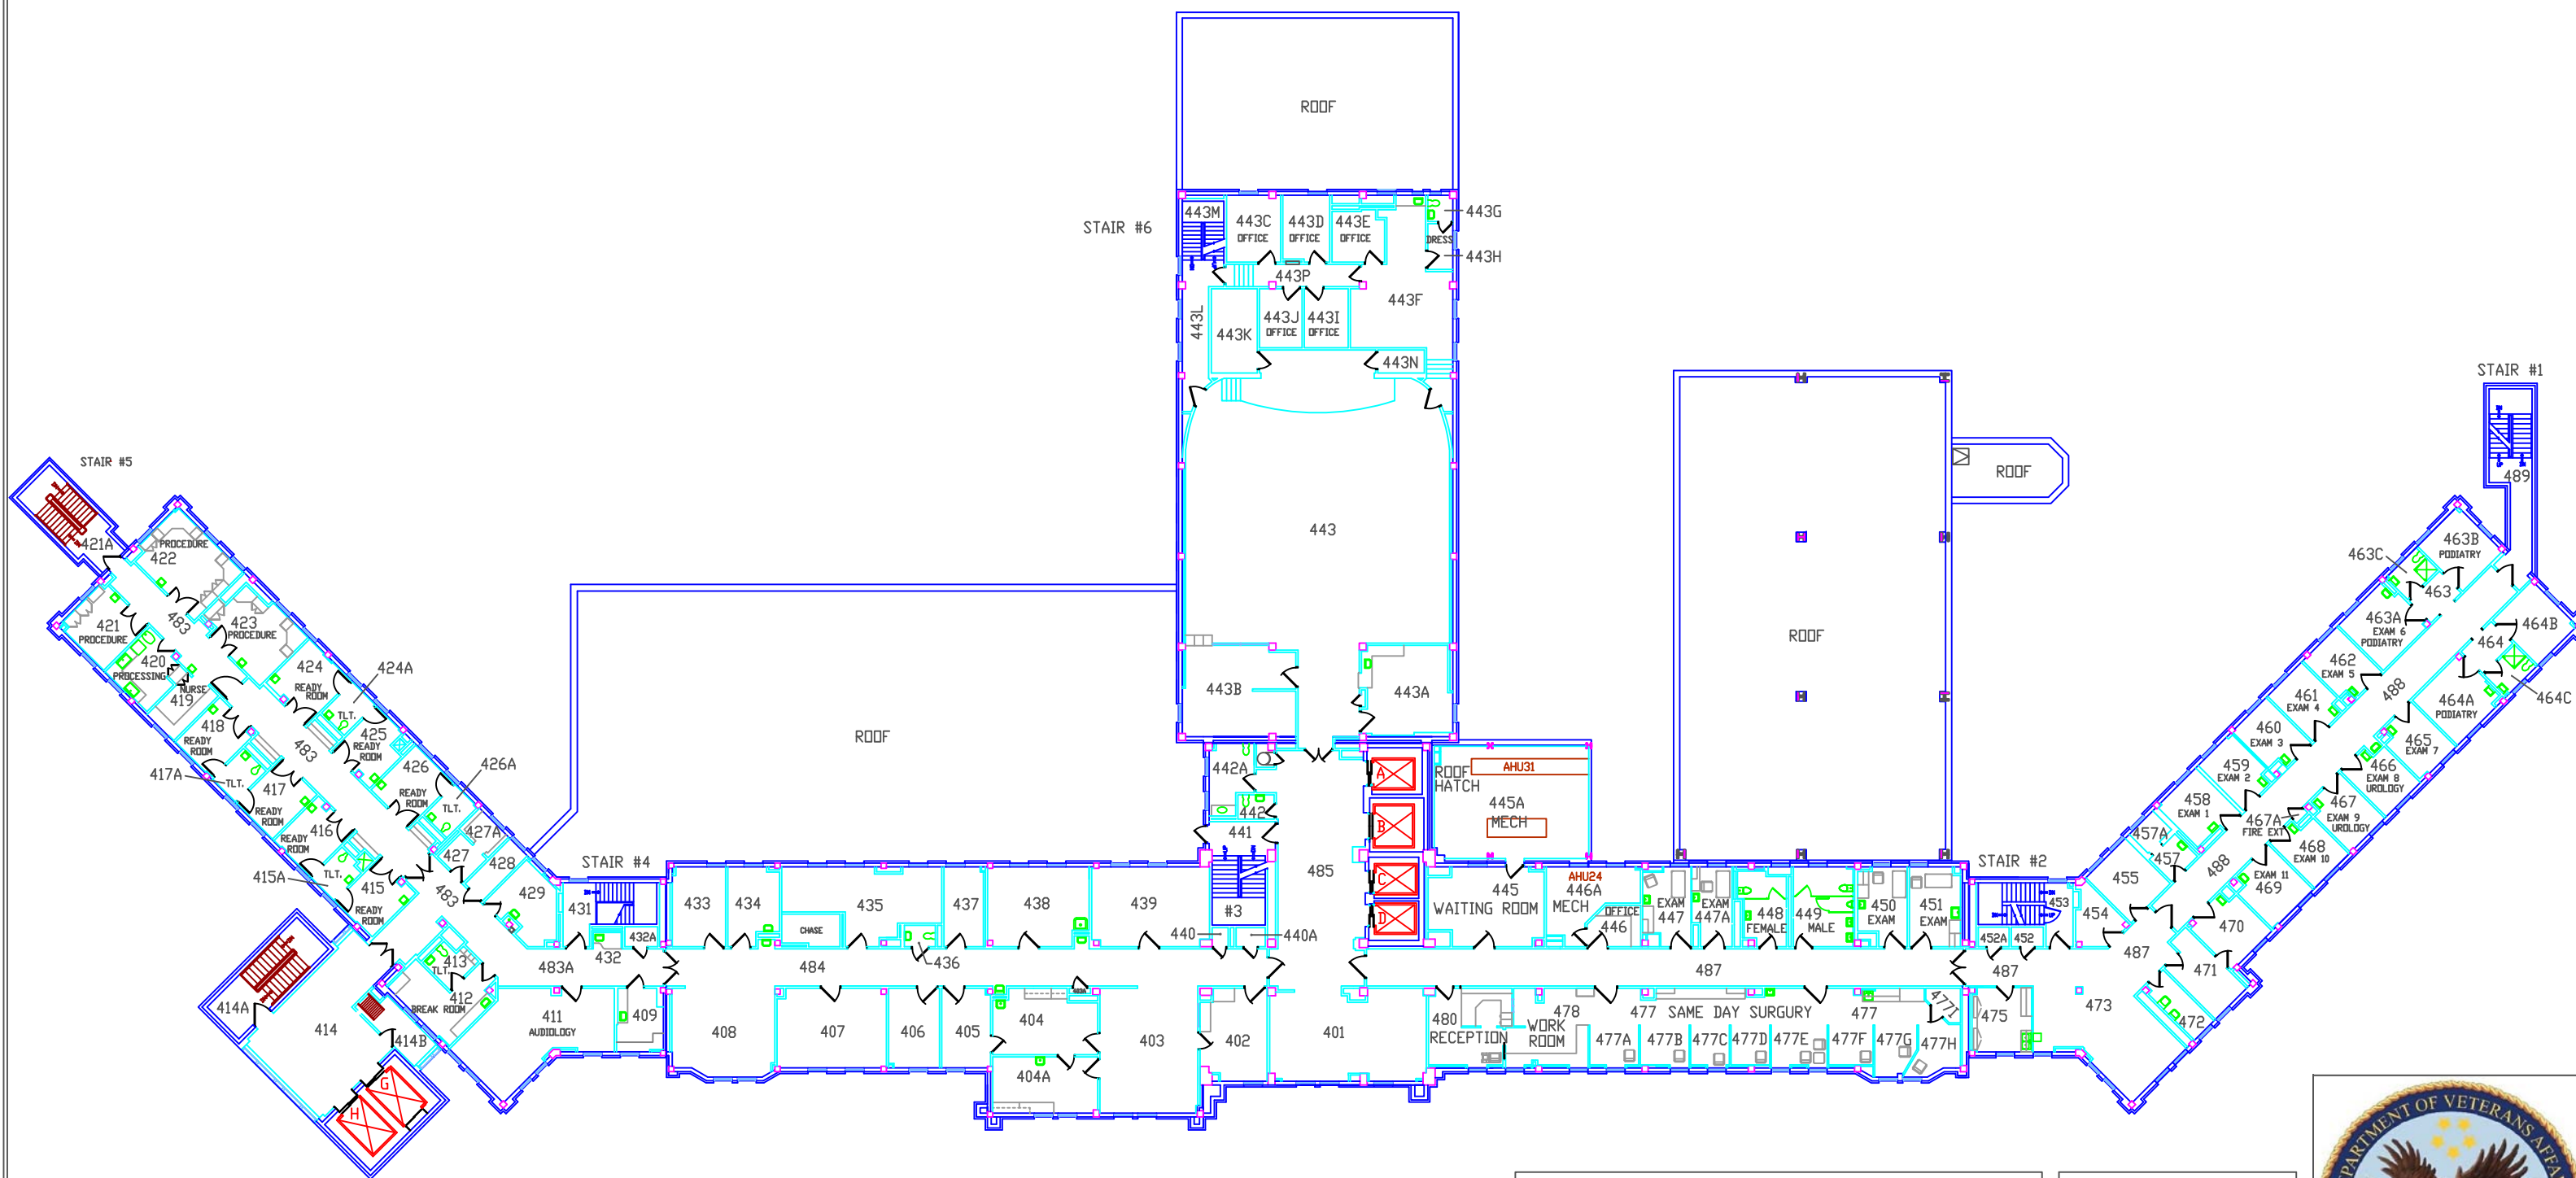

# FOURTH FLOOR PLAN



DRAWING TITLE: FLOOR PLAN BUILDING 5 4TH FLOOR	
LOCATION: SIOUX FALLS VA HEALTH CARE SYSTEM SIOUX FALLS, SOUTH DAKOTA	
REVISION:	DATE:

DRAWING NUMBER: XXX-XXX-XXXX DWG 1 OF 4
DRAWN BY: JDY
DATE: 5-13-2014

