




PENTHOUSE FLOOR PLAN (6TH FLOOR)

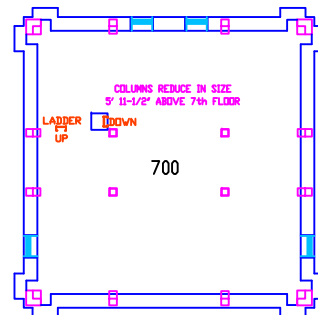


7TH FLOOR PLAN

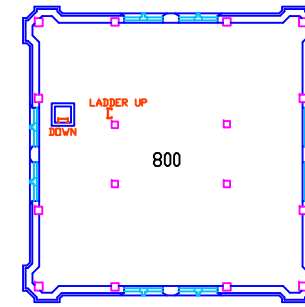

8TH FLOOR PLAN

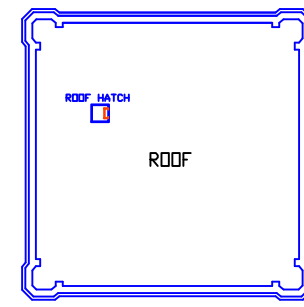

TOWER ROOF PLAN

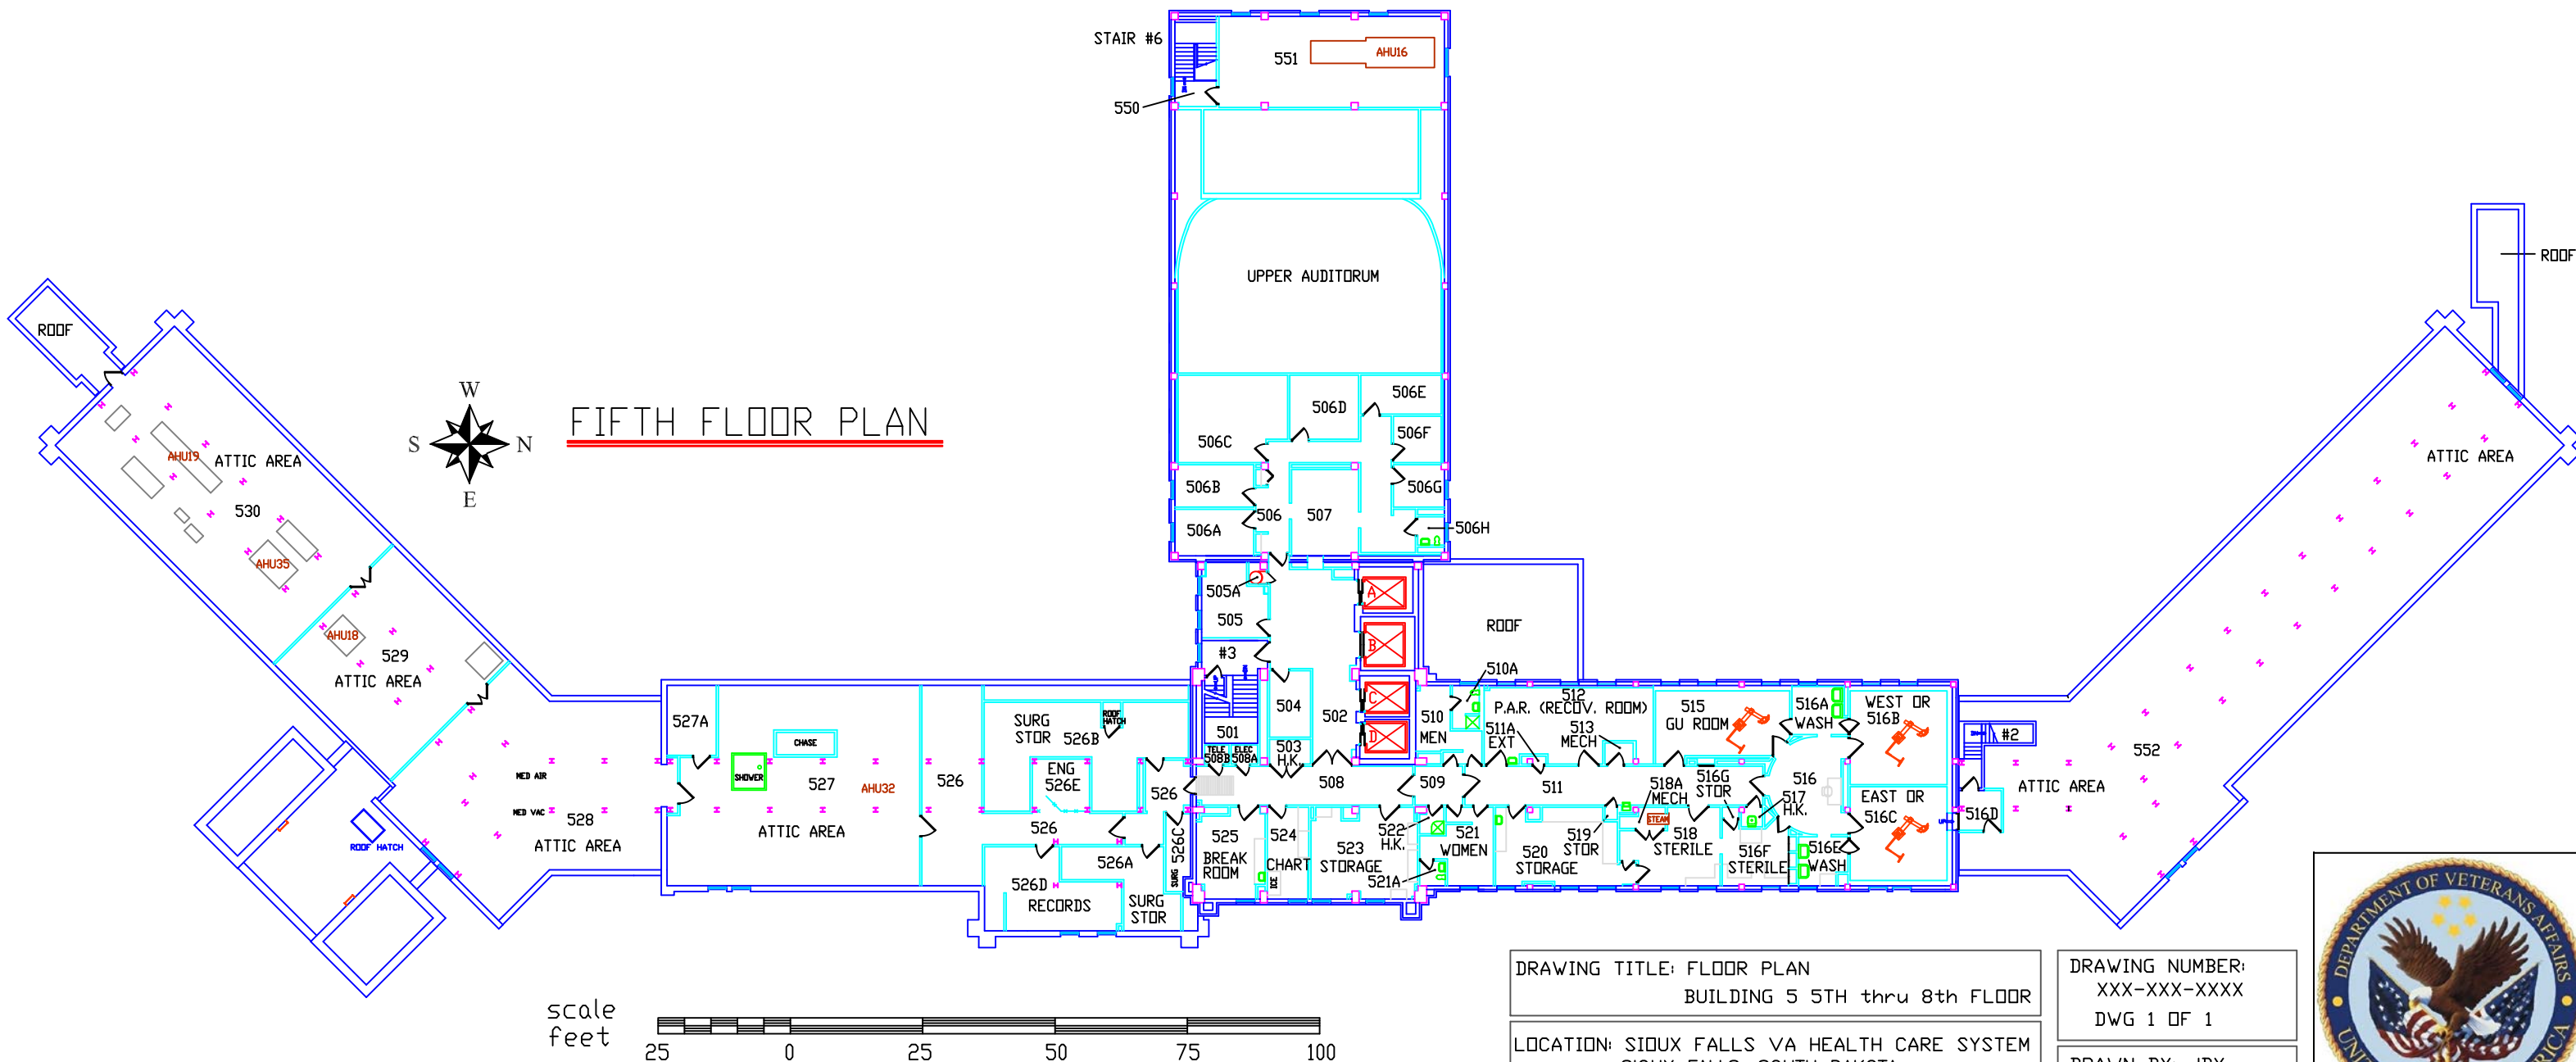

FIFTH FLOOR PLAN

DRAWING TITLE: FLOOR PLAN  
BUILDING 5 5TH thru 8th FLOOR

LOCATION: SIOUX FALLS VA HEALTH CARE SYSTEM  
SIOUX FALLS, SOUTH DAKOTA

REVISION: DATE:

DRAWING NUMBER:  
XXX-XXX-XXXX  
DWG 1 OF 1

DRAWN BY: JDY

DATE: 5-13-2014

