


1 **ROOF PLAN**
0 4" 8" 16"
SCALE: 1/8" = 1'-0"

KEYNOTES THIS DRAWING:

- 1 FOR NEW EXHAUST FAN, IN SPARE SPACE, PROVIDE NEW NEMA SIZE 0 STARTER, 3ØA-3P DISCONNECT SWITCH FUSED AT 6 AMPS AND ALL NECESSARY MOUNTING HARDWARE REQUIRED FOR COMPLETE INSTALLATION WITHIN MOTOR CONTROL CENTER

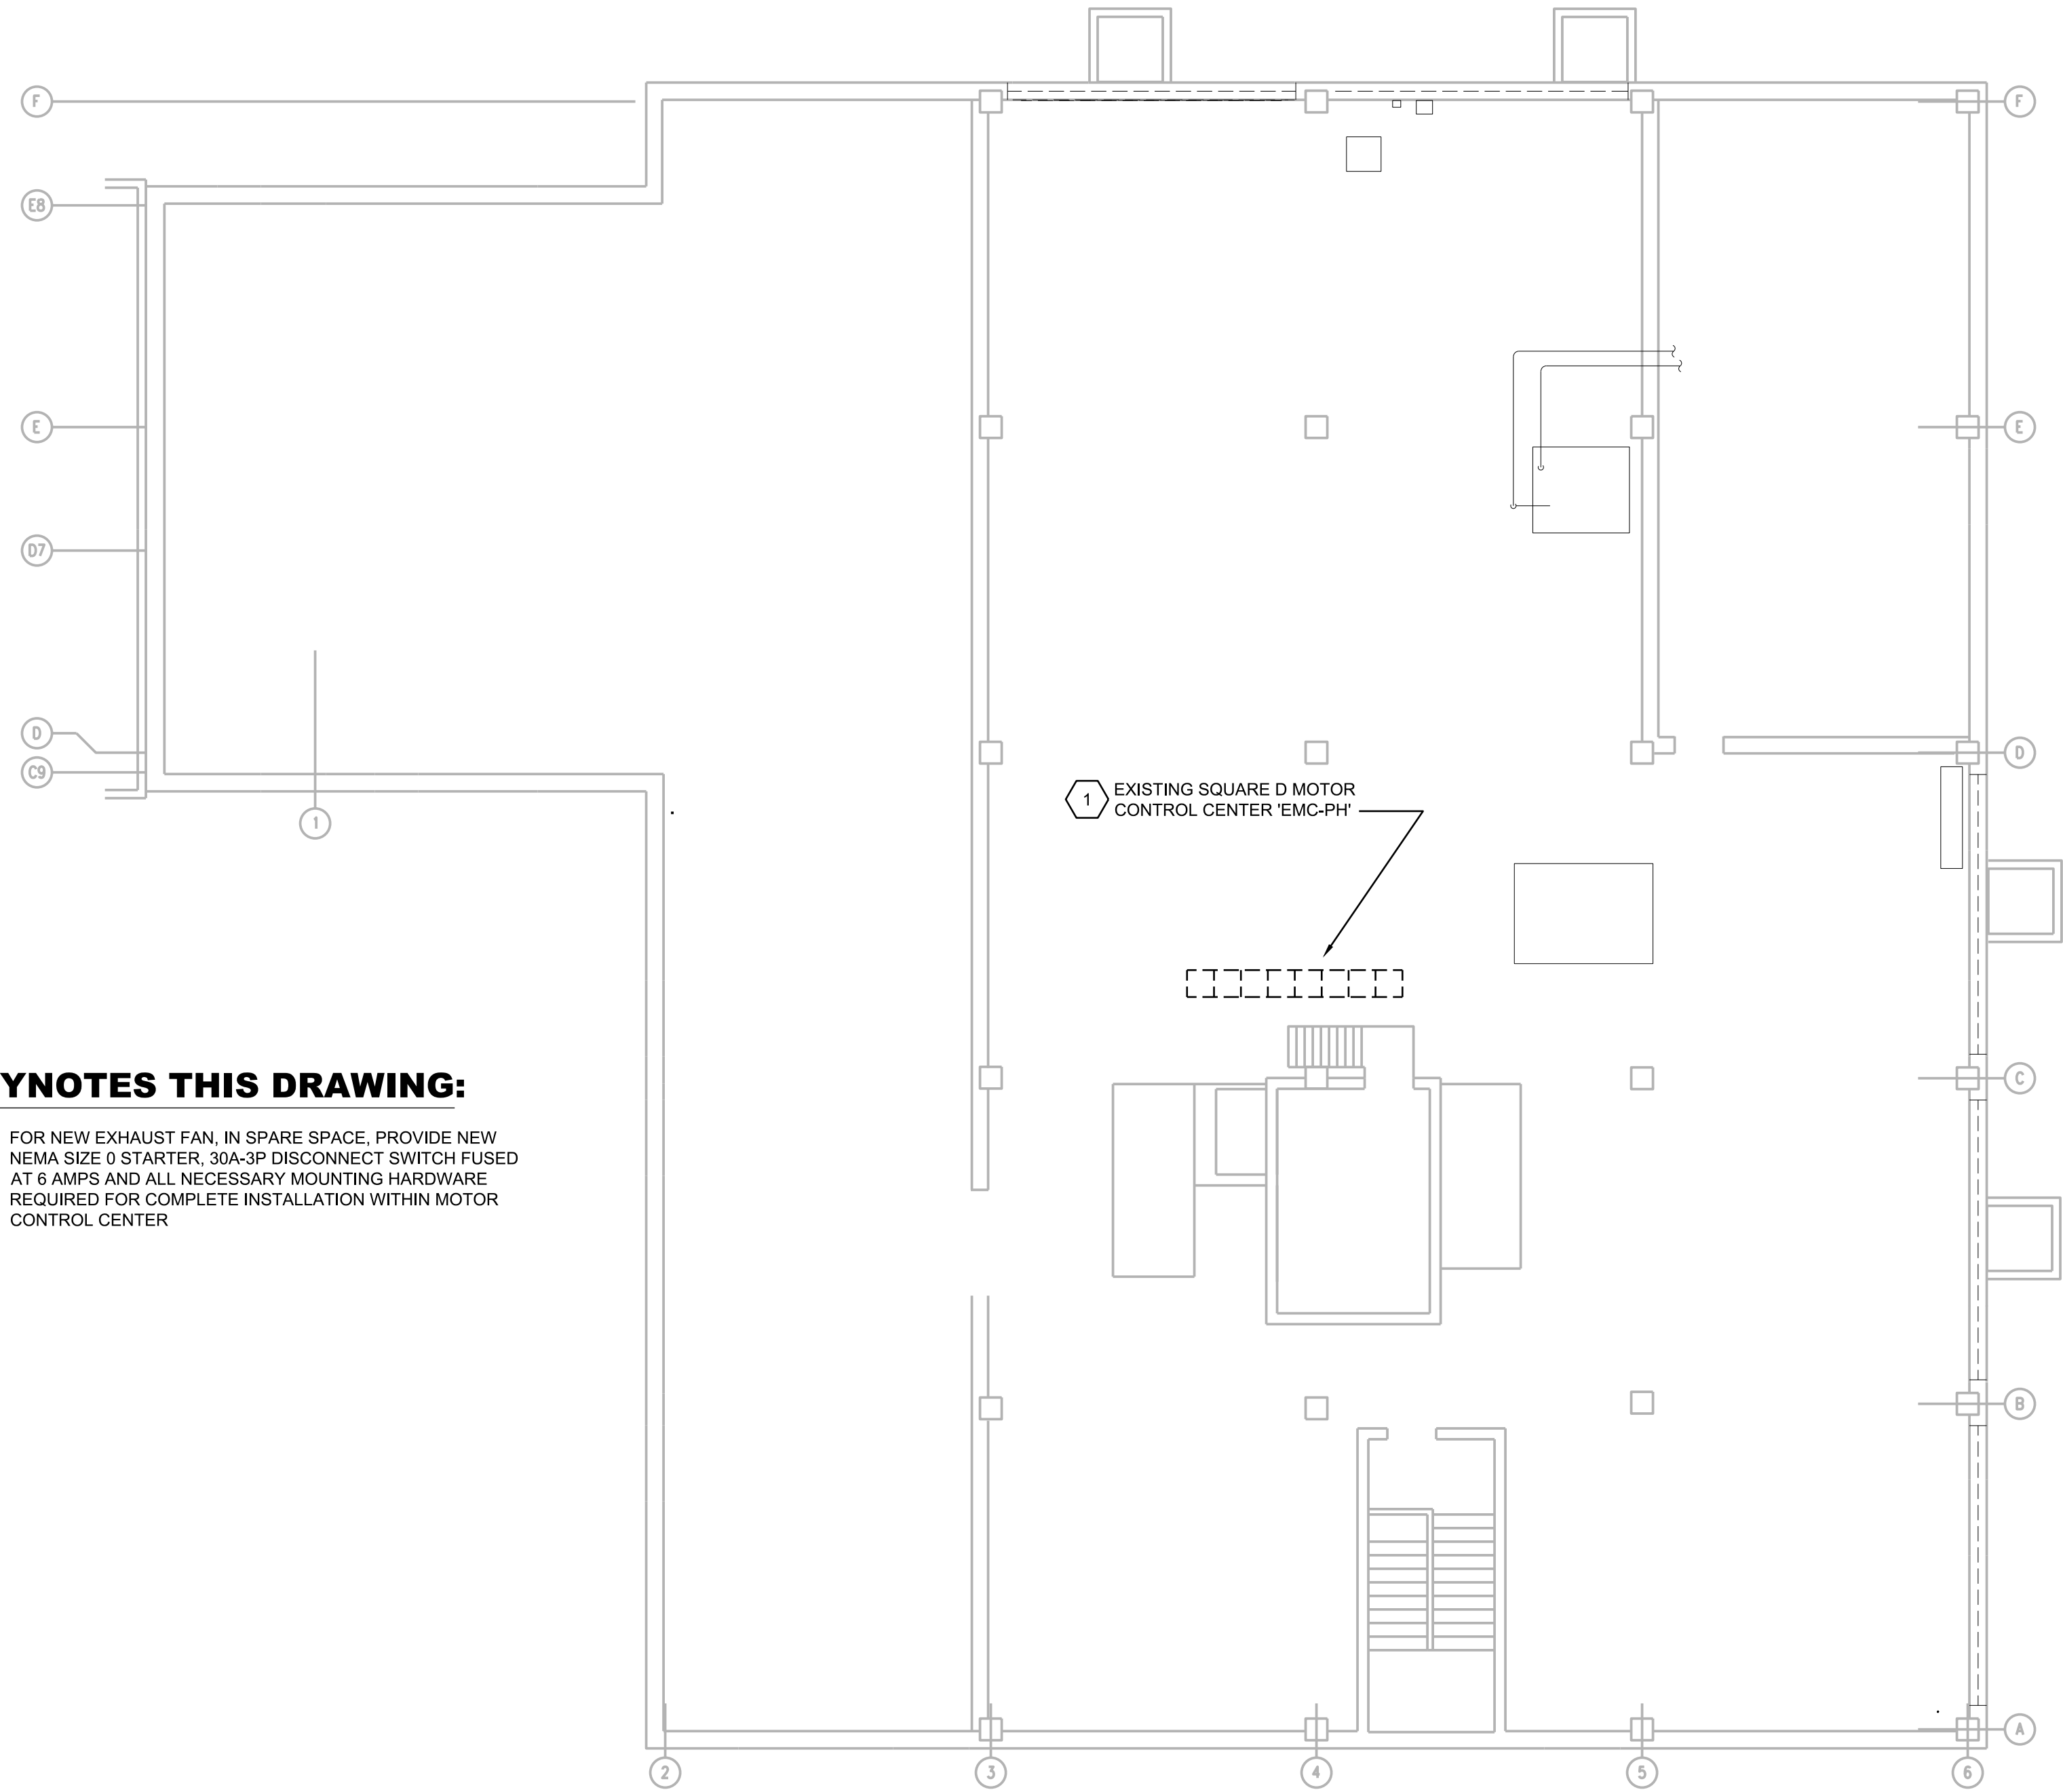

2 **PENTHOUSE FLOOR PLAN**
0 4" 8" 16"
SCALE: 1/8" = 1'-0"

Revisions	Date



H.F. LENZ COMPANY
1407 Scalp Avenue
Phone: 614-269-3000
cadd@hflenz.com
Engineering
Johnstown, PA 15904
PAX: 614-269-8801
www.hflenz.com

PENTHOUSE FLOOR PLAN AND ROOF PLAN		
Approved: Division Chief		
Approved: Service Director		

4TH FLOOR IMAGING SYSTEM		
Building Number 21	Checked TME	Drawn RJD
Location VAMC Philadelphia, Pennsylvania		

Date 04/26/2018
Project No. 642-17-300
DRAWING NO. E102
Dwg. 2 Of 2

Veterans Administration