
 


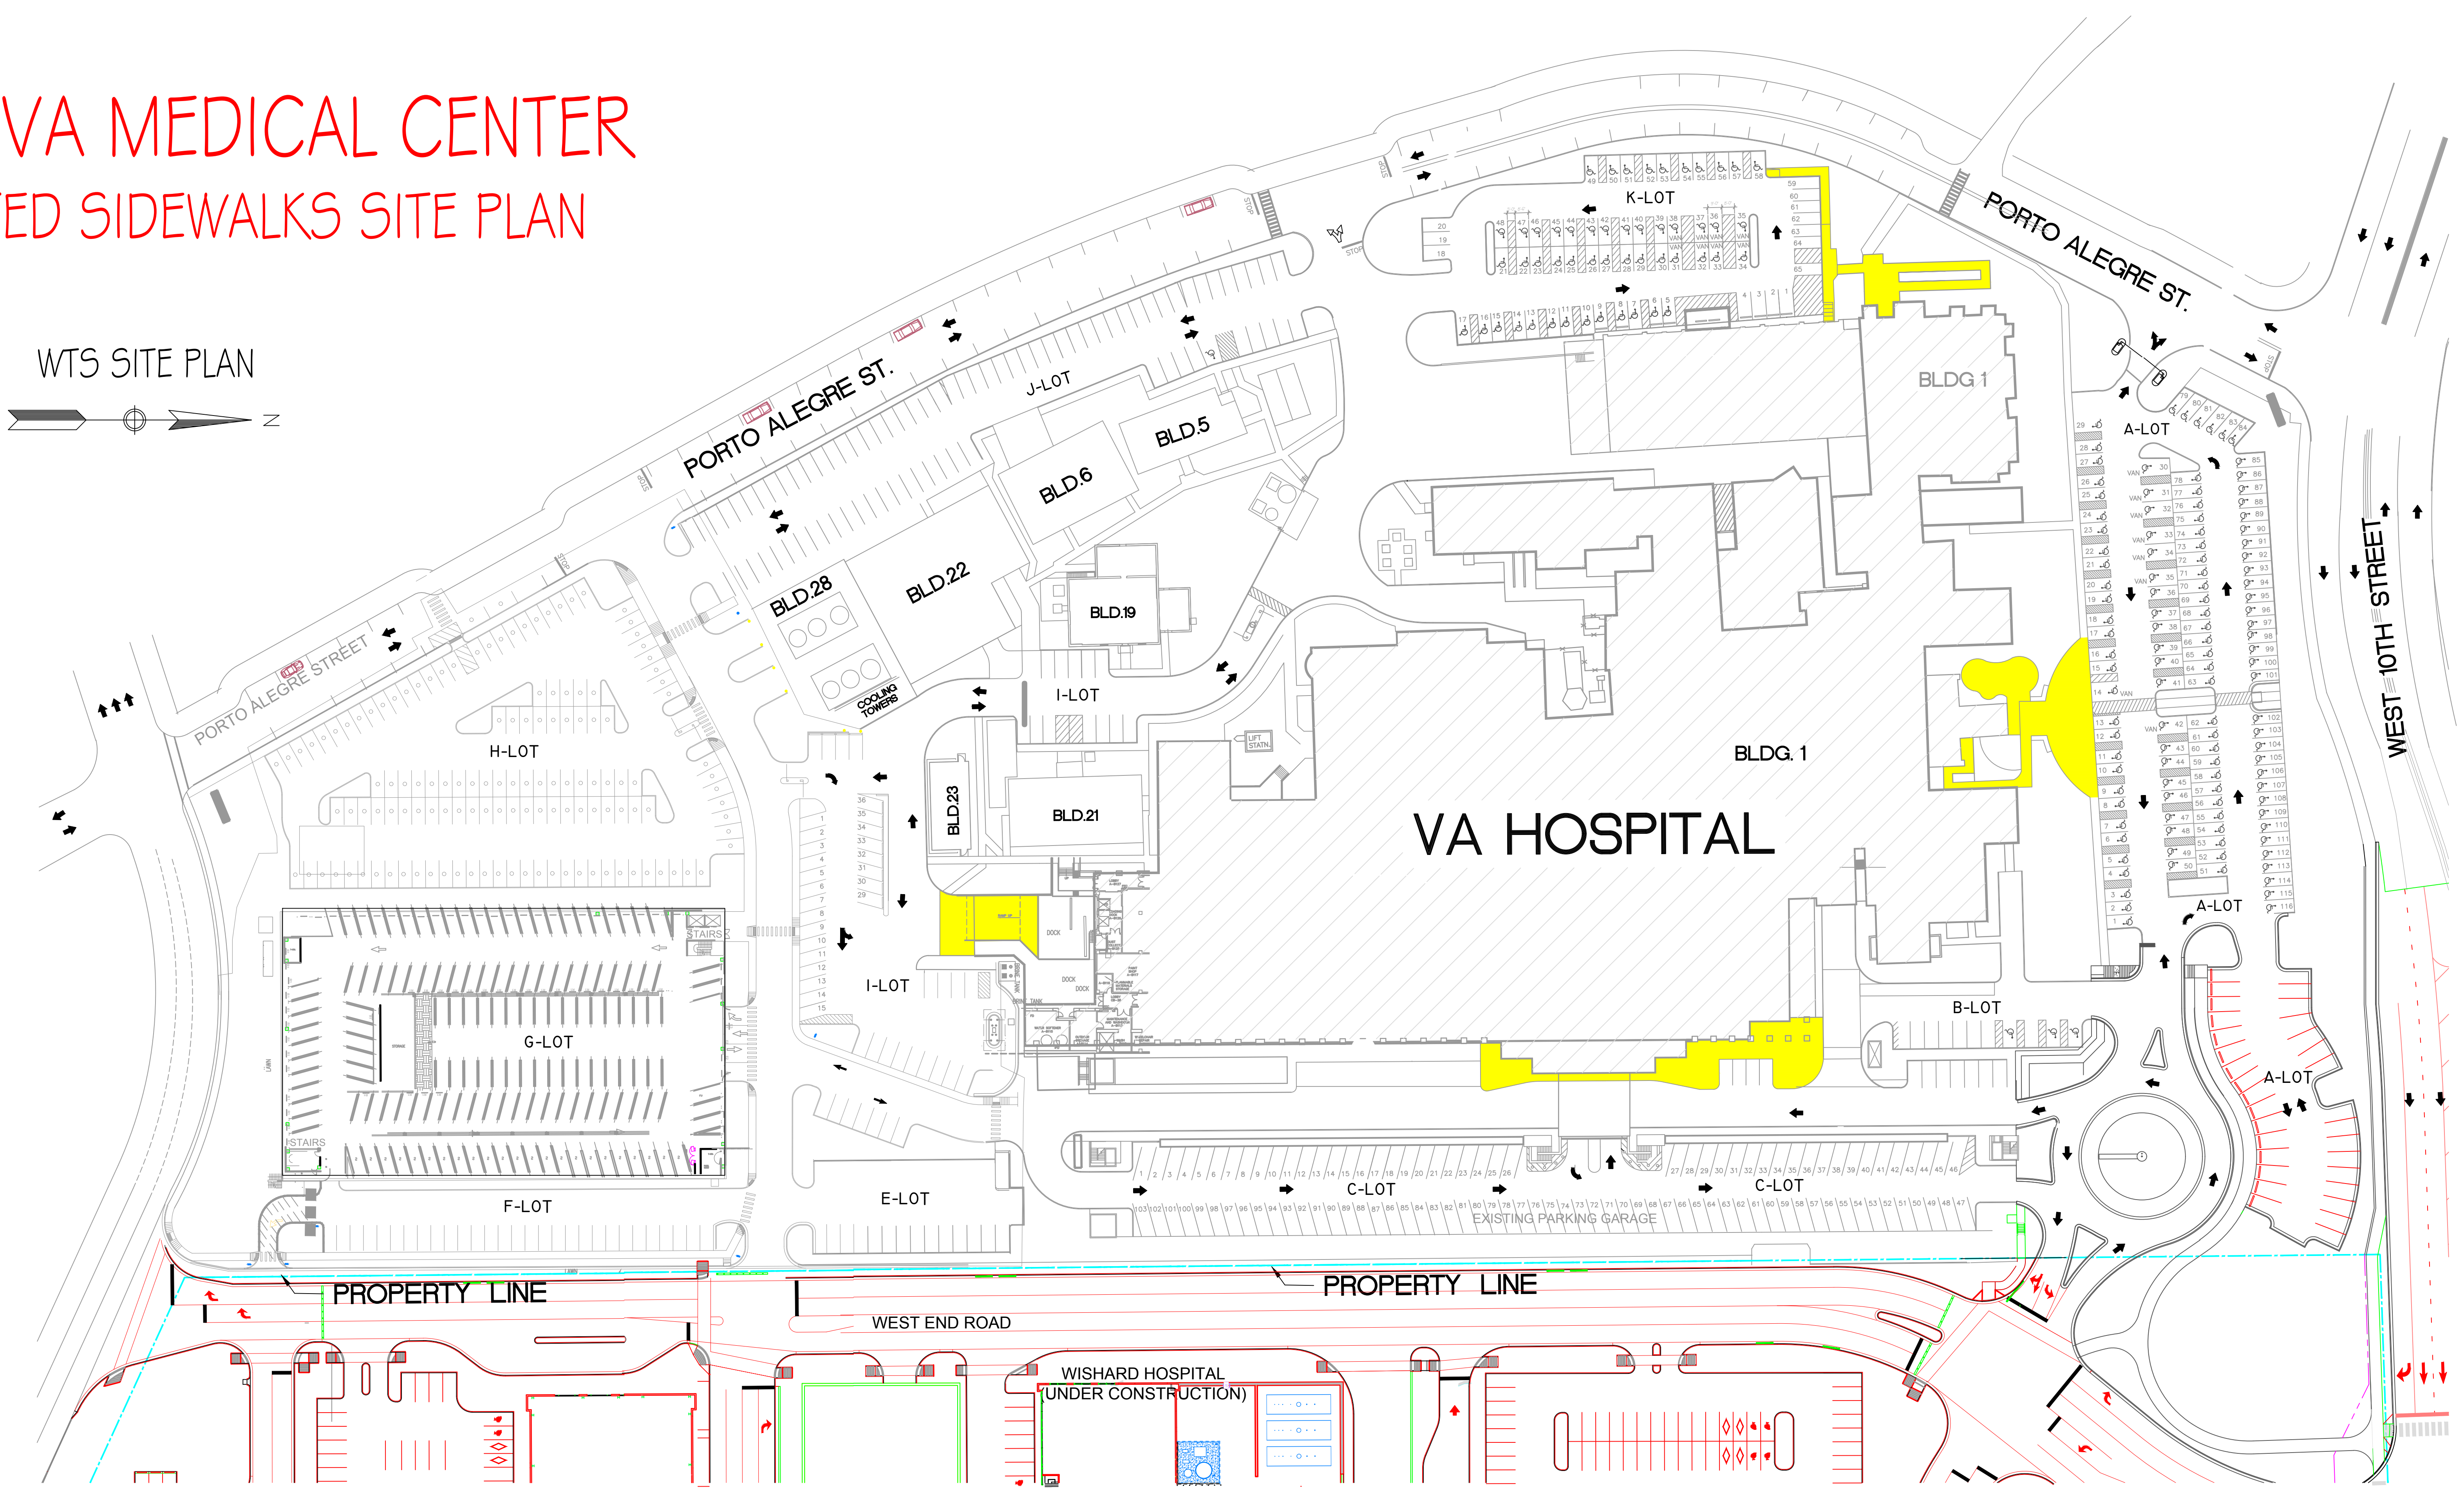


WTS VA MEDICAL CENTER
HEATED SIDEWALKS SITE PLAN

WTS SITE PLAN



 HEATED SIDEWALKS (DO NOT APPLY ANY SALT ON THESE SURFACE AREAS)

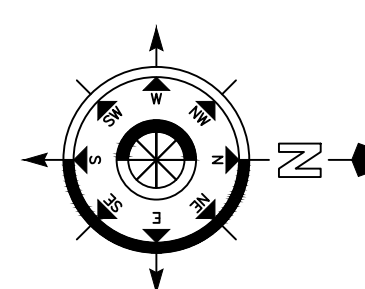MARCH 2018

Revisions:		Date	ADDRESS: Richard L. Roudebush VA Medical Center 1481 W. 10th St. Indianapolis, Indiana 46202		PROJECT ENGINEERS:	Drawing Title		Project Title		Project Number				
						WTS HEATED SIDEWALKS PLAN		HEATED SIDEWALKS SITE PLAN		-				
						Approved Project Director		Location		Building Number				
								WEST TENTH STREET		WTS				
								Date		Checked			Drawing Number	
								26 MAR 2018					C-101	
										Drawn			FY018	
					AF.		Dwg. 1 of 1							
											 Engineering and Facilities Management Services			