

A

B

C

D

E

F

A

B


C

D

E

F

three inches = one foot  
one and one half inches = one foot  
one inch = one foot  
three quarters inch = one foot  
one half inch = one foot  
three eighths inch = one foot  
one quarter inch = one foot  
one eighth inch = one foot

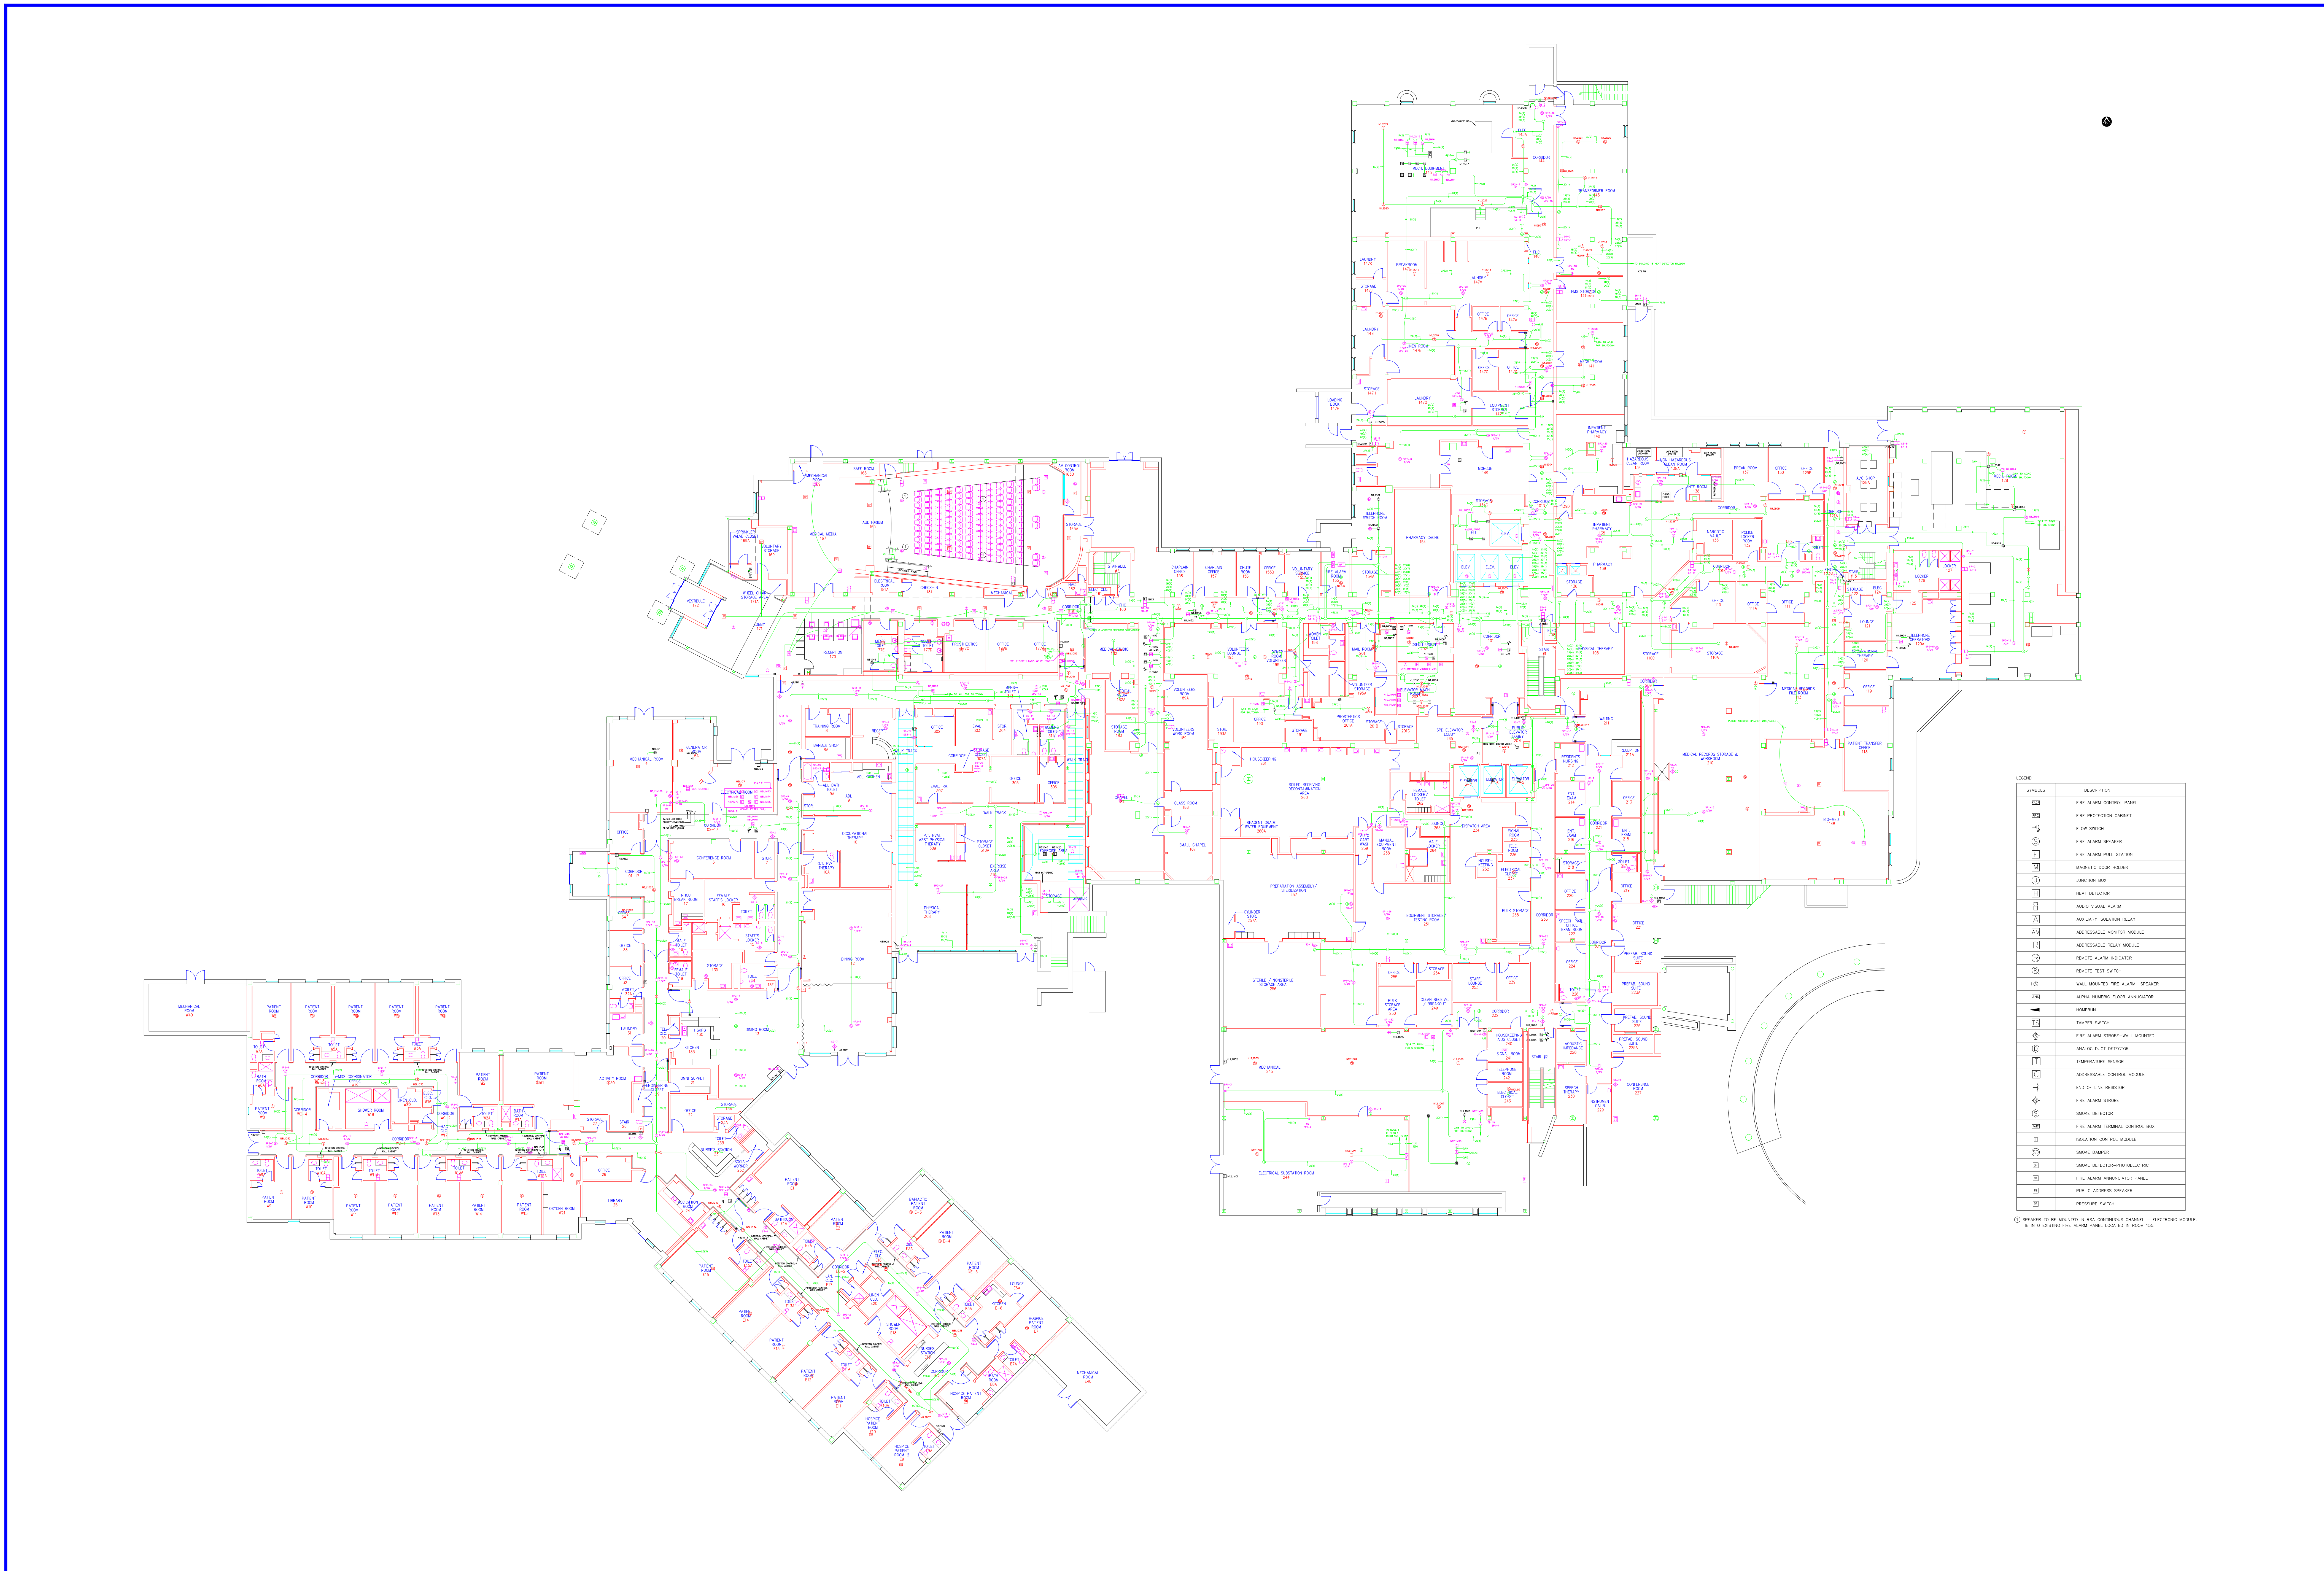

SYMBOL	DESCRIPTION
FCP	FIRE ALARM CONTROL PANEL
PC	FIRE PROTECTION CABINET
FS	FLOW SWITCH
BS	FIRE ALARM BELL
PS	FIRE ALARM PULL STATION
MD	MANUAL DOOR HOLDER
JB	JUNCTION BOX
HT	HEAT DETECTOR
VS	VISUAL ALARM
IR	IRIS ISOLATION RELAY
MR	ADDRESSABLE MONITOR MODULE
RR	ADDRESSABLE RELAY MODULE
RI	REMOTE ALARM INDICATOR
RT	REMOTE TEST SWITCH
WS	WALL MOUNTED FIRE ALARM SPEAKER
AF	ALPHA NUMERIC FLOOR ANALOGATOR
Y	YORKLIN
TS	THATCHER SWITCH
FSW	FIRE ALARM STROBE-WALL MOUNTED
SD	SMOKE DETECTOR
SDS	SMOKE DETECTOR SENSITIVE
SDM	SMOKE DETECTOR MODULE
SDP	SMOKE DETECTOR PHOTOELECTRIC
SDA	FIRE ALARM ANNUNCIATOR PANEL
SP	PUBLIC ADDRESS SPEAKER
SW	SWITCH

① SPEAKER TO BE MOUNTED IN EACH CONTINGUOUS CORRIDOR. - ELECTRONIC MODULE TO BE MOUNTED IN EACH CONTINGUOUS CORRIDOR. - ELECTRONIC MODULE TO BE MOUNTED IN EACH CONTINGUOUS CORRIDOR. - ELECTRONIC MODULE TO BE MOUNTED IN EACH CONTINGUOUS CORRIDOR.

Revisions		Date		Professional Seal		Indus Systems, Inc. 2352, Main Street, Concord MA 01742 Tel: 978-461-0555 www.indus-systems.com		Drawing Title GROUND FLOOR PLAN FIRE PROTECTION		Project Title AS-BUILT Drawings		Date 09-18-2017 Project No.		Building Number 01		Checked		Drawn		Drawing No. 460-1-G-FP		VAMC, WILMINGTON		VA Department of Veterans Affairs	
Approved:								Approved:		Location VAMC WILMINGTON DELAWARE															