



1 EDUCATION & E.E.G.

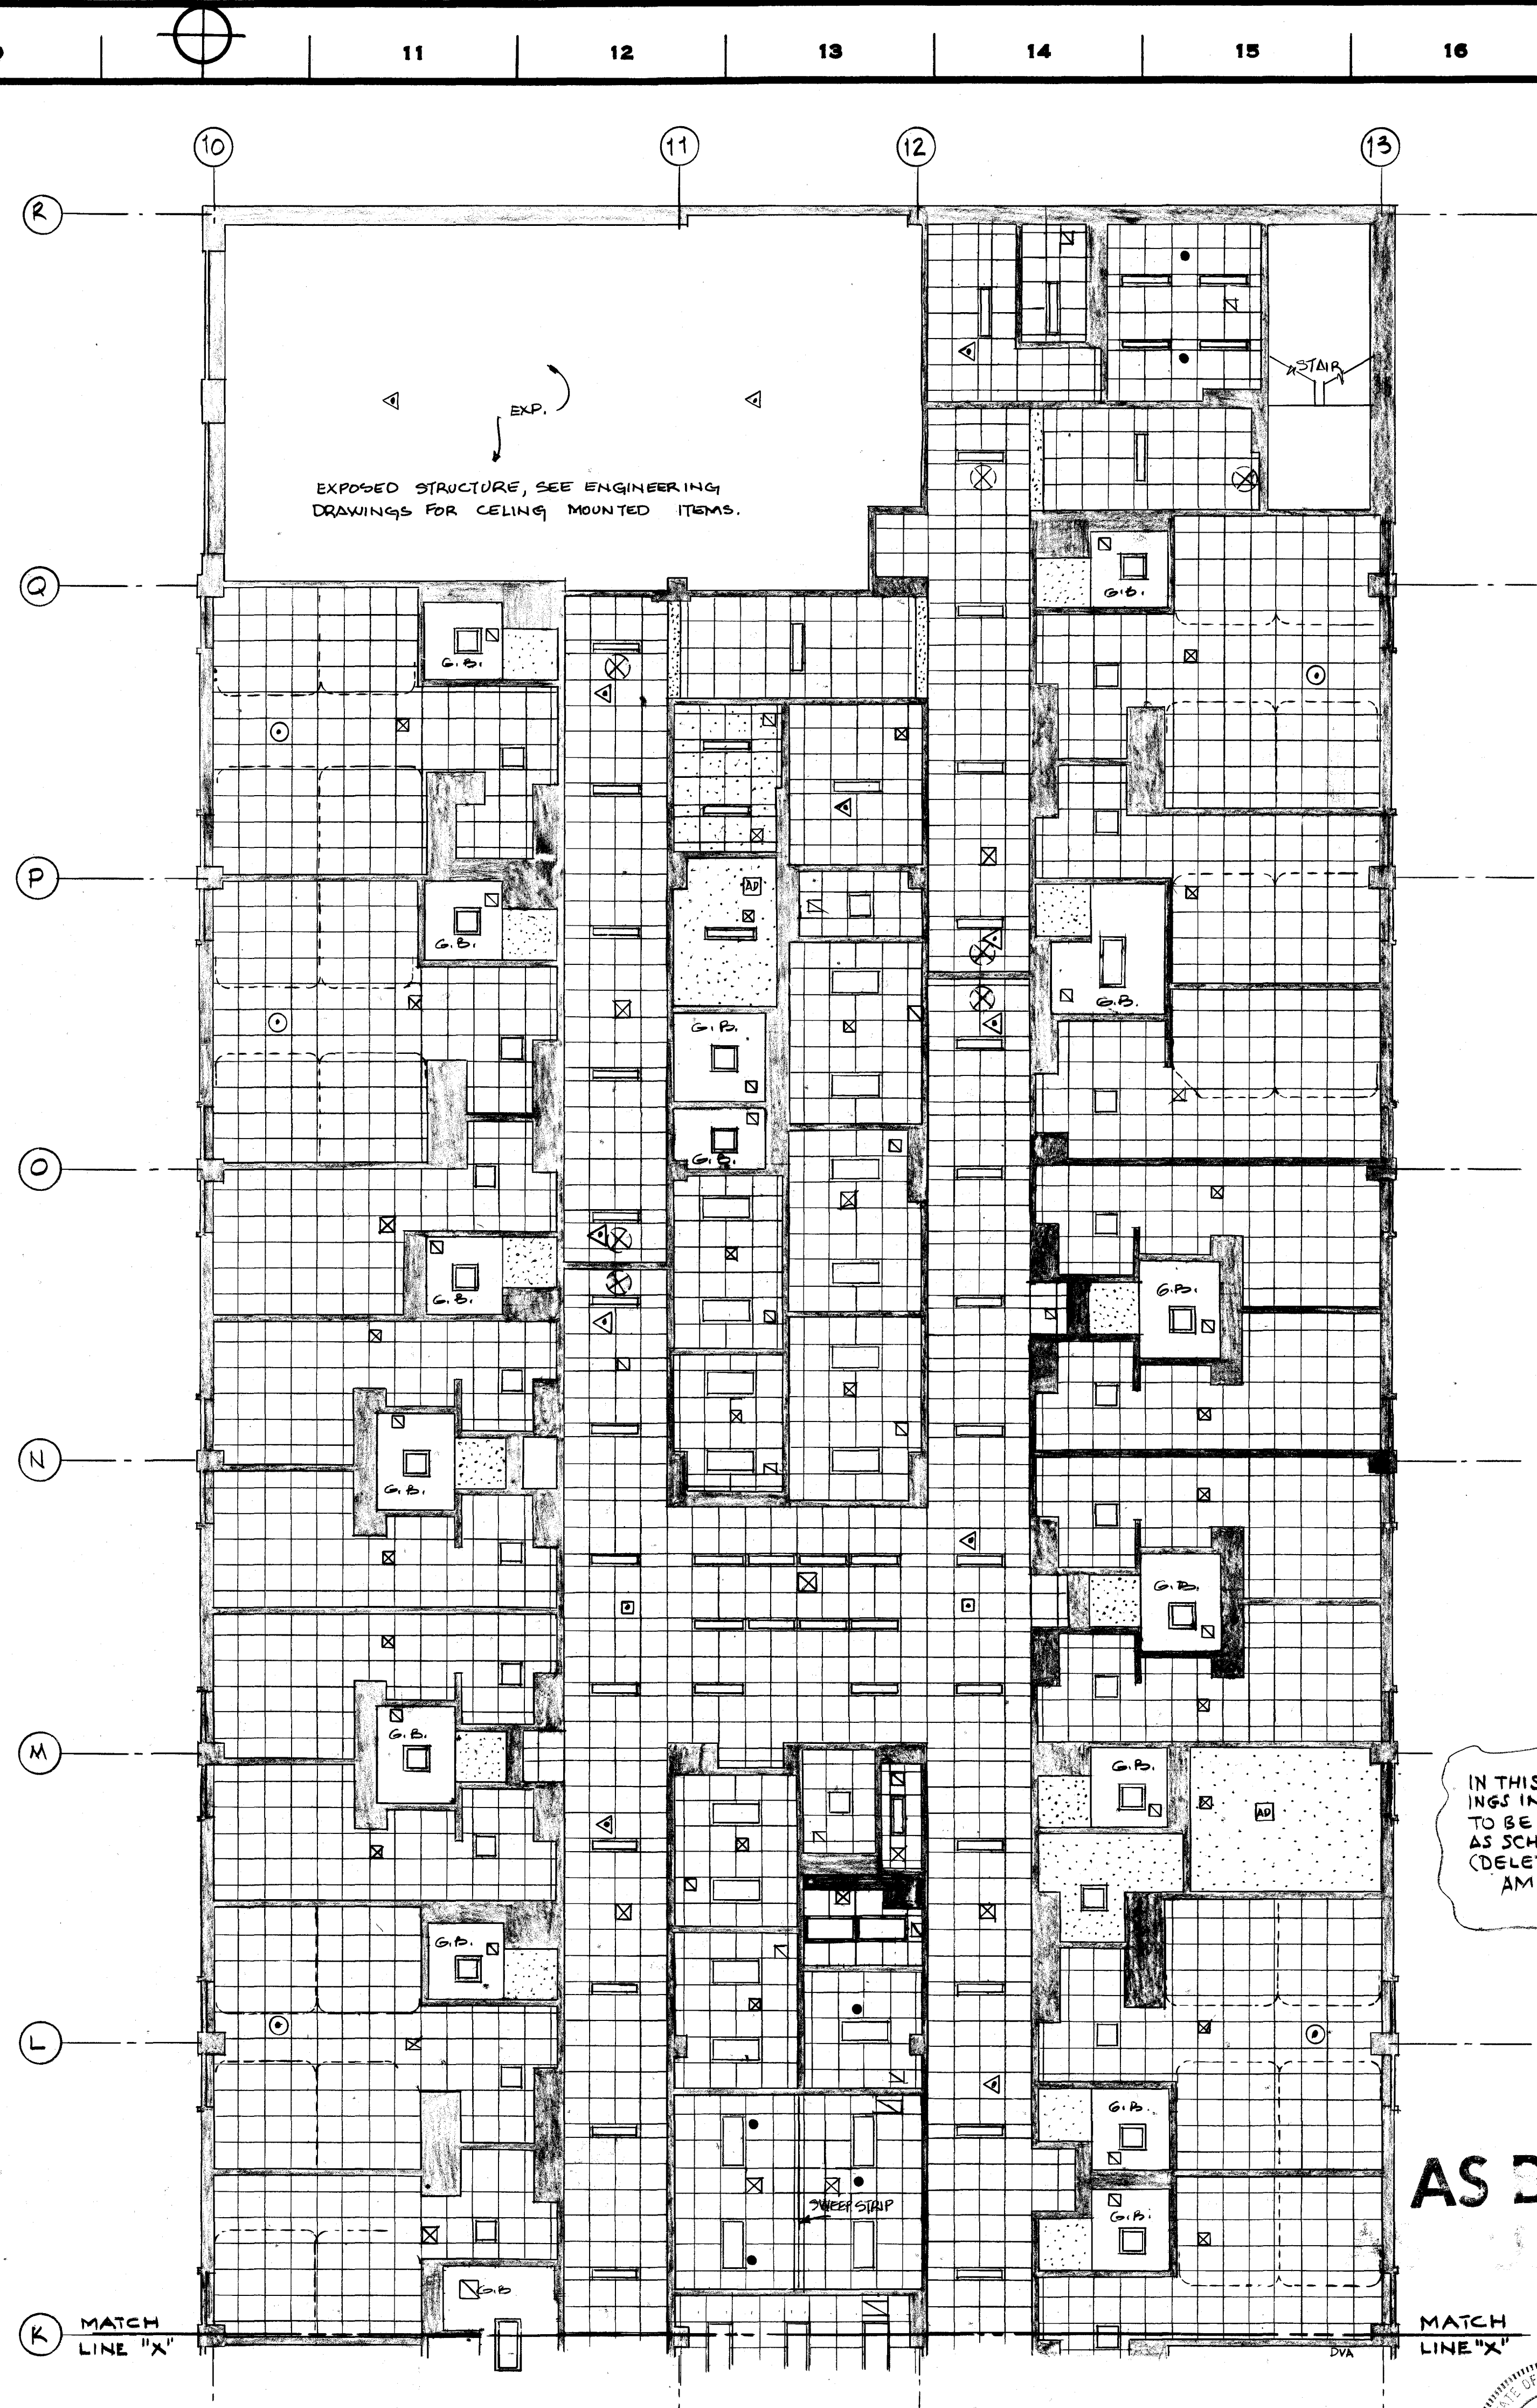

2 NEUROLOGICAL/P.M.&R. NURSING UNIT - 37 BEDS

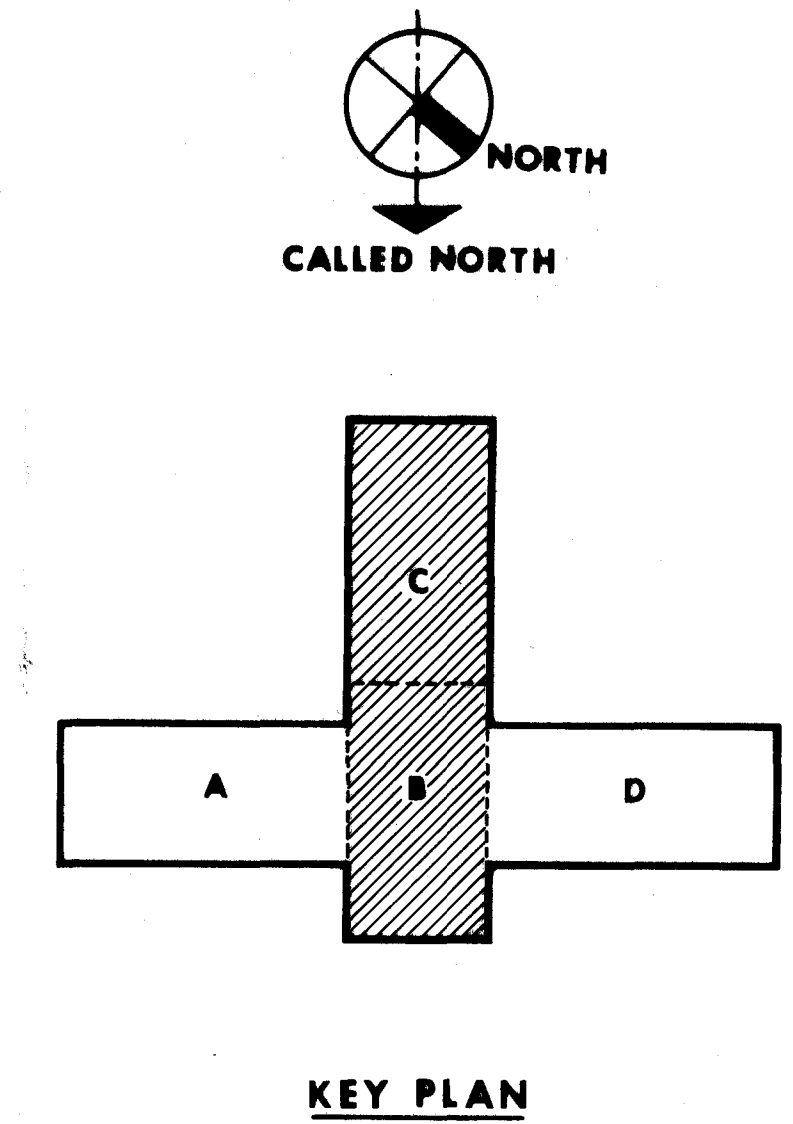

IN THIS AMENDMENT, REFER TO ITEM 117, ELECTRICAL DRAWINGS IN GENERAL, PARAGRAPH C, FOR LIGHTING FIXTURES TO BE DELETED. PROVIDE CEILING MATERIAL AND FINISH AS SCHEDULED IN LIEU OF FIXTURES SO DELETED. (DELETED FIXTURES CIRCLED ON PLAN.)  
AMEND. 4, ITEM 68.

AS BUILT

NO.	DATE	DESCRIPTION
REVISIONS		
SHEET TITLE		
REFLECTED CEILING PLAN		
3RD FLOOR AREA B-C		
PROJECT TITLE		
400 BED REPLACEMENT		
HOSPITAL - PHASE 2		
DRAWN	CHECKED	DATE
CB	CGJ	23 SEPT. 1976
DRAWING NUMBER		
100-133		
PROJECT NUMBER		
544-024B		
VETERANS ADMINISTRATION		
LOCATION		
VAH, COLUMBIA, SOUTH CAROLINA		

