


three inches = one foot  
one and one half inches = one foot  
one inch = one foot  
three quarters inch = one foot  
one half inch = one foot  
three eighths inch = one foot  
one quarter inch = one foot  
one eighth inch = one foot

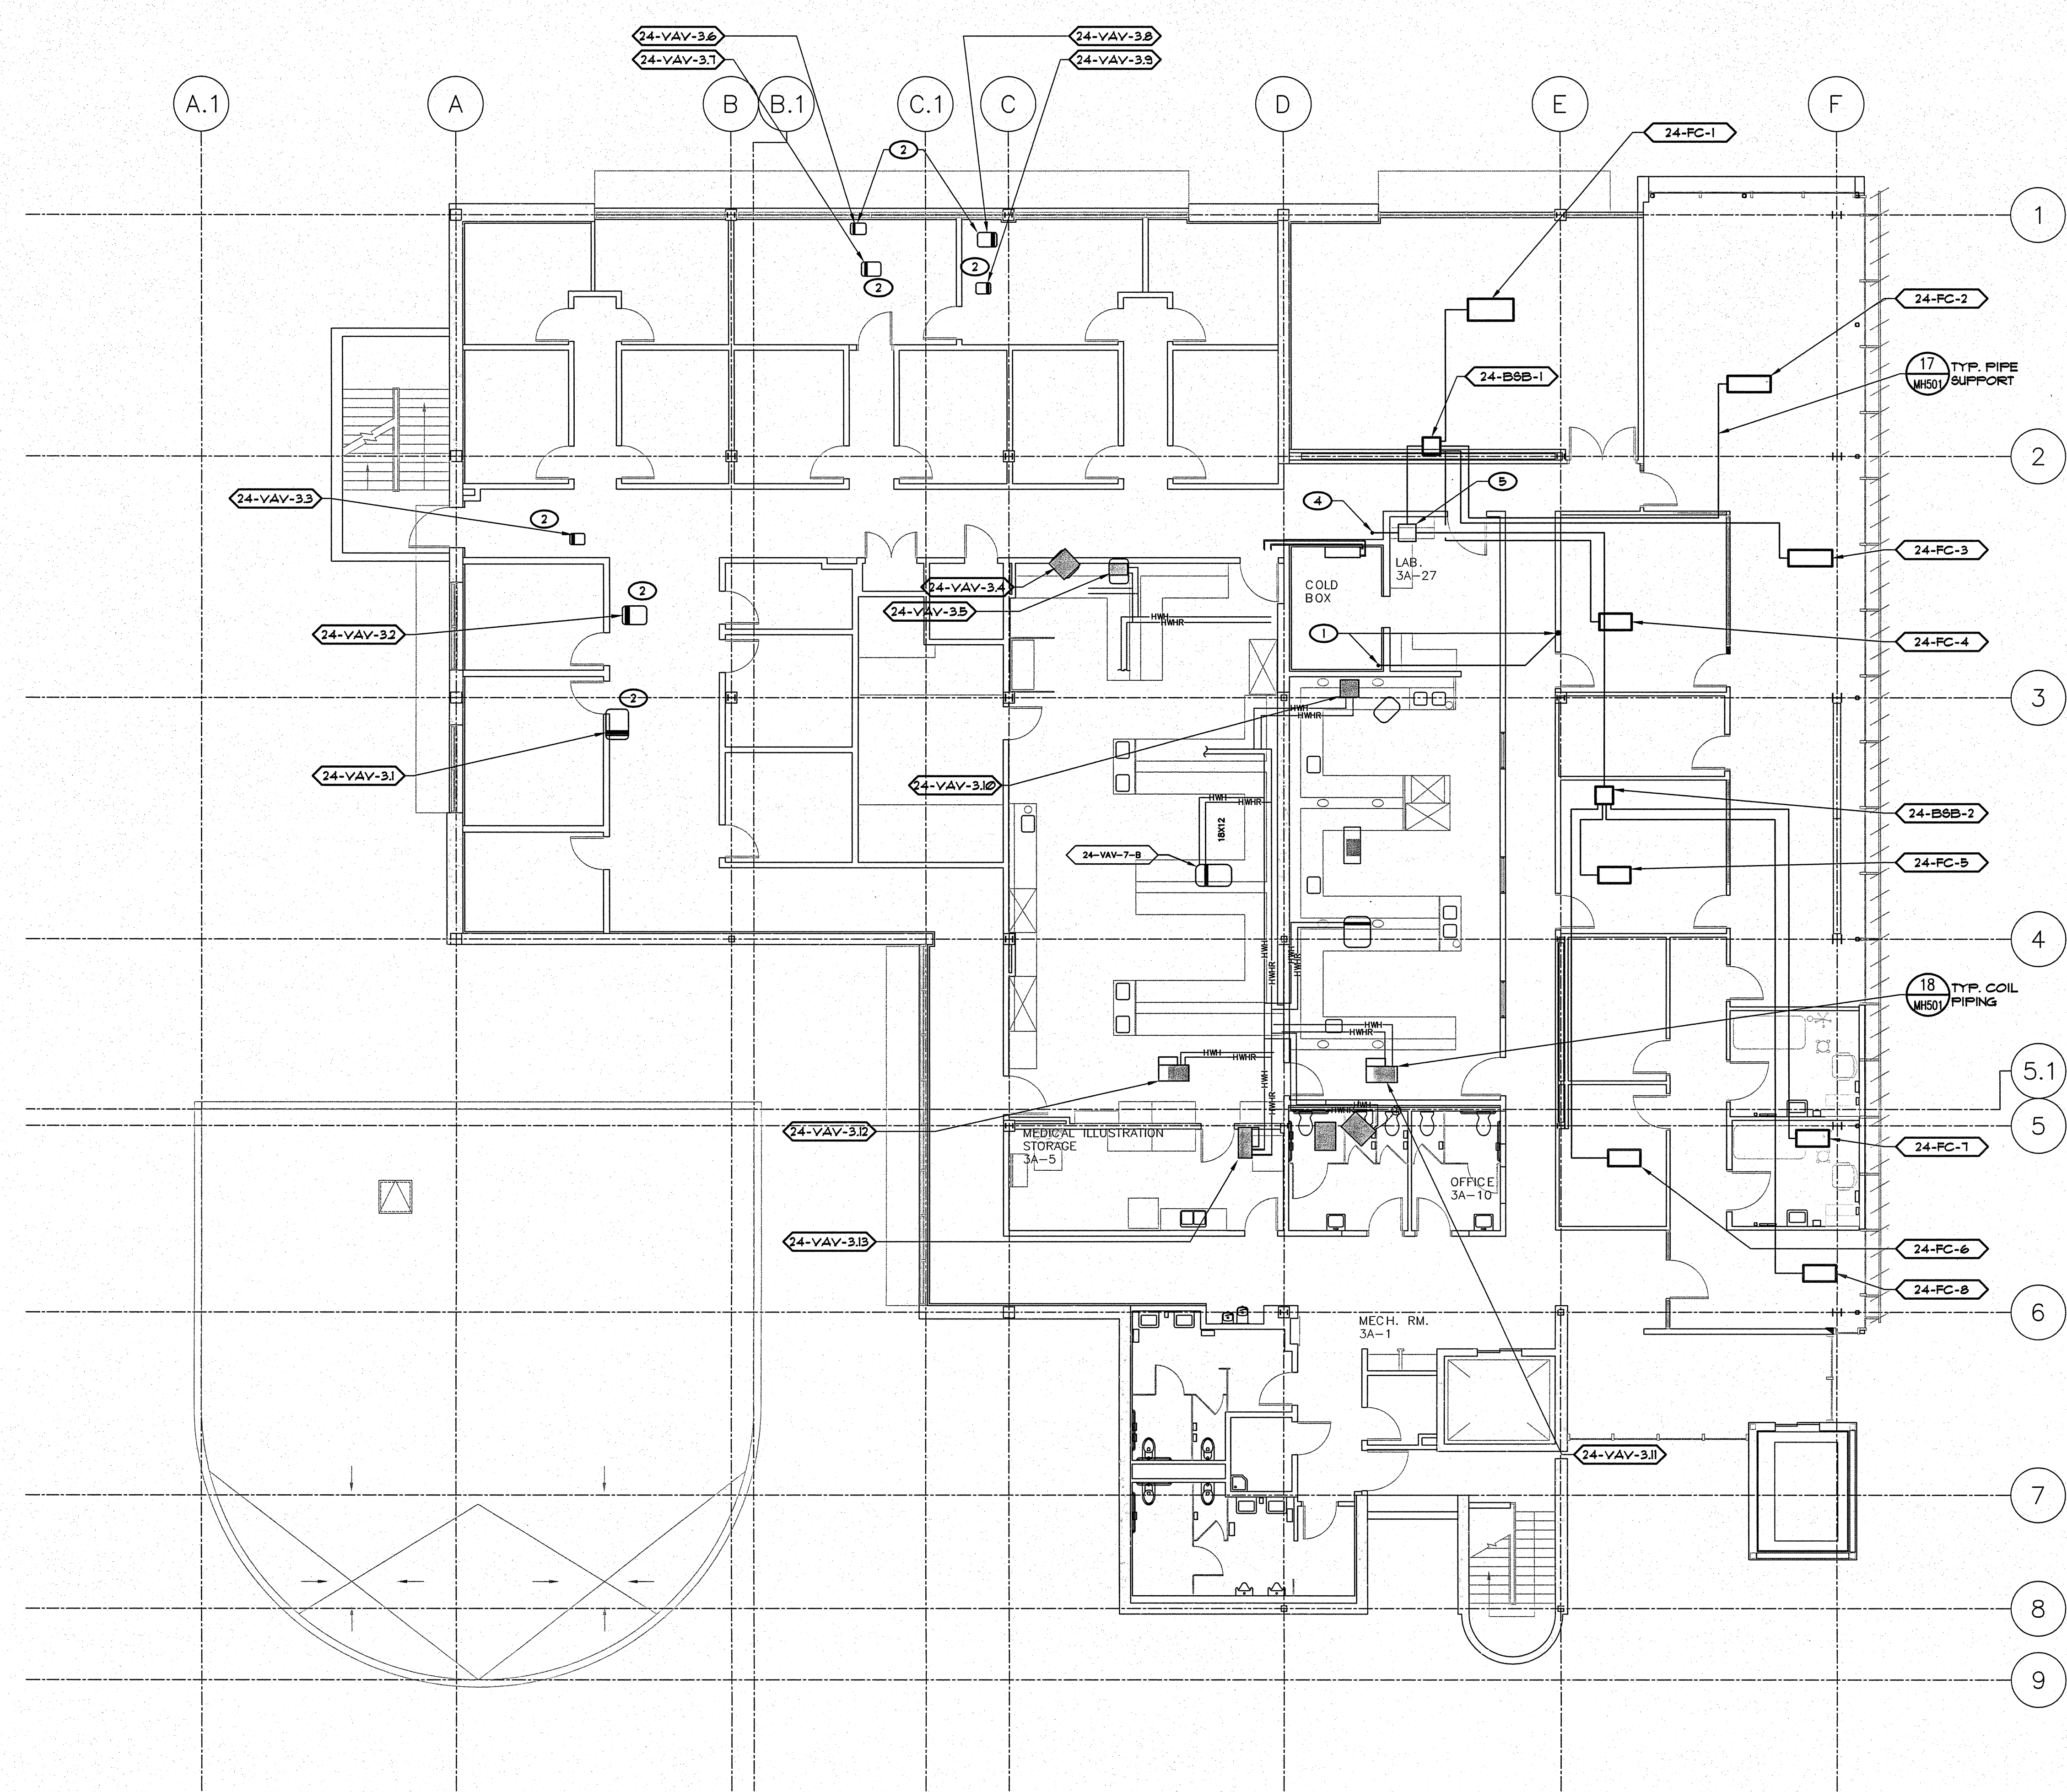

- KEY NOTES**
- 1 REFRIGERANT PIPING DROPS THRU ROOF FROM CDU-2, EXTEND IN ATTIC AS SHOWN AND DROP INSIDE WALL TO SECOND FLOOR. SEE SHEET MP102 FOR CONTINUATION.
  - 2 VAV BOX WITH REHEAT COIL, REPLACE ALL COIL PIPING VALVES ALONG WITH ALL ASSOCIATED CONTROLS.
  - 3 VAV BOX WITH NO HOT WATER COIL.
  - 4 REFRIGERANT PIPING DROPS THRU ROOF FROM CDU-1, EXTEND IN ATTIC TO REHEAT BRANCH, THEN BSB'S AND FC'S AS SHOWN. SEE SHEET MP602 FOR PIPE SIZES ON SCHEMATICS.
  - 5 REFRIGERANT Y-BRANCH FITTING IN ATTIC, SEE PIPING SCHEMATIC SHEET MH602 FOR MODEL.

**EQUIPMENT NOTE**

REFER TO SHEETS MH600 AND MH601 FOR EQUIPMENT SCHEDULES.

1 THIRD FLOOR MECHANICAL REMODEL PIPING PLAN  
SCALE: 1/8" = 1'-0"

<b>CONSULTANTS:</b>  LP Consulting Engineers, Inc. 895 W. Ashlan Ave. Suite 101 Clovis, CA 93612 p 559-348-2130 • f 559-348-2131 www.lpeng.com Job #: 10-1098		<b>ARCHITECT/ENGINEERS:</b>  HMC Architects 1827 E. Fir Avenue, Studio 103 / Fresno, CA 93720 T 559 322 2444 / www.hmcarchitects.com		<b>Drawing Title</b> THIRD FLOOR MECHANICAL REMODEL PIPING PLAN  <b>Approved: Project Director</b>		<b>Project Title</b> BUILDING 24 SEISMIC CORRECTION AND ADDITION  <b>Location</b> VAMC FRESNO, CA  <b>Date</b> January 31, 2012 <b>Checked</b> K.K. <b>Drawn</b> D.N.		<b>Project Number</b> 570-215 <b>Building Number</b> 24 <b>Drawing Number</b> MP103 Dwg. 149 of 180		<b>Office of Construction and Facilities Management</b> Department of Veterans Affairs	
---	--	--	--	--	--	--	--	---	--	---	--