

CHILLER FOR O.R. SUITE AIR-HANDLING UNIT

V.A. MEDICAL CENTER

1601 KIRKWOOD HIGHWAY


WILMINGTON, DE

ENGINEERS


PM&E DESIGN GROUP, P.C.
ROACH CONSULTING ENGINEERS, P.C.
NRW ENGINEERING, P.C.

DISCIPLINE

MECHANICAL ENGINEER
ELECTRICAL ENGINEER
STRUCTURAL ENGINEER

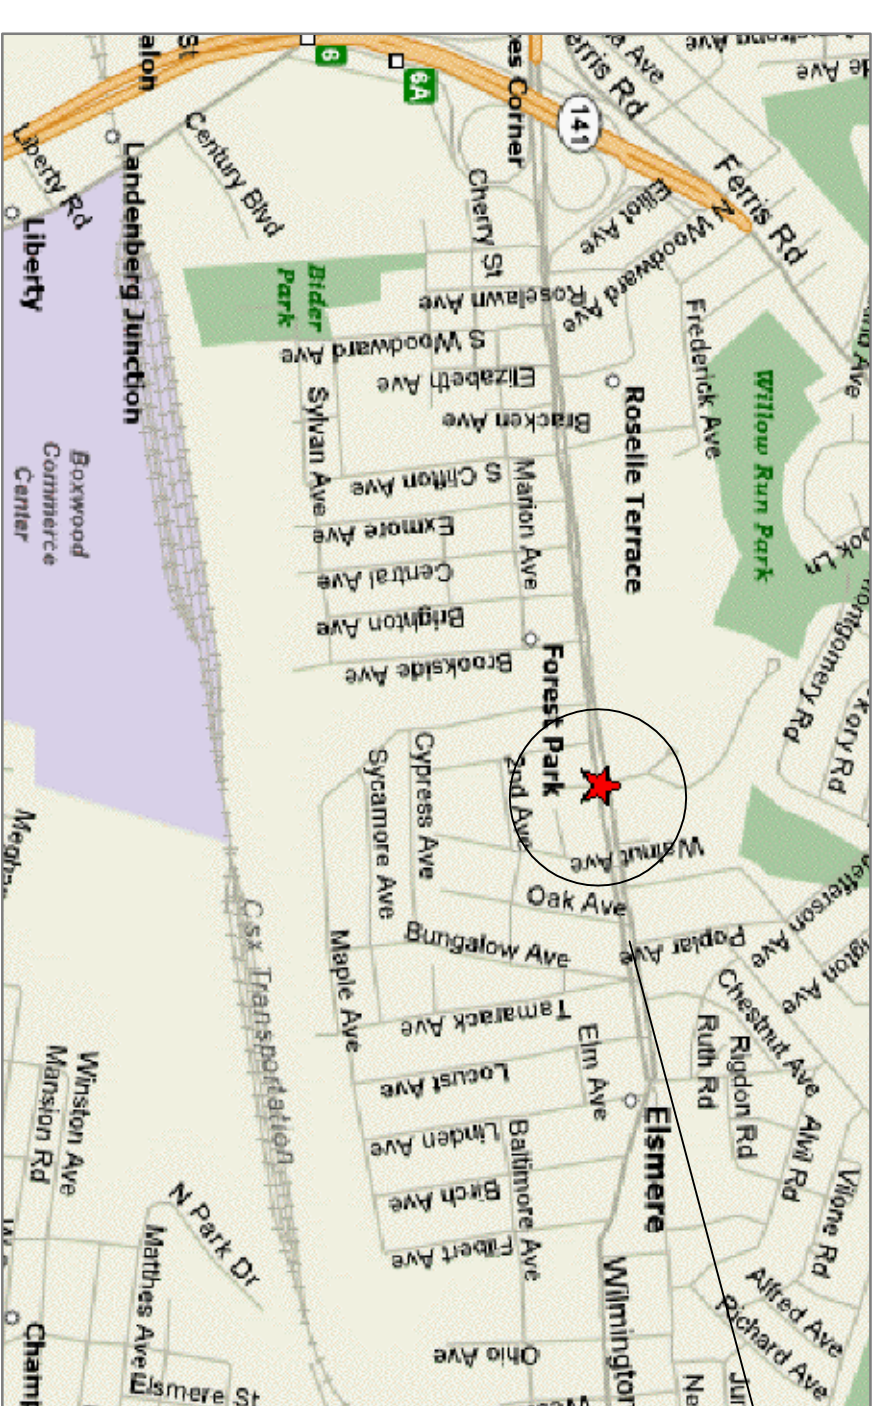

PROJECT
LOCATION

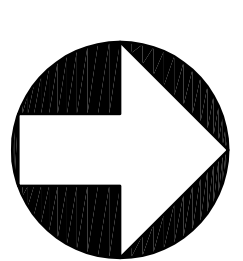

VICINITY MAP
NO SCALE

DRAWING INDEX

DRAWING NO.	SHEET TITLE
G001	TITLE SHEET
S101	STRUCTURAL PLAN & DETAILS
M001	MECHANICAL GENERAL NOTES, LEGEND & ABBREVIATIONS
M0101	THIRD FLOOR MECHANICAL DEMOLITION PLAN
M101	THIRD FLOOR MECHANICAL NEW WORK PLAN, SECTION & DETAILS
M501	MECHANICAL FLOW DIAGRAM AND DETAILS
M601	MECHANICAL EQUIPMENT SCHEDULES &Z CONTROL DIAGRAMS
E101	ELECTRICAL RISER DIAGRAM & DETAILS
E201	FLOOR PLANS – ELECTRICAL

CODE DATA

CODE REFERENCES
REFER TO VHA PROGRAM GUIDE PC-18-3 (MARCH 2006) FOR A LISTING OF BUILDING CODES AND STANDARDS.
EXISTING USE GROUP CLASSIFICATION
"1-2" – HEALTHCARE (UNCHANGED)
ASBESTOS STATEMENT
THE OWNER INDICATES THAT NONE IS PRESENT.

**CHILLER FOR O.R.
SUITE AIR-HANDLING
UNIT**



PM&E DESIGN GROUP, P.C.
2712 SOUTHERN BOULEVARD
SUITE 201
VIRGINIA BEACH, VA 23452
PHONE: (757) 233-3951 FAX: (757) 233-8419

APPROVED BY PROJECT ENGINEER	APPROVED BY CHIEF ENGINEER/ FACILITIES MANAGER
APPROVED BY VISION & SAFETY OFFICER	APPROVED BY INFECTION CONTROL OFFICER
	APPROVED BY CHIEF OF STAFF
	APPROVED BY CENTER DIRECTOR

DRAWING TITLE

DWG.	PROJECT NO.	DATE
G001	460-06-101	4/20/06

