





A three inches = one foot
B one and one half inches = one foot
C one inch = one foot
D three quarters inch = one foot
E one half inch = one foot
F three eighths inch = one foot
G one quarter inch = one foot
H one eighth inch = one foot

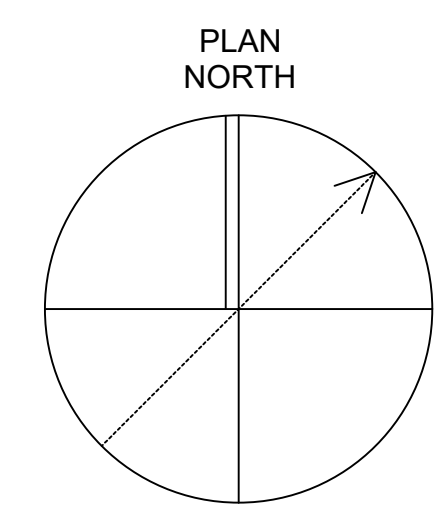

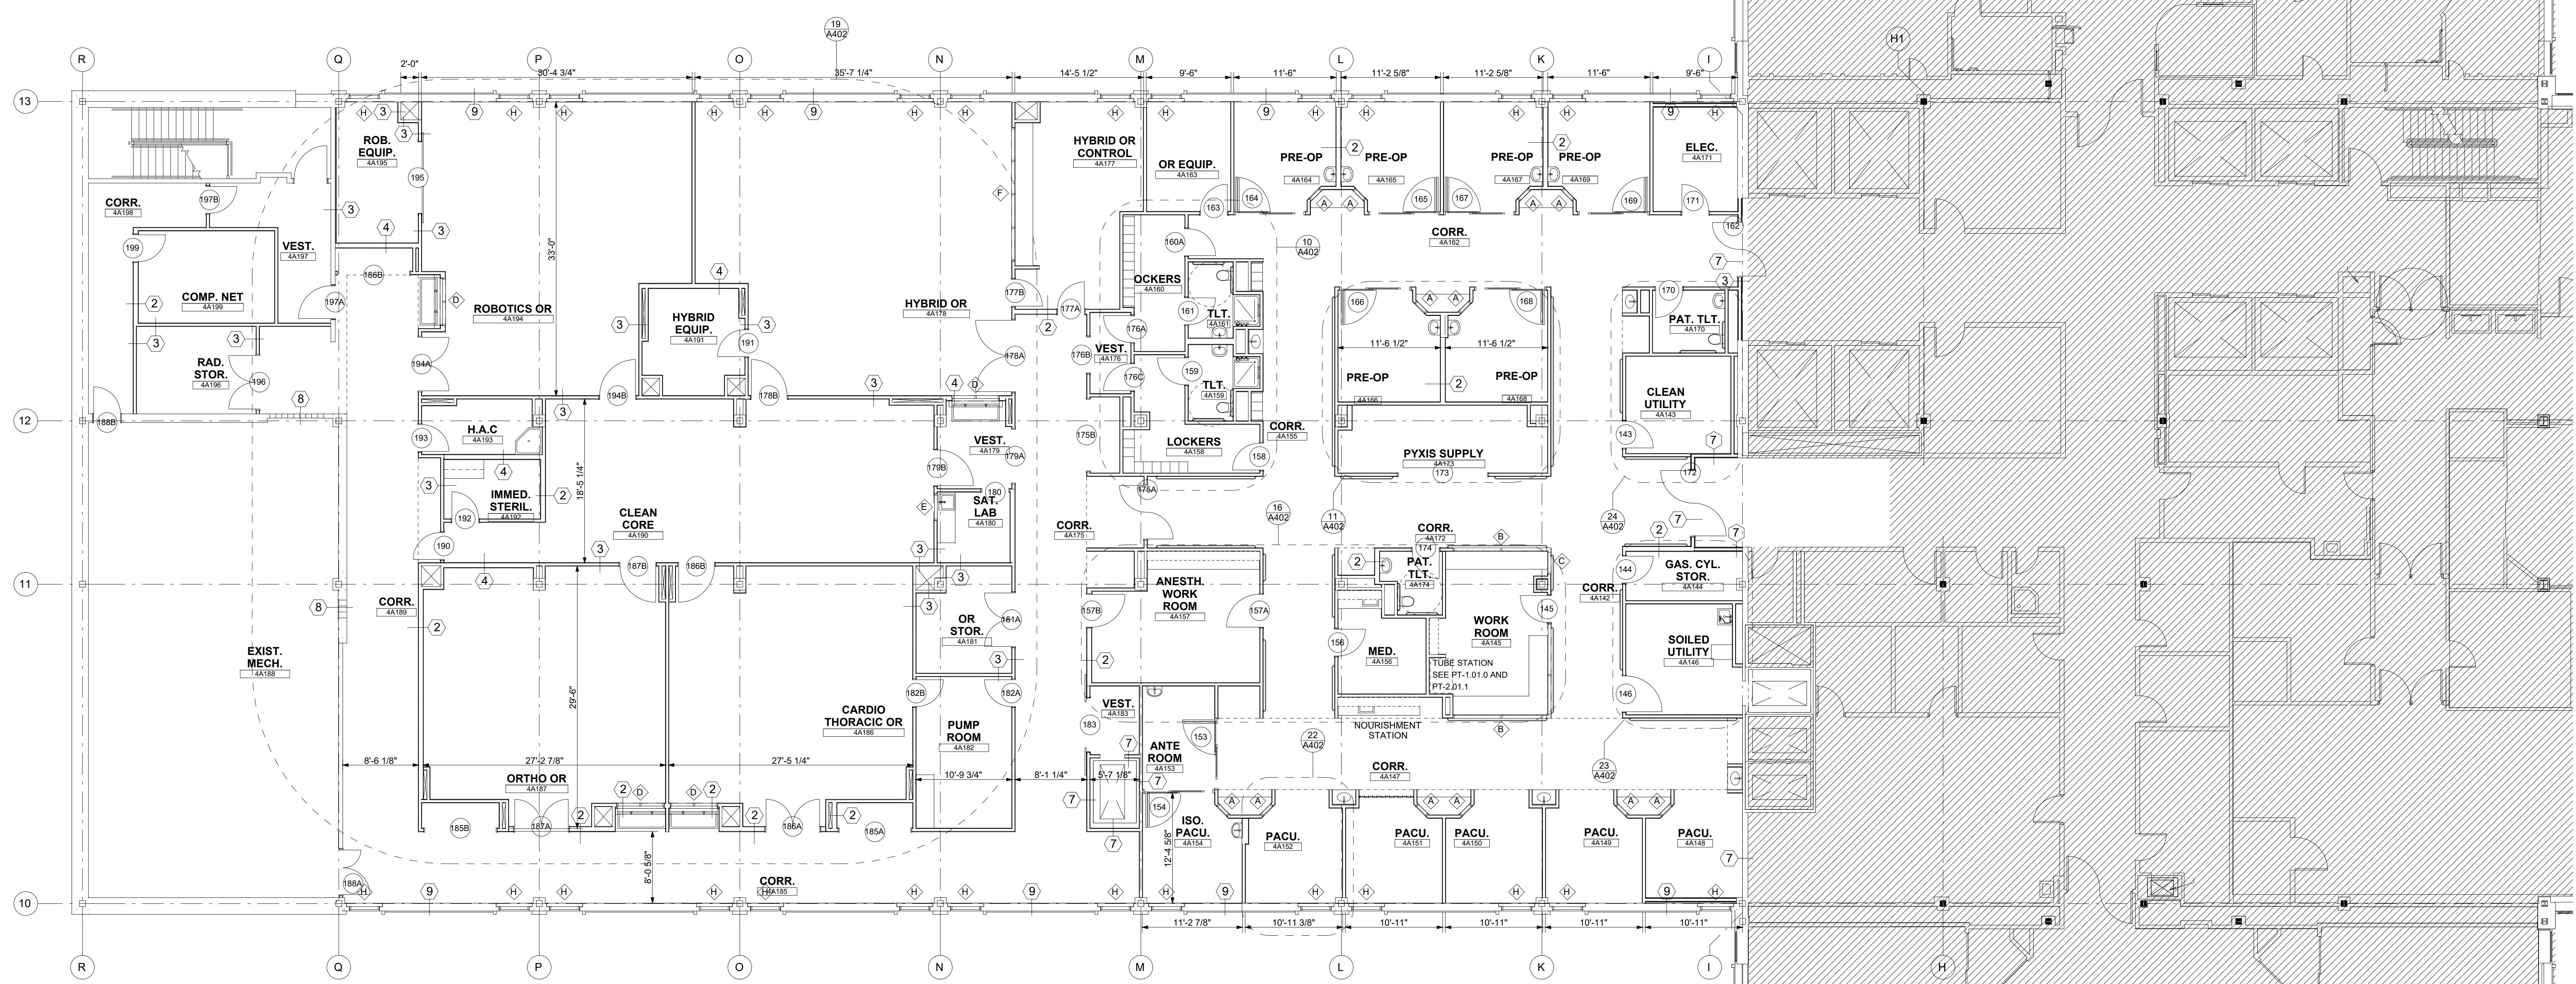


 
13 FOURTH FLOOR PLAN
SCALE: 1/8" = 1'-0"

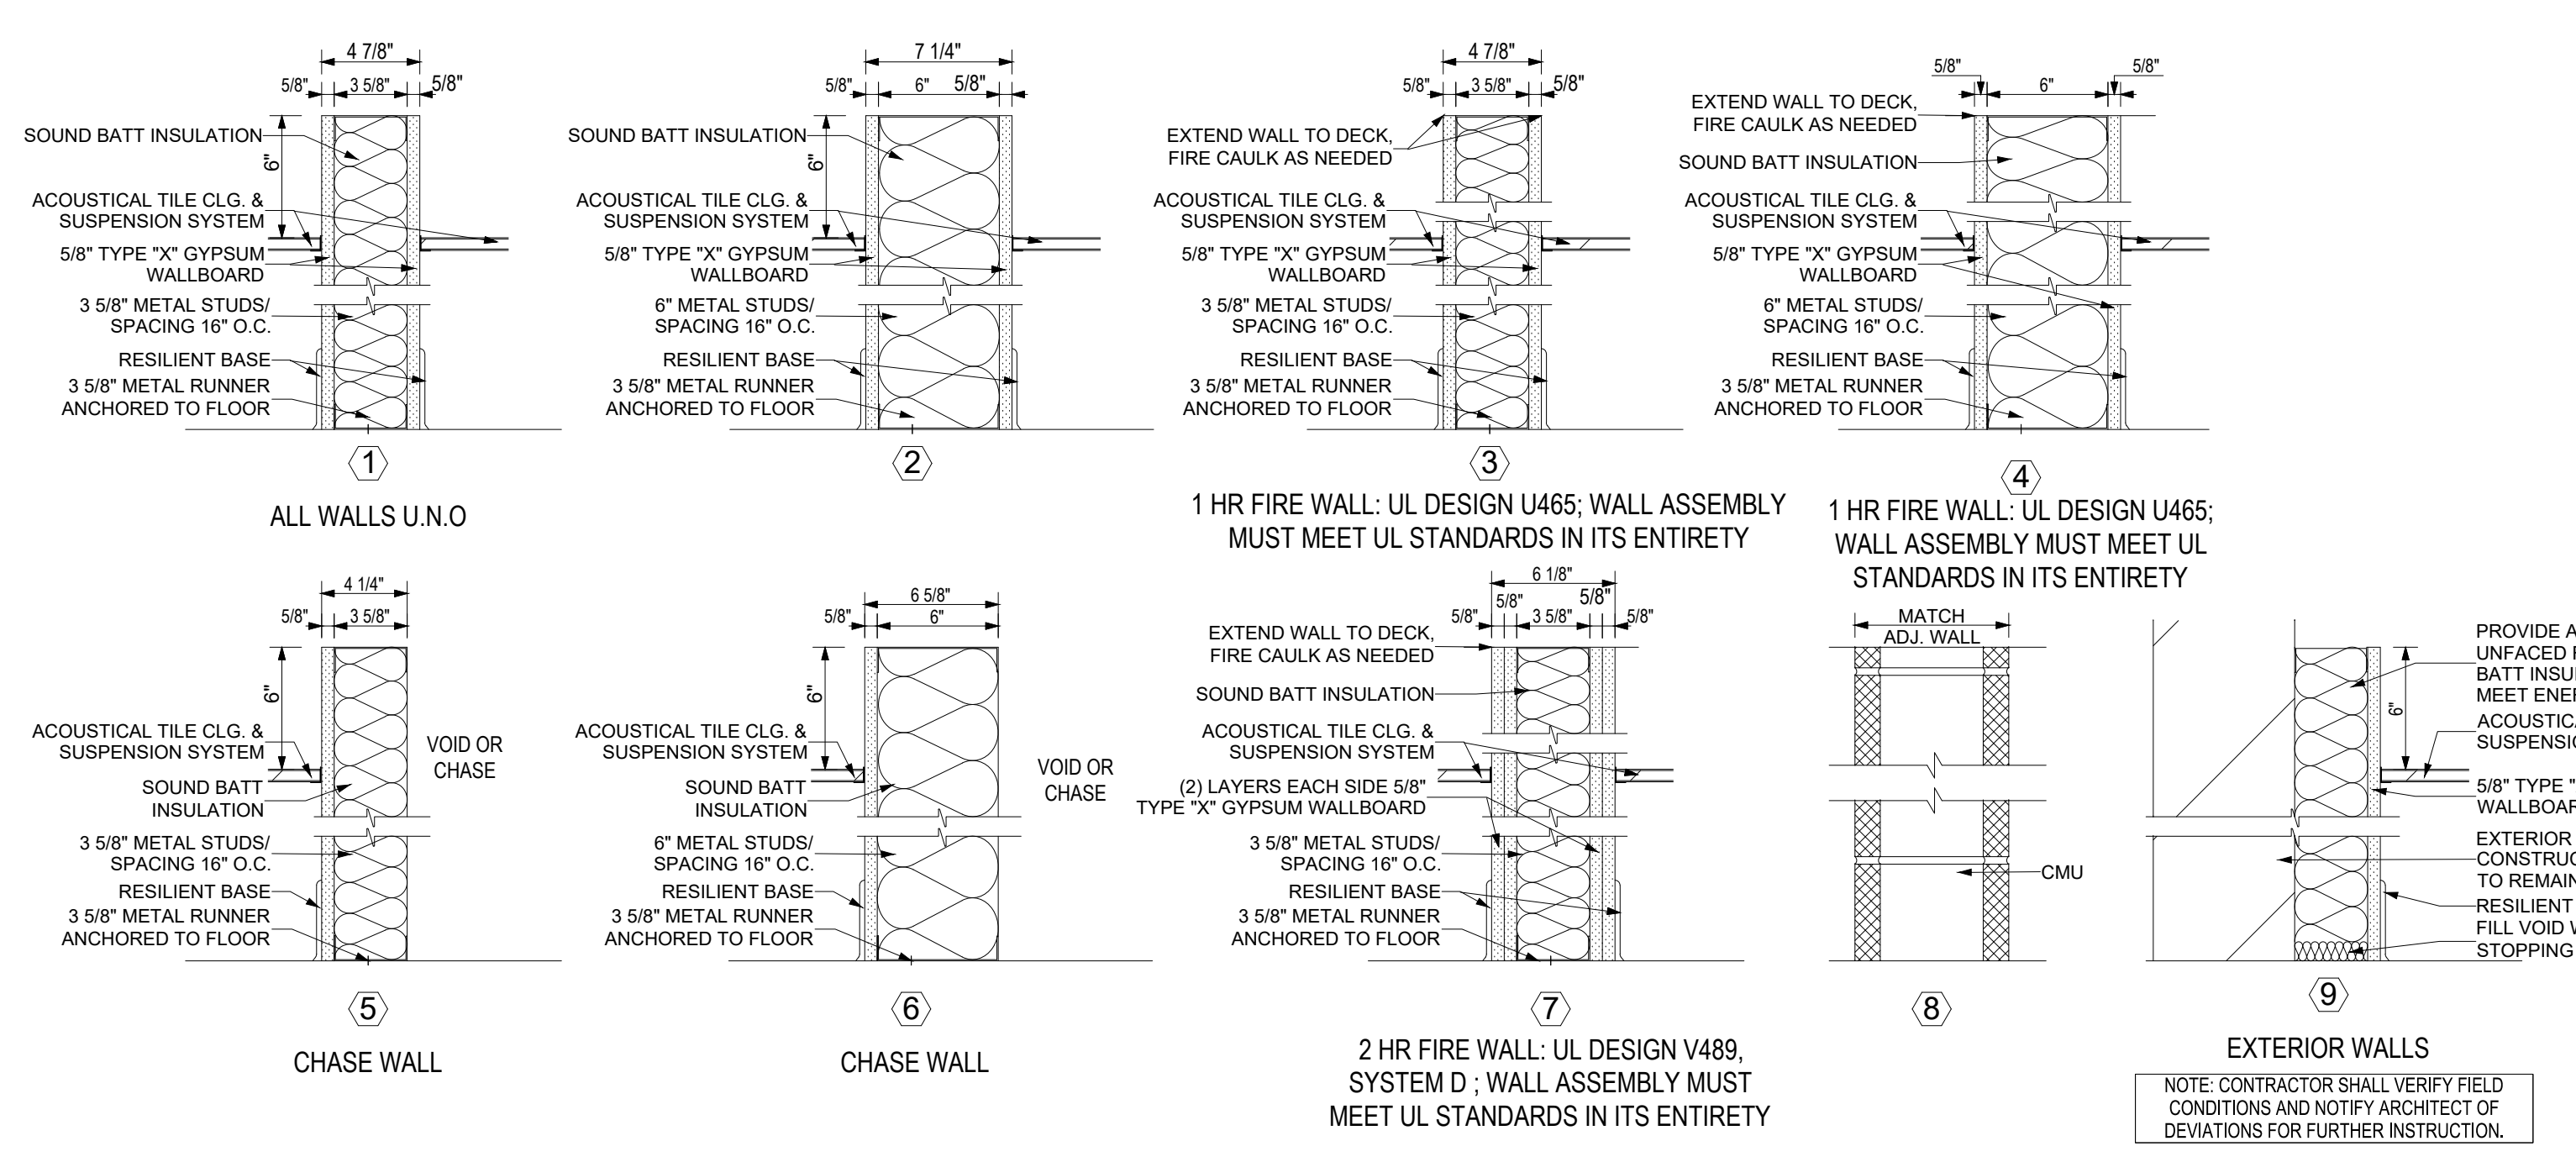

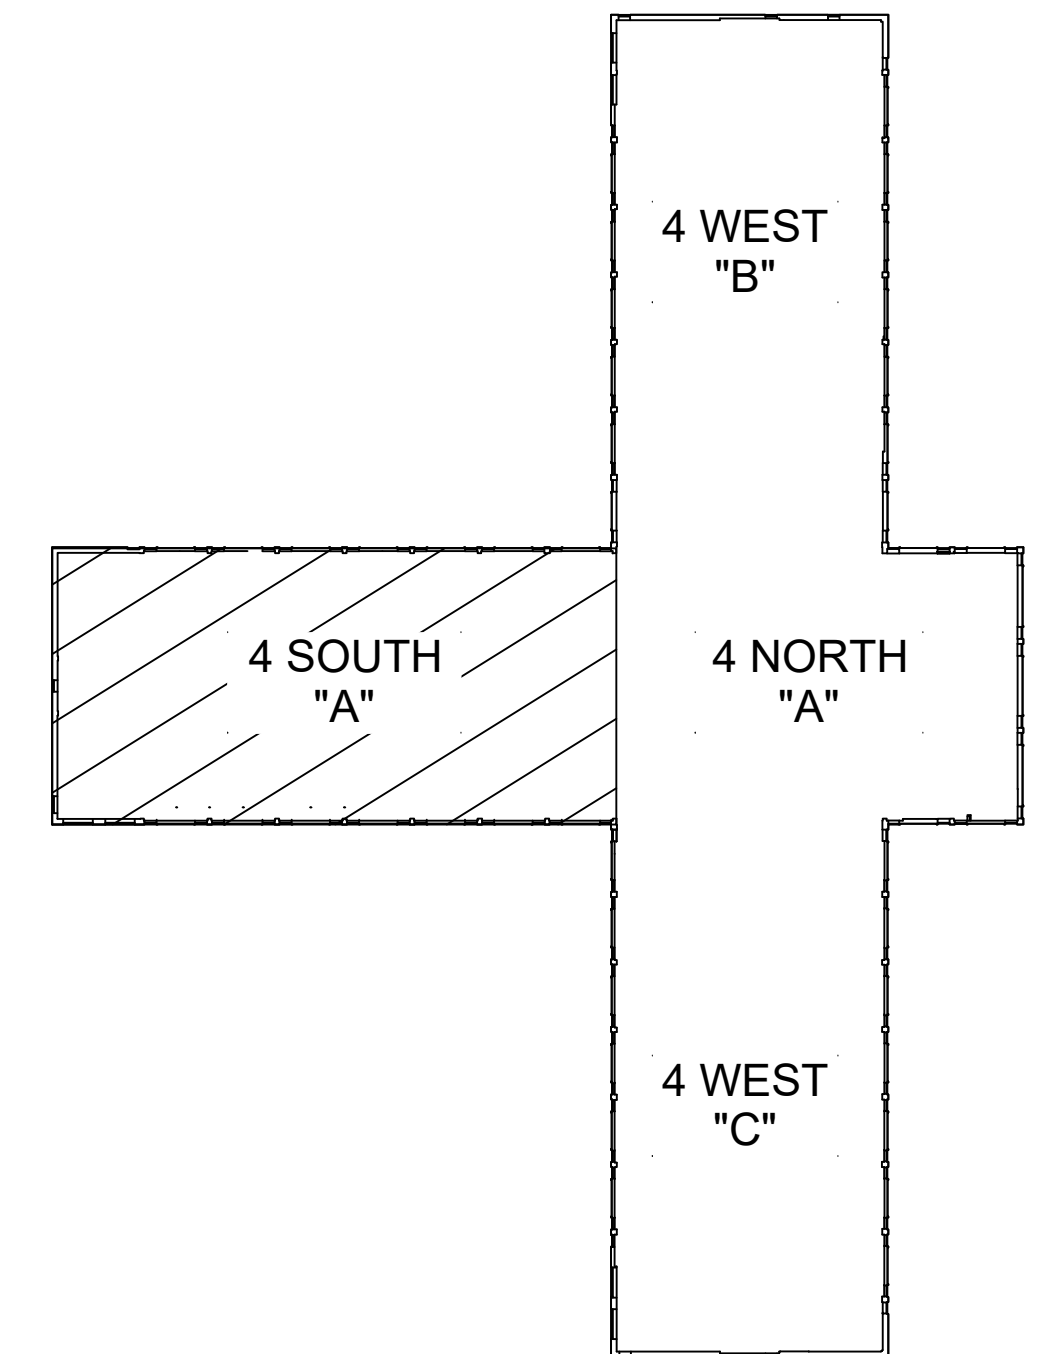19 WALL TYPES
SCALE: 1 1/2\"/>



24 FIRST FLOOR PLAN
SCALE: 1/8\"/>

DESCRIPTION-9		DATE-9	CONSULTANTS:			ARCHITECT/ENGINEERS:				Drawing Title		Project Title		Project Number		Office of Construction and Facilities Management			
DESCRIPTION-8		DATE-8				 <div>VETERANS 1ST ARCHITECTURE 10-A North Louisville Street Arlene, GA 30814 (66) 556-0197 Project Number: V16-01</div>		 <div>ING CONSULTING INC 550 11th Street Augusta, GA 30901 (706) 774-1020</div>		 <div>ELECTRICAL DESIGN CONSULTANTS 1201 Broad Street, Suite 1-A Augusta, GA 30901 (706) 724-3551 Office (706) 724-8507 Fax Project Number: 16110</div>		FOURTH FLOOR PLAN		100% BID SET RENOVATE OR SUITE				544-16-100	
DESCRIPTION-7		DATE-7										Building Number							
DESCRIPTION-6		DATE-6										100							
DESCRIPTION-5		DATE-5																	
DESCRIPTION-4		DATE-4																	
DESCRIPTION-3		DATE-3																	
DESCRIPTION-2		DATE-2																	
PRESOLICITATION RFI-1		08/20/18					Project Location		Location		Drawing Number		A401						
Revisions:		Date					WM. JENNINGS BRYAN DORN VA MEDICAL CENTER		6439 GARNERS FERRY ROAD COLUMBIA, SC										
									Date		Checked				Drawn				
											5/16/2018		LPB3		MSD		U.S. Department of Veterans Affairs		