




Partial Penthouse Framing Plan — 1/8" = 1'-0"
For framing notes, see sheet 6202.


For framing notes, see sheet S2.02.

		Department of Veterans Affairs	
Date: 08/25/08	Project Title: BLDG 650 REPLACE AIR HANDLERS 1 THRU 4, 7 AND 9 - 15	Drawing No.: S22.03	Dwg. - 01
Project No.: 61244-07-342	Building Number:	Location:	MATHER VAMC MATHER CALIFORNIA
Revisors:	Drawing Title: PARTIAL PENTHOUSE FRAMING PLAN	Designer: KYM	Checked: DAC
Approved:	Approved: Medical Center Director 550 LA GONDA WAY, SUITE E DANVILLE, CA 94526	Approved: Chief Engineering Service	Approved:




 BLDG 650





 K.F. DAVIS ENGINEERING, INC.
550 LA GONDA WAY, SUITE E
DANVILLE, CA 94526



Builder & Builder
Structural Engineers, Inc.
600 QUINN AVENUE, SUITE 200
DANVILLE, CA 94526
925/4543303 fax 925/4543313




Date:	08/25/08
Project No.:	612A4-07-342
DRAWING No.	S2.03
Dwg. Of	

Project Title:	BLDG 650 REPLACE AIR HANDLERS 1 THRU 4, 7 AND 9 - 15
Building Number:	
Location:	MATHER VAMC MATHER CALIFORNIA

Drawing Title	PARTIAL PENTHOUSE FRAMING PLAN	
Approved: Medical Center Director	Drawn: KYM	Checked: DAC
Approved: Chief, Engineering Service		


Revisions:	
Approved:	
Approved:	



K.F. DAVIS ENGINEERING, INC.
530 LA GONDA WAY, SUITE E
DANVILLE, CA 94526



Buehler & Buehler
Structural Engineers, Inc.
2000 N. 10th St., Suite 200
Chicago, IL 60642-3981
tel 312/643.1000 fax 312/643.1011

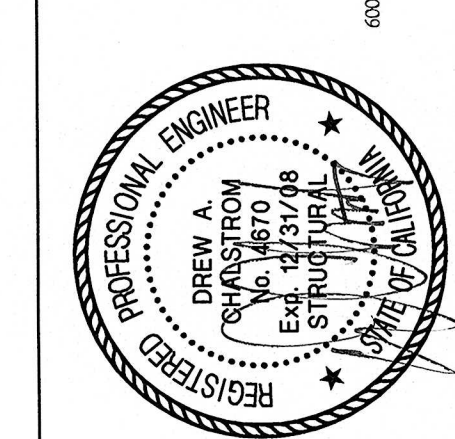

SCALE: 1/8" = 1'