


BUILDING 650
REPLACE AIR HANDLERS
1 THRU 4, 7 AND
9 THRU 15



SACRAMENTO V. A. MEDICAL CENTER
MATHER, CALIFORNIA



VICINITY AND SITE PLANS

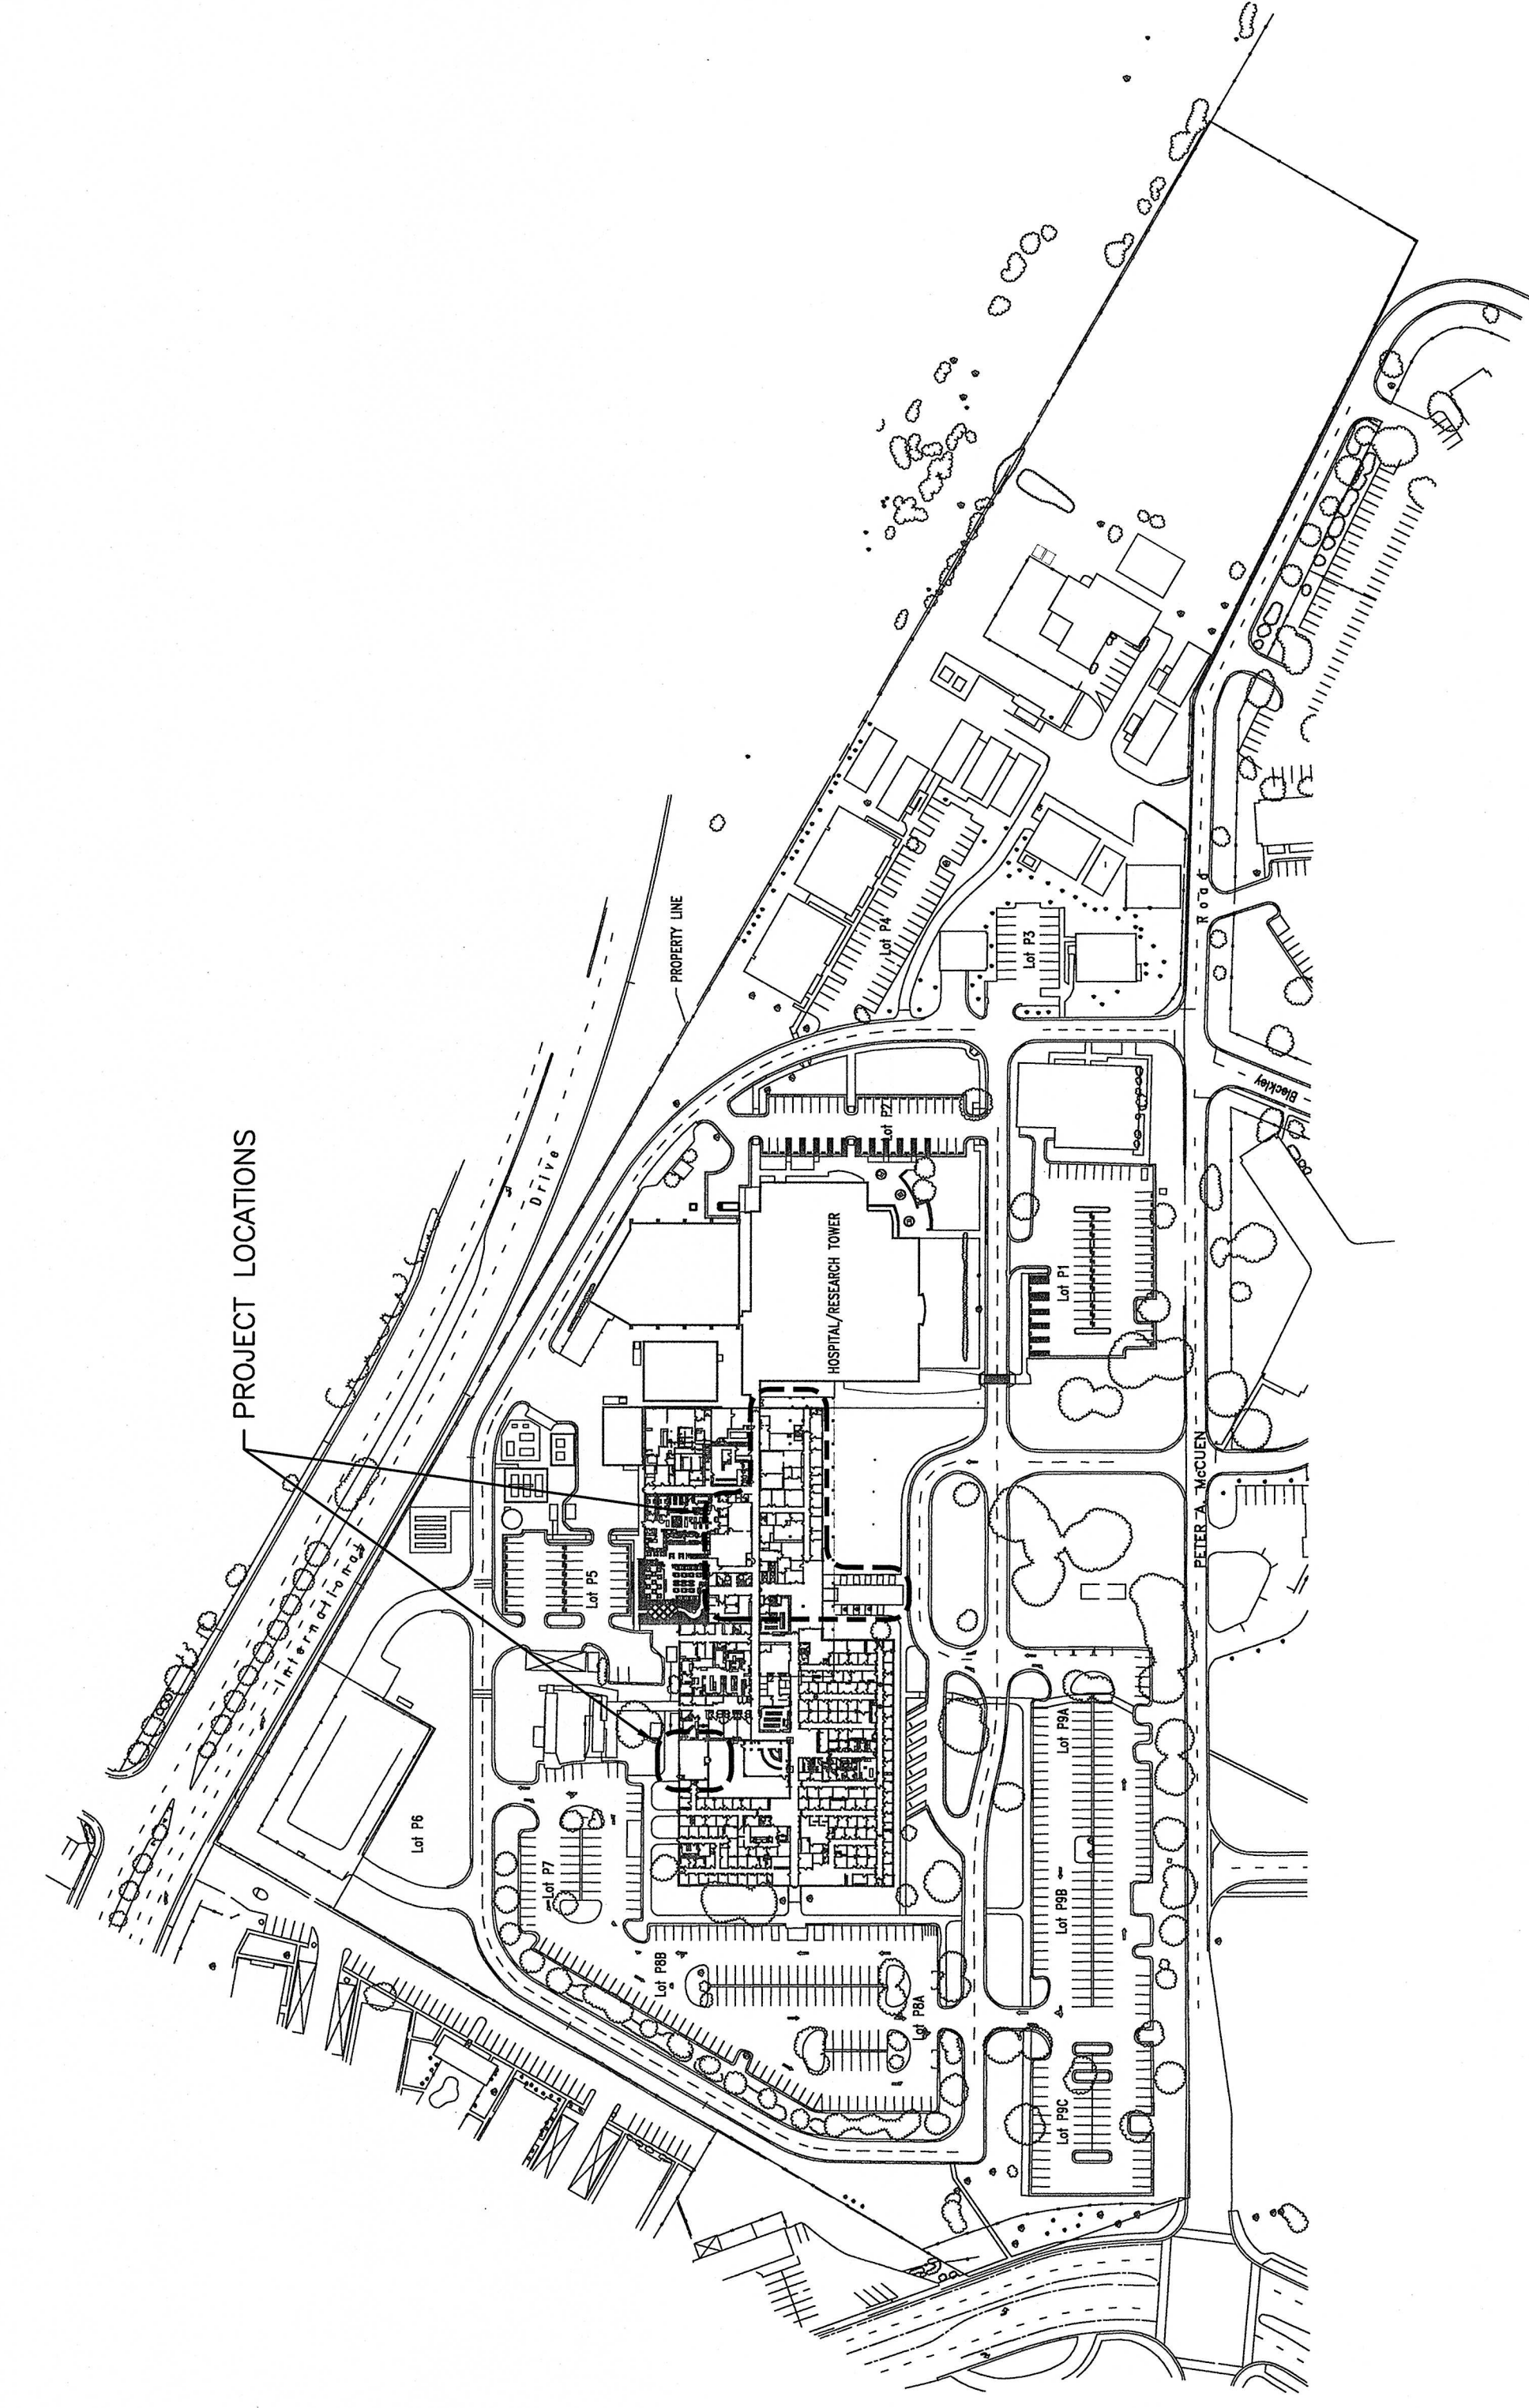

SACRAMENTO V. A. MEDICAL CENTER
MATHER, CALIFORNIA

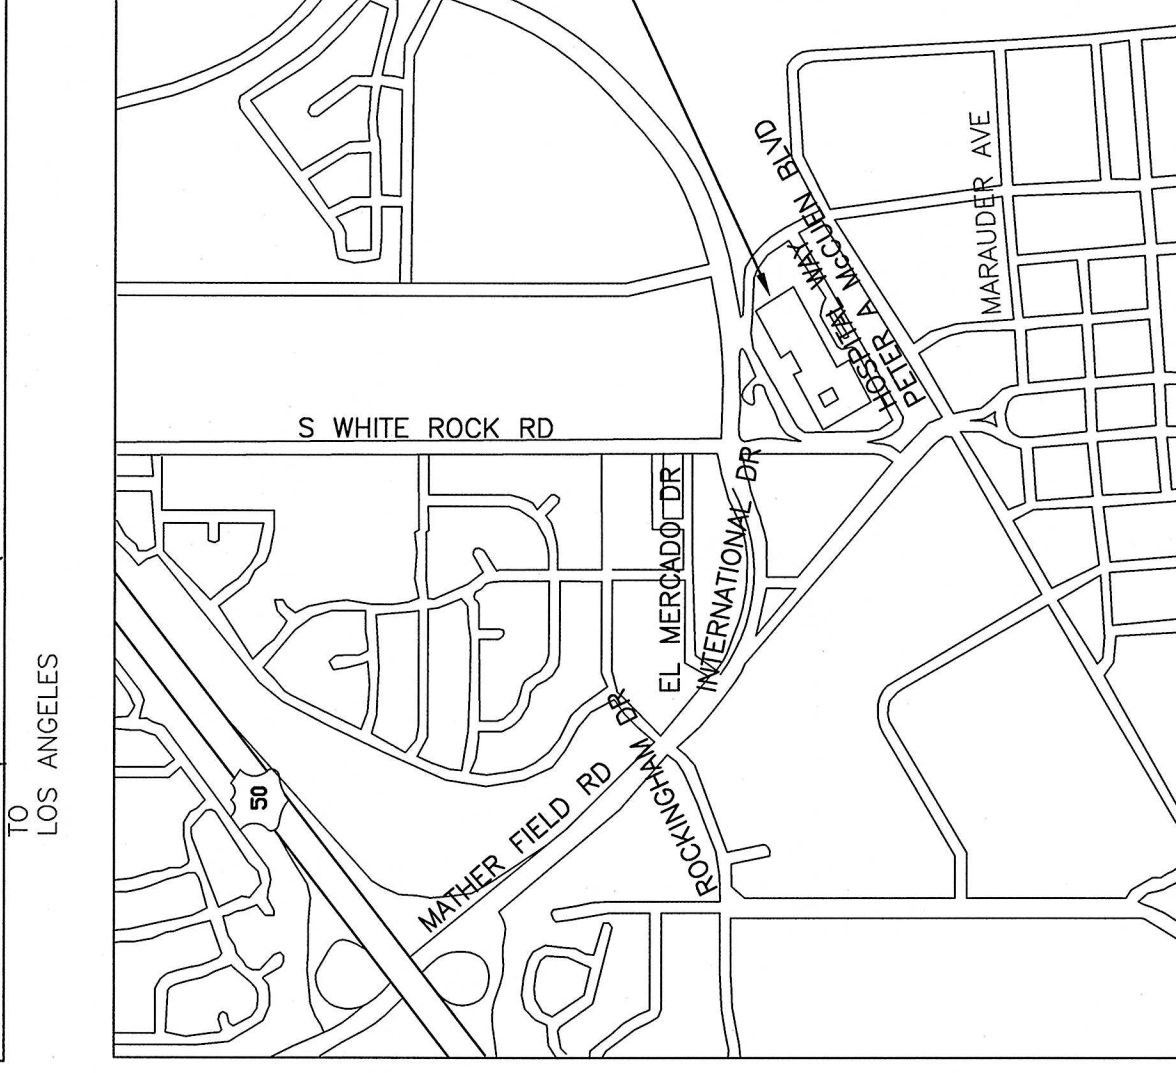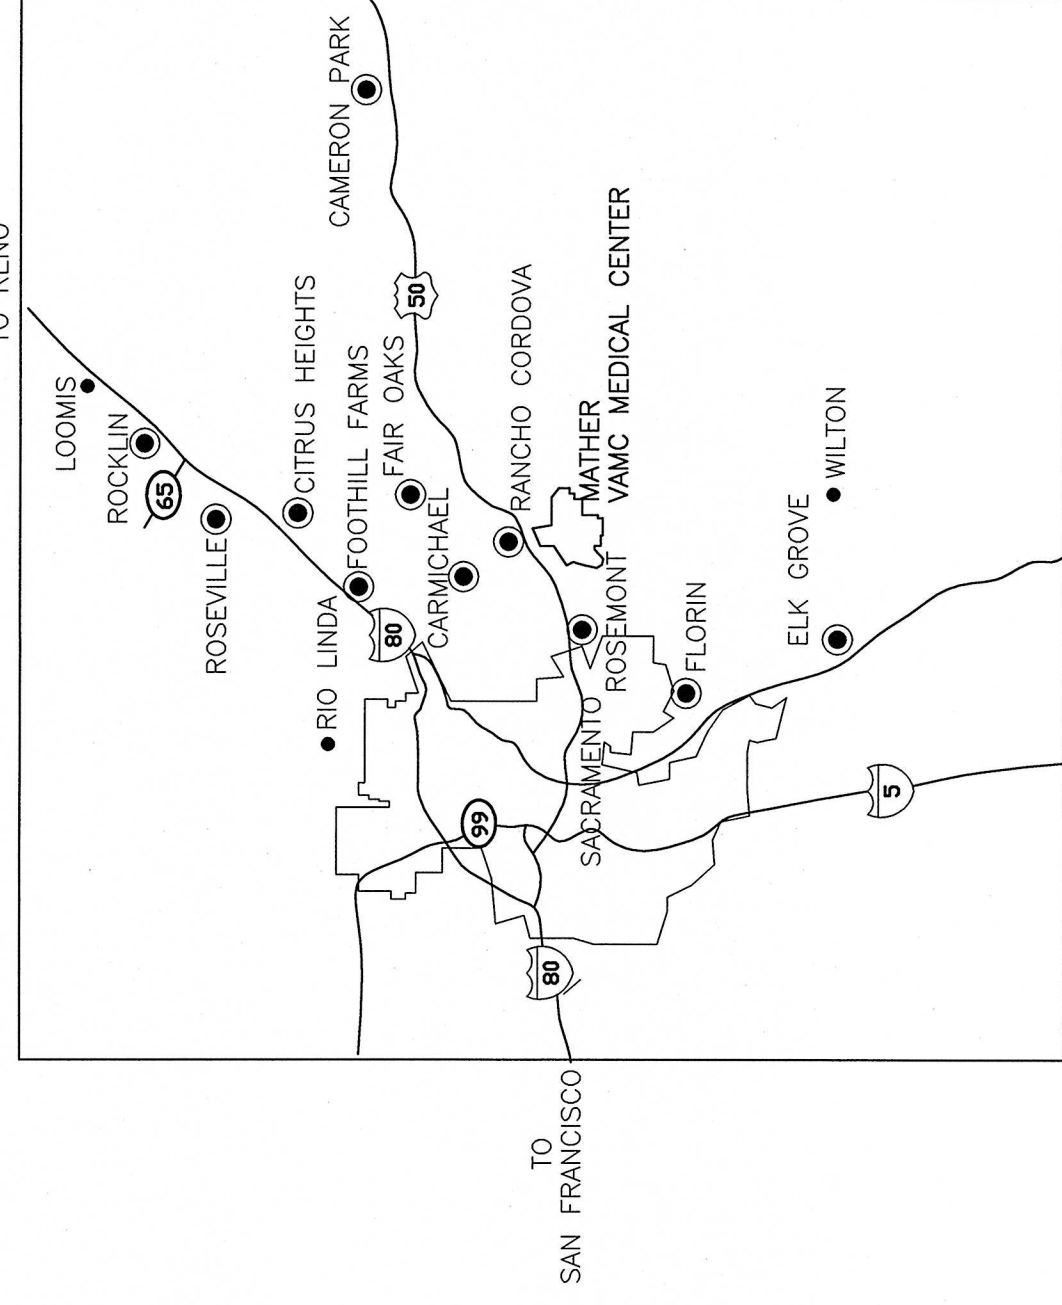

REPLACE B650 AHU's

IN ADDITION TO THE REQUIREMENTS STATED ELSEWHERE IN THE DRAWINGS AND SPECIFICATIONS, AT A MINIMUM THE CONTRACTOR SHALL PROVIDE THE FOLLOWING:

A. AUTOMATIC SPRINKLERS

CONTRACTOR SHALL, ON A DESIGNBUILD BASIS, RELOCATE AUTOMATIC SPRINKLER PIPING WHERE THE ADDITION OF VAV'S AND/OR DUCTS CONFLICT WITH EXISTING SPRINKLER PIPING. EXISTING SPRINKLERS ARE TO REMAIN. NEW SPRINKLER PIPING WORK SHALL COMPLY WITH THE REQUIREMENTS OF THE 2002 EDITION OF NFPA 13.

B. FIRE ALARM

CONTRACTOR SHALL PROVIDE FIRE ALARM WORK ON A DESIGNBUILD BASIS. DUCT SMOKE DETECTORS SHALL BE PROVIDED AT NEW AHU'S EXCEEDING 2,000 CFM WHICH, WHEN ACTIVATED, SHALL SHUT DOWN ALL EXISTING AUTOMATIC SPRINKLER SYSTEMS. ALL DETECTORS SHALL BE COMPATIBLE WITH THE EXISTING FIRE ALARM SYSTEM. THE FIRE ALARM SEQUENCE OF OPERATION FOR THE BUILDING SHALL BE FOLLOWED, WHICH INCLUDES ACTIVATING NOTIFICATION APPLIANCES THROUGHOUT THE BUILDING UPON ACTIVATION OF A DUCT SMOKE DETECTOR. ALL WORK SHALL COMPLY WITH THE REQUIREMENTS OF THE 2002 EDITION OF NFPA 72, THE NATIONAL ELECTRICAL CODE AND VA STANDARDS.

REVISION 1

Project Title:	BLDG 650 REPLACE AIR HANDLERS 1 THRU 4, 7 AND 9 - 15	Scale:	08/25/08
Project No.:	61244-07-342	Project No.:	61244-07-342
Building Number:		DRAWING No.:	T1.1
Drawn:	RMK	Check:	
Approved: Medical Center Director		Location:	MATHER VAMC
Approved: Chief, Engineering Service		Dwg. Of	
			MATHER CALIFORNIA

