
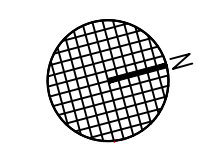


KEY

- [A] OR CORRIDOR SEPARATION 2AS/10NRM||OR CORRIDOR SEPARATION||695-10-149||C00855
- [B] GIGU STERILE CLEANING RM MODS/07NRM||GIGU||695-07-339||C90794 & C70792
- [C] OR PACU RENOVATION/09MINOR||OR PACU||695-228||Z70001
- [D] INSTALL N2 LINE TO O.R. 8/10NRM||INSTALL N2 LINE||695-10-144||C00893
- [E] INSTALL ICU TELEMED CAMERAS /10NRM||ICU CAMERAS||695-10-144||C00904
- [F] ISOLATION RM CONTROLS PH.2/09NRM||ISOLATION RM||695-07-104||C90364
- [G] 111 INSTALL CHILLER AHU-V17/11NRM||V-17||695-11-146||C10527 & Z10001
- [H] ANGIO 2 SUITE RENOVATION/09NRM||ANGIO||695-09-101||C00922
- [J] 111 REPLACE COMMON FLOORING 1-2, 8 & 9/11NRM||FLOORING/WALLS||695-11-157||C10763
- [K] EMPLOYEE LOCKERS/09NRM||LOCKERS, MINOR ARCH MODS||695-09-167||C90628
- [L] LAB 2CN VAR. RM. REMODEL/08NRM||VAR RMS PLMB, ELEC, DATA & COM FLOORING PAINT CEILINGS||695-08-900||C80818 & C90593
- [M] LAB 2CN RM 2623 REMODEL/08NRM||PMBG & HVAC||695-08-918||C80774
- [N] 111 INSTALL ANGIO 1 BI-PLANE/12NRM||INSTALL BI-PLANE||695-12-122||
- [O] 111 INSTLL GI PHILLIPS DIAGNOSTIC ELEVA/12NRM||INSTALL ELEVA||695-12-206||
- [P] 111 UPGRADE MRI SECURITY ZONES 3 & 4/12NRM||UPGRADE MRI SECURITY||695-12-147
- [Q] ERCT SCAN/07NRM||ERCT||695-07-370||C8067
- [R] SCI CONNECTING CORRIDOR/MINORS/09 MINORS||SCI CC||695-320||Z00001
- [S] CORRECT JCAHO DEFICIENCIES/13NRM||JCAHO DEF||695-13-1114||C30339
- [T] 111 UPGRADE LAB 2CN HVAC/11NRM||2CN LAB||695-11-104||C20638
- [U] 111 UPGRADE ICU/13NRM||UPGRADE ICU||695-13-146||C30348
- [V] 111 UPGRADE GI GU NURSE CALL/14NRM/695-14-138
- [W] 111 UPGRADE APC NURSE CALL/14NRM/695-14-137
- [X] 111 RENOVATE XRAY 5/12NRM/695-12-195
- [Y] 111 UPGRADE 3T MRI SUITE/CSI/695-CSI-145
- [Z] 1AMBULATORY SURGERY CENTER/MINORS/00/695-205
- [AA] AMBULATORY PROCEDURE CENTER/MINORS/00/695-206
- [BB] CONSOLIDATE ICU/MINORS/03/695-217
- [CC] 111 TJC AND SAFETY CORRECTIONS FY2015/15NRM/695-15-122
- [DD] 111 UPGRADE HVAC VARIOUS V-7, V-12, S-3 (MER 4, PH1)/13 NRM/695-13-164
- [EE] UPGRADE SMALL VARIOUS AC COMPONENTS AND UNITS/17NRM/695-17-109
- [FF] REPLACE AHU V13, AC4 (MER 5, PH2)/16NRM/695-16-119
- [GG] 111 UPGRADE UROLOGY ROOM/15 NRM/695-14-126
- [HH] SITE ELECTRICAL CORRECTIONS/16NRM/695-16-117

ENTIRE FLOOR: REPLACE FIRE ALARM SYSTEM/09NRM||695-09-151||C90855


111 REKEY BLDG/12NRM/695-12-124

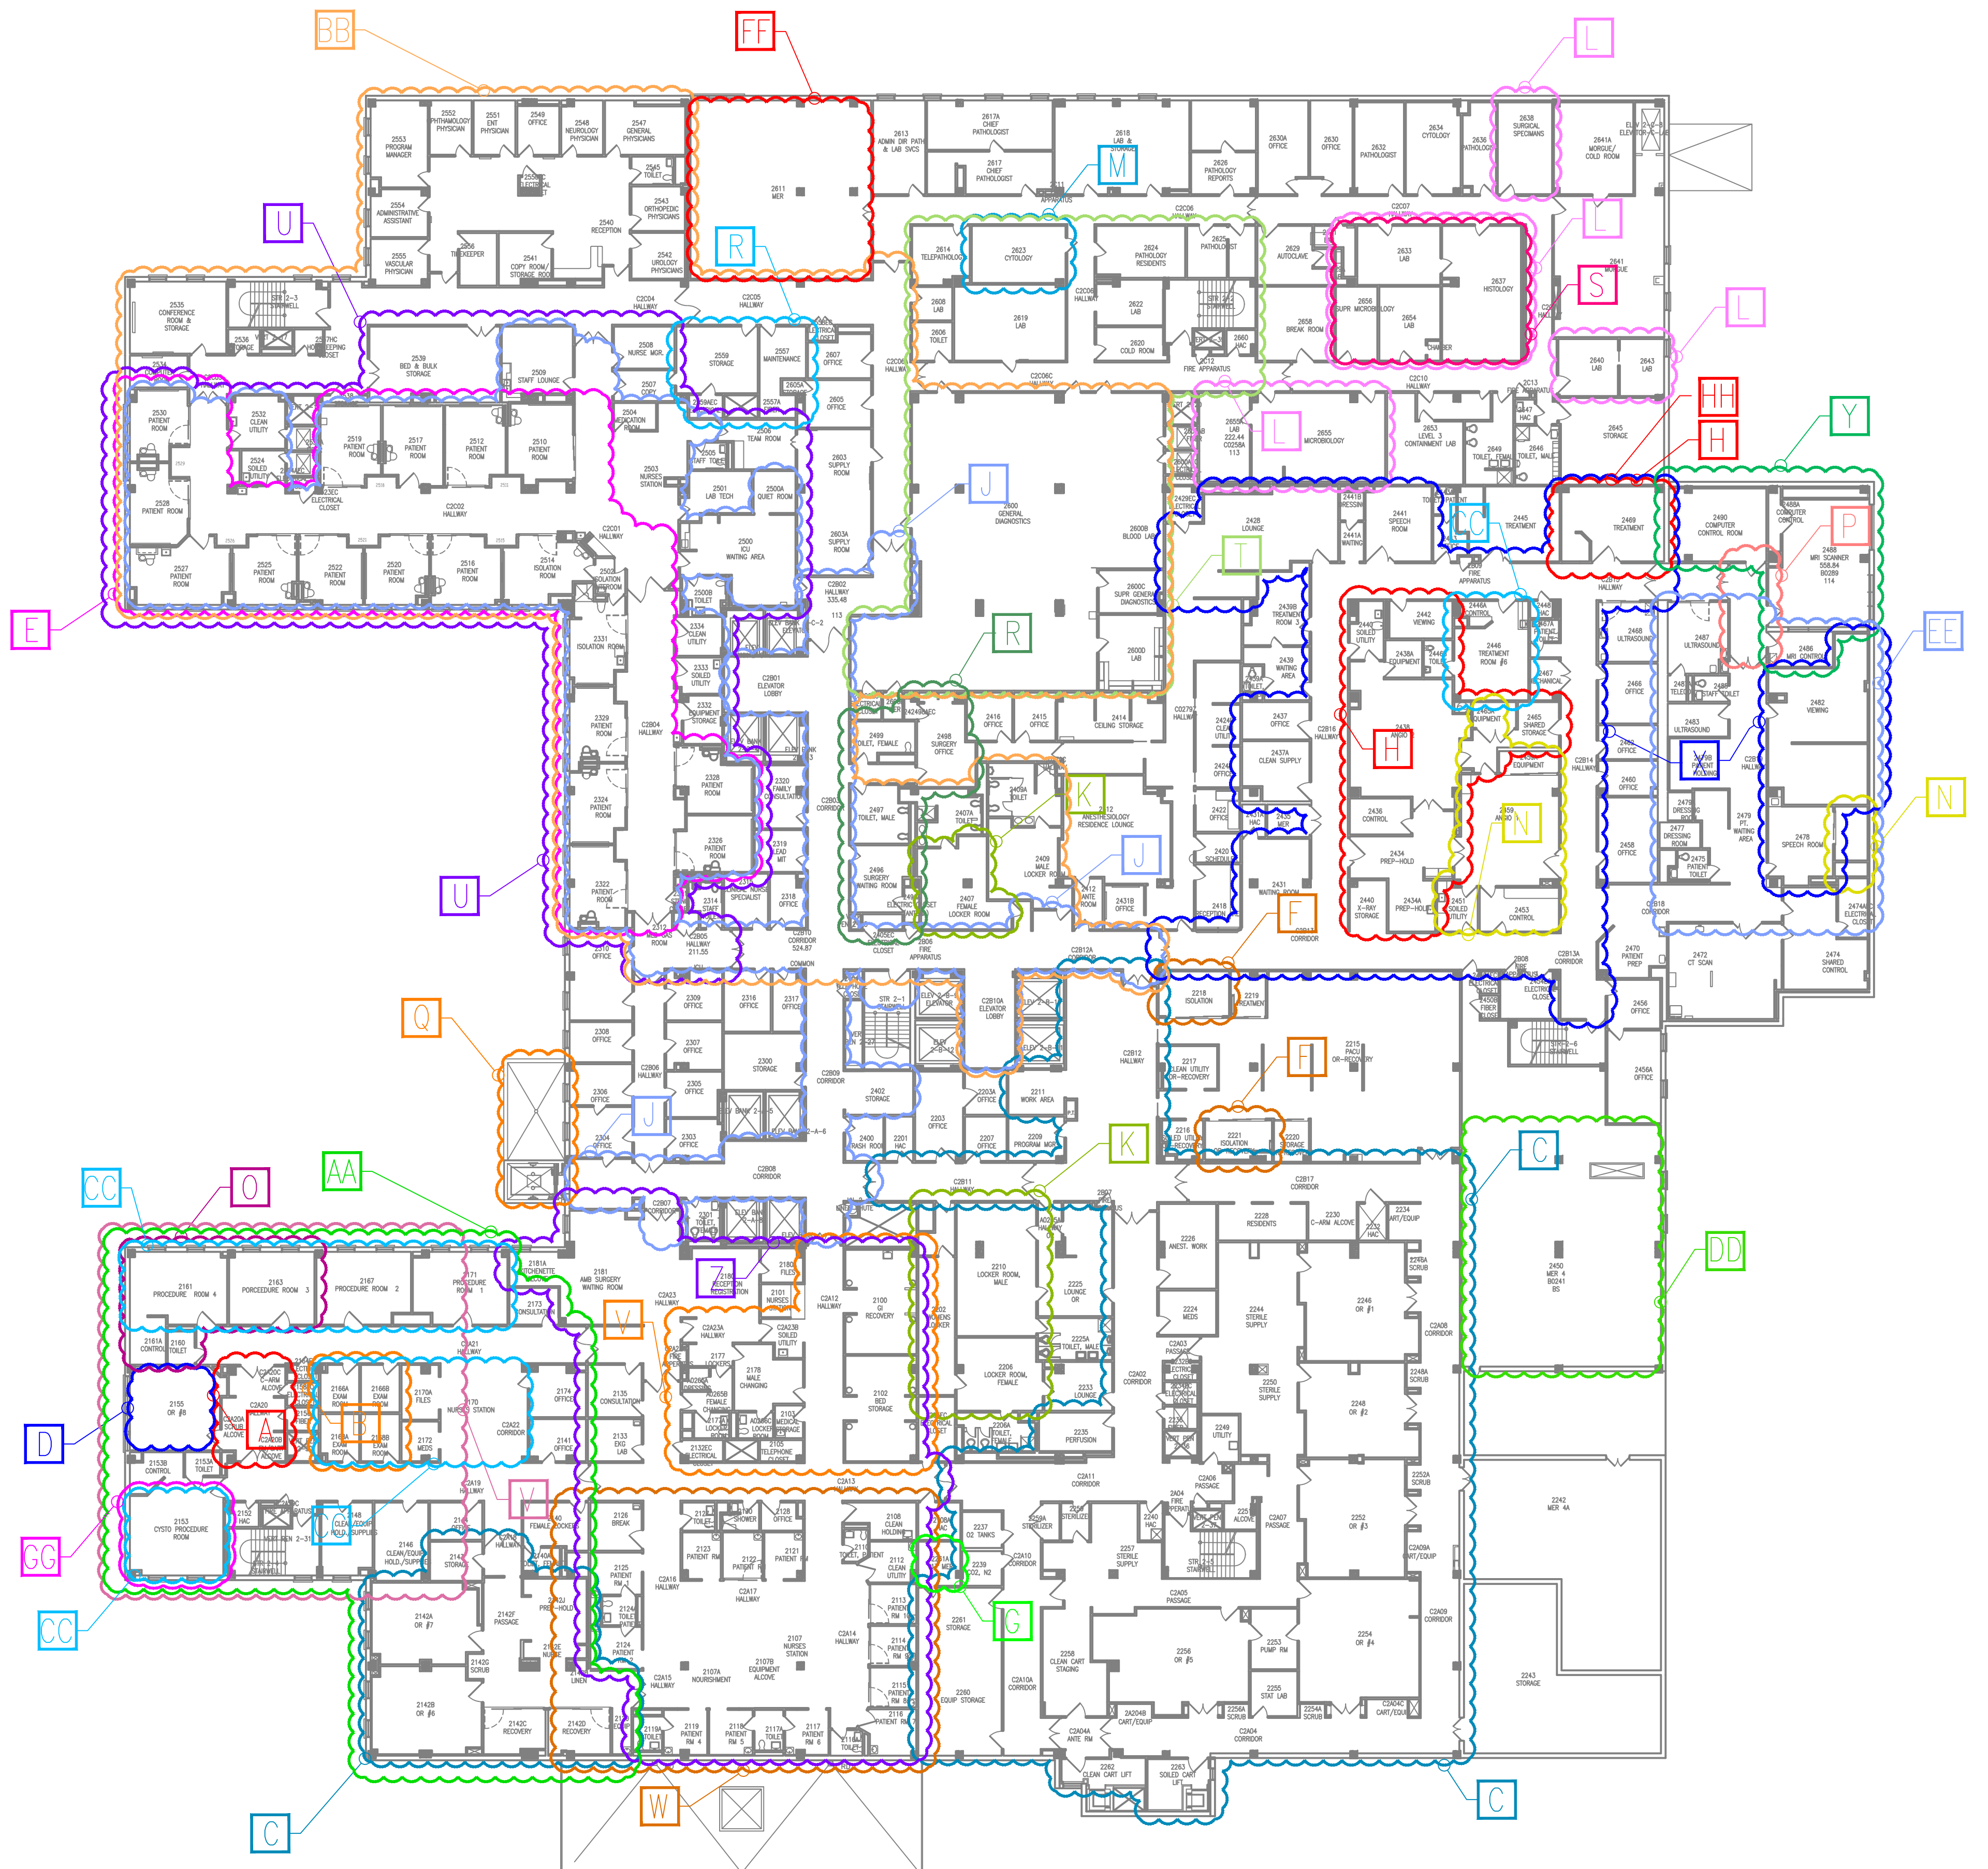


SECOND FLOOR PLAN


N.T.S.

Revisions	Date

 Dept. of Veterans Affairs
Medical Center
5000 W. National Avenue
Milwaukee, WI



KEY PLAN: 

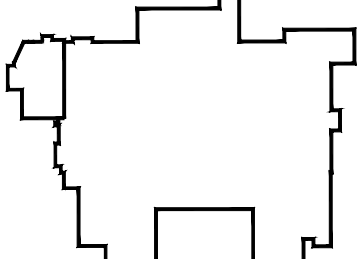

ENGINEER:

ARCHITECT:

Drawing Title
**SECOND FLOOR PLAN
FLOOR AS-BUILT RECORD**

Approved Project Director

Project Title
-

Location
VA Medical Center, Milwaukee, WI

Date
11/13/2017

Checked
-


Drawn
mwm

Project Number
-

Building Number
Building 111

Drawing Number
111-02
3 of 14

Office of
Construction
and Facilities
Management

 Department of
Veterans Affairs