


three inches = one foot
one and one half inches = one foot
one inch = one foot
three quarters inch = one foot
one half inch = one foot
three eighths inch = one foot
one quarter inch = one foot
one eighth inch = one foot

KEY

- 111 REPLACE FLOORING 3-10/12NRM||FLOORING||695-12-166||C20709
- 111 REPAIR 119 PHARMACY IV LAB HOODS/11NRM||695-11-111||C10917
- IMPROVE MH ENGAGEMENT CENTER/11NRM||3CS ENGAGEMENT||C1093628
- 3C MENTAL HEALTH/04NRM||3C MH||695-04-134||C60766,
- 3C SAFETY ENHANCEMENTS/08NRM||3C SAFETY||695-08-120||C70747, C70746
- 3C MENTAL HEALTH/04NRM||3C MH||695-04-???||C80365
- 3C SAFETY ENHANCEMENT/08NRM||3C SAFETY||695-08-???||C80367
- 3A N&S MENTAL HEALTH OFFICES/08NRM||3A N&S||695-08-108||C10910
- FCA FIRE ALARM VOICE ACTIVATION/09NRM||FA VOICE ACTIVATION||695-09-149||C90851
- 111 UPGRADE PUBLIC RESTROOMS/11NRM||FY11 JOC||111 UPGRADE PUBLIC RESTROOMS
- 111 REPLACE SURGERY CHILLERS/13NRM||FY11 JOC||695-13-139
- 111 TJC AND SAFETY CORRECTIONS FY2015/15NRM/695-15-122
- 111 UPGRADE HVAC VARIOUS V-7, V-12, S-3 (MER 4, PH1)/13 NRM/695-13-164
- FY17 SAFETY AND TJC CORRECTIONS/17NRM/695-17-106

ENTIRE FLOOR: REPLACE FIRE ALARM SYSTEM/09NRM||695-09-151||C90855
111 REKEY BLDG/12NRM/695-12-124

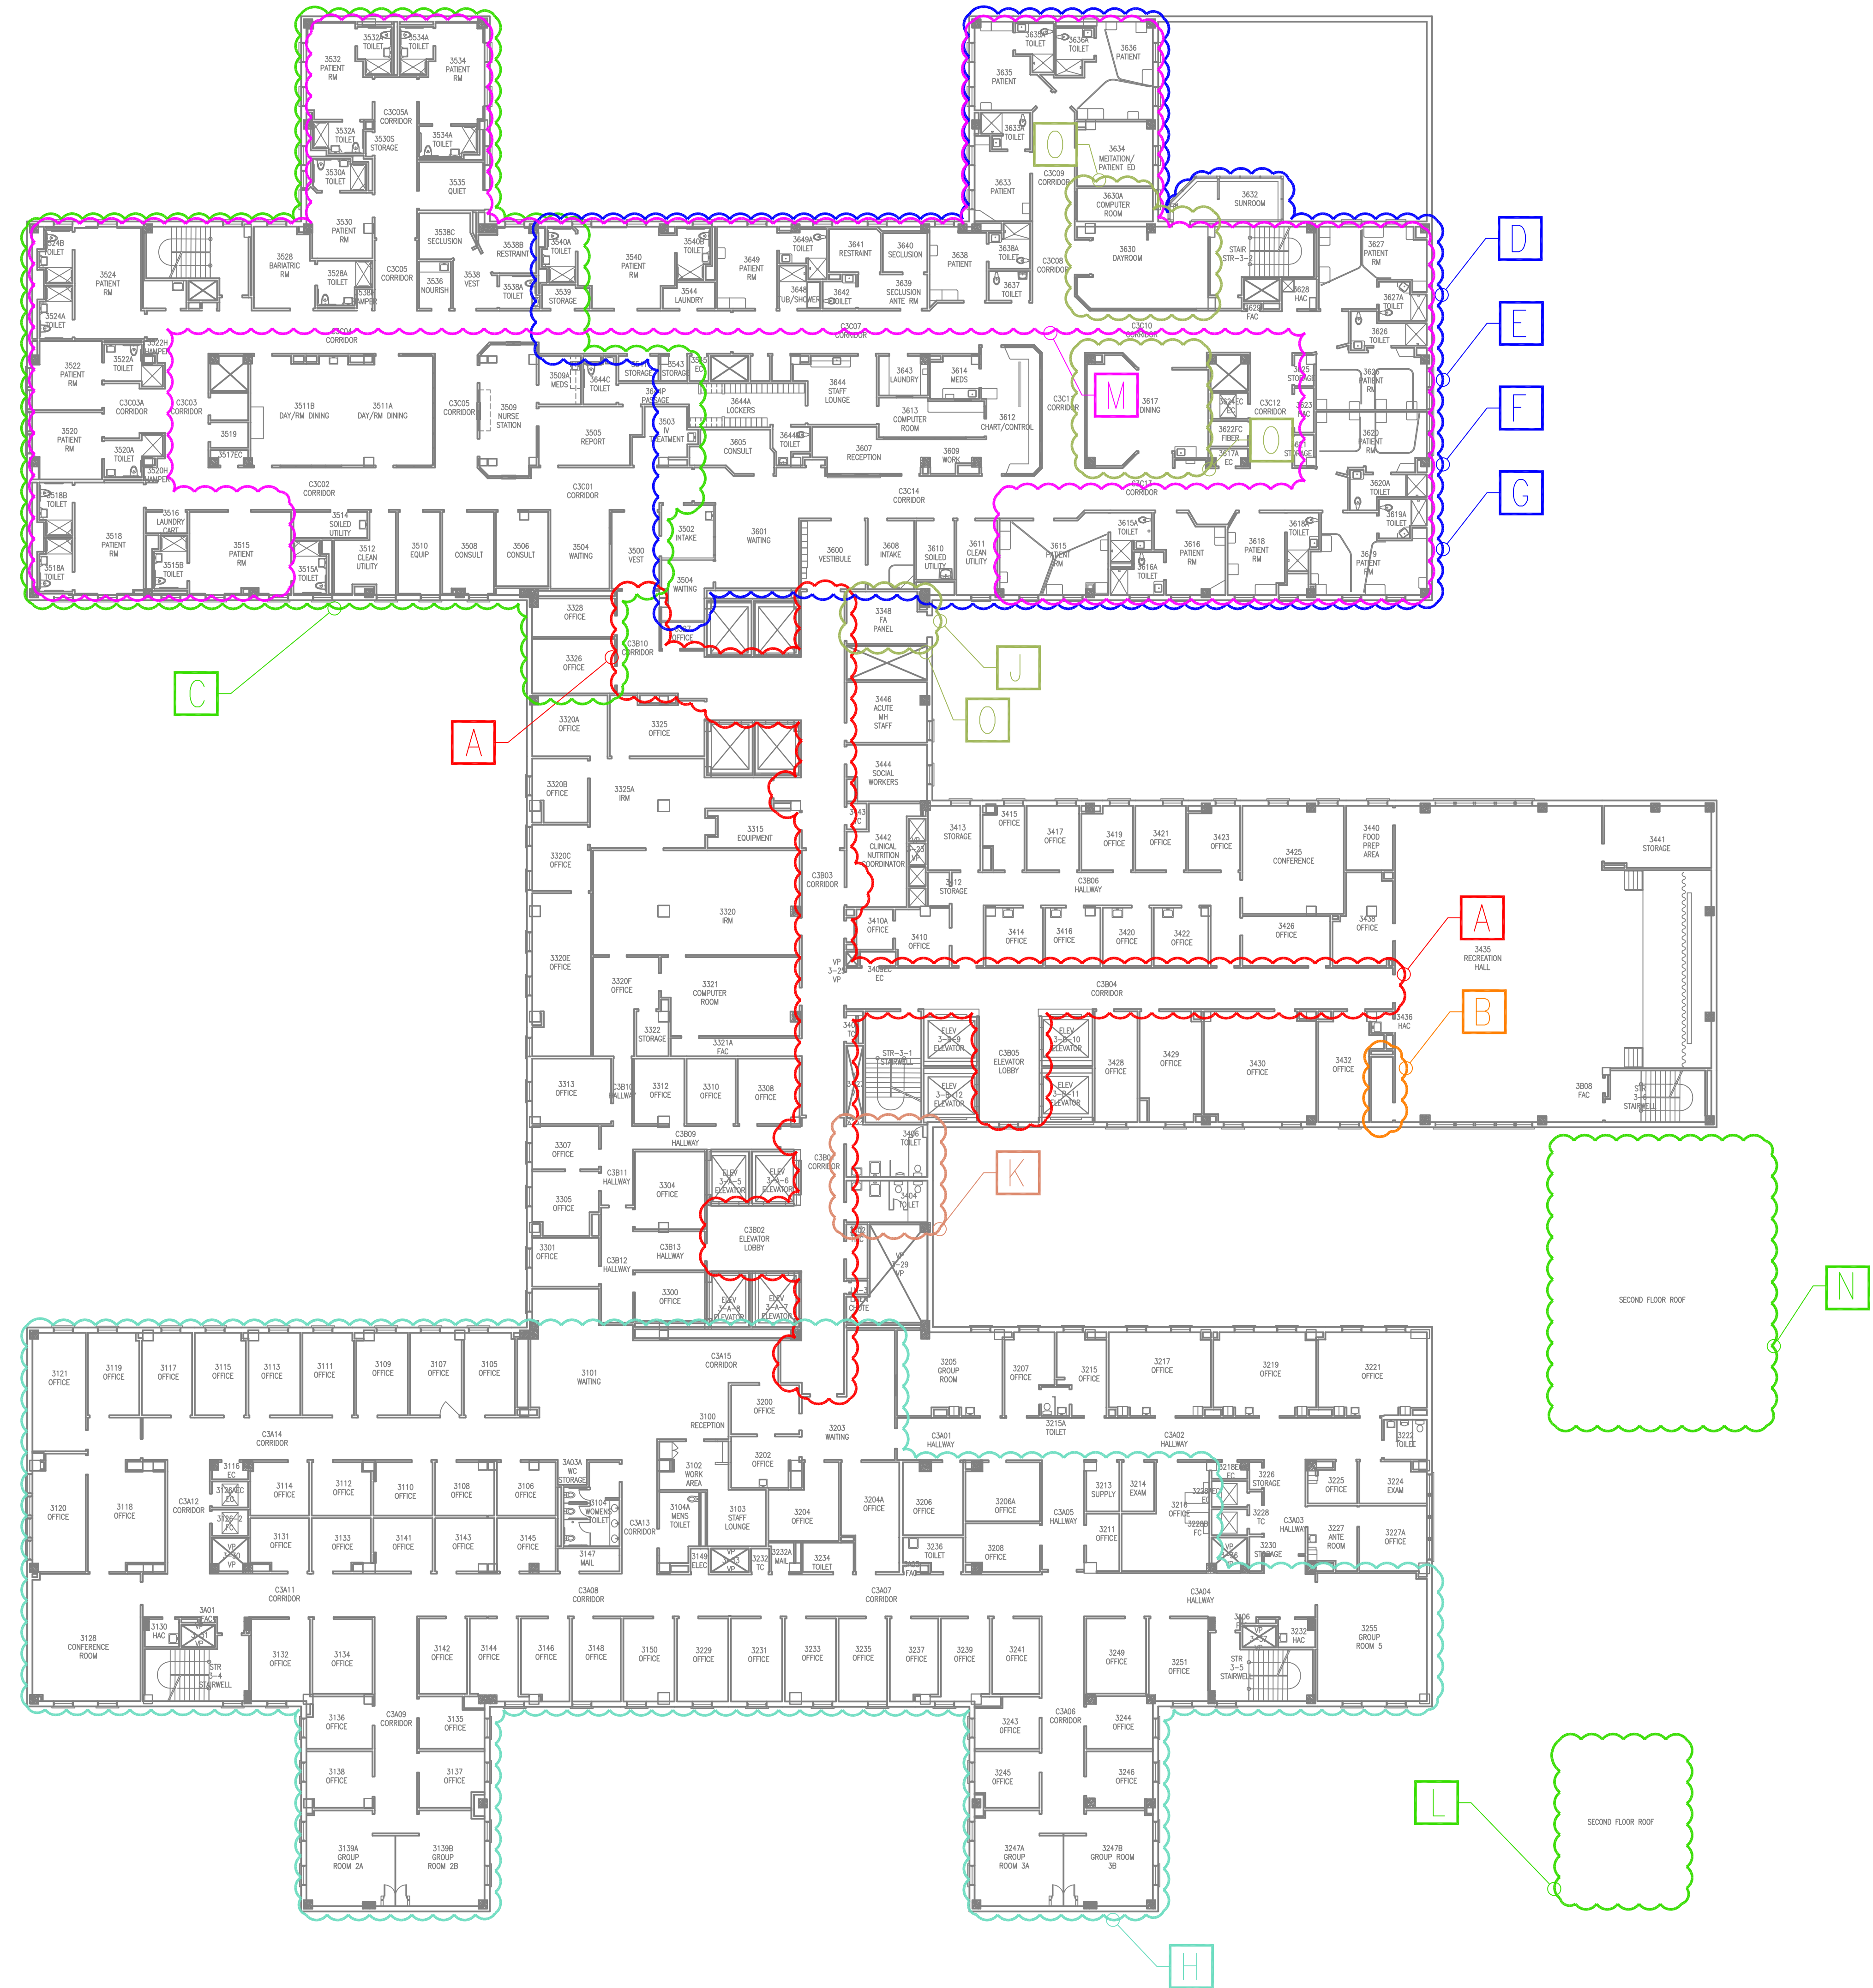

THIRD FLOOR PLAN


N.T.S.


Revisions	Date



Dept. of Veterans Affairs
Medical Center
5000 W. National Avenue
Milwaukee, WI



KEY PLAN: 

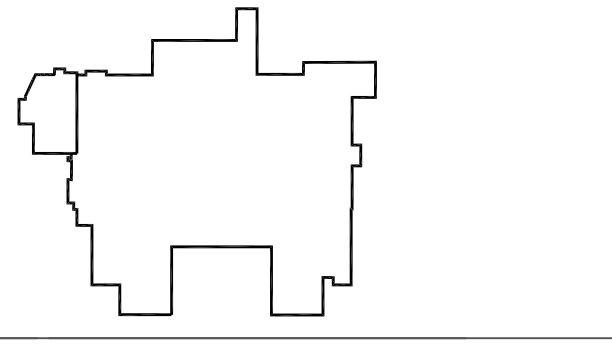

ENGINEER:

ARCHITECT:

THIRD FLOOR PLAN
FLOOR AS-BUILT RECORD

Approved Project Director

Project Title

Location
VA Medical Center, Milwaukee, WI

Date
11/13/2017


Checked
-

Drawn
mwm

Building Number
111

Drawing Number
111-03
4 of 14

Office of
Construction
and Facilities
Management

 Department of
Veterans Affairs