


three inches = one foot  
one and one half inches = one foot  
one inch = one foot  
three quarters inch = one foot  
one half inch = one foot  
three eighths inch = one foot  
one quarter inch = one foot  
one eighth inch = one foot

KEY

- A 111REPLACE FLOORING III-5,6 & 7/12NRM||FLOORING||695-11-202||C20464  
B 111 RENOVATE 5B CARDIOLOGY OFFICES/12NRM/||RENOVATE OFFICES||695-12-165||C20706  
C ACUTE CARE WARDS 6C-5CN/MINORS/09 MINORS||RENOVATE ACUTE CARE||695-223||Z90003 & Z10002  
D DIALYSIS RO EQUIPMENT/07NRM||RO EQUIPMENT||695-07-369||C70799  
E RENOVATE DIALYSIS UNIT/IMAGESITE||WARD REMODEL||695-85-123||XXXXX  
F 111 UPGRADE PUBLIC RESTROOMS/11NRM||FY11 JOC||111 UPGRADE PUBLIC RESTROOMS  
G 111 SITE PREP CATH LAB/14NRM||695-14-112  
H 111 UPGRADE 111 EP LAB 5CS/11NRM||695-11-127  
J INTERNAL LOCKER ROOM REMODEL  
J FY17 SAFETY AND TJC CORRECTIONS/17NRM/695-17-106


ENTIRE FLOOR: REPLACE FIRE ALARM SYSTEM/09NRM||695-09-151||C90855  
111 REKEY BLDG/12NRM/695-12-124

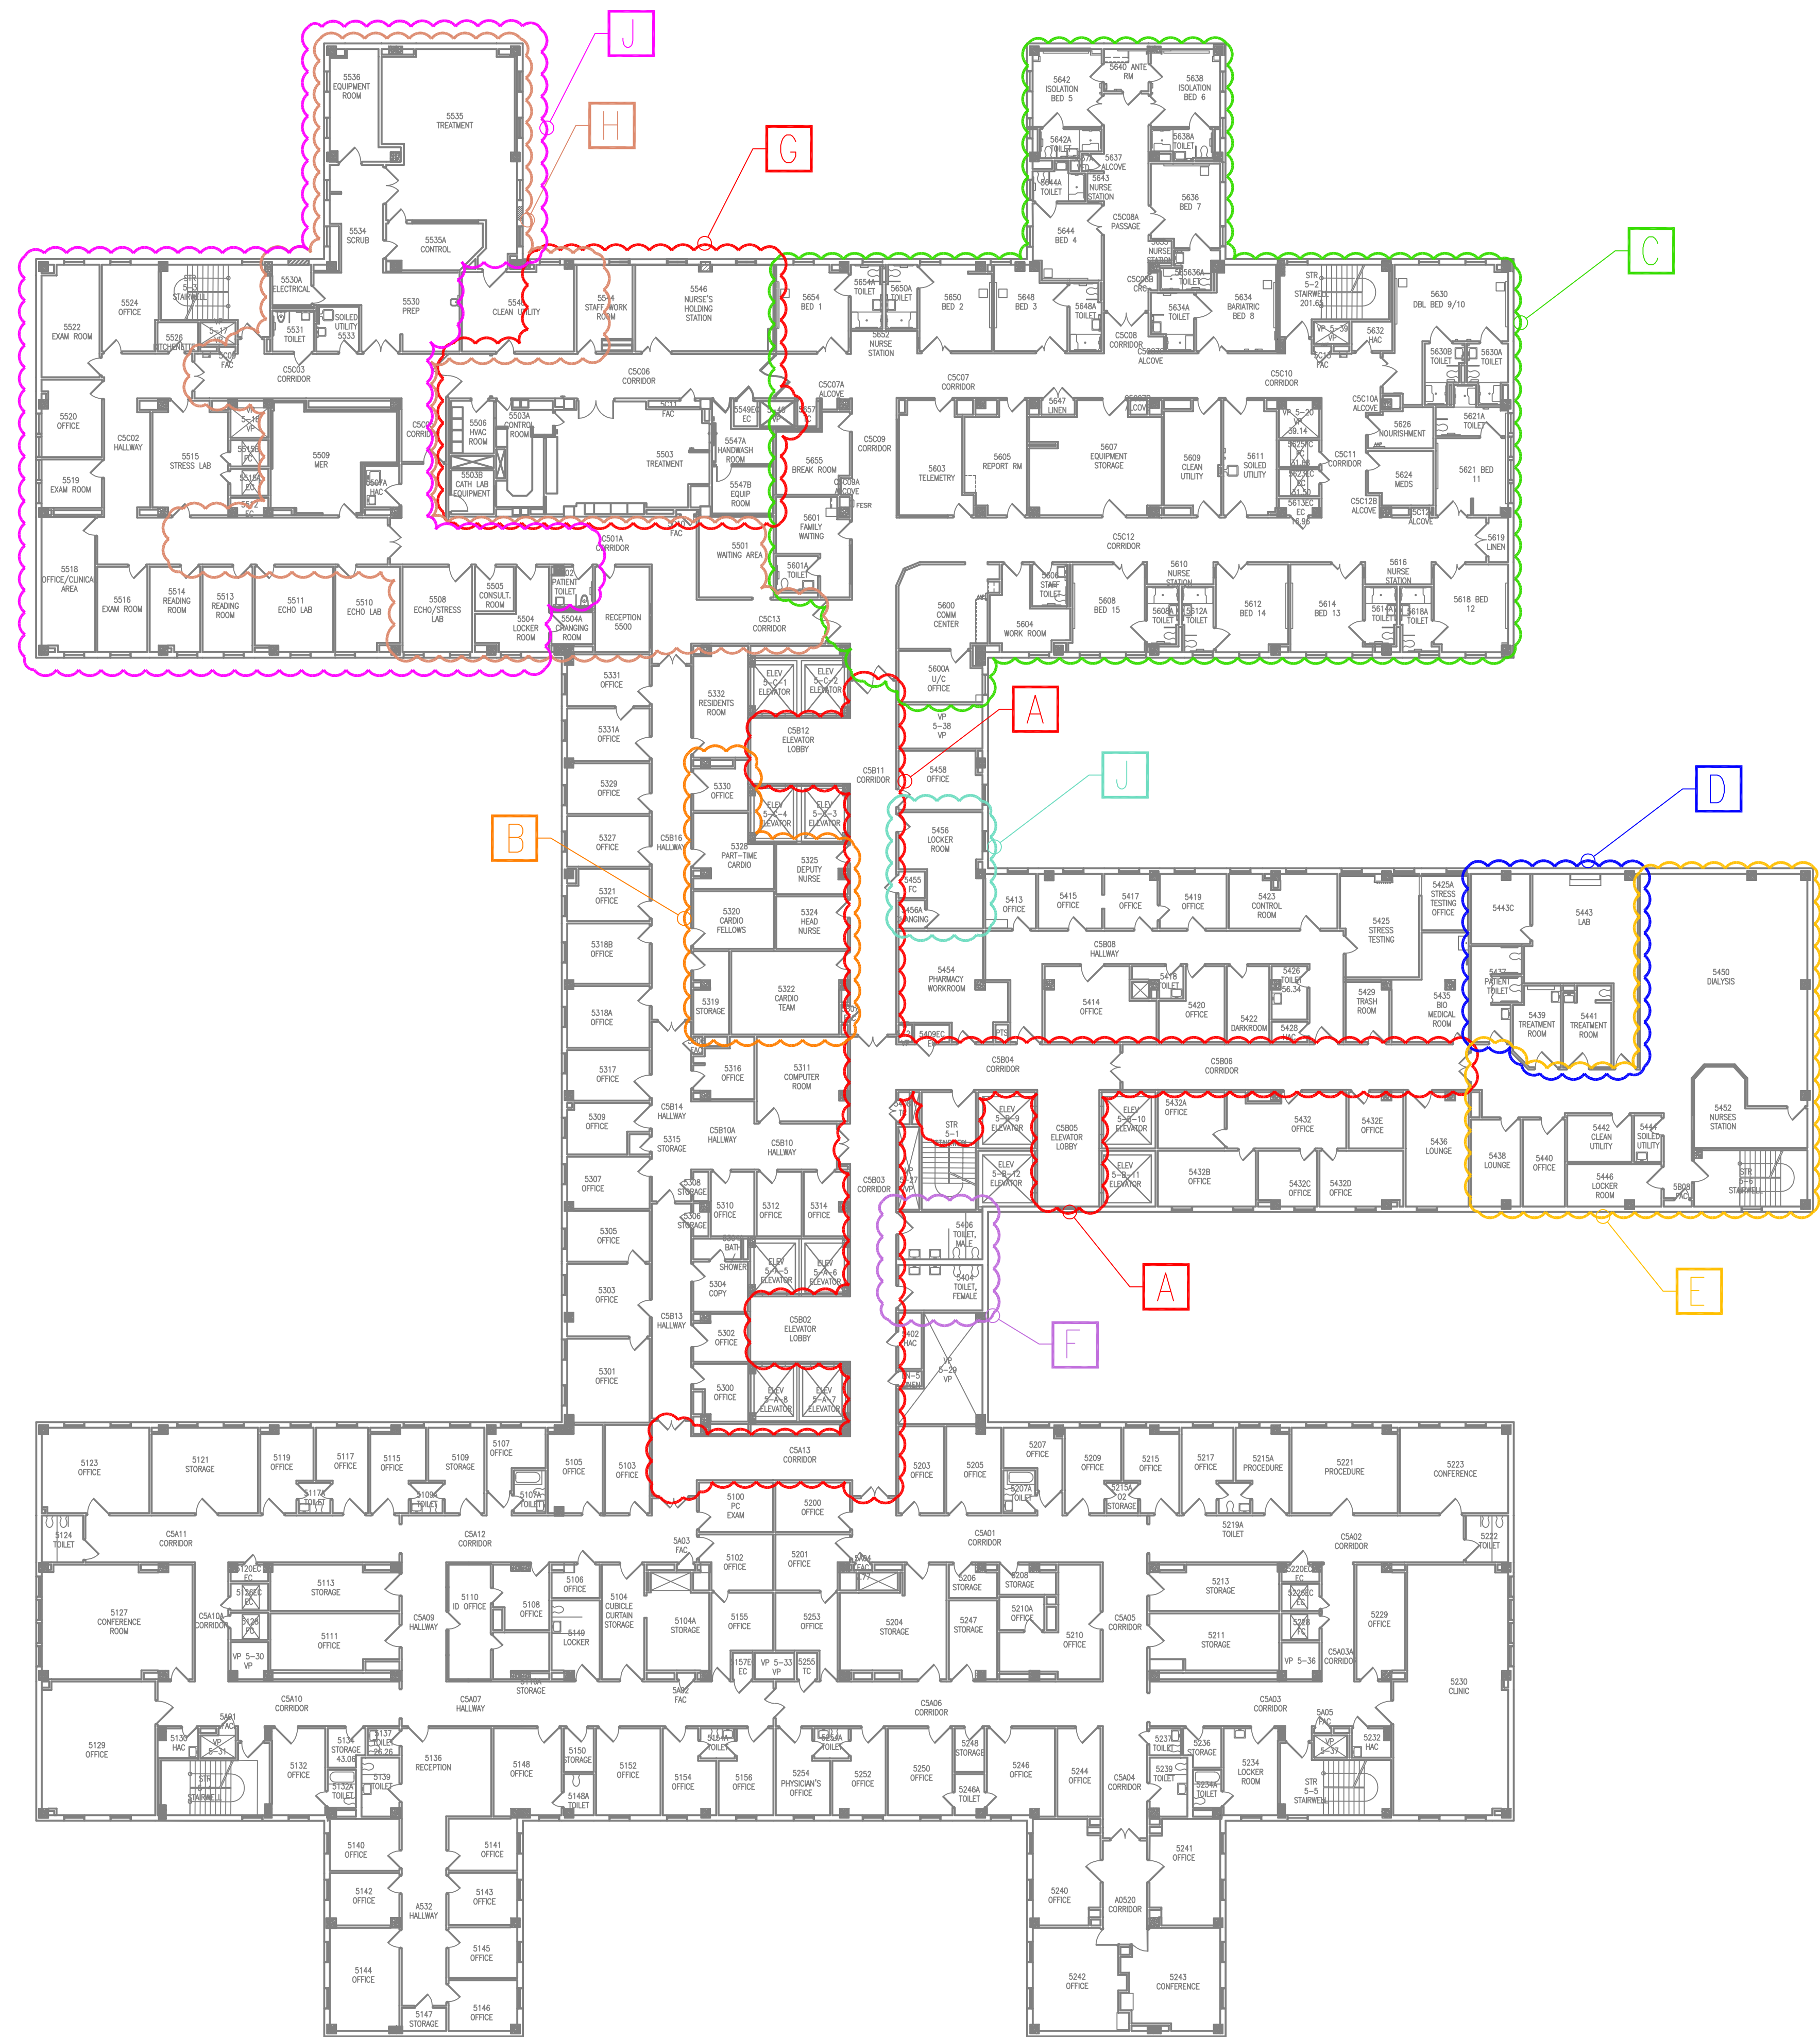

FIFTH FLOOR PLAN


N.T.S.


Revisions	Date

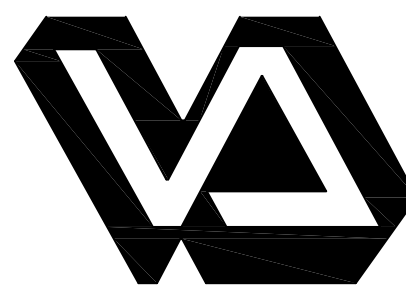

Dept. of Veterans Affairs  
Medical Center  
5000 W. National Avenue  
Milwaukee, WI



KEY PLAN: 

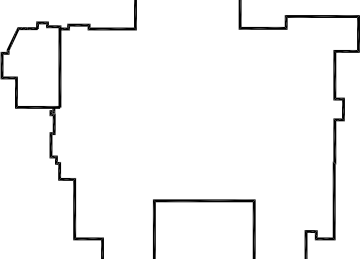

ENGINEER:

ARCHITECT:

Drawing Title  
FIFTH FLOOR PLAN  
FLOOR AS-BUILT RECORD

Approved Project Director

Project Title  
-  
-

Location  
VA Medical Center, Milwaukee, WI

Date  
11/13/2017

Checked  
-

Drawn  
mmm

Project Number  
-

Building Number  
Building 111

Drawing Number  
111-05  
6 of 14

Office of  
Construction  
and Facilities  
Management

 Department of  
Veterans Affairs