


KEY


- A** BOILER REPLACE/08NRM/REPLACE BOILER/695-07-148/C00332
 - B** 111 REPLACE FLOORING ICU 3, 10/12NRM/REPLACE FLOORING/695-12-166/C20709
 - C** AHU V-15 and S-5 REPLACEMENT/07NRM/IDEMO S-5 AHU/695-07-132/C0608, C00876
 - D** 111 RENOVATE 10CN MIS/14NRM/695-14-132
 - E** 111 RENOVATE 10CN/14NRM/695-14-124
 - F** 111 ADMIN CONSOLIDATION FOR 10AS SIM LAB/13NRM/695-13-112
 - G** 111 CORRECT JACHO FIRESTOPPING
 - H** 111 UPGRADE PUBLIC RESTROOMS/11NRM/FY11 JOC/111 UPGRADE PUBLIC RESTROOMS
 - J** 111 REPAIR EXPANSION TANK AND HVAC PIPING/13NRM/695-13-122
 - K** FY16 SAFETY AND TJC CORRECTIONS (UPGRADE 10B CEILING AND LIGHTS)/16NRM/695-16-115
- ENTIRE FLOOR: REPLACE FIRE ALARM SYSTEM/09NRM/695-09-151/C90855
- 111 REKEY BLDG/12NRM/695-12-124

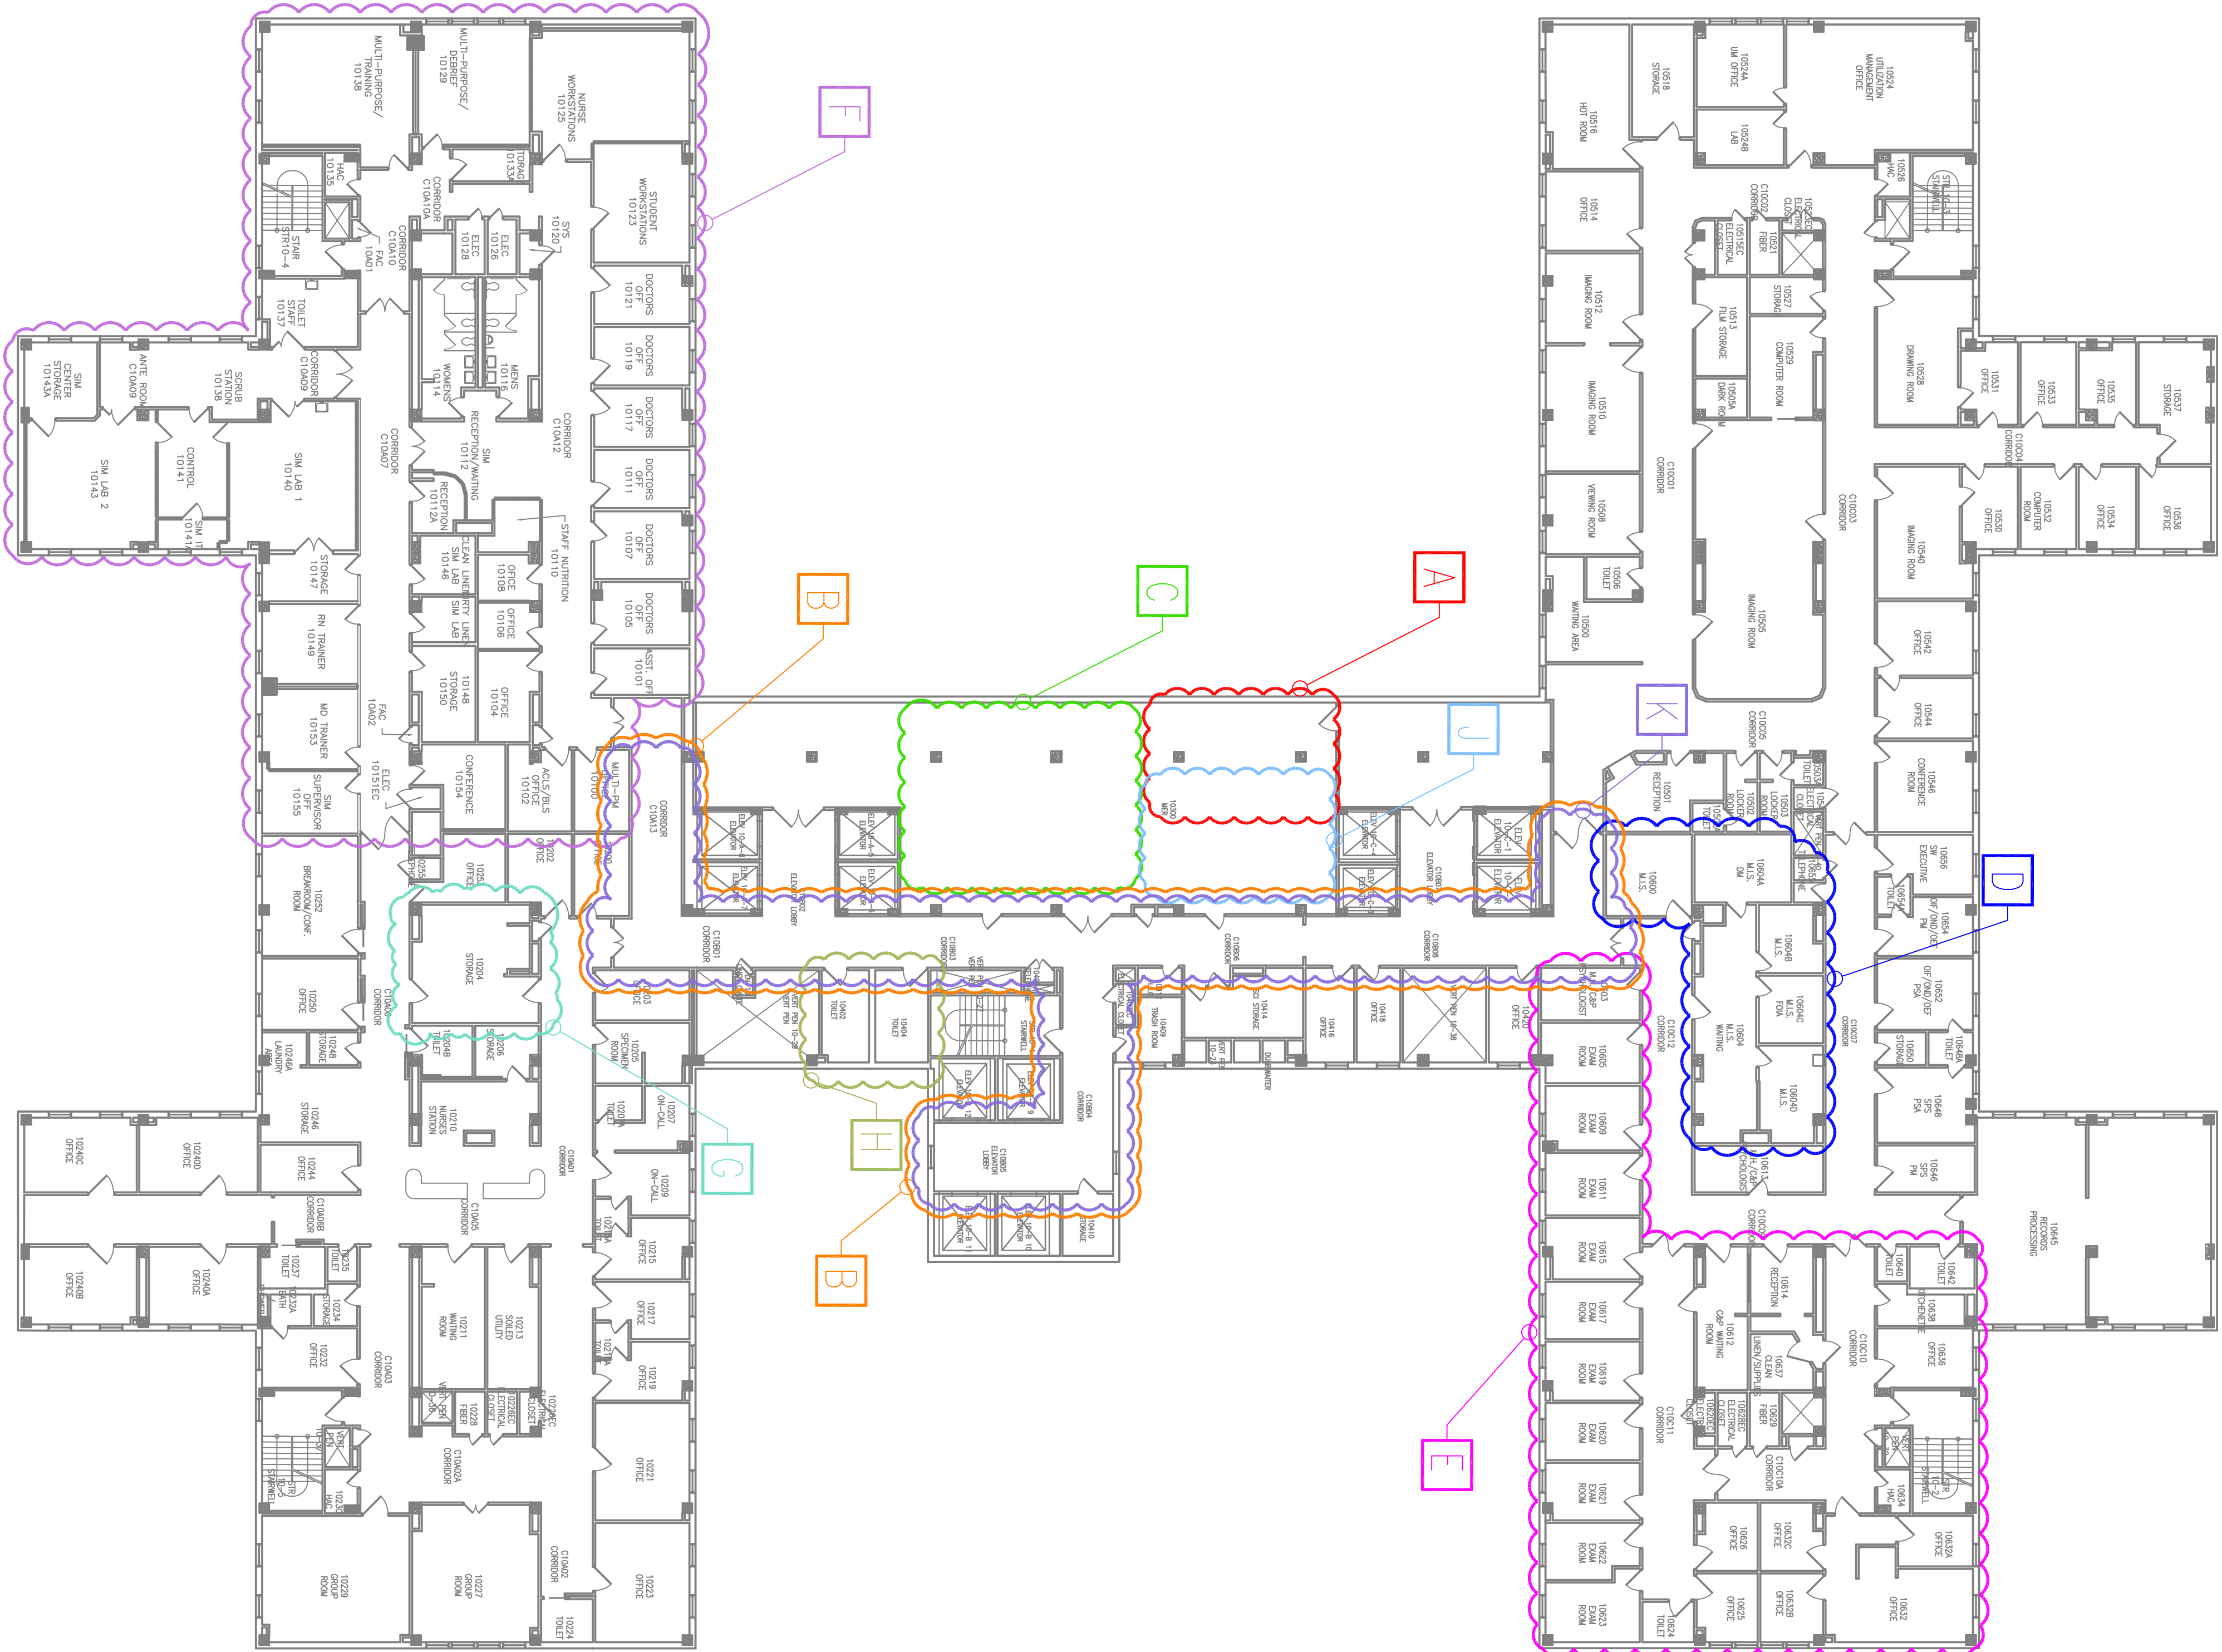

TENTH FLOOR PLAN

N.T.S.

Project Title		Project Title		Project Number		Office of Construction and Facilities Management	
TENTH FLOOR PLAN FLOOR AS-BUILT RECORD		-		Building Number 111-10		-	
Approved Project Director		Location VA Medical Center, Milwaukee, WI		Drawing Number 11-10		-	
Date 11/13/2017		Checked -		Drawn -		-	
VA FORM 08-5231		Date		Date		Date	

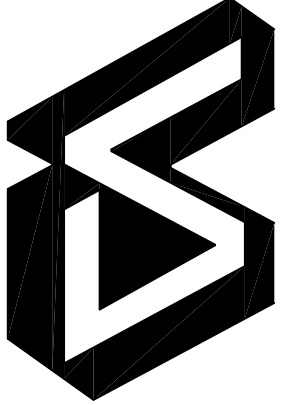

Dept. of Veterans Affairs
Medical Center
5000 W. National Avenue
Milwaukee, WI



KEY PLAN:

ENGINEER:

ARCHITECT: