




three inches = one foot
one and one half inches = one foot
one inch = one foot
three quarters inch = one foot
one half inch = one foot
three eighths inch = one foot
one quarter inch = one foot
one eighth inch = one foot

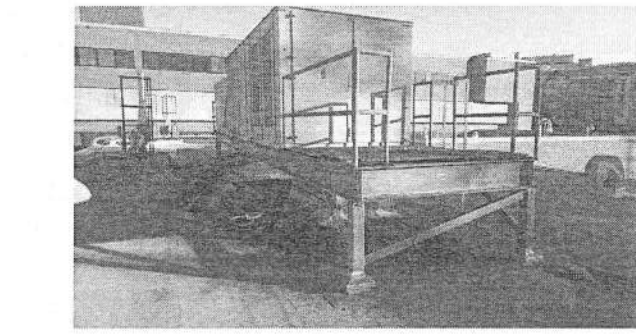


25 HVAC EQUIPMENT ON ROOF
AD109 SCALE: N.T.S.

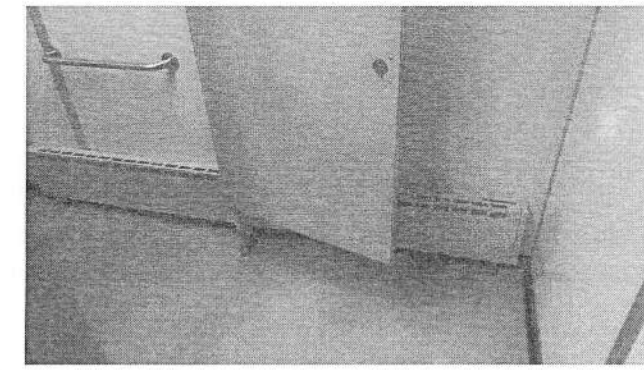


19 HEATER BASEBOARD IN BATHROOM
AD109 SCALE: N.T.S.

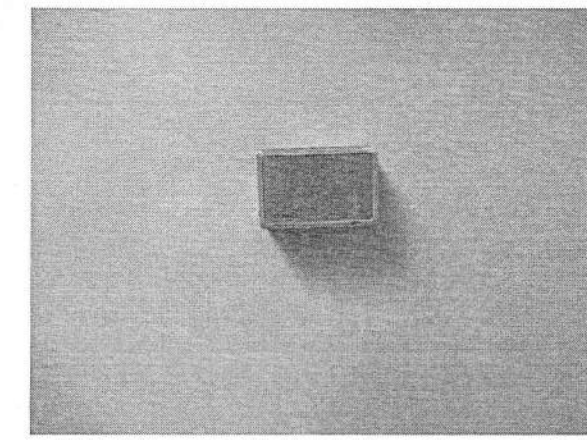


13 THERMOSTAT IN RM 70
AD109 SCALE: N.T.S.

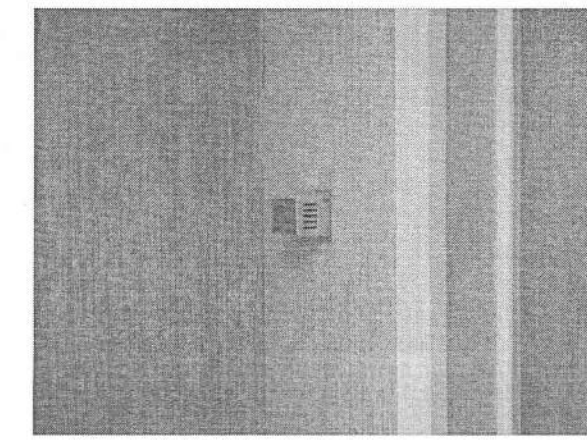

7 THERMOSTAT IN RM 44
AD109 SCALE: N.T.S.

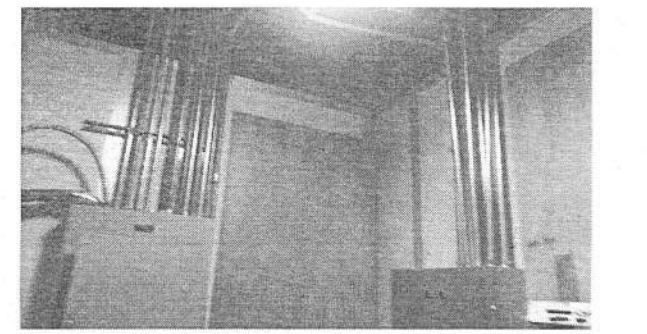


1 ELECTRICAL RM
AD109 SCALE: N.T.S.

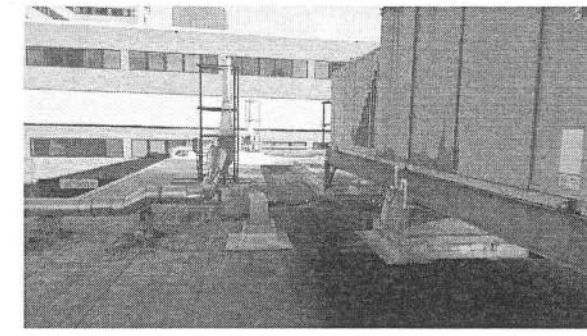

26 HVAC EQUIPMENT ON ROOF
AD109 SCALE: N.T.S.




20 SINKS IN BATHROOM
AD109 SCALE: N.T.S.

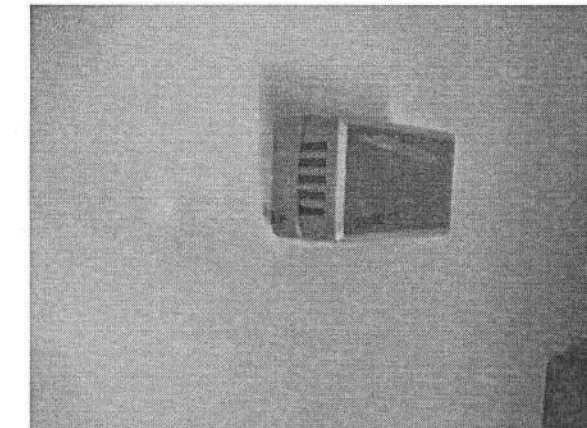


14 THERMOSTAT IN RM 73
AD109 SCALE: N.T.S.




8 TV IN RM 58
AD109 SCALE: N.T.S.

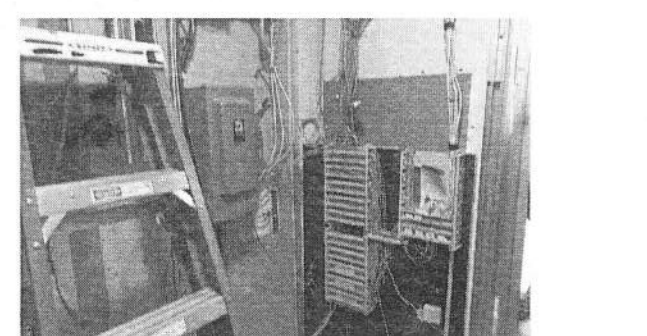

2 ELECTRICAL RM
AD109 SCALE: N.T.S.

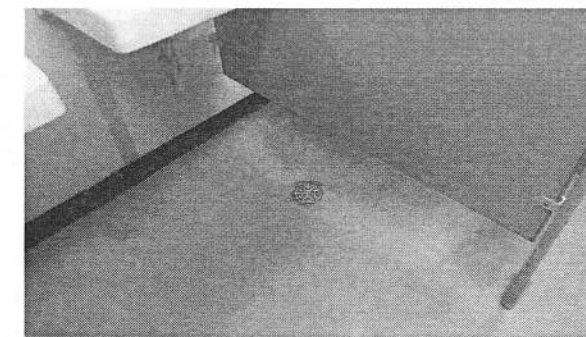


21 DRAIN IN BATHROOM
AD109 SCALE: N.T.S.

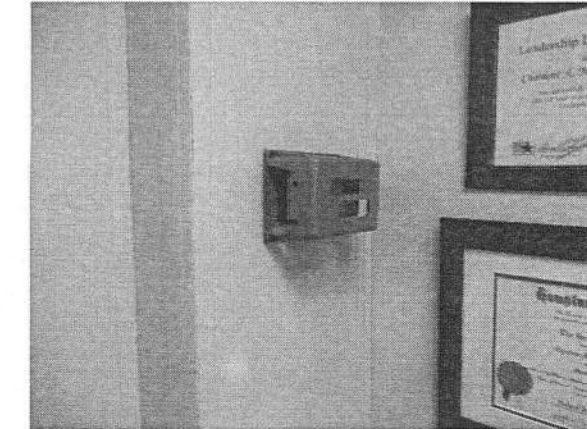


15 THERMOSTAT IN RM 71
AD109 SCALE: N.T.S.




9 TV IN RM 58
AD109 SCALE: N.T.S.

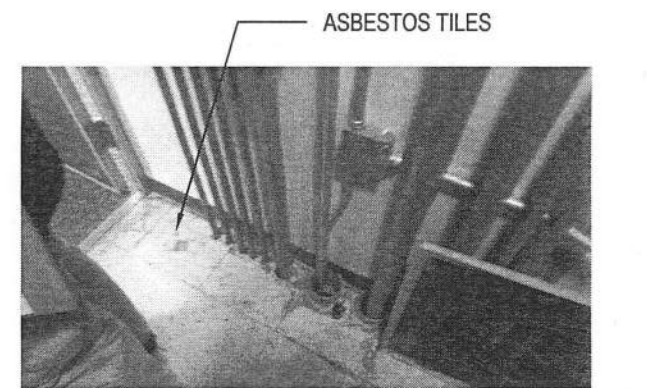

3 ELECTRICAL RM
AD109 SCALE: N.T.S.

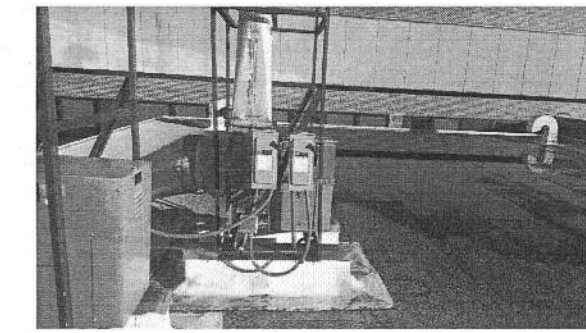


22 ELECTRICAL EQUIPMENT ON ROOF
AD109 SCALE: N.T.S.

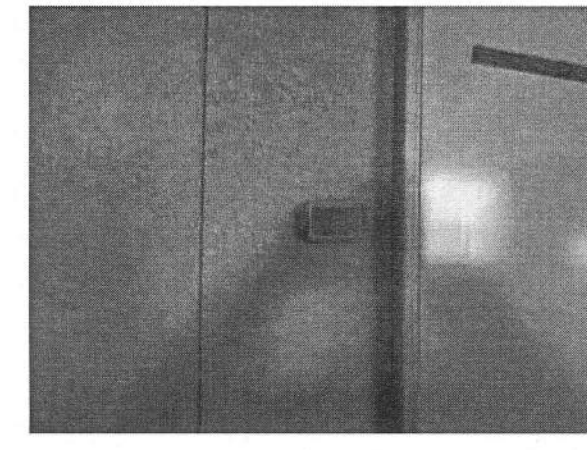


16 THERMOSTAT IN RM 75
AD109 SCALE: N.T.S.




10 THERMOSTAT IN RM 58
AD109 SCALE: N.T.S.

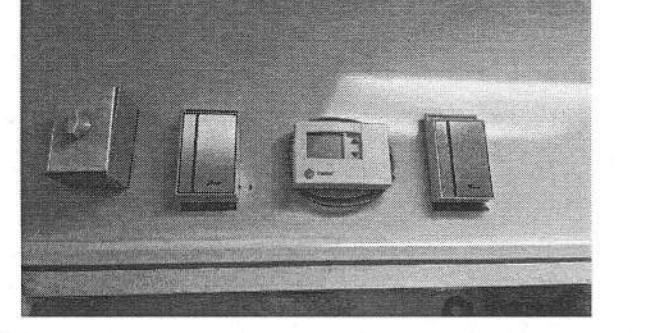

4 THERMOSTATS IN HALLWAY
AD109 SCALE: N.T.S.

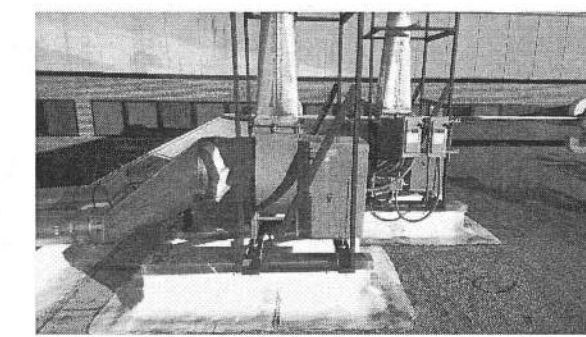


23 ELECTRICAL EQUIPMENT ON ROOF
AD109 SCALE: N.T.S.

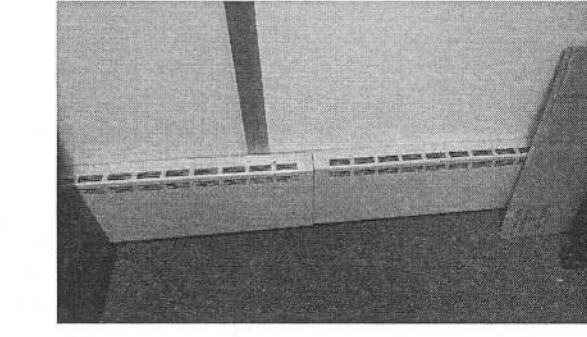


17 HEATER BASEBOARD IN RM 62
AD109 SCALE: N.T.S.




11 TRACK LIGHTS IN RM 58
AD109 SCALE: N.T.S.

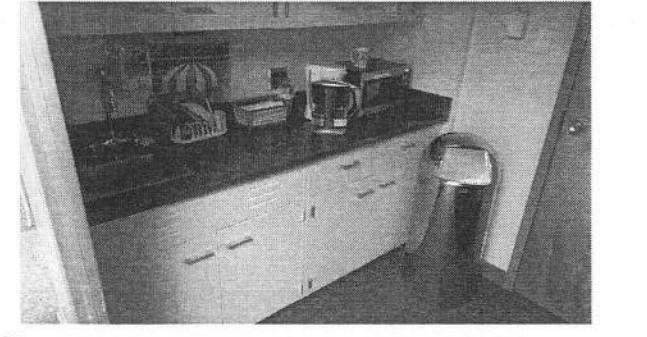


5 CABINETS IN HALLWAY
AD109 SCALE: N.T.S.

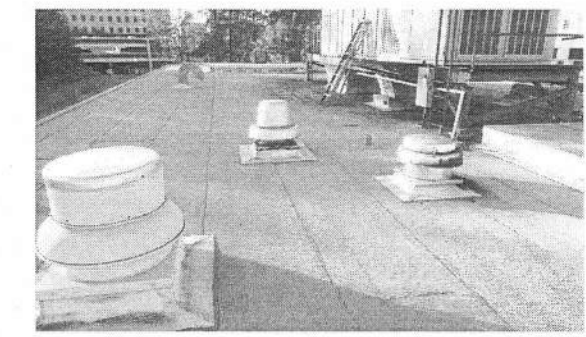


24 EXHUAUST ON ROOF
AD109 SCALE: N.T.S.

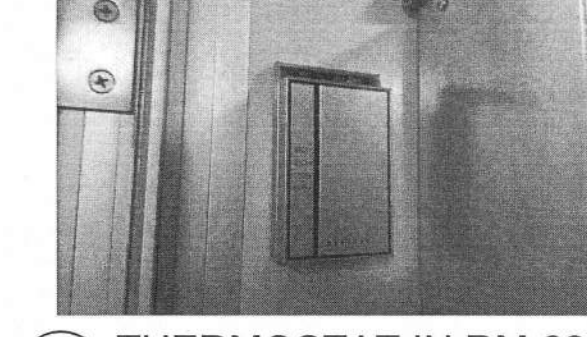

18 THERMOSTAT IN RM 62
AD109 SCALE: N.T.S.

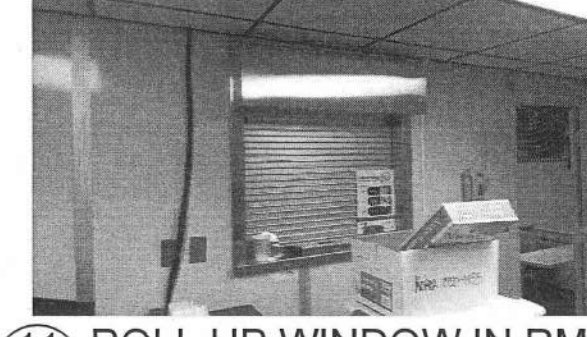

11 ROLL UP WINDOW IN RM 62
AD109 SCALE: N.T.S.

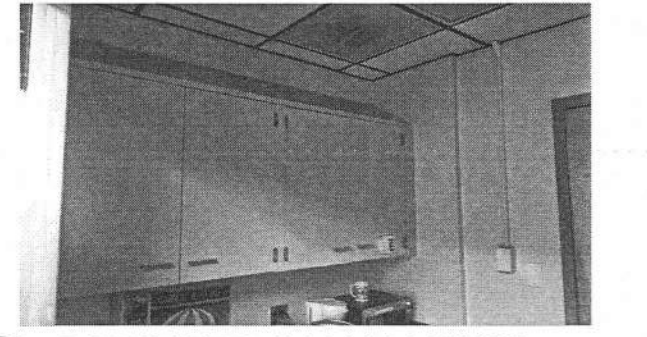

6 CABINETS IN HALLWAY
AD109 SCALE: N.T.S.

CONSULTANTS:



5960 Fairview Road, Suite 500
Charlotte, NC 28210
704-887-3500

Coulter|Jewell|Thames.



111 West Main Street
Durham, NC 27701
919-628-0368



GARDNER &
McDANIEL, P.A.
CONSULTING ENGINEERS
P. O. Box 51967
Durham, NC 27717
919-489-0826



3516 Bush Street, Suite 200
Raleigh, NC 27609
919-871-1070



PROJECT MANAGER:



Raleigh, NC
Indianapolis, IN
Philadelphia, PA
Pittsburgh, PA
Virginia Beach, VA
Fort Collins, CO
(919) 858-7420



Project Number
13-290

Scale

Drawing Title:
EXISTING BUILDING 16 LEVEL 1 -
DEMOLITION FLOOR PLAN PHOTOS

Approved: Project Director

Project Title
VA Durham Specialty Care
Building 42

Location
Durham, North Carolina

Date
04/28/2015

Checked
KMN

Drawn
ERA/MEG

Project Number
558-321

Building Number
42

Drawing Number
AD106

Dwg. 6 of 60

Office of
Construction
and Facilities
Management



FULLY SPRINKLERED
FINAL DOCUMENTS FOR CONSTRUCTION