


one eighth inch = one foot

C:\Users\jason\Documents\Projects\2012\Aurora\Aurora.dwg

8/20/2012 1:46:27 PM

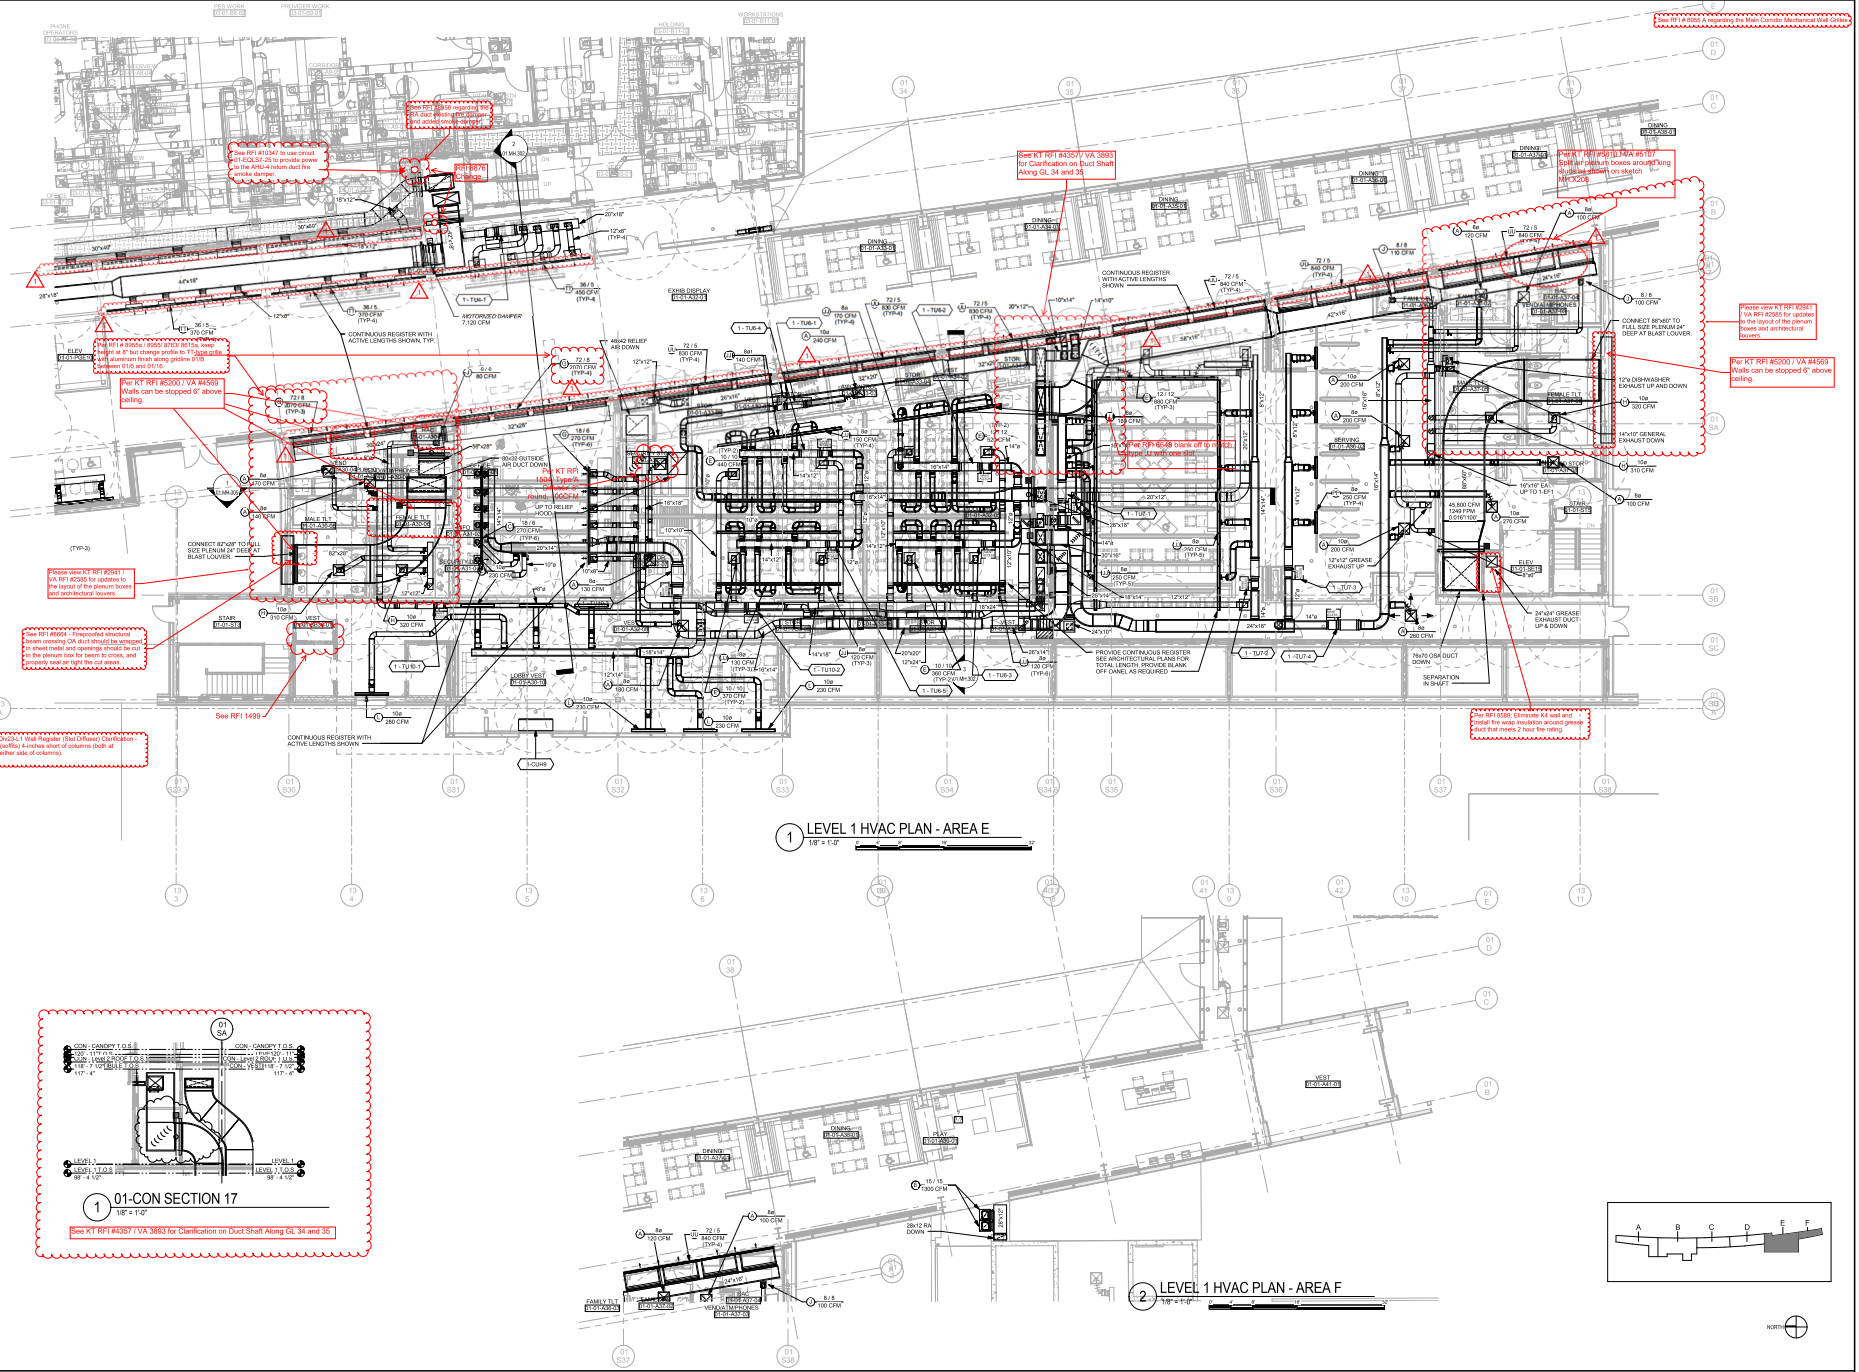

		CONSULTANTS:		Professional Seal		ARCHITECT/ENGINEERS:		Key Plan		Drawing Title		Project Title		Project Number		OFFICE OF CONSTRUCTION AND FACILITIES MANAGEMENT	
						H+L SOM CRA SAM ARCHITECTS ENGINEERS				CONCOURSE LEVEL 1 HVAC PLAN - AREA E/F		REPLACEMENT MEDICAL CENTER FACILITY, EASTERN COLORADO HEALTH CARE SYSTEM		554-501		Department of Veterans Affairs	
						H+L Architecture 1000 Broadway Suite 400 Denver, CO 80202		Baldwin, DeLong & Merrill LLP 204 South Morgan Avenue Suite 1000 Chicago, IL 60604		Cofor, Ruma & Associates 400 West Street Lakewood, CO 80401		S. A. Wicks, Inc. 400 West Street Suite 300 Denver, CO 80202		Building Number			
CDI No. 12		08/31/2012								Approved: Project Director		Location: AURORA, COLORADO		Drawing Number			
Revisions		Date										Date 08/31/2012		Checked		Drawn	
														01.MH.101-D			