



one eighth inch = one foot

D:\Revit Local Projects\2012\PL-FC-01\Sheet_Digital.rvt

11/14/2012 4:46:53 PM

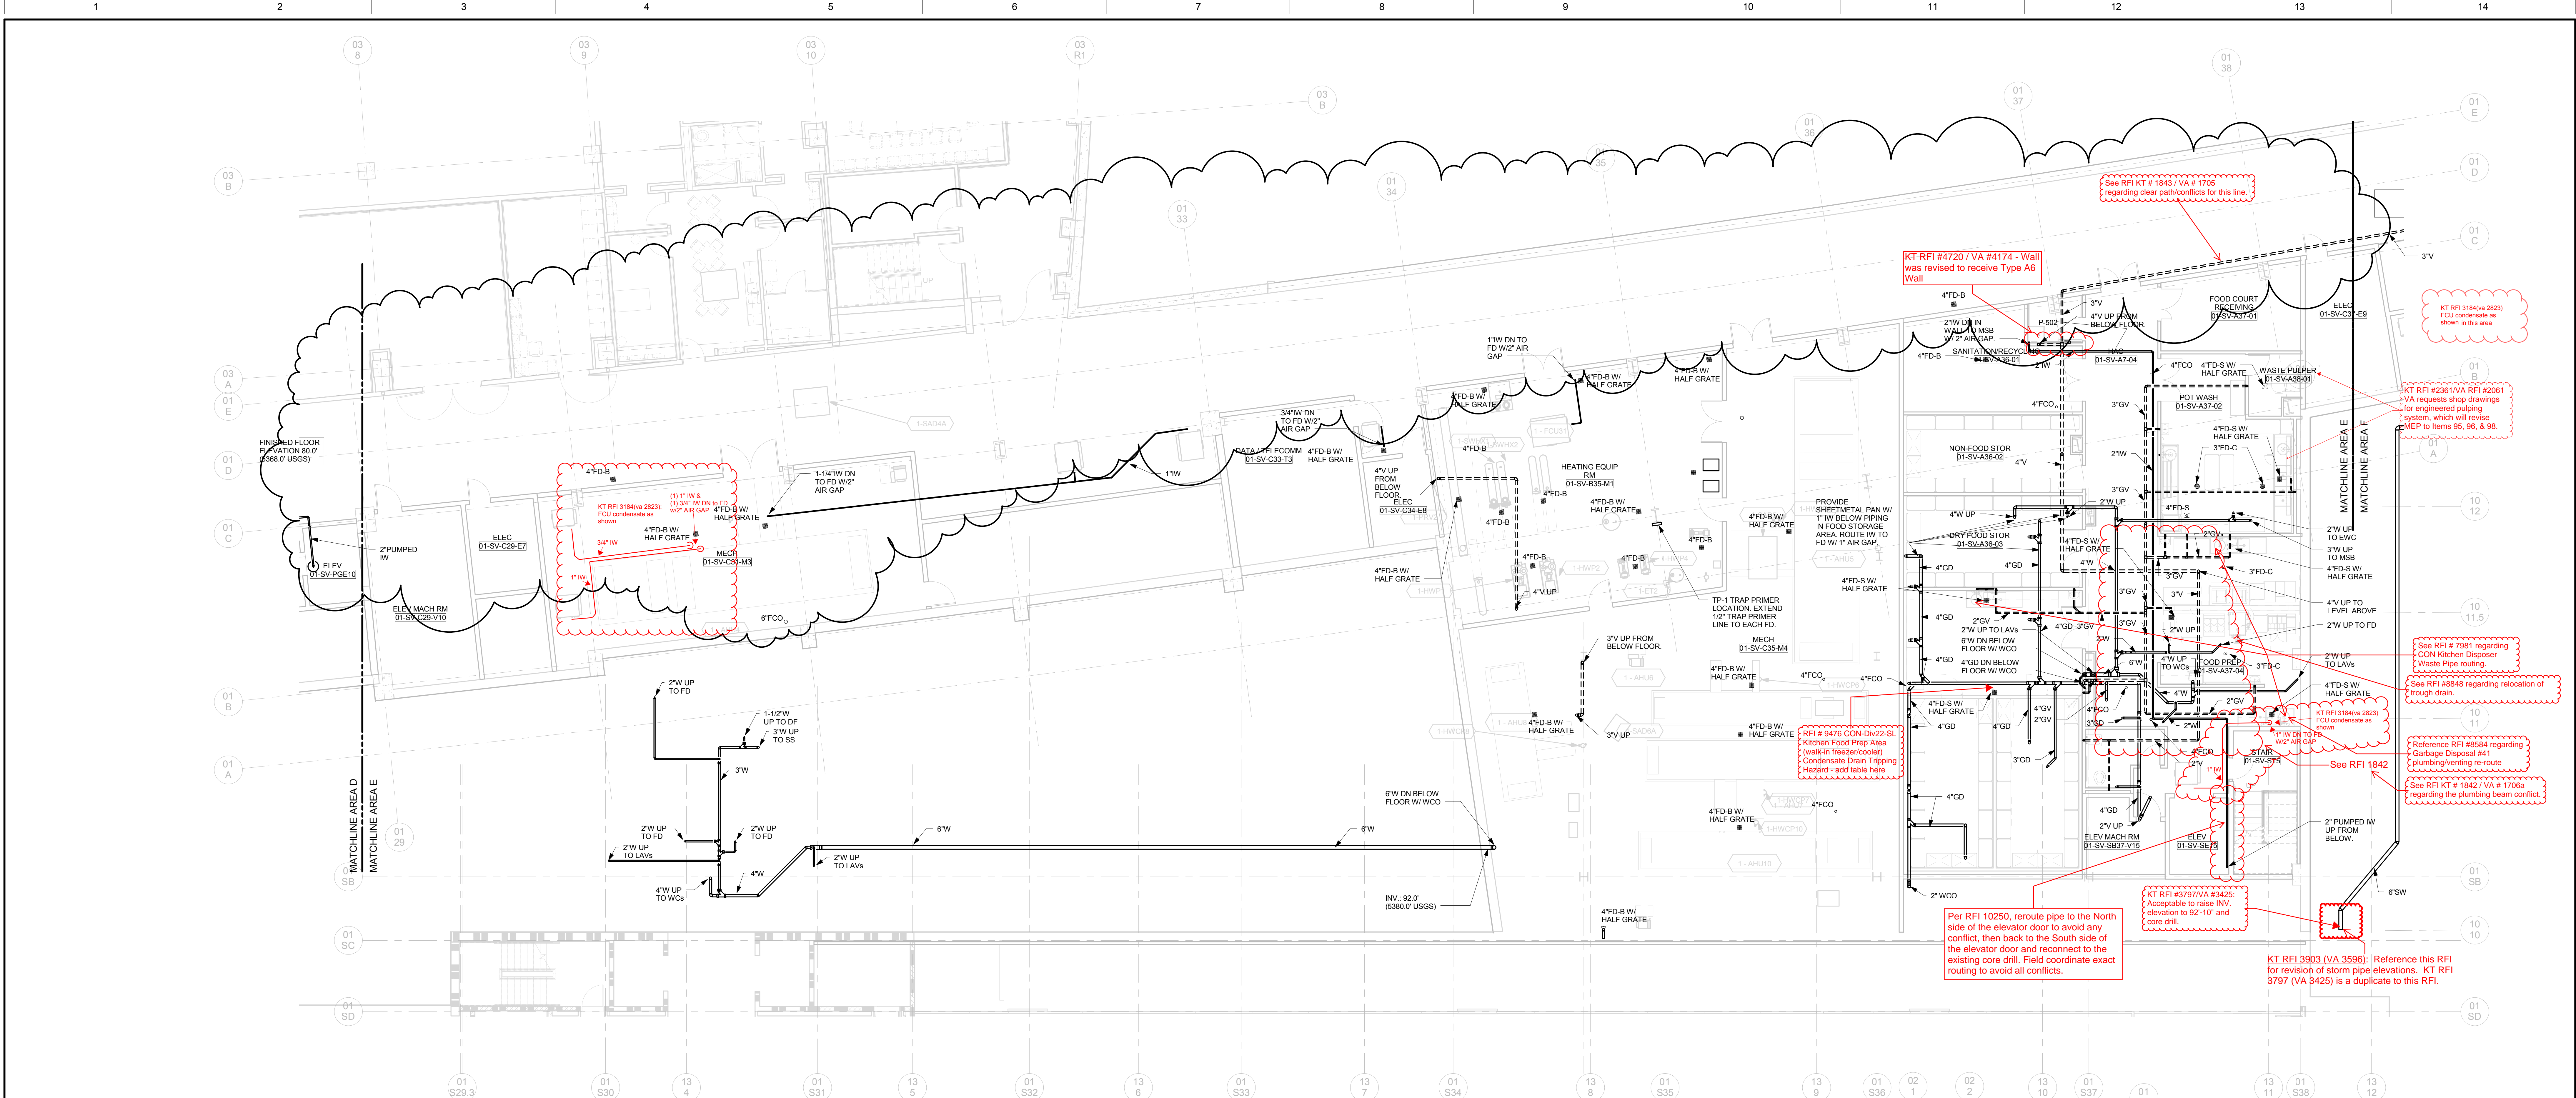

1 SERVICE LEVEL WASTE, DRAIN AND VENT PIPING PLAN - AREA E
1/8" = 1'-0"

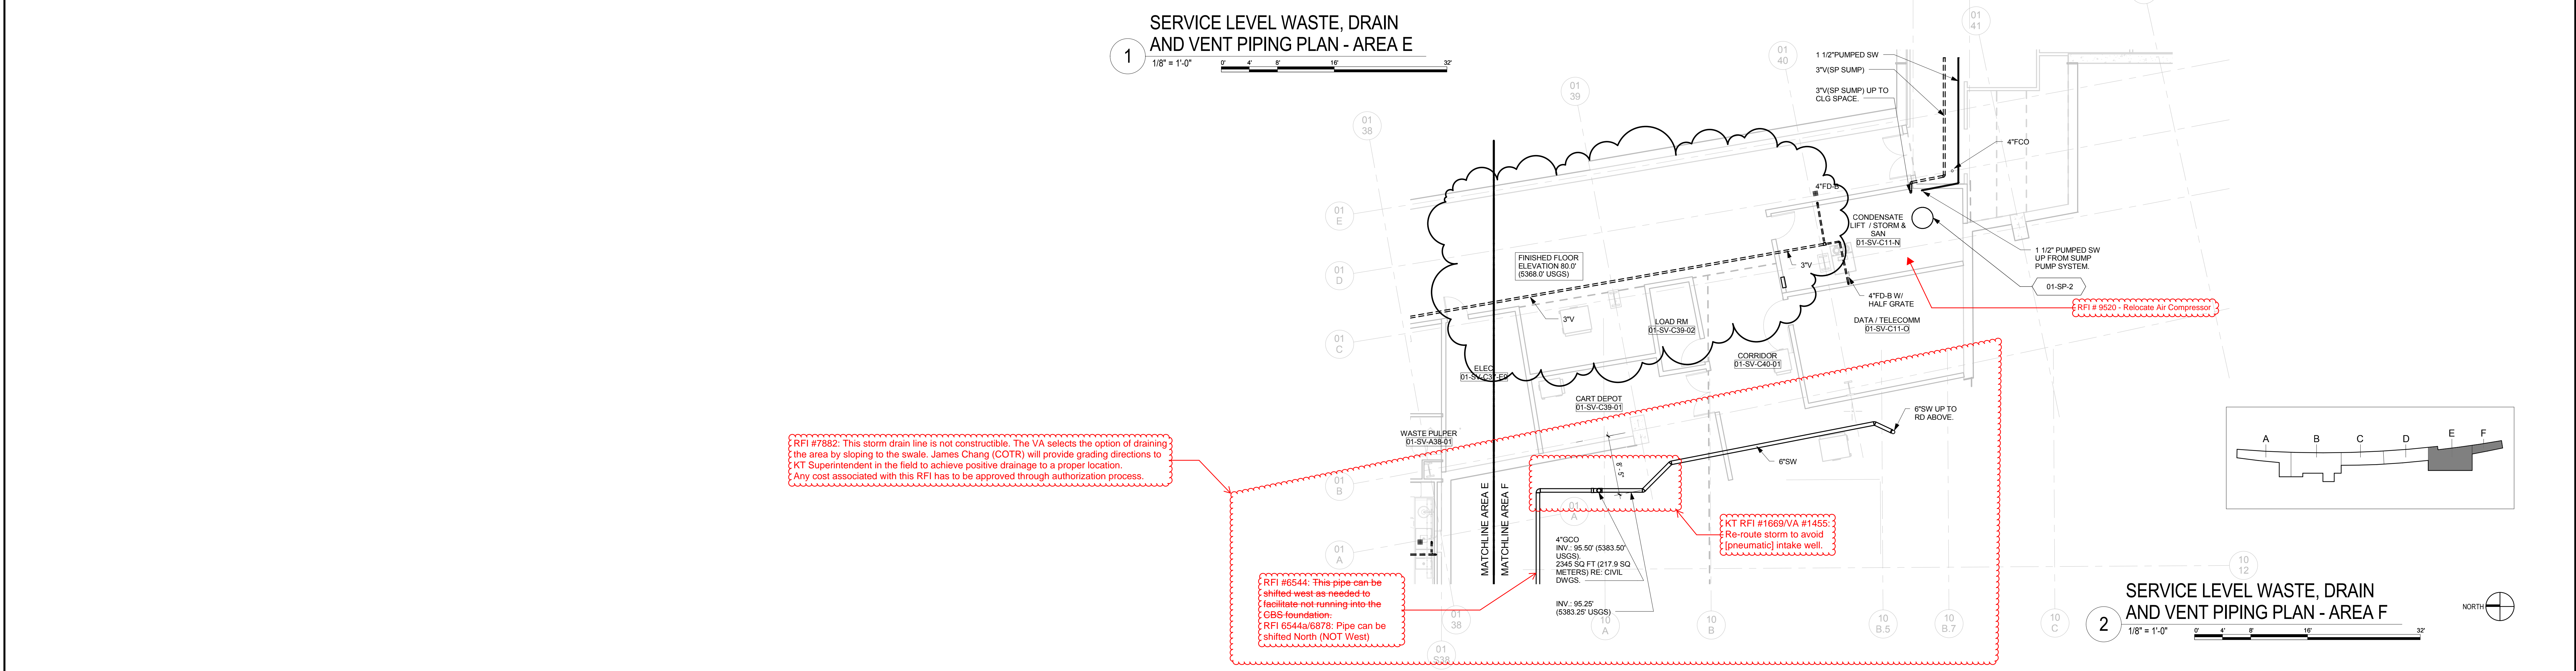

2 SERVICE LEVEL WASTE, DRAIN AND VENT PIPING PLAN - AREA F
1/8" = 1'-0"

CONSULTANTS:		Professional Seal	ARCHITECT/ENGINEERS:		Key Plan	Drawing Title	Project Title	Project Number	OFFICE OF CONSTRUCTION AND FACILITIES MANAGEMENT Department of Veterans Affairs
						CONCOURSE SERVICE LEVEL WASTE, DRAIN AND VENT PIPING PLAN - AREA E/F	REPLACEMENT MEDICAL CENTER FACILITY, EASTERN COLORADO HEALTH CARE SYSTEM	554-501	
USI No. 041 CDI No. 12 Revisions		11/16/2012 08/31/2012 Date	H+L SOM ARCHITECTS CRA SAM ENGINEERS H+L Architecture 1755 Blake Street, Suite 400 Denver, CO 80202 Sklomro, Orm & Merrill LLP 224 South Michigan Avenue Suite 1000 Chicago, IL 60604 Cato, Rums & Associates 696 Tabor Street Lakewood, CO 80401 S. A. Miro, Inc. 4582 South Ulster Street Pkwy. Suite 300 Denver, CO 80237		07 11 12 08 09 13	Approved: Project Director	Location AURORA, COLORADO	Drawing Number 01.PL.100-D	