






383-010 V.A.H. INDIANAPOLIS, BLDG. 1, THIRD FLOOR PLAN, UNIT A (BASIC PLAN, BLUE) 1-9, 11, 14, 15, 18, 19, 21, 22, 23, 999, 1000

NOTE:  
1. PITCH CONDENSATE DRAINS TOWARDS INDICATED DIRECTION OF FLOW @ 1/8" PER FOOT.  
2. USE EXISTING DUCTS.

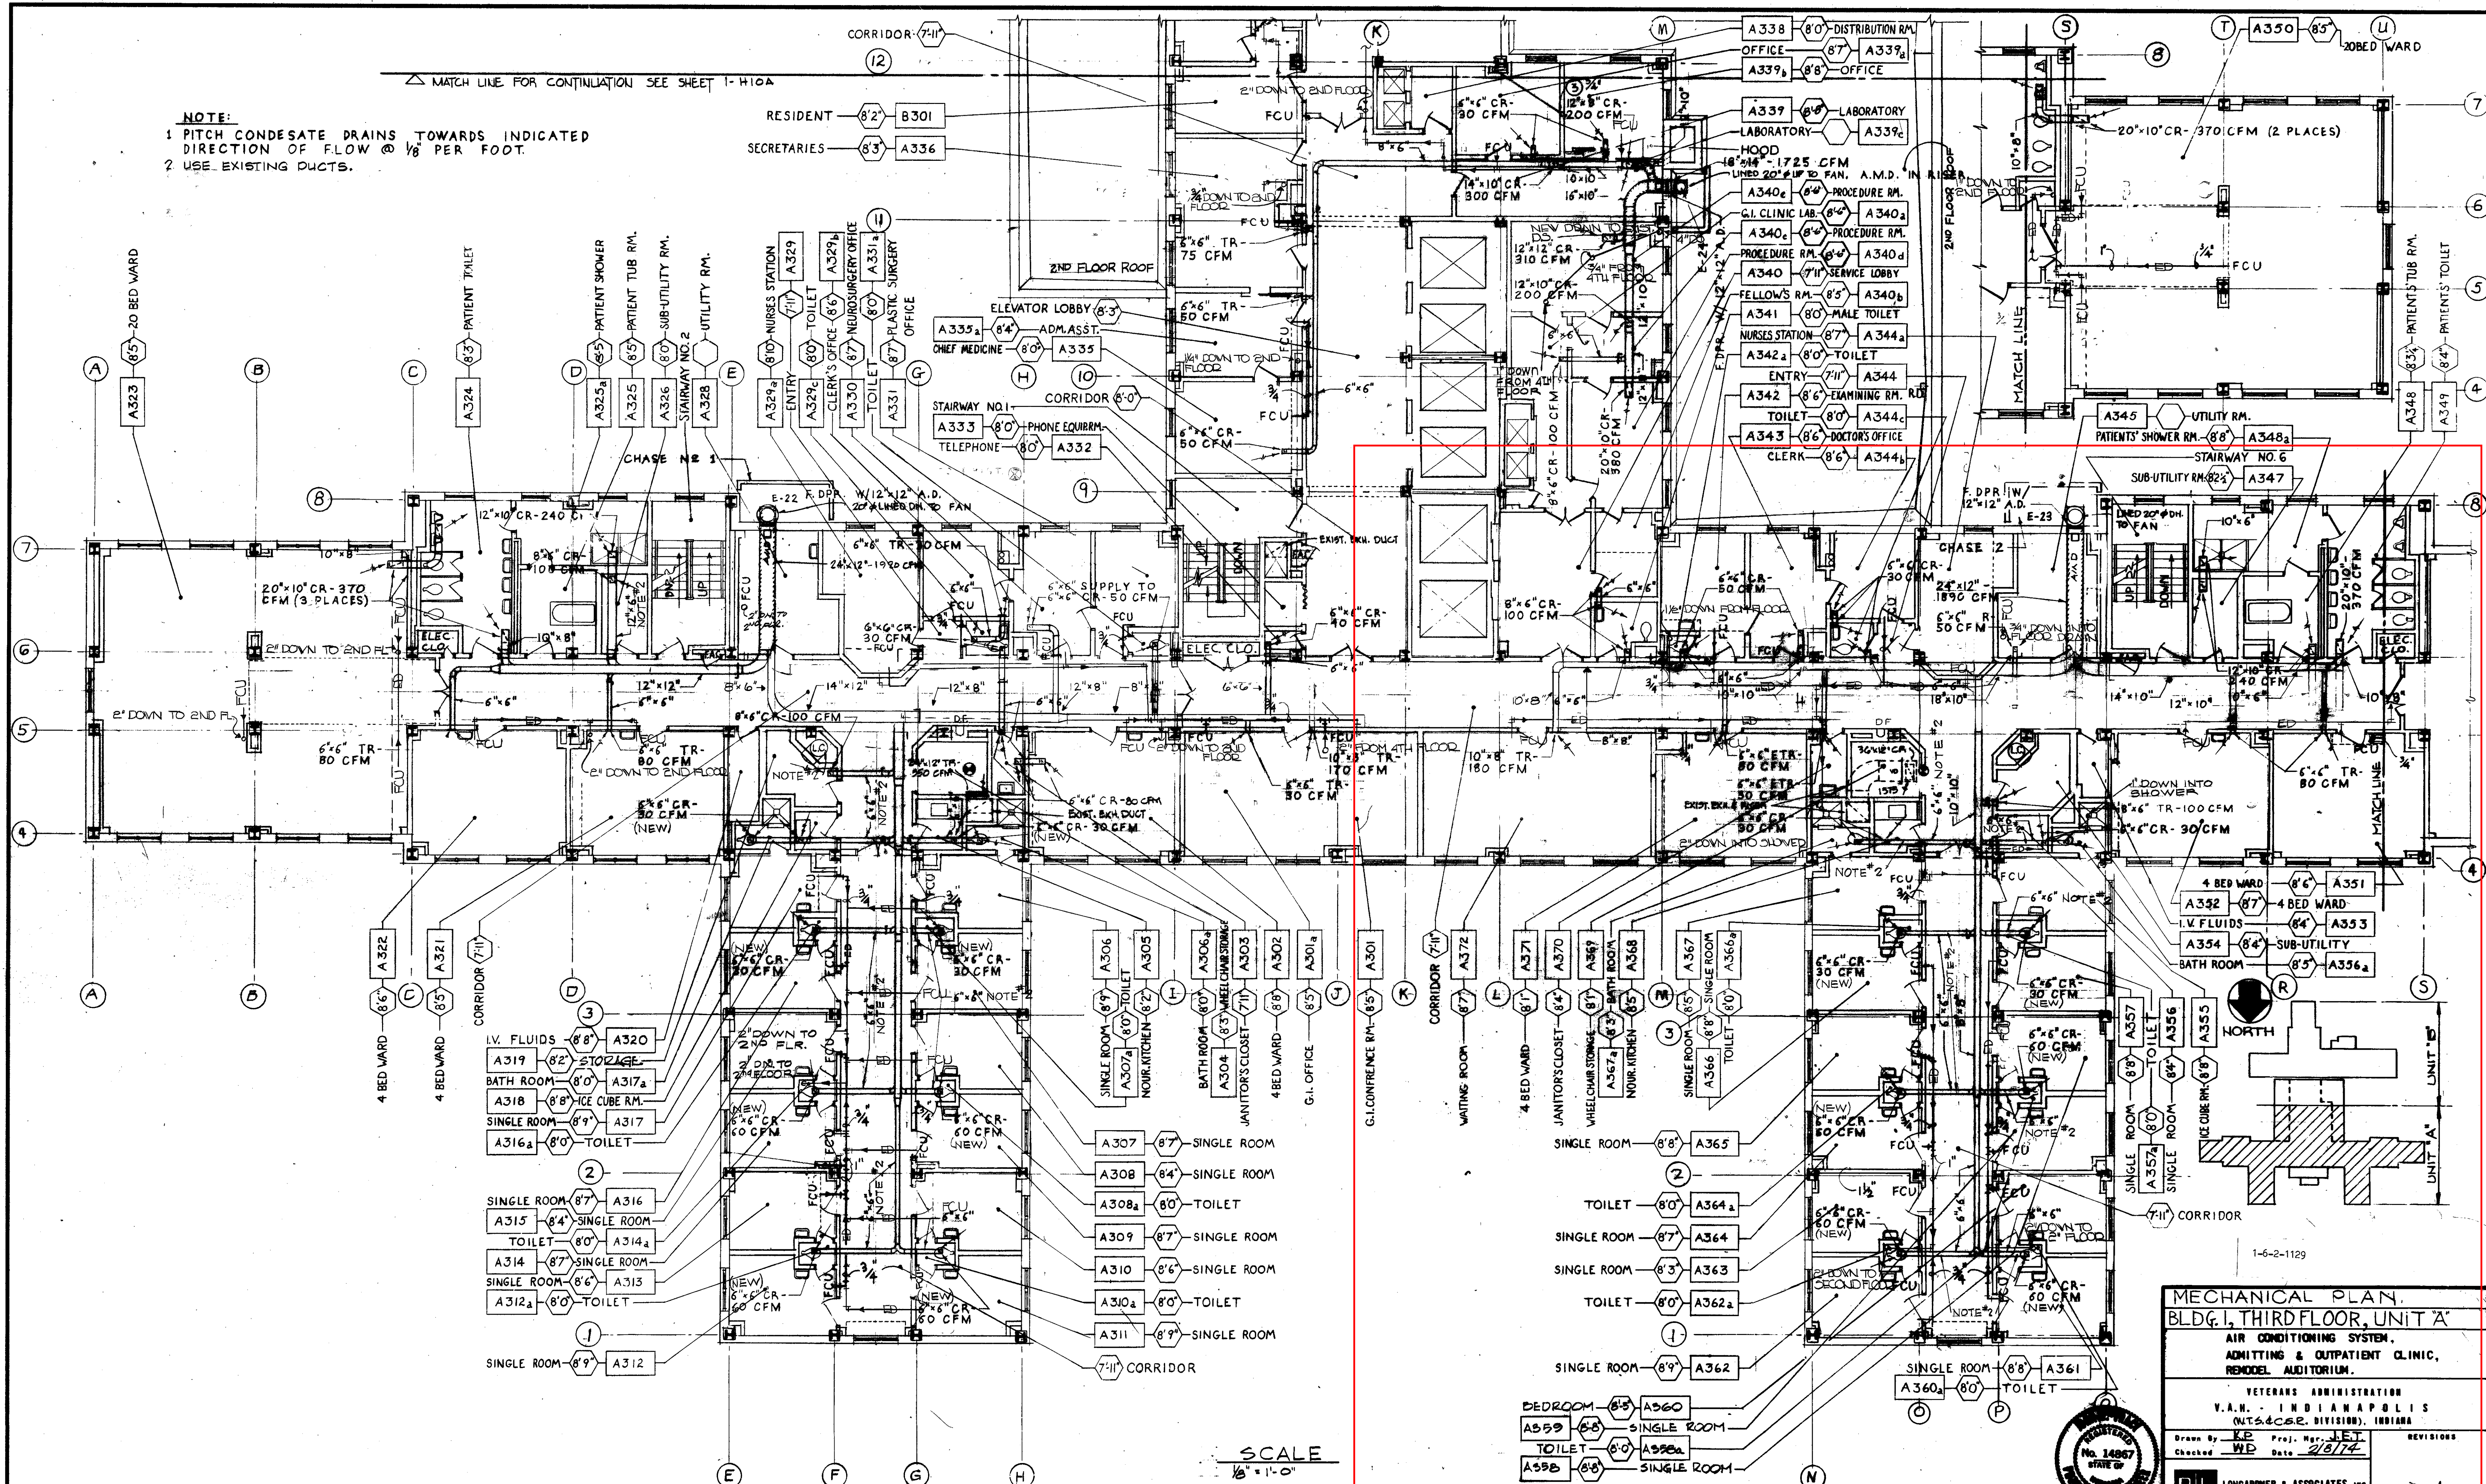

MECHANICAL PLAN  
BLDG. 1, THIRD FLOOR, UNIT A  
AIR CONDITIONING SYSTEM,  
ADMITTING & OUTPATIENT CLINIC,  
REMODEL AUDITORIUM.

VETERANS ADMINISTRATION  
V.A.H. - INDIANAPOLIS  
(N.T.S. & C.E. DIVISION), INDIANA

Drawn By: J.P. Date: 2/8/74  
Checked: W.D. Date: 2/8/74

LONGHART & ASSOCIATES, INC.  
3515 WASHINGTON BOULEVARD  
INDIANAPOLIS, INDIANA 46206  
517-924-8874

APPROVED: PROJECT DIRECTOR  
W.A. Selmond

DRAWING NUMBER  
1H9A  
Proj. No. 583-010

RETURN TO PLAN LIBRARY


FILE FOLDER NO. 2C

AS BUILT









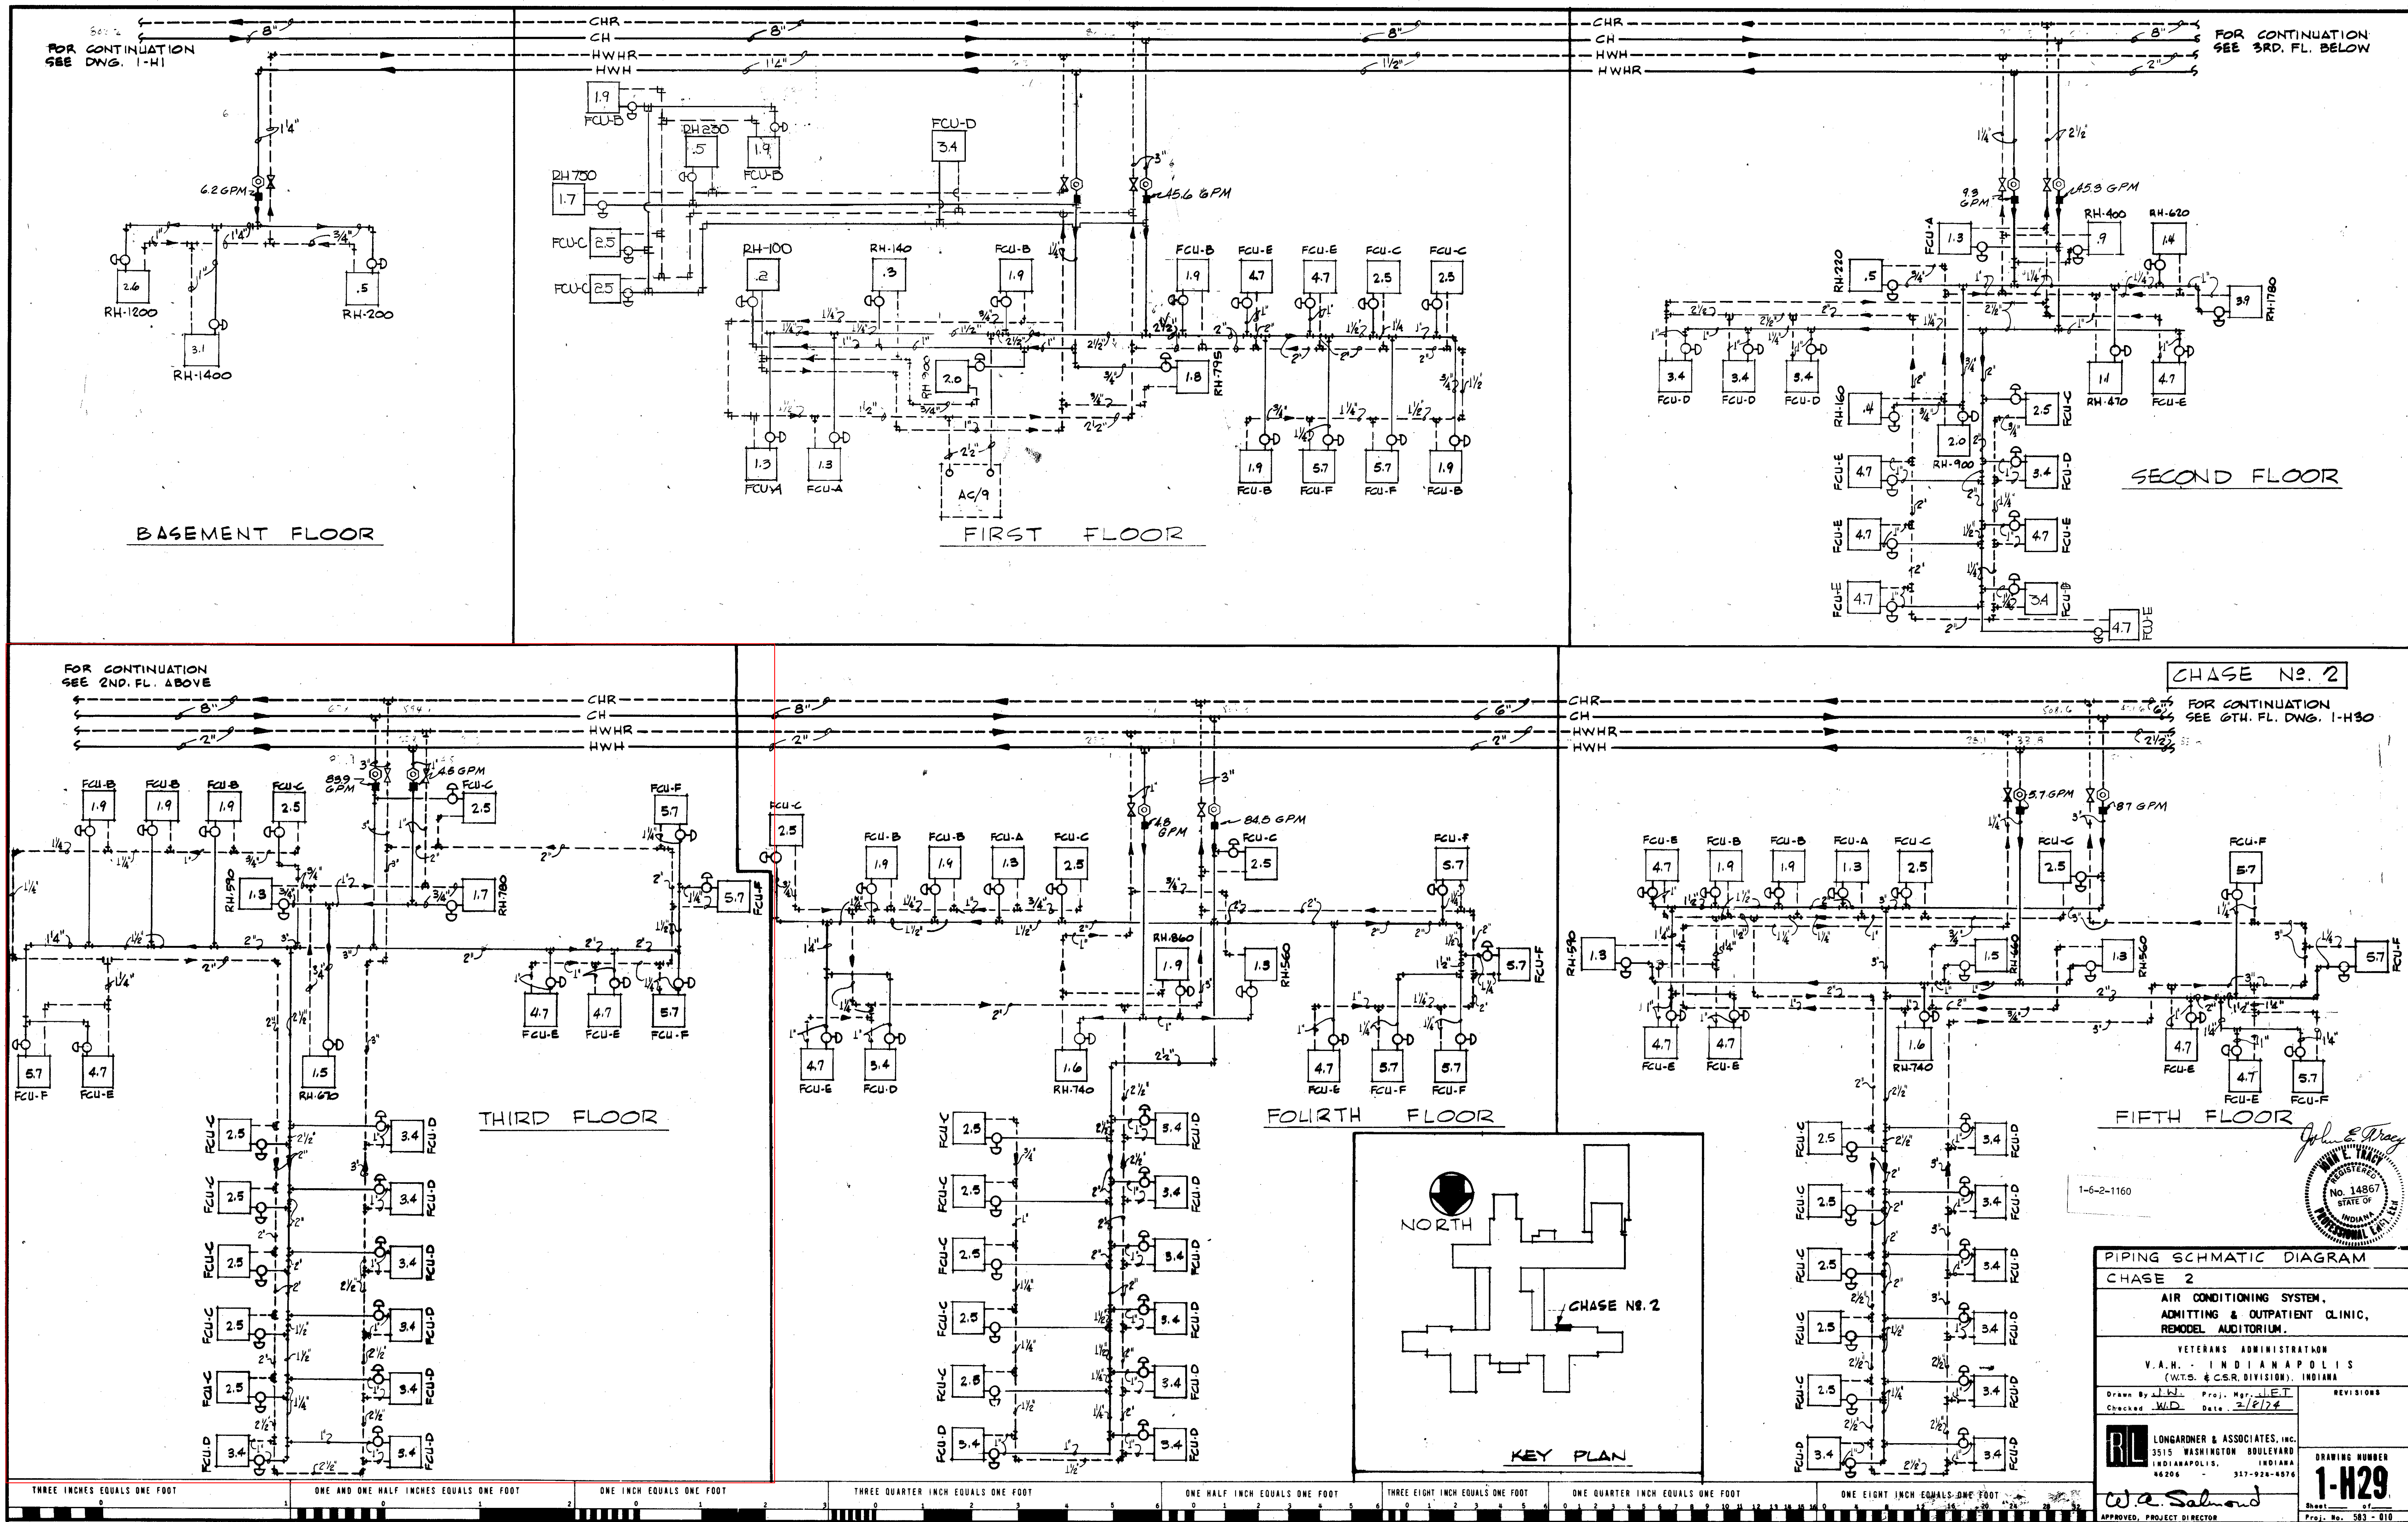



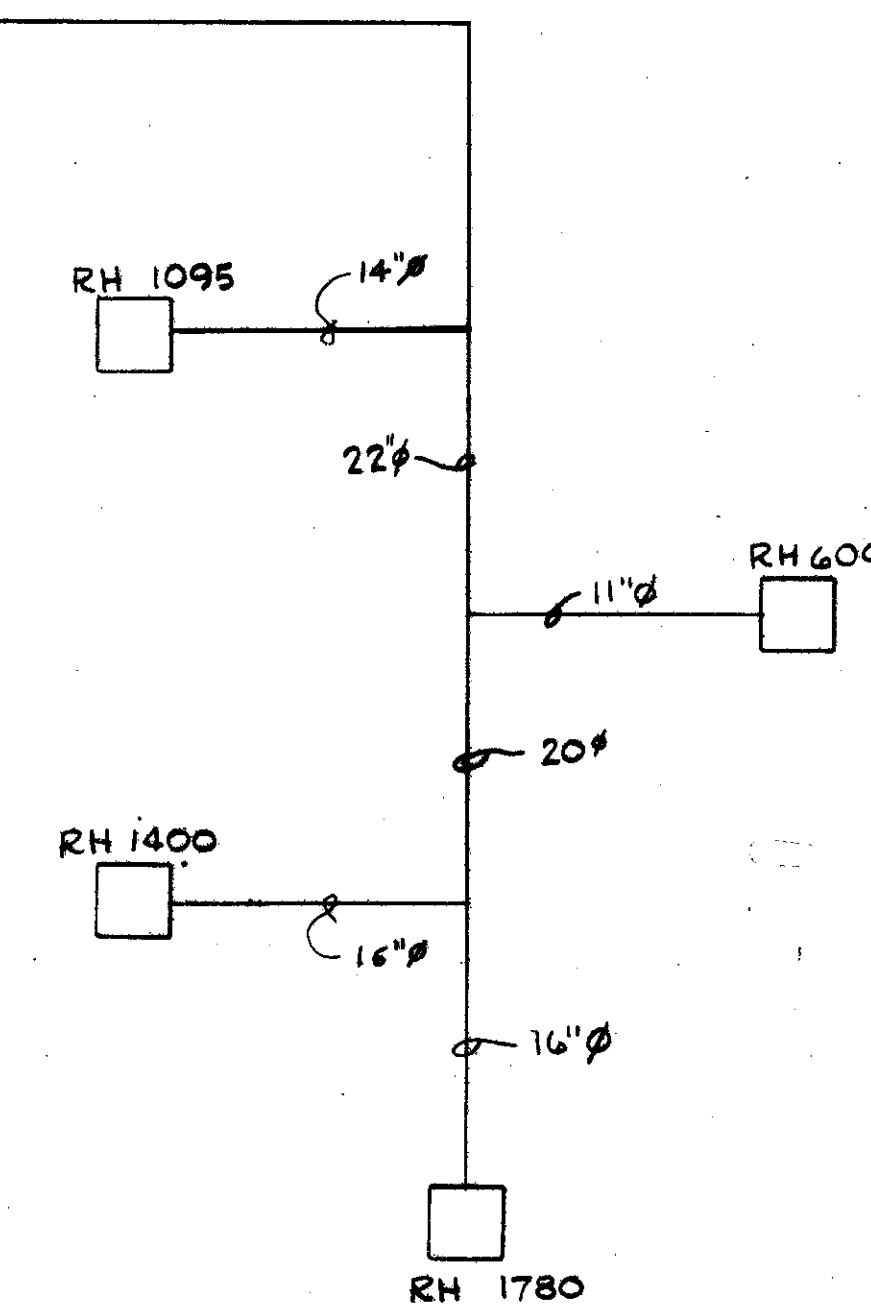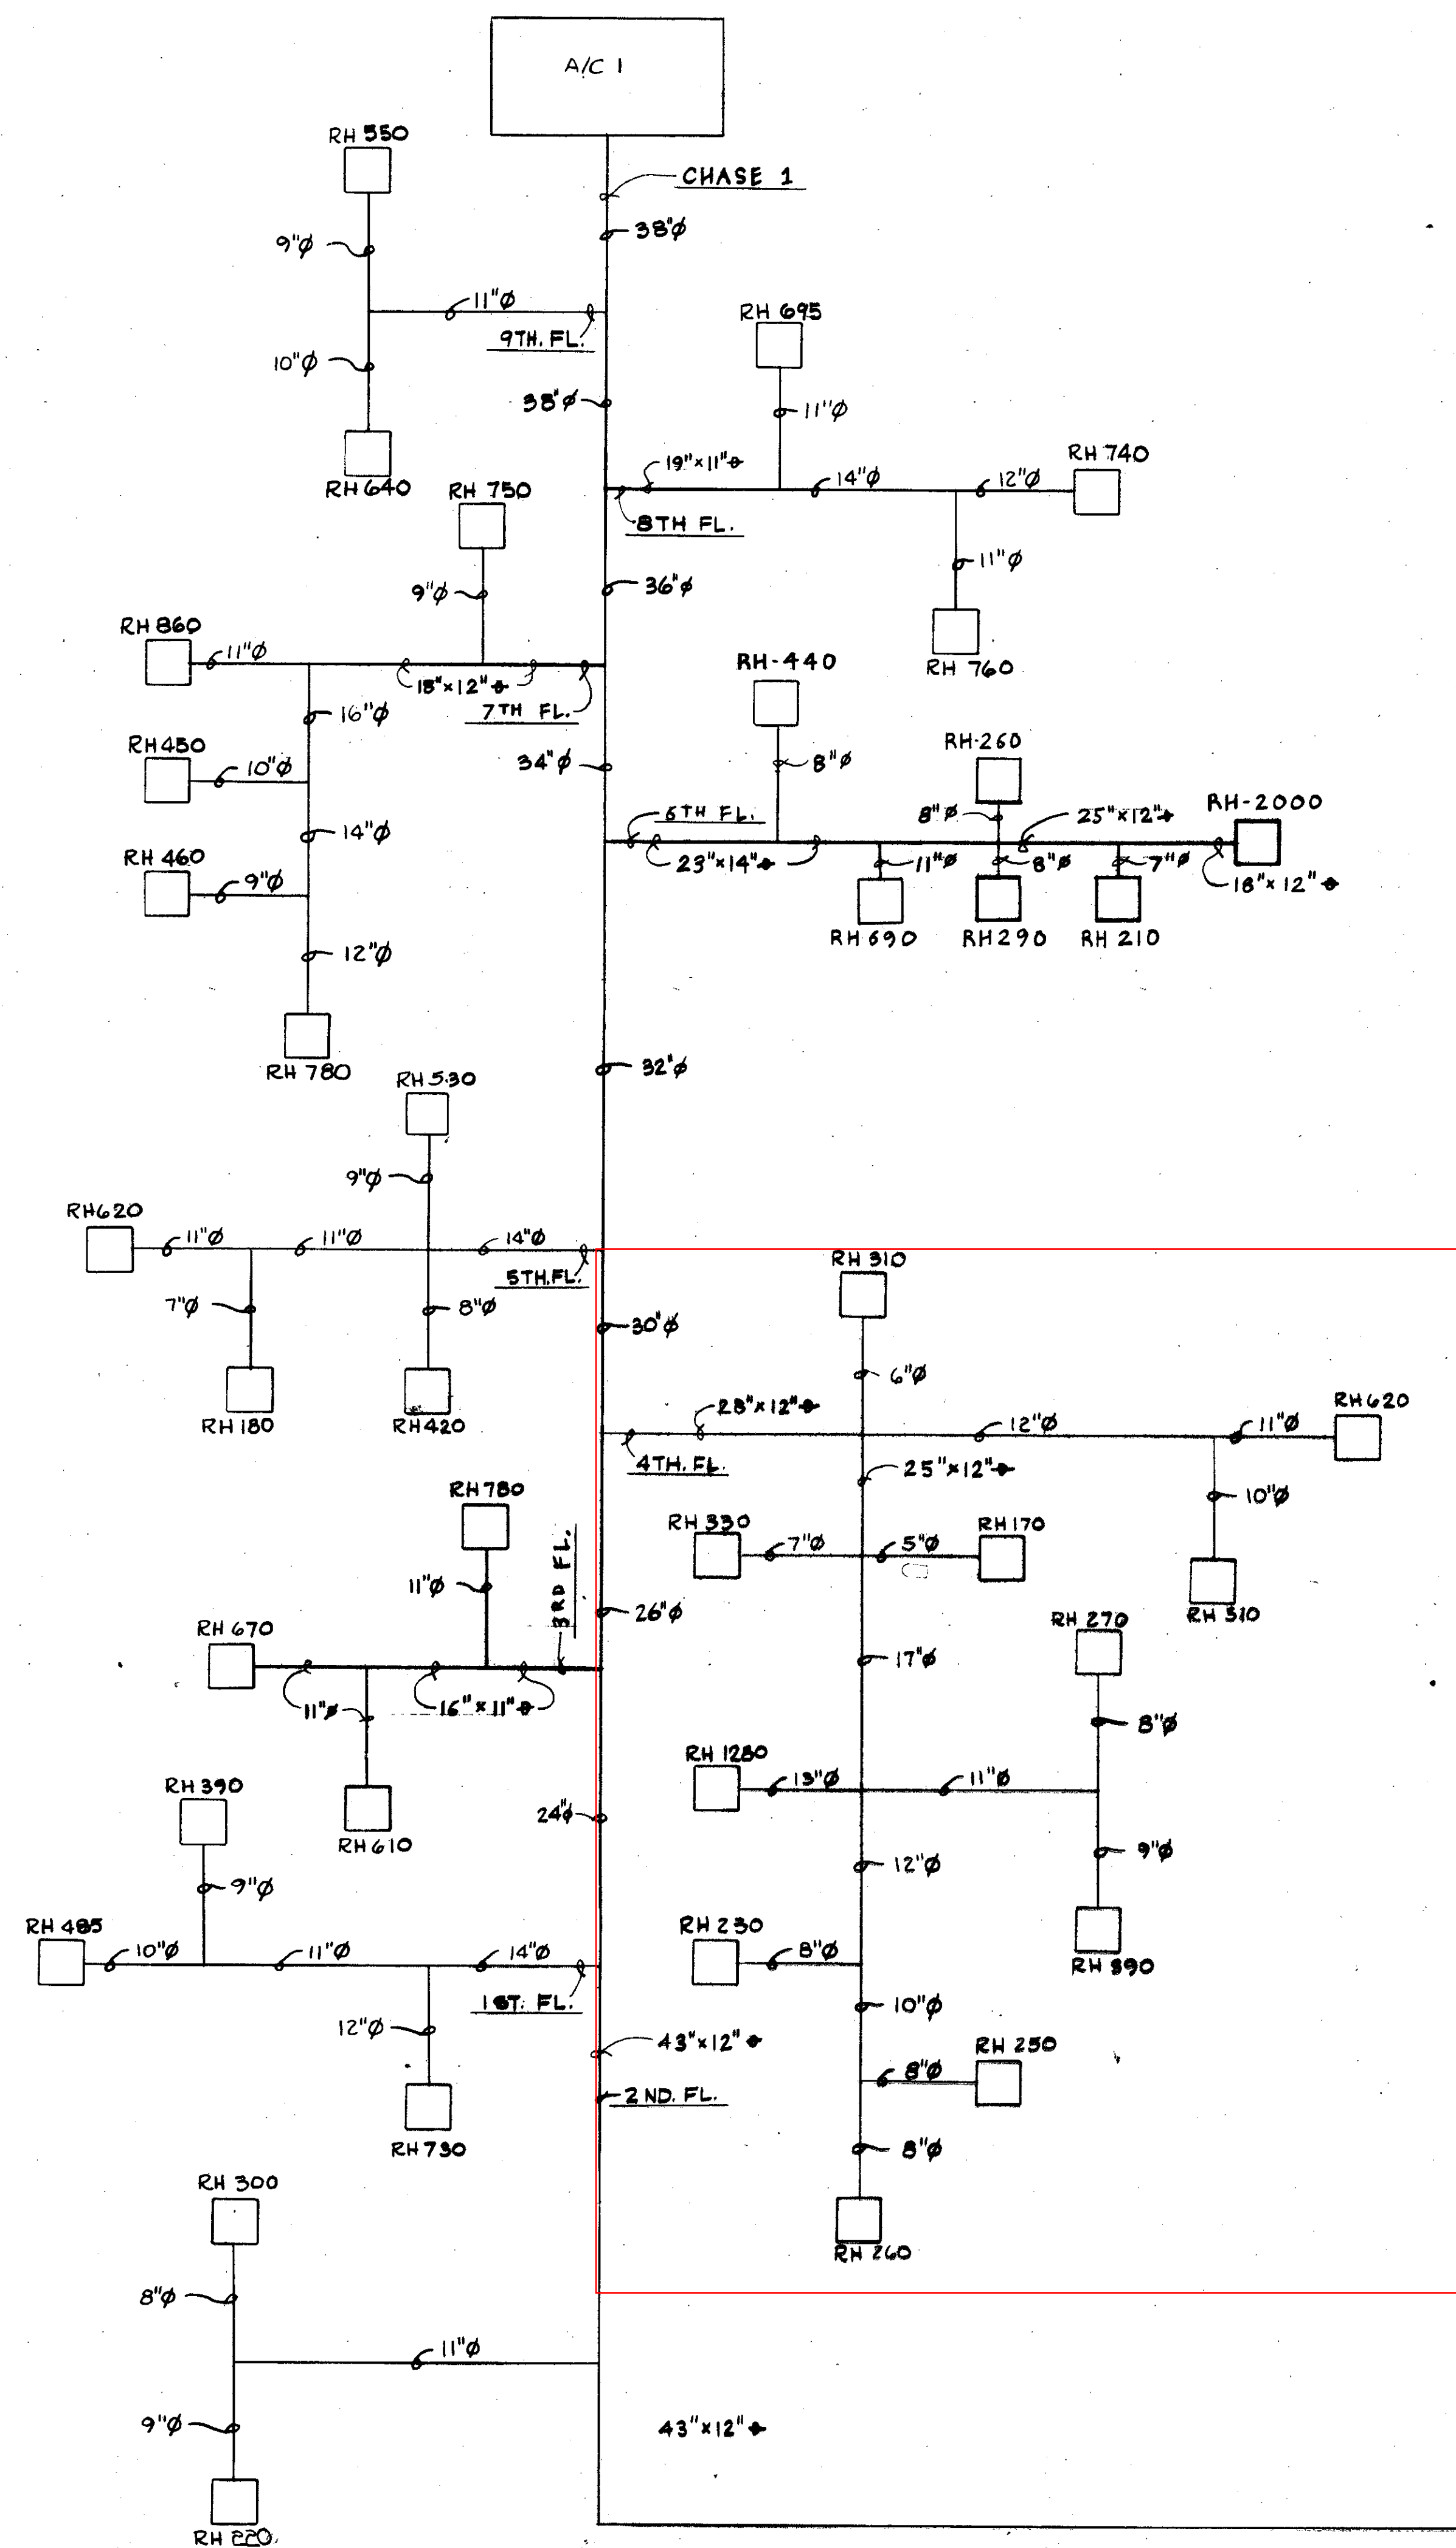

THREE INCHES EQUALS ONE FOOT    ONE AND ONE HALF INCHES EQUALS ONE FOOT    ONE INCH EQUALS ONE FOOT    THREE QUARTER INCH EQUALS ONE FOOT    ONE HALF INCH EQUALS ONE FOOT    THREE EIGHT INCH EQUALS ONE FOOT    ONE QUARTER INCH EQUALS ONE FOOT    ONE EIGHT INCH EQUALS ONE FOOT


RETURN TO PLAN LIBRARY

FILE FOLDER NO. 2C

DUCT SCHEMATIC DIAGRAMS	
AIR CONDITIONING SYSTEM, ADMITTING & OUTPATIENT CLINIC, REMODEL AUDITORIUM.	
VETERANS ADMINISTRATION V.A.H. - INDIANAPOLIS (M.T.S. & C.B.R. DIVISION), INDIANA	
Drawn By <u>RS</u> Checked <u>WD</u>	Proj. Mgr. <u>JET</u> Date <u>2/27/74</u>
<b>W.A. Salmon</b> APPROVED, PROJECT DIRECTOR	
LONGARDNER & ASSOCIATES, INC. 3515 WASHINGTON BOULEVARD INDIANAPOLIS, INDIANA 46206 317-926-8676	DRAWING NUMBER <b>1-H32</b> Sheet <u>57</u> of <u>57</u> Proj. No. <u>585-00</u>

**AS BUILT**



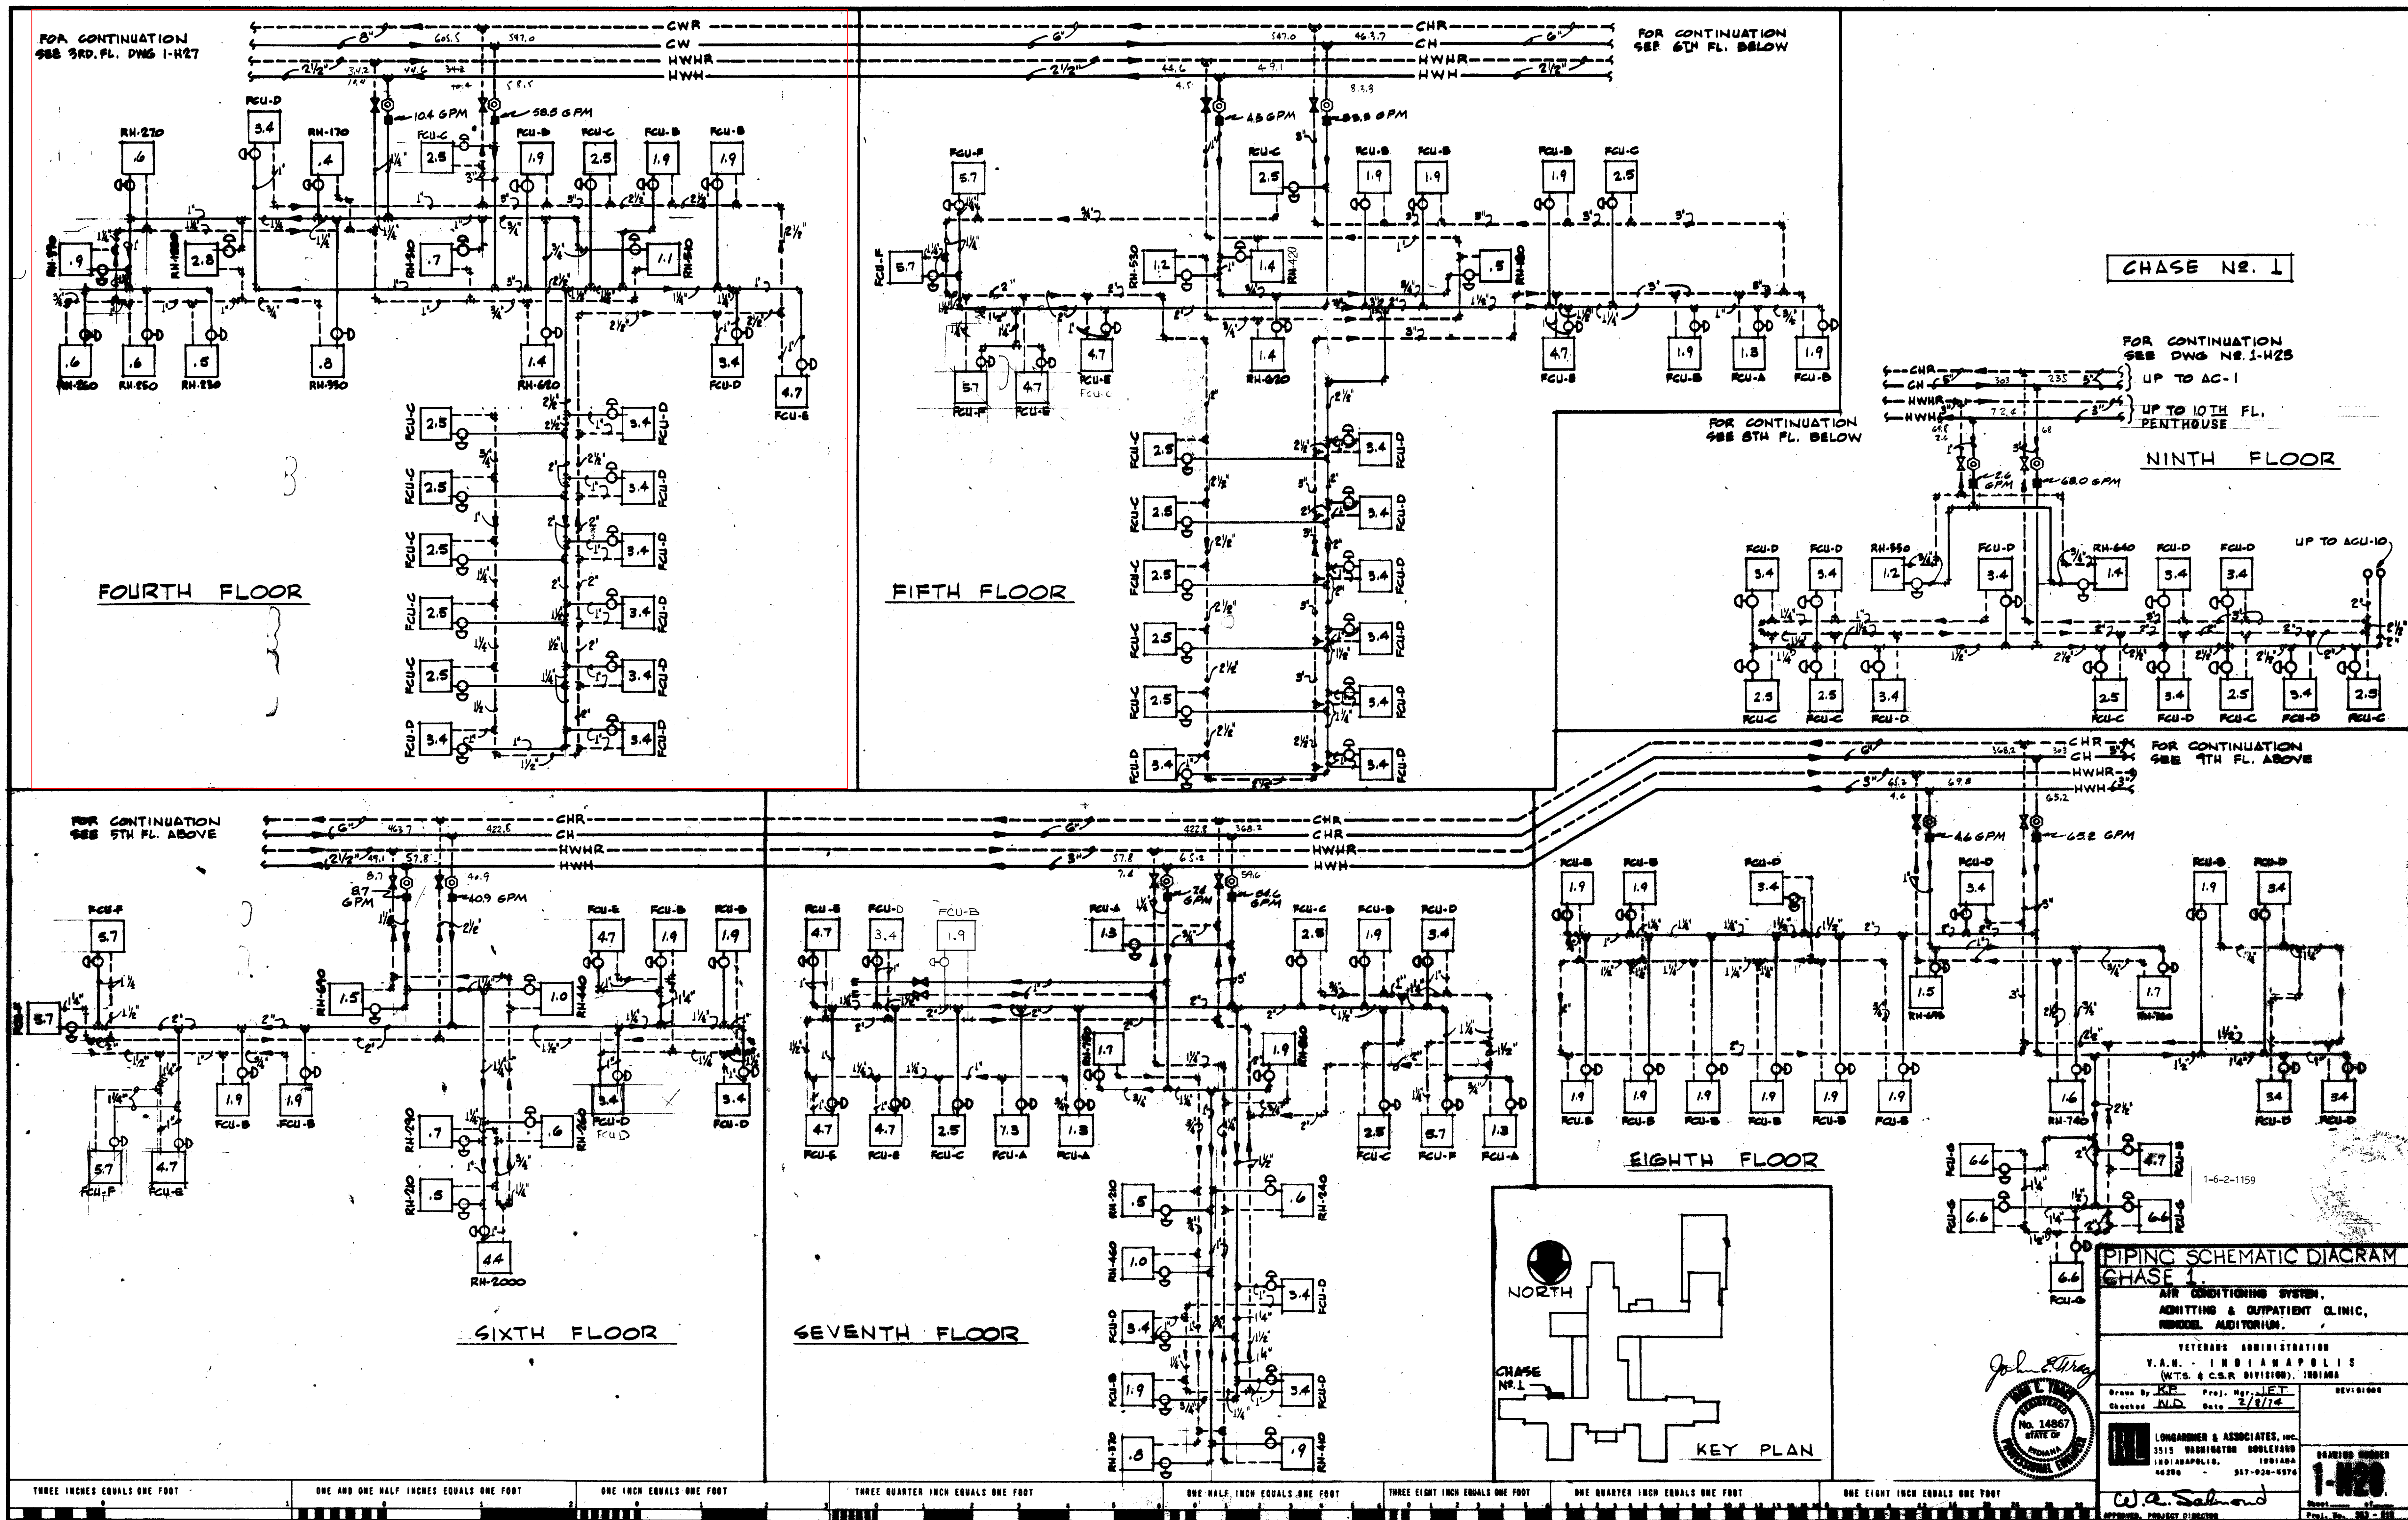


RETURN TO PLAN LIBRARY

FILE FOLDER NO. 2c



PLAN NOTE:  
 ■■■ INDICATES RECESSED FCU.

△ MATCH LINE FOR CONTINUATION SEE SHEET I-112

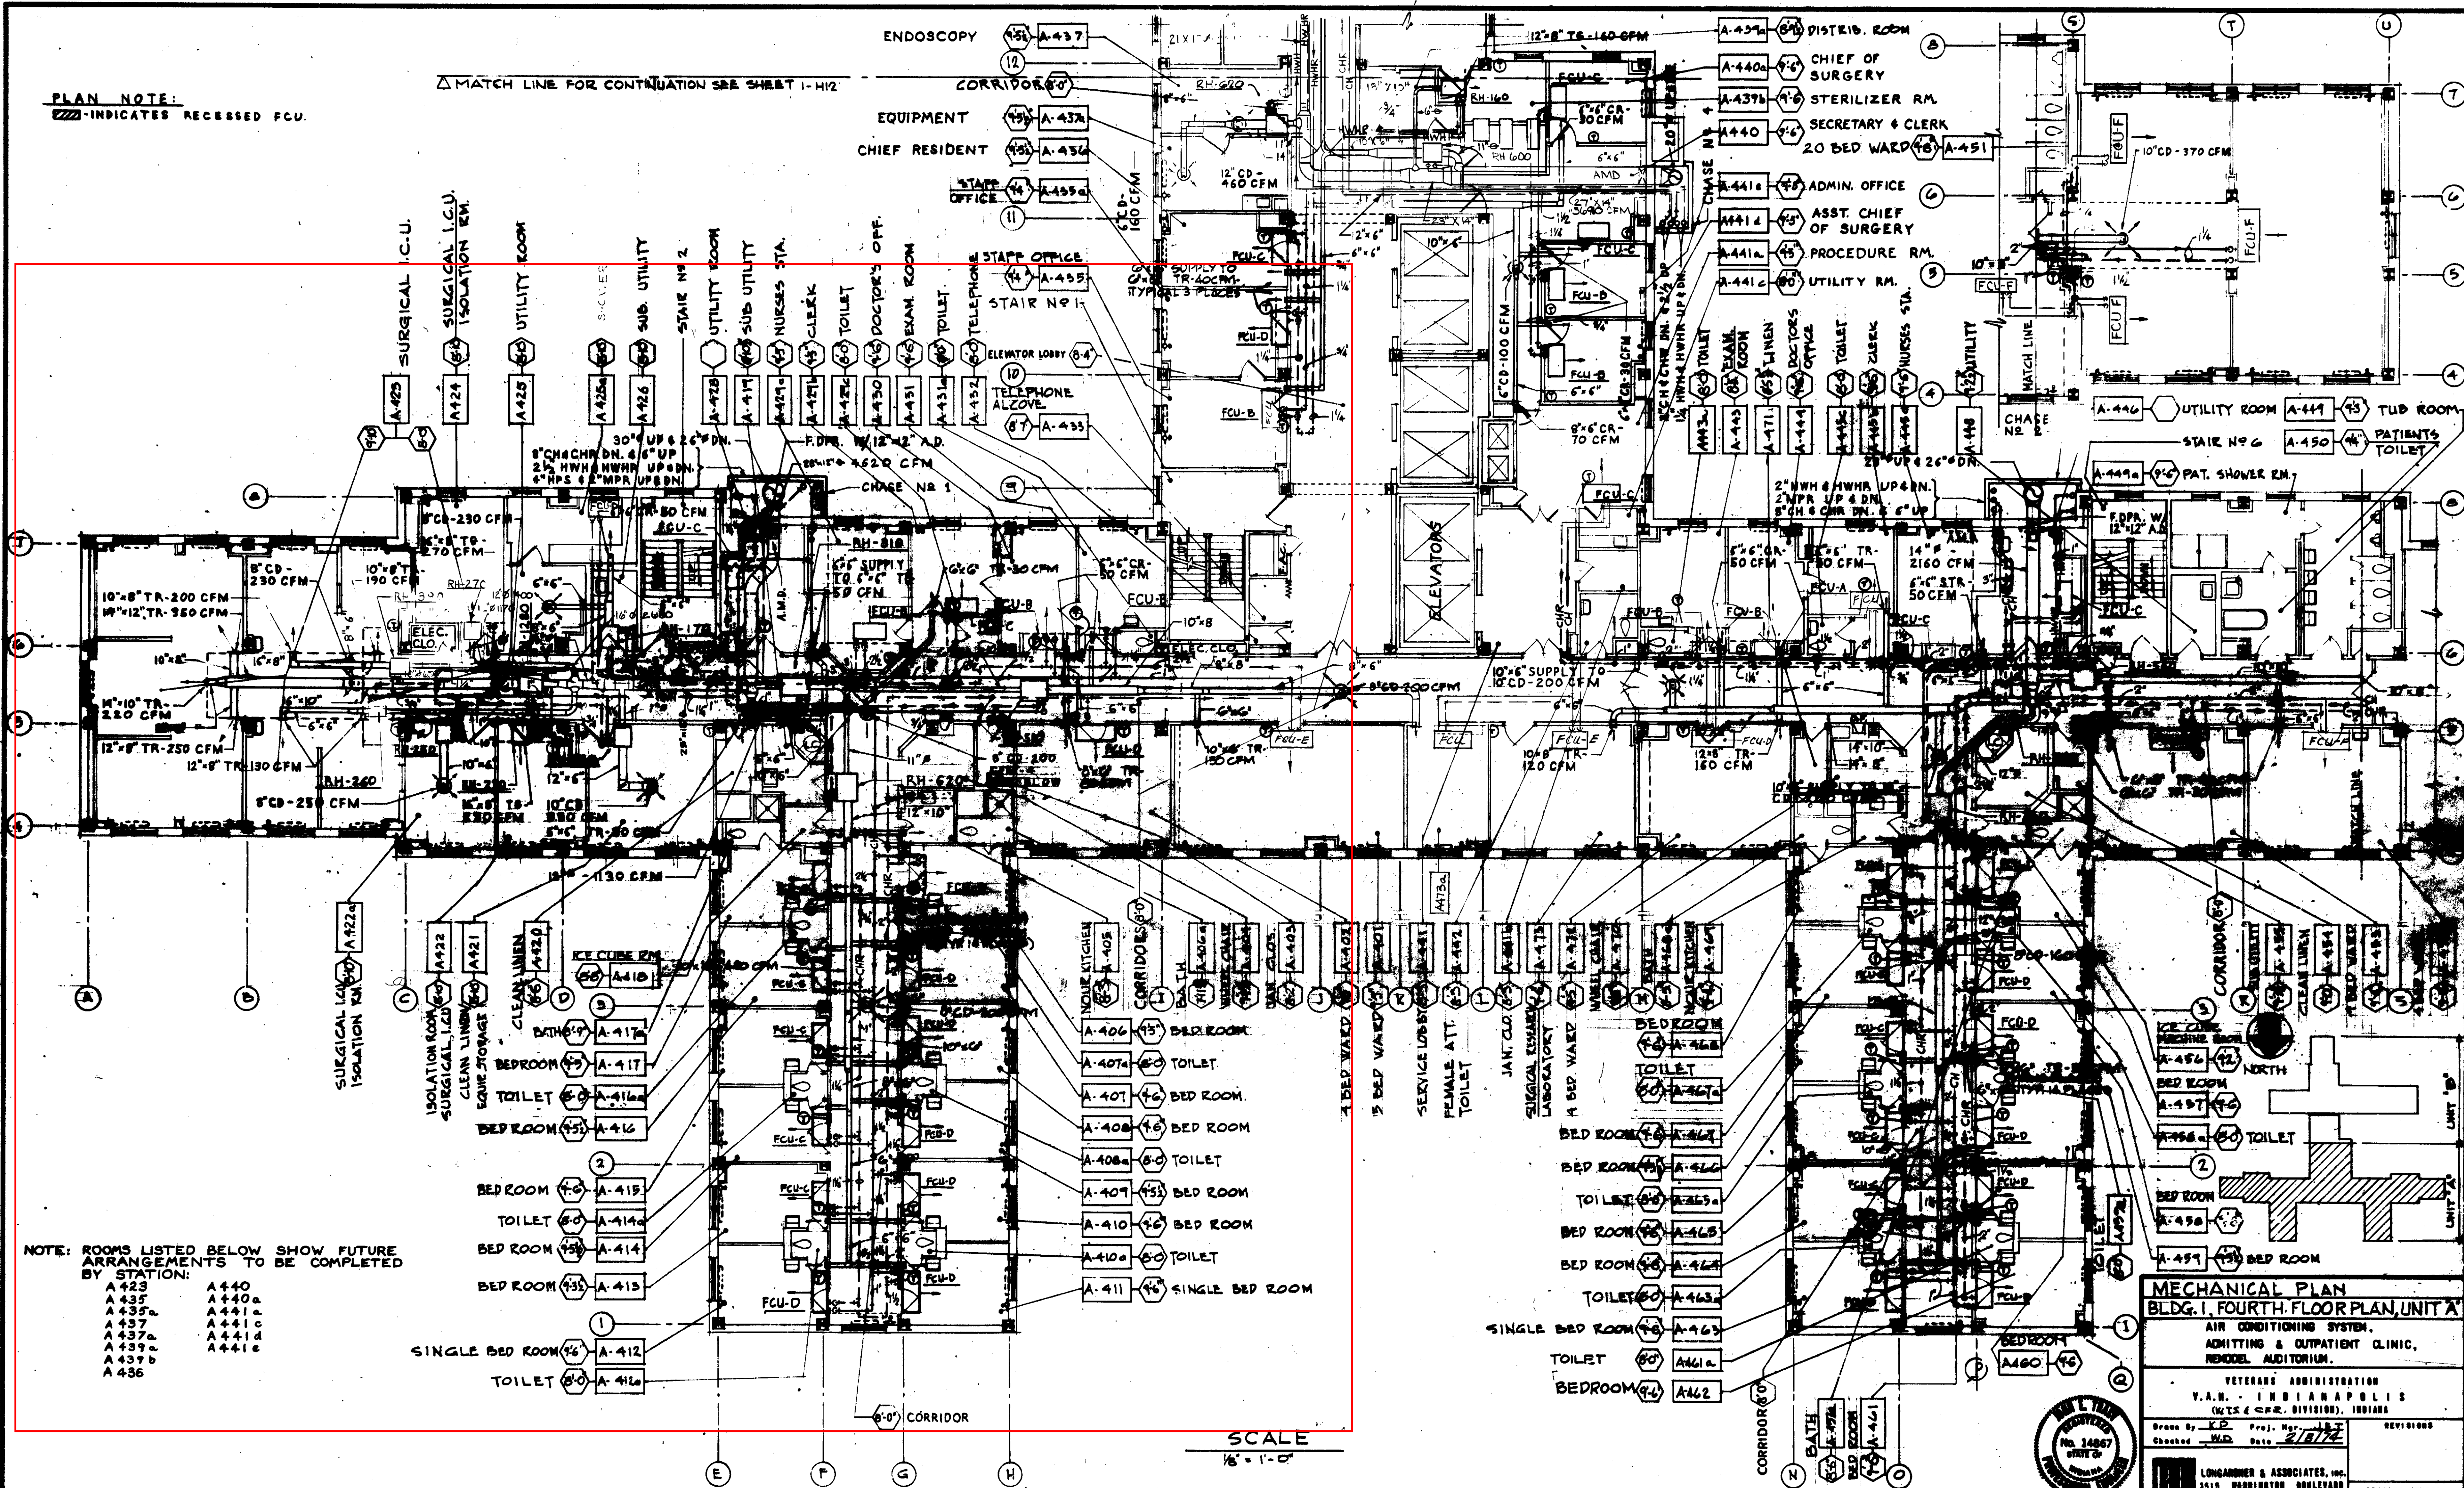

NOTE: ROOMS LISTED BELOW SHOW FUTURE ARRANGEMENTS TO BE COMPLETED BY STATION:

A-423	A-440
A-435	A-440a
A-435a	A-441
A-437	A-441a
A-437a	A-441c
A-439a	A-441d
A-439b	A-441e
A-436	

SCALE  
 1/8" = 1'-0"

**MECHANICAL PLAN**  
 BLDG. I, FOURTH FLOOR PLAN, UNIT A

AIR CONDITIONING SYSTEM,  
 ADMITTING & OUTPATIENT CLINIC,  
 REMODEL AUDITORIUM.

VETERANS ADMINISTRATION  
 V.A.H. - INDIANAPOLIS  
 (METS & CORR. DIVISION), INDIANA

Drawn By: J.D. Proj. No.: 15-7  
 Checked: W.D. Date: 2/10/74

LONGANGER & ASSOCIATES, INC.  
 3515 WASHINGTON BOULEVARD  
 INDIANAPOLIS, INDIANA 46206  
 317-926-0070

SHAWING BOARD  
**1-111**

THREE EIGHTS EQUALS ONE FOOT    ONE AND ONE HALF INCHES EQUALS ONE FOOT    ONE INCH EQUALS ONE FOOT    THREE QUARTER INCH EQUALS ONE FOOT    ONE HALF INCH EQUALS ONE FOOT    THREE EIGHTS INCH EQUALS ONE FOOT    ONE QUARTER INCH EQUALS ONE FOOT    ONE EIGHT INCH EQUALS ONE FOOT




583-010 V.A.H. INDIANAPOLIS, BLDG. 1, FOURTH FLOOR PLAN, UNIT 'A', MECHANICAL OVERLAY, UNIT 'A', BASIC PLAN (BLUE) 1-111A, 1-111B, 1-111C, 1-111D, 1-111E, 1-111F, 1-111G, 1-111H, 1-111I, 1-111J, 1-111K, 1-111L, 1-111M, 1-111N, 1-111O, 1-111P, 1-111Q, 1-111R, 1-111S, 1-111T, 1-111U, 1-111V, 1-111W, 1-111X, 1-111Y, 1-111Z, 1-111AA, 1-111AB, 1-111AC, 1-111AD, 1-111AE, 1-111AF, 1-111AG, 1-111AH, 1-111AI, 1-111AJ, 1-111AK, 1-111AL, 1-111AM, 1-111AN, 1-111AO, 1-111AP, 1-111AQ, 1-111AR, 1-111AS, 1-111AT, 1-111AU, 1-111AV, 1-111AW, 1-111AX, 1-111AY, 1-111AZ, 1-111BA, 1-111BB, 1-111BC, 1-111BD, 1-111BE, 1-111BF, 1-111BG, 1-111BH, 1-111BI, 1-111BJ, 1-111BK, 1-111BL, 1-111BM, 1-111BN, 1-111BO, 1-111BP, 1-111BQ, 1-111BR, 1-111BS, 1-111BT, 1-111BU, 1-111BV, 1-111BW, 1-111BX, 1-111BY, 1-111BZ, 1-111CA, 1-111CB, 1-111CC, 1-111CD, 1-111CE, 1-111CF, 1-111CG, 1-111CH, 1-111CI, 1-111CJ, 1-111CK, 1-111CL, 1-111CM, 1-111CN, 1-111CO, 1-111CP, 1-111CQ, 1-111CR, 1-111CS, 1-111CT, 1-111CU, 1-111CV, 1-111CW, 1-111CX, 1-111CY, 1-111CZ, 1-111DA, 1-111DB, 1-111DC, 1-111DD, 1-111DE, 1-111DF, 1-111DG, 1-111DH, 1-111DI, 1-111DJ, 1-111DK, 1-111DL, 1-111DM, 1-111DN, 1-111DO, 1-111DP, 1-111DQ, 1-111DR, 1-111DS, 1-111DT, 1-111DU, 1-111DV, 1-111DW, 1-111DX, 1-111DY, 1-111DZ, 1-111EA, 1-111EB, 1-111EC, 1-111ED, 1-111EE, 1-111EF, 1-111EG, 1-111EH, 1-111EI, 1-111EJ, 1-111EK, 1-111EL, 1-111EM, 1-111EN, 1-111EO, 1-111EP, 1-111EQ, 1-111ER, 1-111ES, 1-111ET, 1-111EU, 1-111EV, 1-111EW, 1-111EX, 1-111EY, 1-111EZ, 1-111FA, 1-111FB, 1-111FC, 1-111FD, 1-111FE, 1-111FF, 1-111FG, 1-111FH, 1-111FI, 1-111FJ, 1-111FK, 1-111FL, 1-111FM, 1-111FN, 1-111FO, 1-111FP, 1-111FQ, 1-111FR, 1-111FS, 1-111FT, 1-111FU, 1-111FV, 1-111FW, 1-111FX, 1-111FY, 1-111FZ, 1-111GA, 1-111GB, 1-111GC, 1-111GD, 1-111GE, 1-111GF, 1-111GG, 1-111GH, 1-111GI, 1-111GJ, 1-111GK, 1-111GL, 1-111GM, 1-111GN, 1-111GO, 1-111GP, 1-111GQ, 1-111GR, 1-111GS, 1-111GT, 1-111GU, 1-111GV, 1-111GW, 1-111GX, 1-111GY, 1-111GZ, 1-111HA, 1-111HB, 1-111HC, 1-111HD, 1-111HE, 1-111HF, 1-111HG, 1-111HH, 1-111HI, 1-111HJ, 1-111HK, 1-111HL, 1-111HM, 1-111HN, 1-111HO, 1-111HP, 1-111HQ, 1-111HR, 1-111HS, 1-111HT, 1-111HU, 1-111HV, 1-111HW, 1-111HX, 1-111HY, 1-111HZ, 1-111IA, 1-111IB, 1-111IC, 1-111ID, 1-111IE, 1-111IF, 1-111IG, 1-111IH, 1-111II, 1-111IJ, 1-111IK, 1-111IL, 1-111IM, 1-111IN, 1-111IO, 1-111IP, 1-111IQ, 1-111IR, 1-111IS, 1-111IT, 1-111IU, 1-111IV, 1-111IW, 1-111IX, 1-111IY, 1-111IZ, 1-111JA, 1-111JB, 1-111JC, 1-111JD, 1-111JE, 1-111JF, 1-111JG, 1-111JH, 1-111JI, 1-111JJ, 1-111JK, 1-111JL, 1-111JM, 1-111JN, 1-111JO, 1-111JP, 1-111JQ, 1-111JR, 1-111JS, 1-111JT, 1-111JU, 1-111JV, 1-111JW, 1-111JX, 1-111JY, 1-111JZ, 1-111KA, 1-111KB, 1-111KC, 1-111KD, 1-111KE, 1-111KF, 1-111KG, 1-111KH, 1-111KI, 1-111KJ, 1-111KK, 1-111KL, 1-111KM, 1-111KN, 1-111KO, 1-111KP, 1-111KQ, 1-111KR, 1-111KS, 1-111KT, 1-111KU, 1-111KV, 1-111KW, 1-111KX, 1-111KY, 1-111KZ, 1-111LA, 1-111LB, 1-111LC, 1-111LD, 1-111LE, 1-111LF, 1-111LG, 1-111LH, 1-111LI, 1-111LJ, 1-111LK, 1-111LL, 1-111LM, 1-111LN, 1-111LO, 1-111LP, 1-111LQ, 1-111LR, 1-111LS, 1-111LT, 1-111LU, 1-111LV, 1-111LW, 1-111LX, 1-111LY, 1-111LZ, 1-111MA, 1-111MB, 1-111MC, 1-111MD, 1-111ME, 1-111MF, 1-111MG, 1-111MH, 1-111MI, 1-111MJ, 1-111MK, 1-111ML, 1-111MM, 1-111MN, 1-111MO, 1-111MP, 1-111MQ, 1-111MR, 1-111MS, 1-111MT, 1-111MU, 1-111MV, 1-111MW, 1-111MX, 1-111MY, 1-111MZ, 1-111NA, 1-111NB, 1-111NC, 1-111ND, 1-111NE, 1-111NF, 1-111NG, 1-111NH, 1-111NI, 1-111NJ, 1-111NK, 1-111NL, 1-111NM, 1-111NN, 1-111NO, 1-111NP, 1-111NQ, 1-111NR, 1-111NS, 1-111NT, 1-111NU, 1-111NV, 1-111NW, 1-111NX, 1-111NY, 1-111NZ, 1-111OA, 1-111OB, 1-111OC, 1-111OD, 1-111OE, 1-111OF, 1-111OG, 1-111OH, 1-111OI, 1-111OJ, 1-111OK, 1-111OL, 1-111OM, 1-111ON, 1-111OO, 1-111OP, 1-111OQ, 1-111OR, 1-111OS, 1-111OT, 1-111OU, 1-111OV, 1-111OW, 1-111OX, 1-111OY, 1-111OZ, 1-111PA, 1-111PB, 1-111PC, 1-111PD, 1-111PE, 1-111PF, 1-111PG, 1-111PH, 1-111PI, 1-111PJ, 1-111PK, 1-111PL, 1-111PM, 1-111PN, 1-111PO, 1-111PP, 1-111PQ, 1-111PR, 1-111PS, 1-111PT, 1-111PU, 1-111PV, 1-111PW, 1-111PX, 1-111PY, 1-111PZ, 1-111QA, 1-111QB, 1-111QC, 1-111QD, 1-111QE, 1-111QF, 1-111QG, 1-111QH, 1-111QI, 1-111QJ, 1-111QK, 1-111QL, 1-111QM, 1-111QN, 1-111QO, 1-111QP, 1-111QQ, 1-111QR, 1-111QS, 1-111QT, 1-111QU, 1-111QV, 1-111QW, 1-111QX, 1-111QY, 1-111QZ, 1-111RA, 1-111RB, 1-111RC, 1-111RD, 1-111RE, 1-111RF, 1-111RG, 1-111RH, 1-111RI, 1-111RJ, 1-111RK, 1-111RL, 1-111RM, 1-111RN, 1-111RO, 1-111RP, 1-111RQ, 1-111RR, 1-111RS, 1-111RT, 1-111RU, 1-111RV, 1-111RW, 1-111RX, 1-111RY, 1-111RZ, 1-111SA, 1-111SB, 1-111SC, 1-111SD, 1-111SE, 1-111SF, 1-111SG, 1-111SH, 1-111SI, 1-111SJ, 1-111SK, 1-111SL, 1-111SM, 1-111SN, 1-111SO, 1-111SP, 1-111SQ, 1-111SR, 1-111SS, 1-111ST, 1-111SU, 1-111SV, 1-111SW, 1-111SX, 1-111SY, 1-111SZ, 1-111TA, 1-111TB, 1-111TC, 1-111TD, 1-111TE, 1-111TF, 1-111TG, 1-111TH, 1-111TI, 1-111TJ, 1-111TK, 1-111TL, 1-111TM, 1-111TN, 1-111TO, 1-111TP, 1-111TQ, 1-111TR, 1-111TS, 1-111TT, 1-111TU, 1-111TV, 1-111TW, 1-111TX, 1-111TY, 1-111TZ, 1-111UA, 1-111UB, 1-111UC, 1-111UD, 1-111UE, 1-111UF, 1-111UG, 1-111UH, 1-111UI, 1-111UJ, 1-111UK, 1-111UL, 1-111UM, 1-111UN, 1-111UO, 1-111UP, 1-111UQ, 1-111UR, 1-111US, 1-111UT, 1-111UU, 1-111UV, 1-111UW, 1-111UX, 1-111UY, 1-111UZ, 1-111VA, 1-111VB, 1-111VC, 1-111VD, 1-111VE, 1-111VF, 1-111VG, 1-111VH, 1-111VI, 1-111VJ, 1-111VK, 1-111VL, 1-111VM, 1-111VN, 1-111VO, 1-111VP, 1-111VQ, 1-111VR, 1-111VS, 1-111VT, 1-111VU, 1-111VV, 1-111VW, 1-111VX, 1-111VY, 1-111VZ, 1-111WA, 1-111WB, 1-111WC, 1-111WD, 1-111WE, 1-111WF, 1-111WG, 1-111WH, 1-111WI, 1-111WJ, 1-111WK, 1-111WL, 1-111WM, 1-111WN, 1-111WO, 1-111WP, 1-111WQ, 1-111WR, 1-111WS, 1-111WT, 1-111WU, 1-111WV, 1-111WW, 1-111WX, 1-111WY, 1-111WZ, 1-111XA, 1-111XB, 1-111XC, 1-111XD, 1-111XE, 1-111XF, 1-111XG, 1-111XH, 1-111XI, 1-111XJ, 1-111XK, 1-111XL, 1-111XM, 1-111XN, 1-111XO, 1-111XP, 1-111XQ, 1-111XR, 1-111XS, 1-111XT, 1-111XU, 1-111XV, 1-111XW, 1-111XX, 1-111XY, 1-111XZ, 1-111YA, 1-111YB, 1-111YC, 1-111YD, 1-111YE, 1-111YF, 1-111YG, 1-111YH, 1-111YI, 1-111YJ, 1-111YK, 1-111YL, 1-111YM, 1-111YN, 1-111YO, 1-111YP, 1-111YQ, 1-111YR, 1-111YS, 1-111YT, 1-111YU, 1-111YV, 1-111YW, 1-111YX, 1-111YY, 1-111YZ, 1-111ZA, 1-111ZB, 1-111ZC, 1-111ZD, 1-111ZE, 1-111ZF, 1-111ZG, 1-111ZH, 1-111ZI, 1-111ZJ, 1-111ZK, 1-111ZL, 1-111ZM, 1-111ZN, 1-111ZO, 1-111ZP, 1-111ZQ, 1-111ZR, 1-111ZS, 1-111ZT, 1-111ZU, 1-111ZV, 1-111ZW, 1-111ZX, 1-111ZY, 1-111ZZ

PLAN NOTE:

1. PITCH CONDENSATE DRAINS TOWARDS INDICATED DIRECTION OF FLOW @ 1/8" PER FOOT.
2. CONDENSATE DRAINS DOWN FROM FLOOR ABOVE FOR SOURCE OF ORIGIN SEE NEXT FLOOR PLAN ABOVE.
3. EXISTING DUCTS TO BE USED.

△ MATCH LINE FOR CONTINUATION SEE SHEET 1-112A

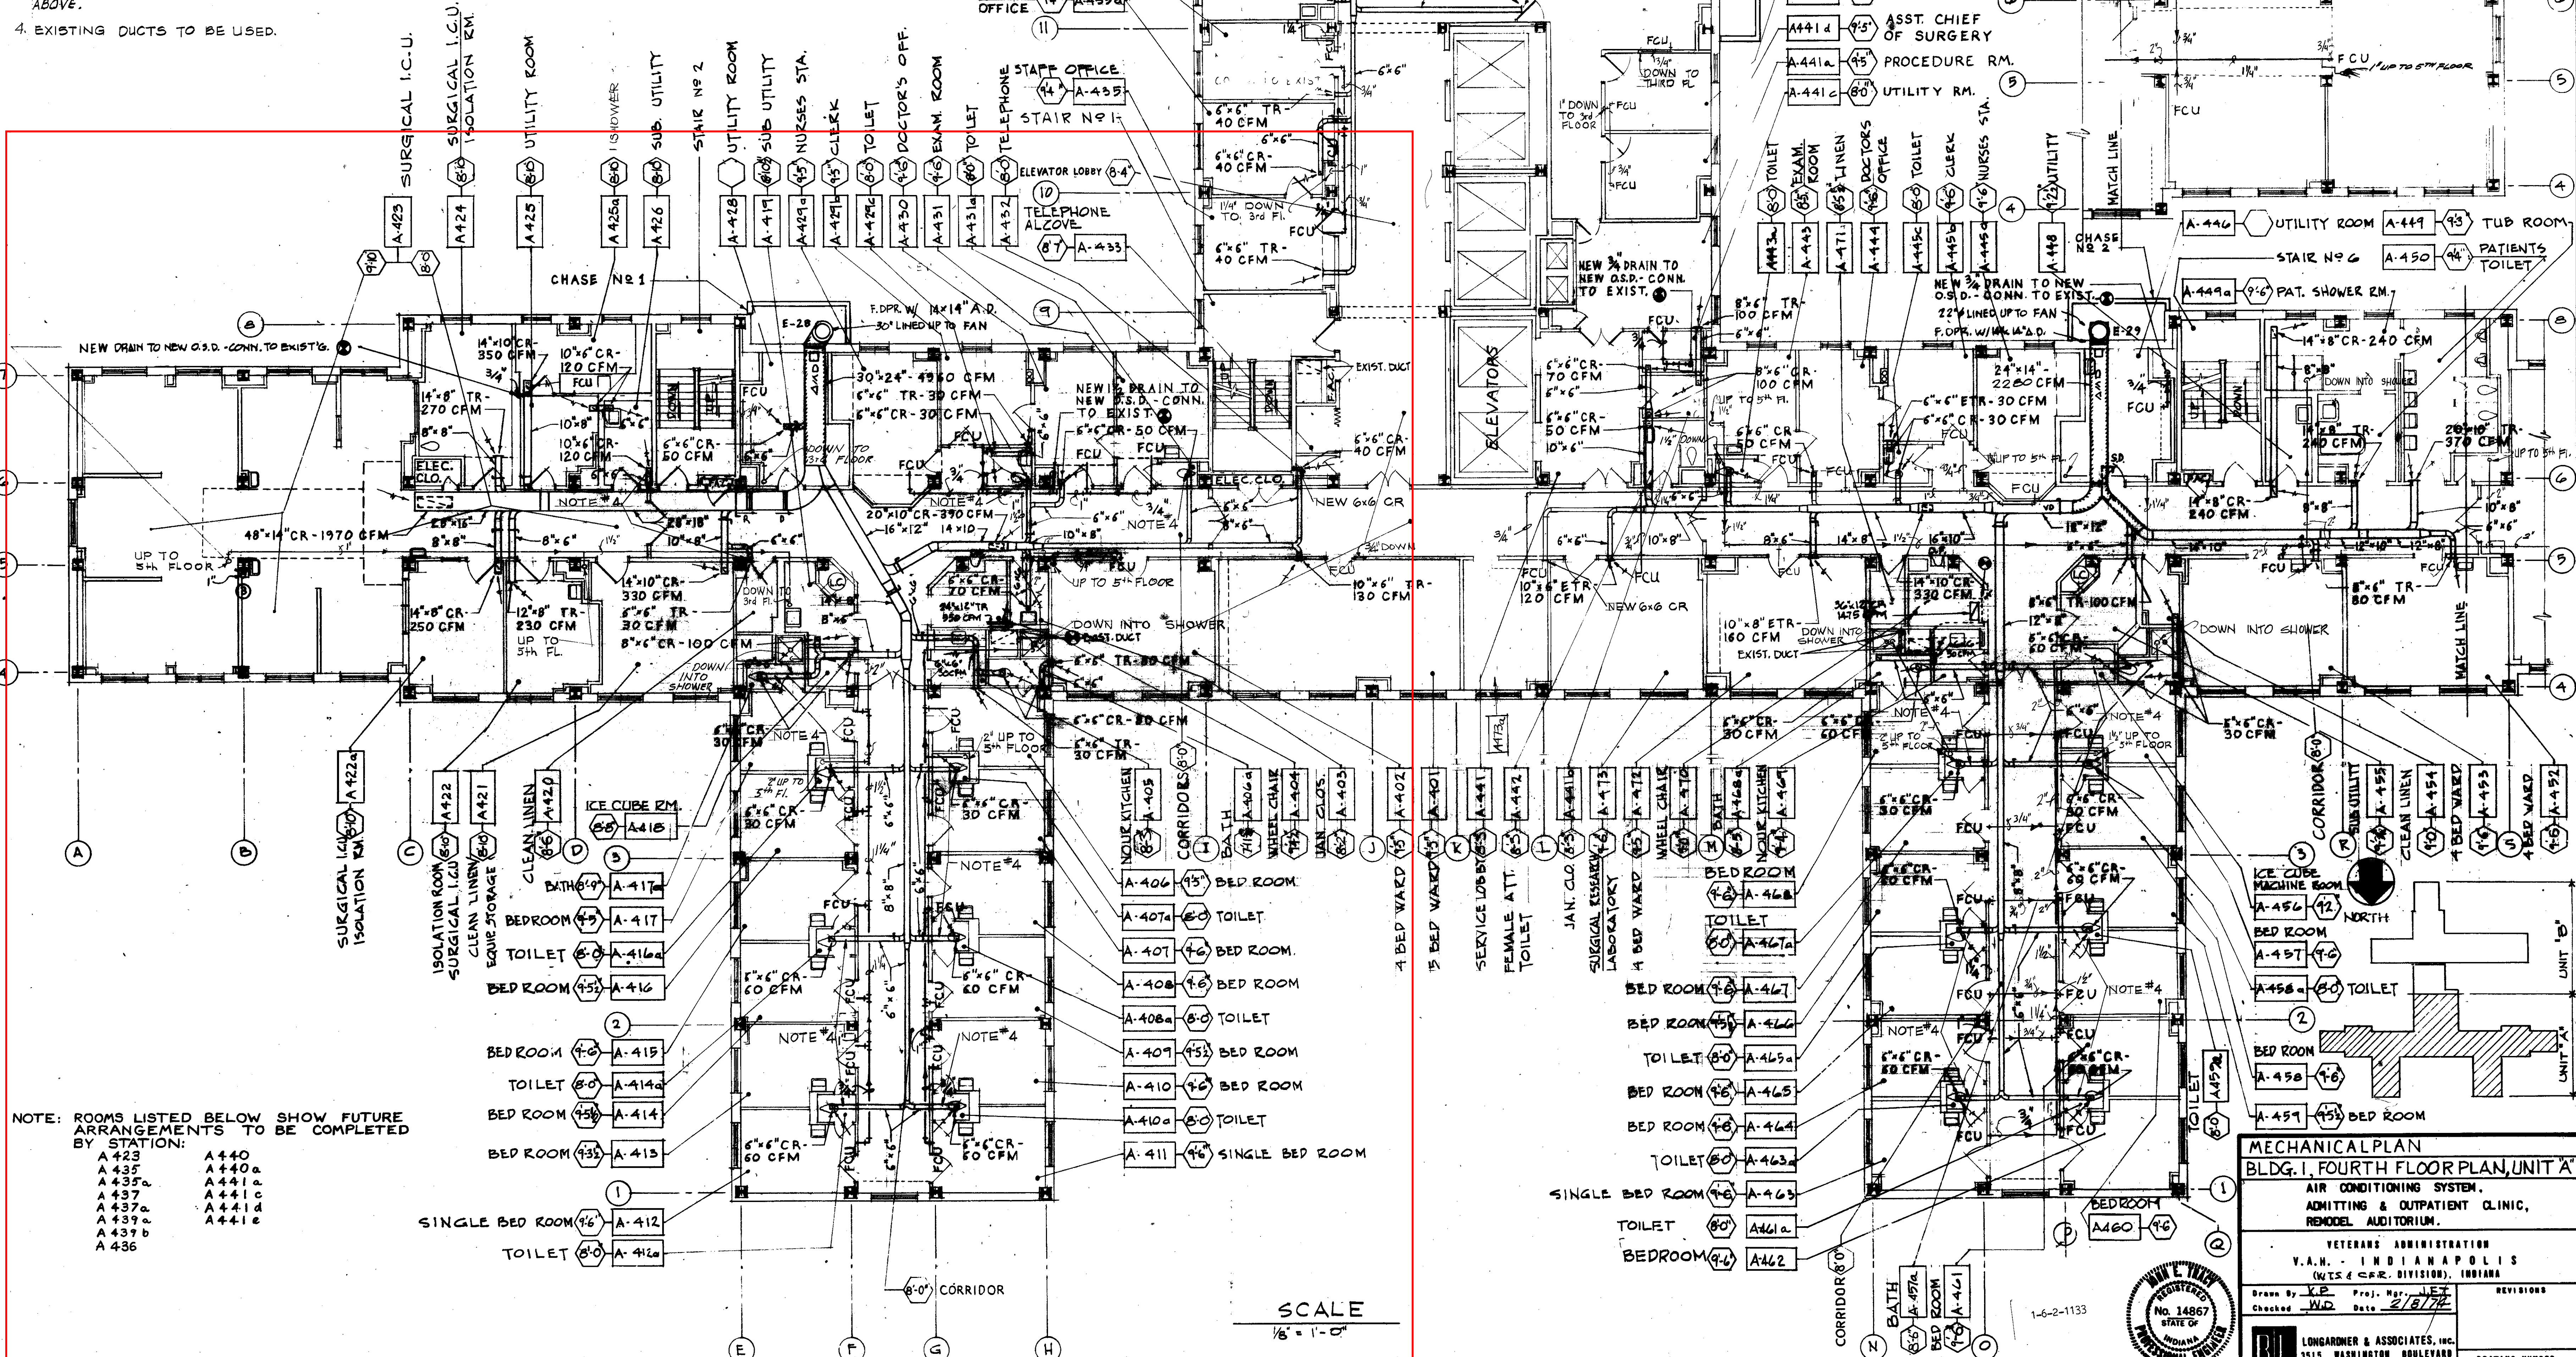

NOTE: ROOMS LISTED BELOW SHOW FUTURE ARRANGEMENTS TO BE COMPLETED BY STATION:

- |        |        |
|--------|--------|
| A-423  | A-440  |
| A-435  | A-440a |
| A-437a | A-441a |
| A-437b | A-441b |
| A-437c | A-441c |
| A-437d | A-441d |
| A-437e | A-441e |
| A-437f | A-441f |
| A-437g | A-441g |
| A-437h | A-441h |
| A-437i | A-441i |
| A-437j | A-441j |
| A-437k | A-441k |
| A-437l | A-441l |
| A-437m | A-441m |
| A-437n | A-441n |
| A-437o | A-441o |
| A-437p | A-441p |
| A-437q | A-441q |
| A-437r | A-441r |
| A-437s | A-441s |
| A-437t | A-441t |
| A-437u | A-441u |
| A-437v | A-441v |
| A-437w | A-441w |
| A-437x | A-441x |
| A-437y | A-441y |
| A-437z | A-441z |

- |                 |        |
|-----------------|--------|
| SINGLE BED ROOM | A-412  |
| TOILET          | A-412a |
| BED ROOM        | A-413  |
| TOILET          | A-413a |
| BED ROOM        | A-414  |
| TOILET          | A-414a |
| BED ROOM        | A-415  |
| TOILET          | A-415a |
| BED ROOM        | A-416  |
| TOILET          | A-416a |
| BED ROOM        | A-417  |
| TOILET          | A-417a |
| BED ROOM        | A-418  |
| TOILET          | A-418a |
| BED ROOM        | A-419  |
| TOILET          | A-419a |
| BED ROOM        | A-420  |
| TOILET          | A-420a |
| BED ROOM        | A-421  |
| TOILET          | A-421a |
| BED ROOM        | A-422  |
| TOILET          | A-422a |

- |          |        |
|----------|--------|
| BED ROOM | A-406  |
| TOILET   | A-406a |
| BED ROOM | A-407  |
| TOILET   | A-407a |
| BED ROOM | A-408  |
| TOILET   | A-408a |
| BED ROOM | A-409  |
| TOILET   | A-409a |
| BED ROOM | A-410  |
| TOILET   | A-410a |
| BED ROOM | A-411  |
| TOILET   | A-411a |
| BED ROOM | A-412  |
| TOILET   | A-412a |
| BED ROOM | A-413  |
| TOILET   | A-413a |
| BED ROOM | A-414  |
| TOILET   | A-414a |
| BED ROOM | A-415  |
| TOILET   | A-415a |
| BED ROOM | A-416  |
| TOILET   | A-416a |
| BED ROOM | A-417  |
| TOILET   | A-417a |
| BED ROOM | A-418  |
| TOILET   | A-418a |
| BED ROOM | A-419  |
| TOILET   | A-419a |
| BED ROOM | A-420  |
| TOILET   | A-420a |
| BED ROOM | A-421  |
| TOILET   | A-421a |
| BED ROOM | A-422  |
| TOILET   | A-422a |

- |          |        |
|----------|--------|
| BED ROOM | A-467  |
| TOILET   | A-467a |
| BED ROOM | A-468  |
| TOILET   | A-468a |
| BED ROOM | A-469  |
| TOILET   | A-469a |
| BED ROOM | A-470  |
| TOILET   | A-470a |
| BED ROOM | A-471  |
| TOILET   | A-471a |
| BED ROOM | A-472  |
| TOILET   | A-472a |
| BED ROOM | A-473  |
| TOILET   | A-473a |
| BED ROOM | A-474  |
| TOILET   | A-474a |
| BED ROOM | A-475  |
| TOILET   | A-475a |
| BED ROOM | A-476  |
| TOILET   | A-476a |
| BED ROOM | A-477  |
| TOILET   | A-477a |
| BED ROOM | A-478  |
| TOILET   | A-478a |
| BED ROOM | A-479  |
| TOILET   | A-479a |
| BED ROOM | A-480  |
| TOILET   | A-480a |
| BED ROOM | A-481  |
| TOILET   | A-481a |
| BED ROOM | A-482  |
| TOILET   | A-482a |
| BED ROOM | A-483  |
| TOILET   | A-483a |
| BED ROOM | A-484  |
| TOILET   | A-484a |
| BED ROOM | A-485  |
| TOILET   | A-485a |
| BED ROOM | A-486  |
| TOILET   | A-486a |
| BED ROOM | A-487  |
| TOILET   | A-487a |
| BED ROOM | A-488  |
| TOILET   | A-488a |
| BED ROOM | A-489  |
| TOILET   | A-489a |
| BED ROOM | A-490  |
| TOILET   | A-490a |
| BED ROOM | A-491  |
| TOILET   | A-491a |
| BED ROOM | A-492  |
| TOILET   | A-492a |

MECHANICAL PLAN  
BLDG. 1, FOURTH FLOOR PLAN, UNIT 'A'

AIR CONDITIONING SYSTEM,  
ADMITTING & OUTPATIENT CLINIC,  
REMODEL AUDITORIUM.

V.A.H. - INDIANAPOLIS  
(MIS & C.R. DIVISION), INDIANA

Drawn By: J.E. H. Date: 2/1/77  
Checked: J.E. H. Date: 2/1/77

LONGARMER & ASSOCIATES, INC.  
3015 WASHINGTON BOULEVARD  
INDIANAPOLIS, INDIANA 46206  
317-228-4874

APPROVED, PROJECT DIRECTOR  
J.E. H.

DRAWING NUMBER  
1-111A

Sheet No. 102 of 108  
Project No. 583-010

RETURN TO PLAN LIBRARY

FILE FOLDER NO. 2C

AS BUILT