


KEYED NOTES	
1	PROVIDE A COMPLETE AND COORDINATED LADDER RACK MANAGEMENT SYSTEM IN ALL DATA CLOSETS.
2	PERFORM A COMPLETE TEST FOR SYNC LIGHT CONNECTIVITY ON ALL PORTS NOT RECERTIFIED WITHIN THE EXISTING HOSPITAL AND PROVIDE A COMPLETE AND COMPREHENSIVE REPORT.
3	REPLACE ANY EXISTING CAT3 INFRASTRUCTURE WITH CAT6.
4	PROVIDE A COMPLETE STANDARDIZATION OF ALL WIRE CONFIGURATIONS TO 568B STANDARD AND RECERTIFY AFTER IMPLEMENTATION OF STANDARDIZATION.
5	PROVIDE A COMPLETE REPLACEMENT OF ALL EXISTING CLOSET PATCH PANELS WITH LEVITON CAT6 EXTREME 6+ 2U 48 QUICKPORT PANELS OR EQUAL.
6	PROVIDE A COMPLETE RE-LABELING OF ALL NEW CERTIFICATIONS WITH THE NEW VA STANDARD LISTED AS FOLLOWS: PATCH PANEL - LABELED WITH ROOM NUMBER WALL JACK - LABELED WITH SWITCH ROOM NUMBER (EX. A101)/PATCH PANEL POSITION (EX. P01-01)
7	PROVIDE A COMPLETE TRANSFER OF EXISTING PATCH PANEL LABELS TO NEW PATCH PANELS AFTER INSTALLATION AS SPECIFIED IN TASK 5 ABOVE. FOR ALL NON-RECERTIFICATION'S 1 U PATCH PANEL HORIZONTAL ORGANIZERS SHALL BE PLACED AFTER EVERY 92 PORTS. HORIZONTAL ORGANIZERS SHALL BE PANDUIT PATCHLINK™ 1U CABLE MANAGERS WITH COVERS OR EQUAL. VERTICAL ORGANIZERS SHALL BE PANDUIT PATCHRUNNER™ VERTICAL CABLE MANAGERS WITH DOORS OR EQUAL.
8	PROVIDE A COMPLETE RE-CONFIGURATION OF CLOSET SWITCHES TO BE MOUNTED MID-RACK. PATCH PANELS SHALL GO NO FURTHER DOWN THE RACK THAN 8 U'S AND ASSURING THAT 3 U'S SHALL BE LEFT EMPTY ON TOP OF PATCH PANEL.
9	PROVIDE A COMPLETE REPLACEMENT OF PATCH CABLES WITH NEW CAT 6 PATCH CABLES FOLLOWING BELOW COLOR CONFIGURATION:  VIDEO VLAN - WHITE MEDICAL VLAN - RED PC VLAN ORANGE PRINTER VLAN YELLOW ALL OTHER VLANS - BL
10	PEFORM ALL TASKS IN NOTES 1-9 IN THE FOLLOWING COMMUNICATION CLOSETS: A501

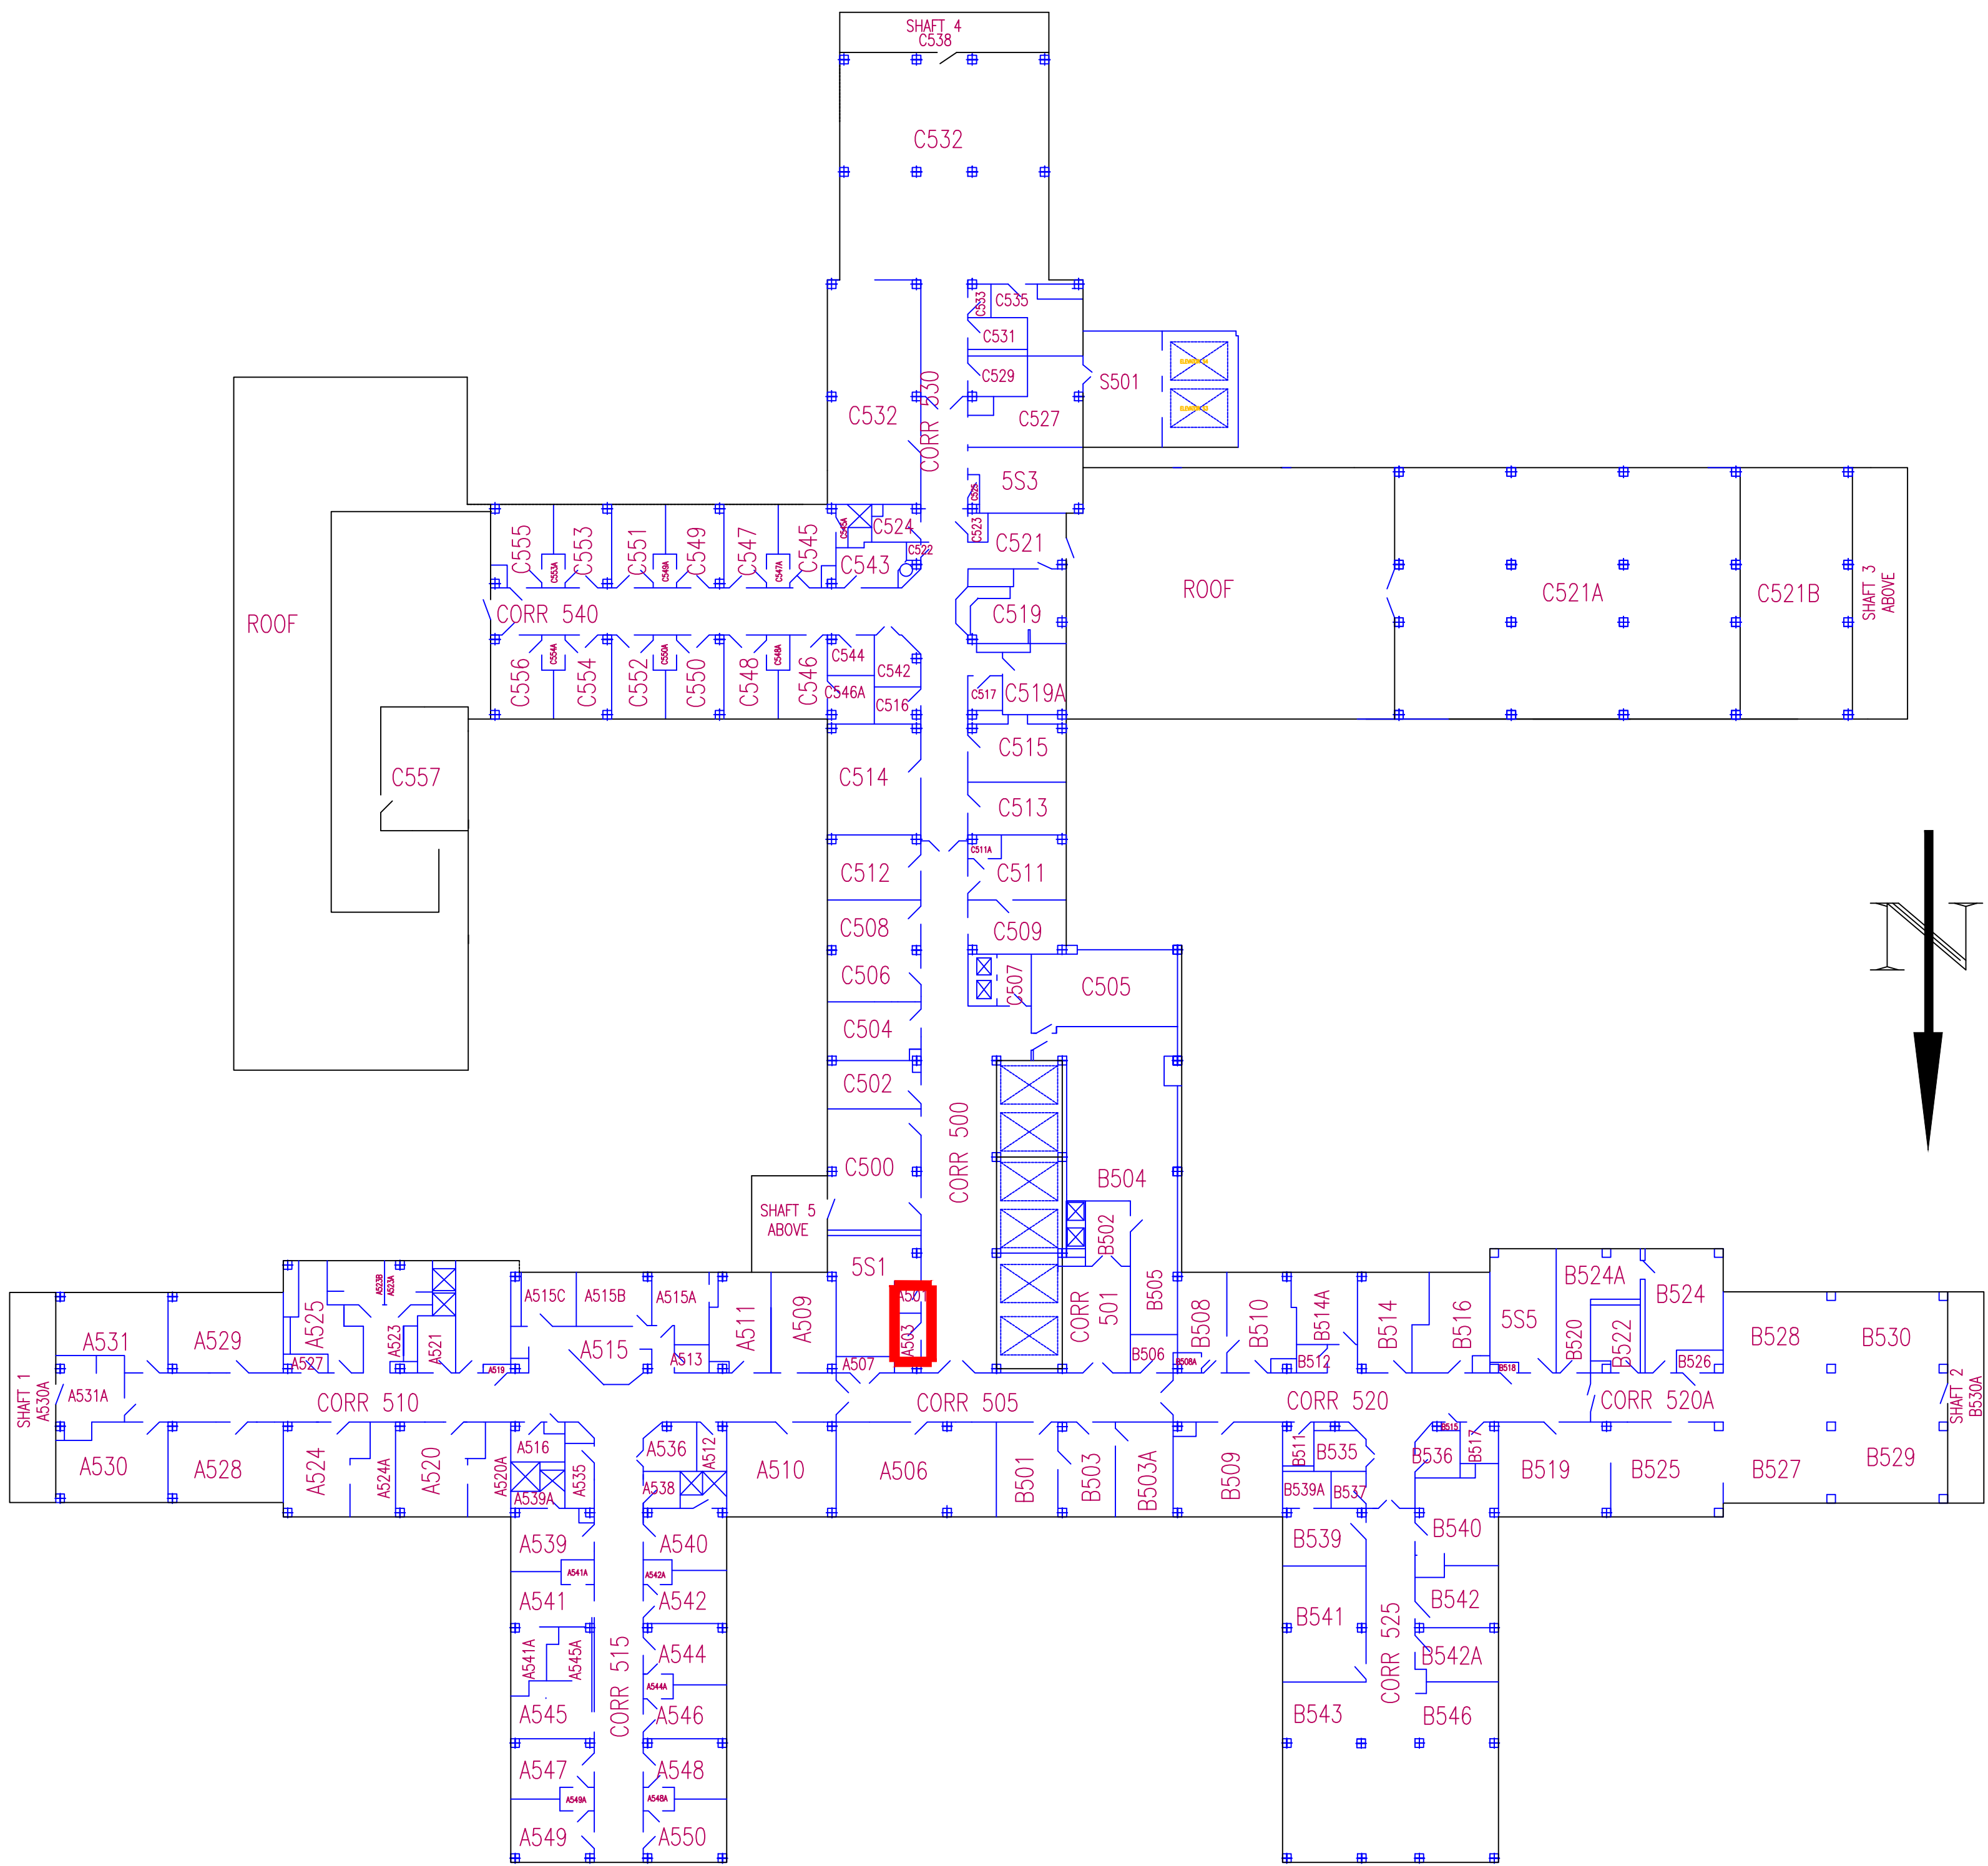


revised 2/11

# FIFTH FLOOR PLAN

- GENERAL NOTES
- WHERE THE WORDS "PROVIDE", "NEW" OR "INSTALL" APPEAR IN THE DRAWINGS OR SPECIFICATIONS, THE CONTRACTOR SHALL FURNISH AND INSTALL THAT PORTION OF THE TOTAL PROJECT.
  - ANY DIMENSIONS, MEASUREMENTS OR SCALES NOTED ON THESE DRAWINGS ARE FOR GUIDANCE INFORMATIONAL PURPOSES ONLY. THE CONTRACTOR SHALL FIELD VERIFY ALL MEASUREMENTS AND CONDITIONS.
  - THE CONTRACTOR SHALL PROTECT ALL VA PROPERTY FROM DUST AND DAMAGE AT ALL TIMES. ANY RESULTING DAMAGE TO VA PROPERTY, WILL BE IMMEDIATELY CORRECTED BY THE CONTRACTOR AT THEIR EXPENSE.
  - BASEMENT & GROUND FLOOR OPERATIONS, OFFICES AND PATIENT WARDS WILL REMAIN OPERATIONAL.
  - THIS PROJECT REQUIRES NEGATIVE AIR DUST AND DEBRIS CONTAINMENT ENCLOSURES. ALL VA SERVICES MUST BE ABLE TO CONDUCT BUSINESS, UNOBSERVED, ON A DAILY BASIS.
  - THE CONTRACTOR SHALL PROVIDE ALL REQUIRED INFESTION CONTROL MEASURES DURING SELECTIVE DEMOLITION AND OTHER TRADE APPLICATIONS AS NOTED IN SPECIFICATION SECTION 01 00 00 "GENERAL REQUIREMENTS" & SECTION 01 00 00 "INFESTION CONTROL". ALL TEMPORARY ENCLOSURES SHALL BE CONSTRUCTED OF PROPERLY SUPPORTED, 6 MIL FIRE-RESISTIVE POLYETHYLENE. THE TEMPORARY PARTITIONS SHALL BE SMOKE TIGHT & SEALED TO THE WALLS, FLOOR AND CEILING TILE. WITHIN A PHASED AREA, ALL ROOM DOORS ARE TO BE SEALED OFF FROM THE WORK AREA DURING ALL DUST PRODUCING ACTIVITIES. LOCAL SMOKE DETECTORS SHALL BE COVERED AT THE BEGINNING OF EACH WORK SHIFT AND REMOVED AT THE END OF EACH WORK SHIFT. STICKY MATS ARE TO BE USED IN CONJUNCTION WITH ALL DUST ENCLOSURES.
  - ALL ADHESIVES USED AS A RESULT OF ENCLOSURES, HEPA DUCT EXHAUSTS AND/OR NORMAL ROUTINE CONSTRUCTION, MUST BE COMPLETELY REMOVED FROM FINISHED SURFACES.
  - NEGATIVE AIR HEPA UNITS SHALL BE LOCATED AS REQUIRED BY THE CONTRACT SPECIFICATIONS. HEPA EXHAUST DUCTS SHALL EXHAUST OUTSIDE THE CONSTRUCTION AREA. WHEN USING WINDOW OPENINGS, SECURELY ATTACH HEPA EXHAUST DUCTS TO WEATHER PROOF TEMPORARY PLYWOOD INSERTS AT THE WINDOW.
  - EXISTING FIRE ALARM DEVICES, PHONES AND FLUSH MOUNTED CONTROLS ARE TO REMAIN UNDISTURBED.
  - UNLESS OTHERWISE NOTED, ALL KITCHEN AREA WALLS ARE TILE FINISH.
  - PROVIDE ALL MATERIALS, EQUIPMENT AND LABOR REQUIRED TO INSTALL COMPLETE AND OPERABLE SYSTEMS AS INDICATED ON THE DRAWINGS, AS SPECIFIED AND AS REQUIRED BY ALL APPLICABLE CODES, REGULATIONS, AND STANDARDS, INCLUDING BUT NOT LIMITED TO BUILDING CODE OF NEW YORK STATE, NFPA, FEDERAL, STATE, COUNTY AND CITY ORDINANCES, CODES, LAWS AND REGULATIONS.
  - PROVIDE DUST "STICKY" MAT AT ALL CONSTRUCTION AREA ENTRANCES CHANGE OFTEN IN ACCORDANCE WITH SPECIFICATIONS AND INDICATE ON DAILY INSPECTION LOGS.
  - REFUSE CONTAINERS WILL BE PERMITTED ON MEDICAL CENTER PROPERTY FOR THIS PROJECT. EXACT LOCATION TO BE DETERMINED & ASSIGNED BY THE CDR.
  - DEBRIS MUST BE REMOVED ONLY FROM THE WORK SITE.
  - HOT WORK SHALL NOT BE PERFORMED UNDER THIS CONTRACT.
  - UNLESS OTHERWISE NOTED, CONTRACTOR WILL ONLY PERFORM WORK ASSOCIATED WITH THIS CONTRACT IN CONSTRUCTION AREAS INDICATED ON DRAWINGS. IF IT BECOMES NECESSARY TO PERFORM WORK OUTSIDE THE INDICATED CONSTRUCTION AREAS INDICATED CONTRACTOR WILL COORDINATE WORK WITH CDR PRIOR TO START.
  - THE GENERAL INTENTION OF THESE DRAWINGS IS TO PROVIDE A REFERENCE AND A GUIDE FOR CLOSET LOCATIONS TO BE UPGRADED; IT IS THE CONTRACTOR'S RESPONSIBILITY TO COORDINATE WITH CDR AND WITH LOCAL IT STAFF TO SUCCESSFULLY PERFORM TASKS INDICATED IN CLOSET.

 CONSTRUCTION ZONE BOUNDARIES

SCALE  
1/16" = 1'-0"

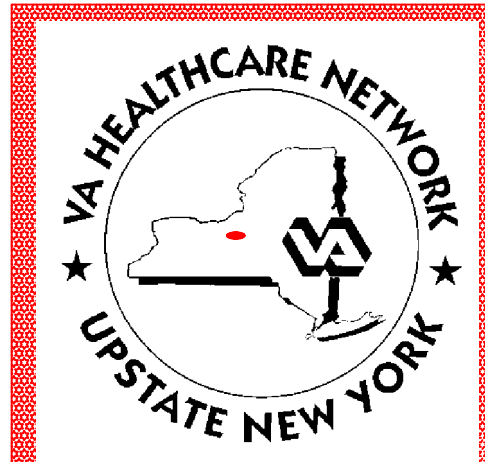								(Company Logo/Information Block)				Drawing Title <b>FIFTH FLOOR PLAN</b>		Project Title UPGRADE FOR COMMUNICATIONS CLOSET RECONFIGURATION AND RESTRUCTURING		Date 05/10/2012							
										Approved: Facility Manager		Building Number 1		Checked CF		Drawn AZH				Project No. 528A7-12-735			
																				DRAWING NO. <b>GS-105</b>			
																				Dwg. 8 Of 11			
Revisions				Date										Location VAMC SYRACUSE, NY									
1	2	3	4	5	6	7	8	9	10	11	12	13	14	15	16	17	18	19	20	21	22	23	24