

INSTALL PERIMETER HEAT & 4-EAST DESIGN

VA PROJECT NUMBER: 585-17-105
OSCAR G. JOHNSON VA MEDICAL CENTER
325 EAST H STREET
IRON MOUNTAIN, MI 49801

SHEET INDEX

GENERAL

1. G001 TITLE SHEET/LOCATION MAP

ARCHITECTURAL


2. A001 FOURTH FLOOR PHASING PLAN
3. A100 SECOND FLOOR PLAN
4. A100.5 SECOND FLOOR PLAN PART B
5. A101 FOURTH FLOOR PLAN - PART A
6. A102 FOURTH FLOOR PLAN - PART B
7. A103 FOURTH FLOOR PLAN - PART C

MECHANICAL

8. M001 MECHANICAL NOTES, SYMBOLS, AND ABBREVIATIONS
9. MPD140 FOURTH FLOOR EAST MECHANICAL PIPING DEMOLITION PLAN
10. MPD160 SIXTH FLOOR EAST MECHANICAL PIPING DEMOLITION PLAN
11. MSD120 SECOND FLOOR EAST MECHANICAL STEAM DEMOLITION PLAN
12. MSD121 SECOND FLOOR EAST MECHANICAL STEAM DEMOLITION PLAN AREA B
13. MP120 SECOND FLOOR EAST MECHANICAL PIPING PLAN
14. MP121 SECOND FLOOR EAST MECHANICAL PIPING PLAN AREA B
15. MP140 FOURTH FLOOR EAST MECHANICAL PIPING PLAN
16. MP160 SIXTH FLOOR EAST MECHANICAL PIPING PLAN
17. M501 MECHANICAL DETAILS
18. M502 MECHANICAL DETAILS
19. M503 MECHANICAL DETAILS
20. M601 MECHANICAL SCHEDULES
21. M602 MECHANICAL SCHEDULES
22. M701 MECHANICAL CONTROL DIAGRAMS
23. M801 HOT WATER PIPING EAST RISER DIAGRAM
24. M802 AHU-10/ERV-2 RISER DIAGRAM

ELECTRICAL

25. E001 ELECTRICAL NOTES, SYMBOLS AND ABBREVIATIONS
26. EP140 FOURTH FLOOR EAST ELECTRICAL PLAN
27. EP160 SIXTH FLOOR EAST ELECTRICAL PLAN

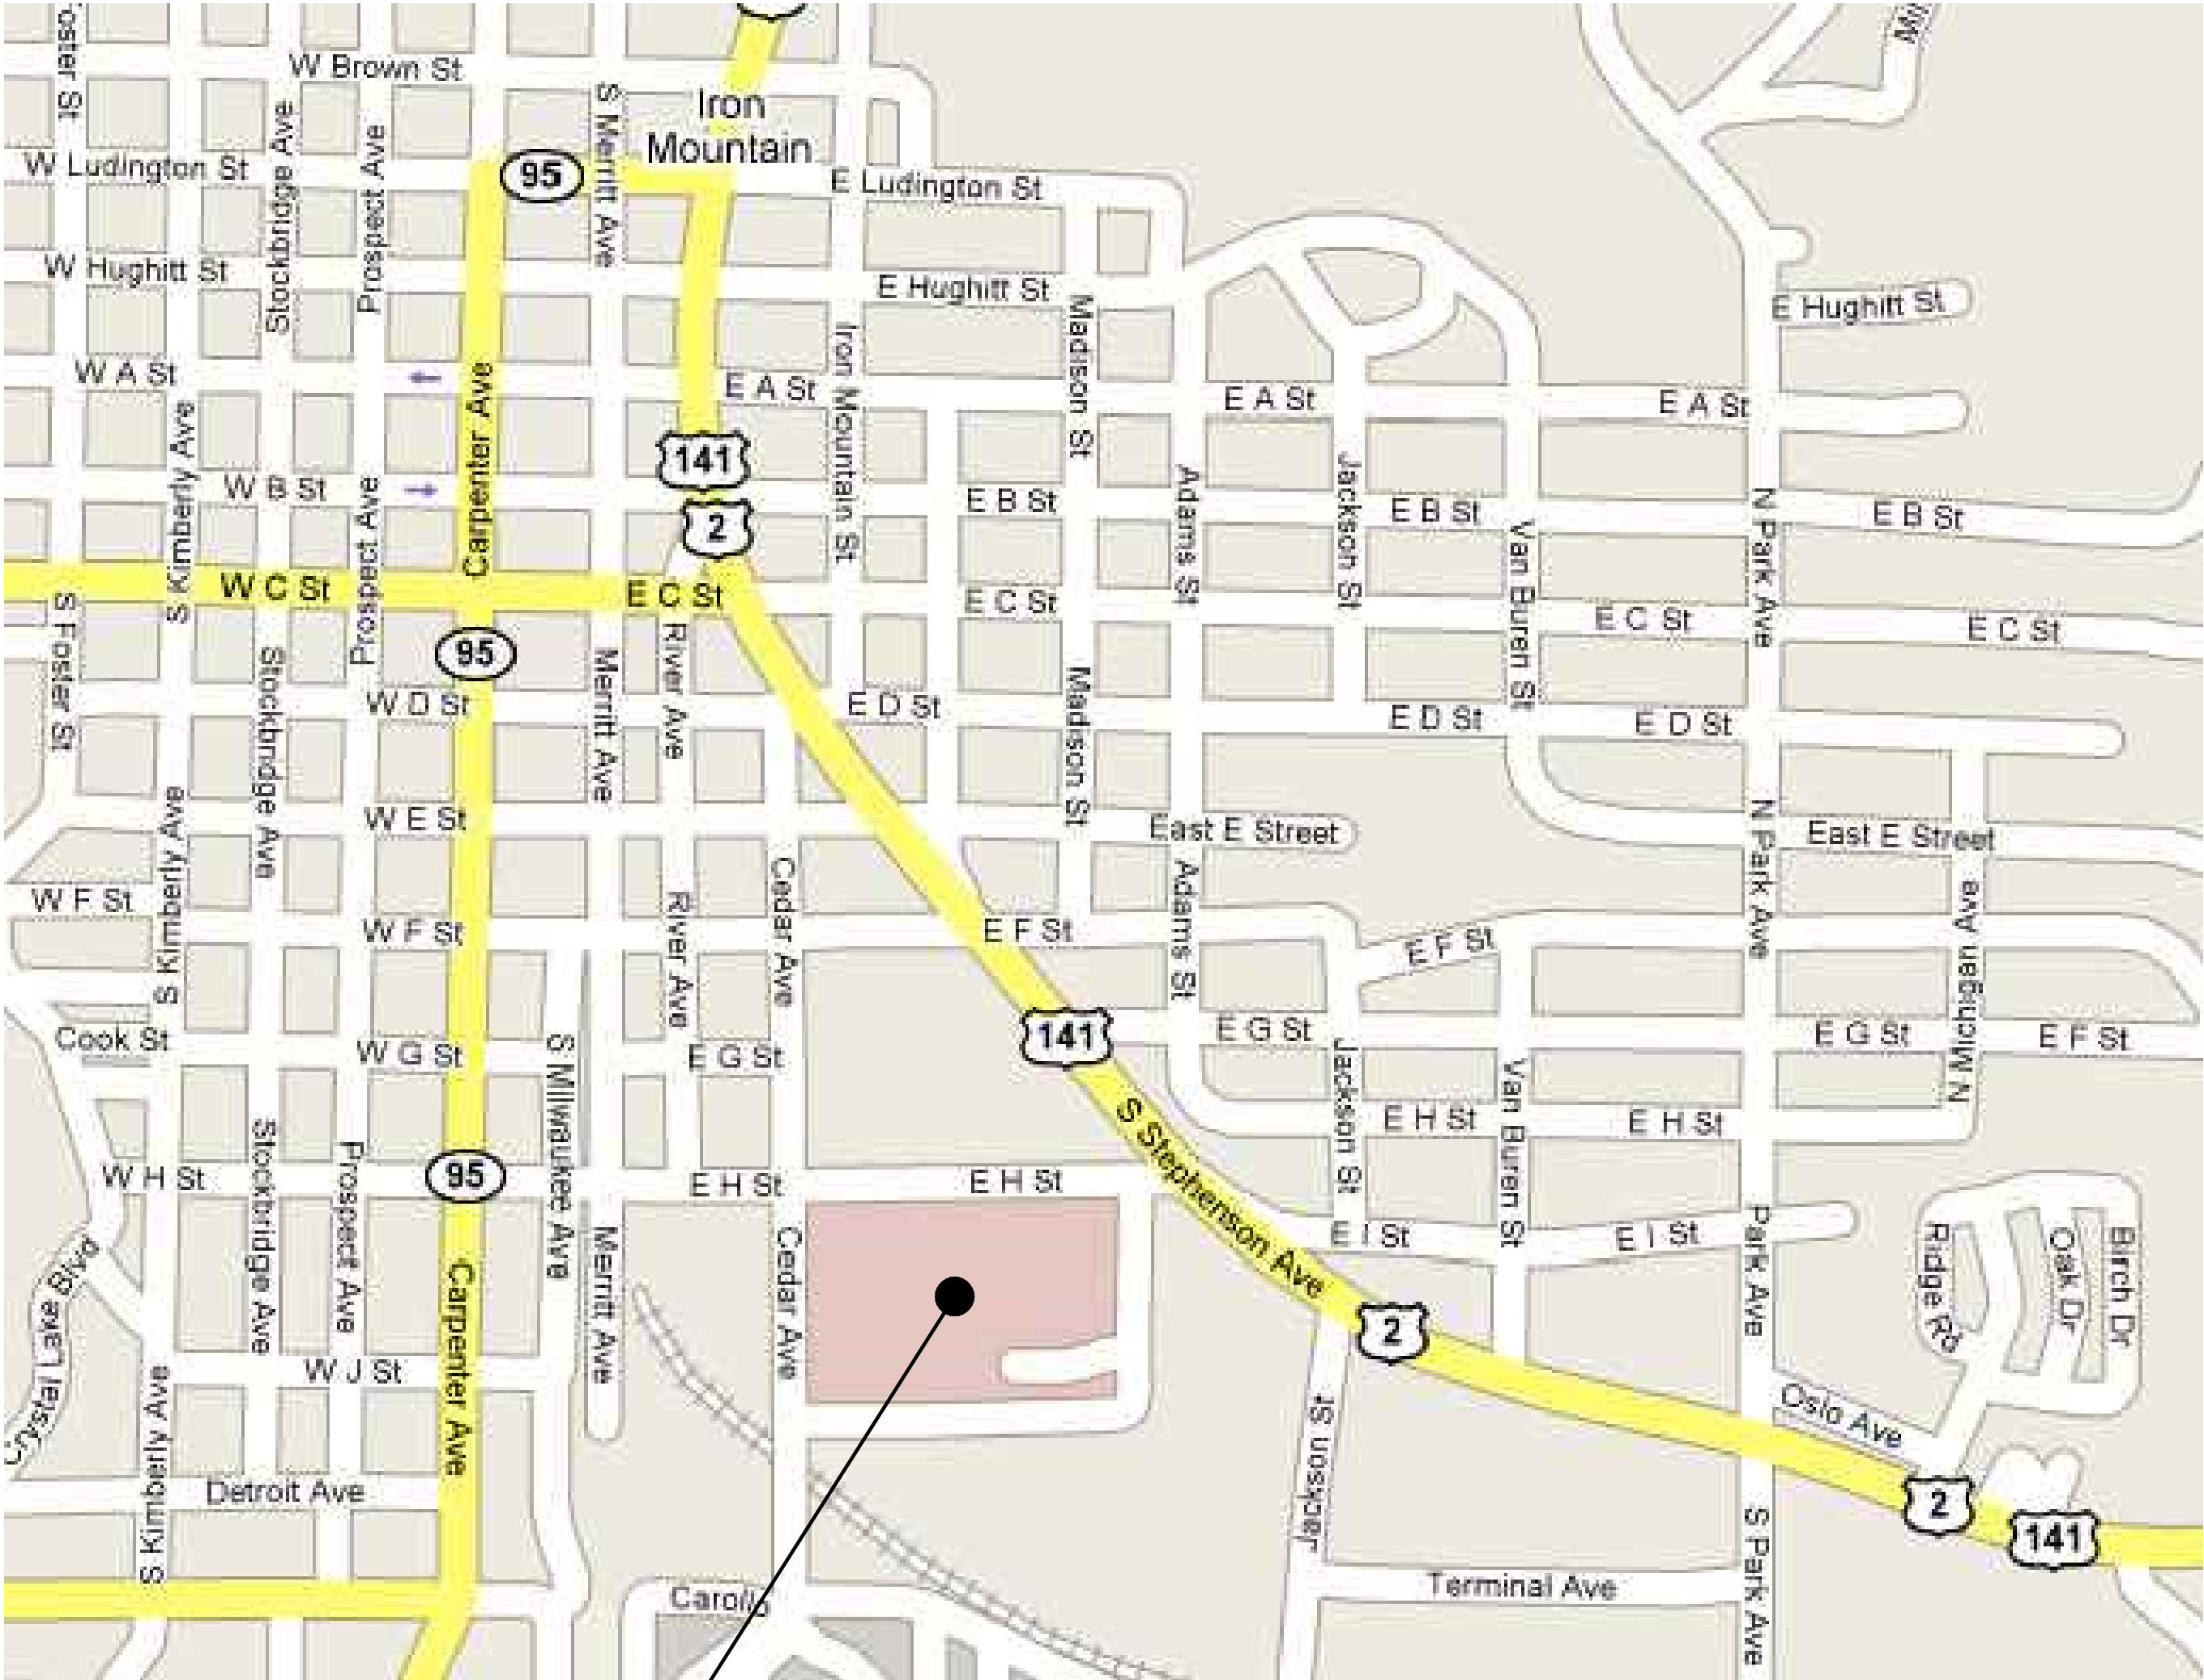

VA MEDICAL CENTER
325 EAST H STREET
IRON MOUNTAIN, MI 49801

1 LOCATION MAP
NOT TO SCALE



Director _____
Associate Director _____
Chief of Staff _____
Associate Director for N&PCS _____
Chief of Police _____
Chief of Engineering _____
Industrial Hygienist _____
Infection Control Nurse _____
A.F.G.E. _____
Patient Safety _____
Safety _____

PREPARED BY:

Electrical, Mechanical, & Plumbing Engineering
MEP Associates, LLC
860 Blue Gentian Road, Suite 175
Eagan, MN 55121
651.379.9120
www.mepassocaites.com



ADDENDUM #1	10/30/2018
BID SET	06/18/2018
100% REVIEW	1/30/2018
SOX REVIEW	12/8/2017
Revisions:	Date:

CONSULTANT

**NORTHERN
DESIGN
WORKS**

420 RAIL STREET
NEGAUNEE, MI 49866
PHONE: 906-475-6616
NDW PROJECT NUMBER: 1718

ARCHITECT/ENGINEER OF RECORD

**MEP
ASSOCIATES, LLC**
engineers | consultants | commissioning
MEP Associates, LLC | 2720 Arbor Court | Eau Claire, WI 54601
Phone: 715.837.5880 | Fax: 715.837.5880 | www.mepassocaites.com
MEP PROJECT NO.: G29.17.04

STAMP

Office of
Construction
and Facilities
Management

VA U.S. Department
of Veterans Affairs

Drawing Title
COVER SHEET

Approved: Project Director

Phase
CONSTRUCTION
DOCUMENTS

FULLY SPRINKLERED

Project Title
INSTALL PERIMETER HEAT TO
IMAGING AND 4-EAST

Location
IRON MOUNTAIN, MICHIGAN

Issue Date
JUNE 18, 2018

Checked
RCA

Drawn
JTG

Project Number
585-17-105
Building Number
No. 1

Drawing Number
G001

Dwg. 1 of 24