

Revisions		Date							Drawing Title		Project Title			Date		
									FLOOR PLAN		CONCEPTUAL PLAN			Project No.		
									Approved: Project Manager		Building Number N/A		Checked	Drawn	Drawing No.	
									Approved: Service Chief		Location		<div>VAMC BEDFORD</div>			

VA Department of Veterans Affairs



HAVERHILL CBOC CONCEPTUAL
N.T.S.

12

- FLOOR FINISH LEGEND
- CARPET TILE

WALK-OFF CARPET TILE


WELDED SHEET VINYL

LUXURY VINYL TILE

RUBBER TILE

CERAMIC TILE


SEALED CONCRETE

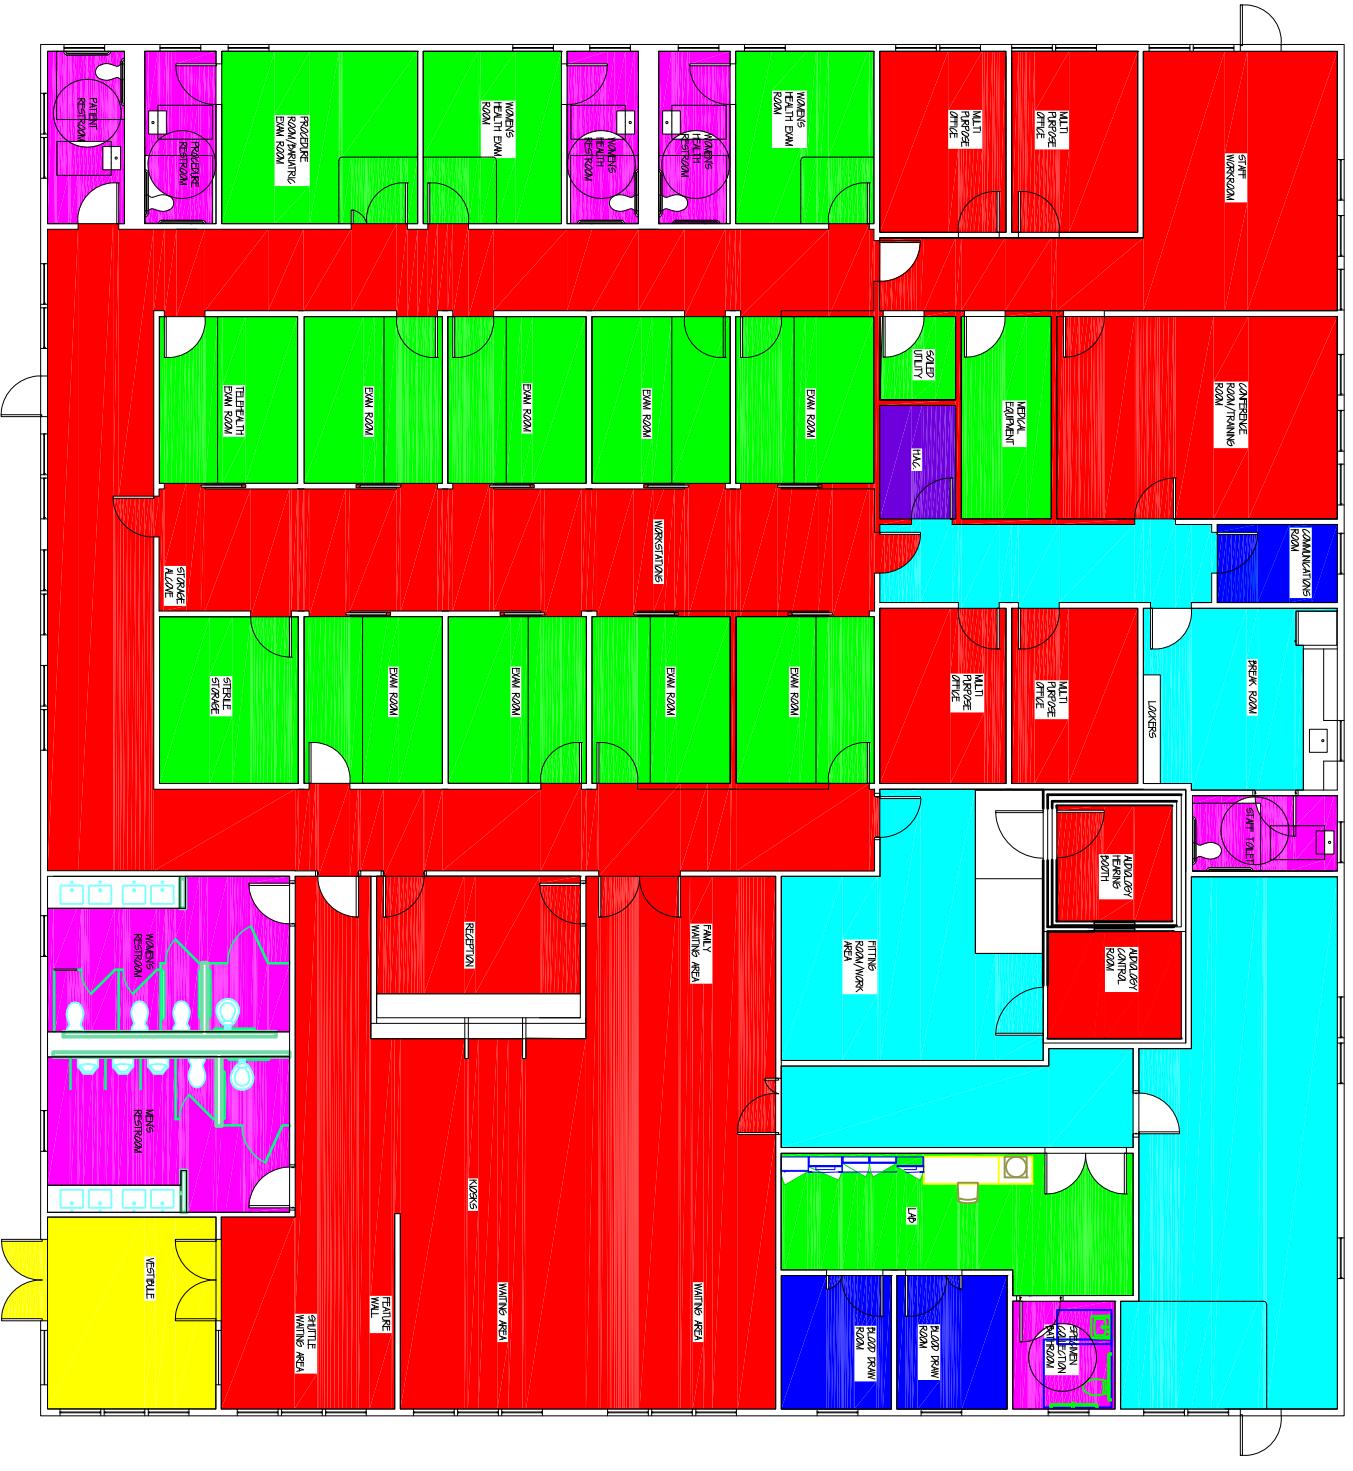

HAVERHILL CBOC CONCEPTUAL

N.T.S.

Revisions	Date	Drawing Title		Project Title		Date	
		FINISH PLAN		CONCEPTUAL PLAN		Project No.	
		Approved: Project Manager		Building Number N/A		Checked	Drawn
		Approved: Service Chief		Location		Drawing No.	
		Professional Seal				VAMC BEDFORD	
						VA Department of Veterans Affairs	

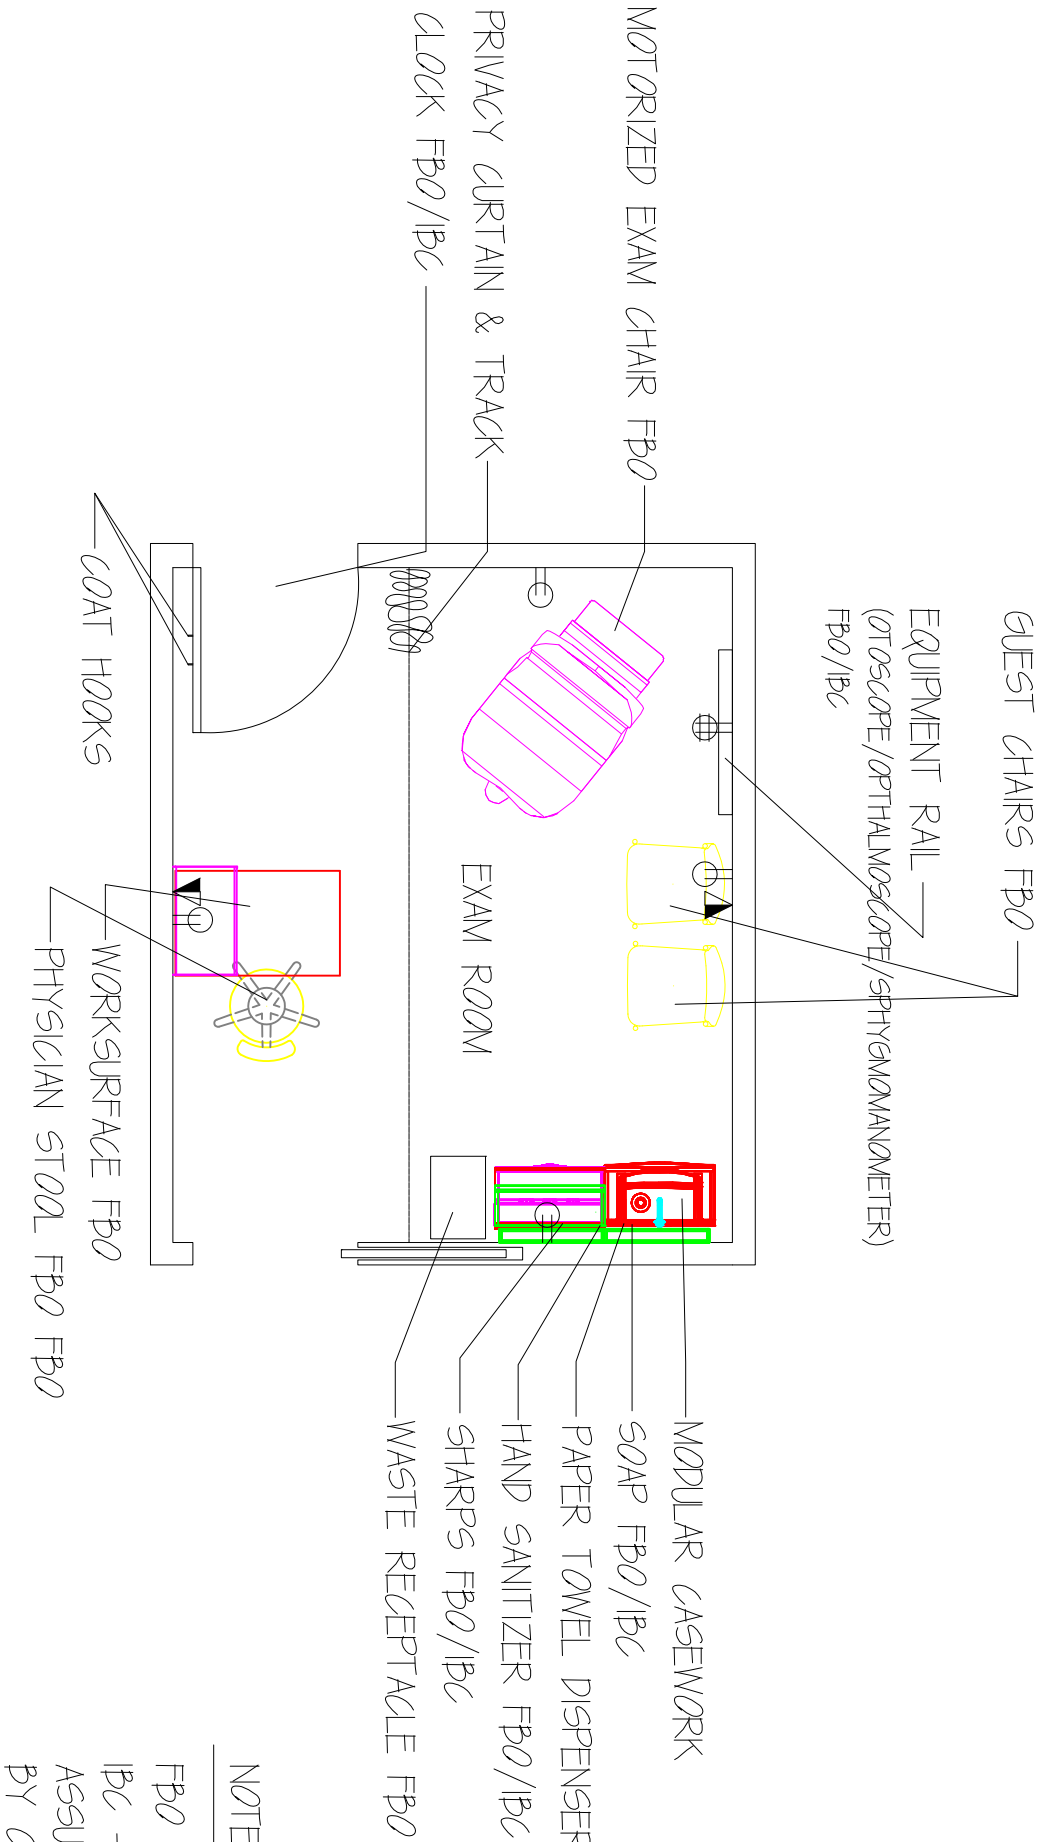

NOTES:


FBO – FURNISHED BY OWNER
IBC – INSTALLED BY CONTRACTOR
ASSUME PROVIDED & INSTALLED
BY CONTRACTOR IF NO LABEL

TYPICAL EXAM ROOM LAYOUT
N.T.S.

HAVERHILL CBOC CONCEPTUAL
N.T.S.



Revisions		Date						Drawing Title		Project Title		Date	
								TYPICAL EXAM LAYOUT		CONCEPTUAL PLAN		Project No.	
								Approved: Project Manager		Building Number N/A		Checked JCW	
								Approved: Service Chief		Location		Drawing No.	

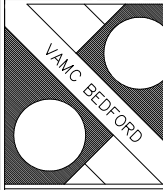

VA
Department of
Veterans Affairs