


- PLUMBING GENERAL NOTES**
- 1 REFER TO P-001 FOR PLUMBING ABBREVIATIONS AND SYMBOLS.**
 - 2 REFER TO P-501 THROUGH P-502 FOR PLUMBING DETAILS.**
 - 3 REFER TO P-701 FOR PLUMBING SCHEDULES.**
 - 4 REFER TO P-901 THROUGH P-902 FOR PLUMBING RISER DIAGRAMS.**

[illegible]

ARCHITECT:

C.C. HODGSON
ARCHITECTURAL GROUP LLC

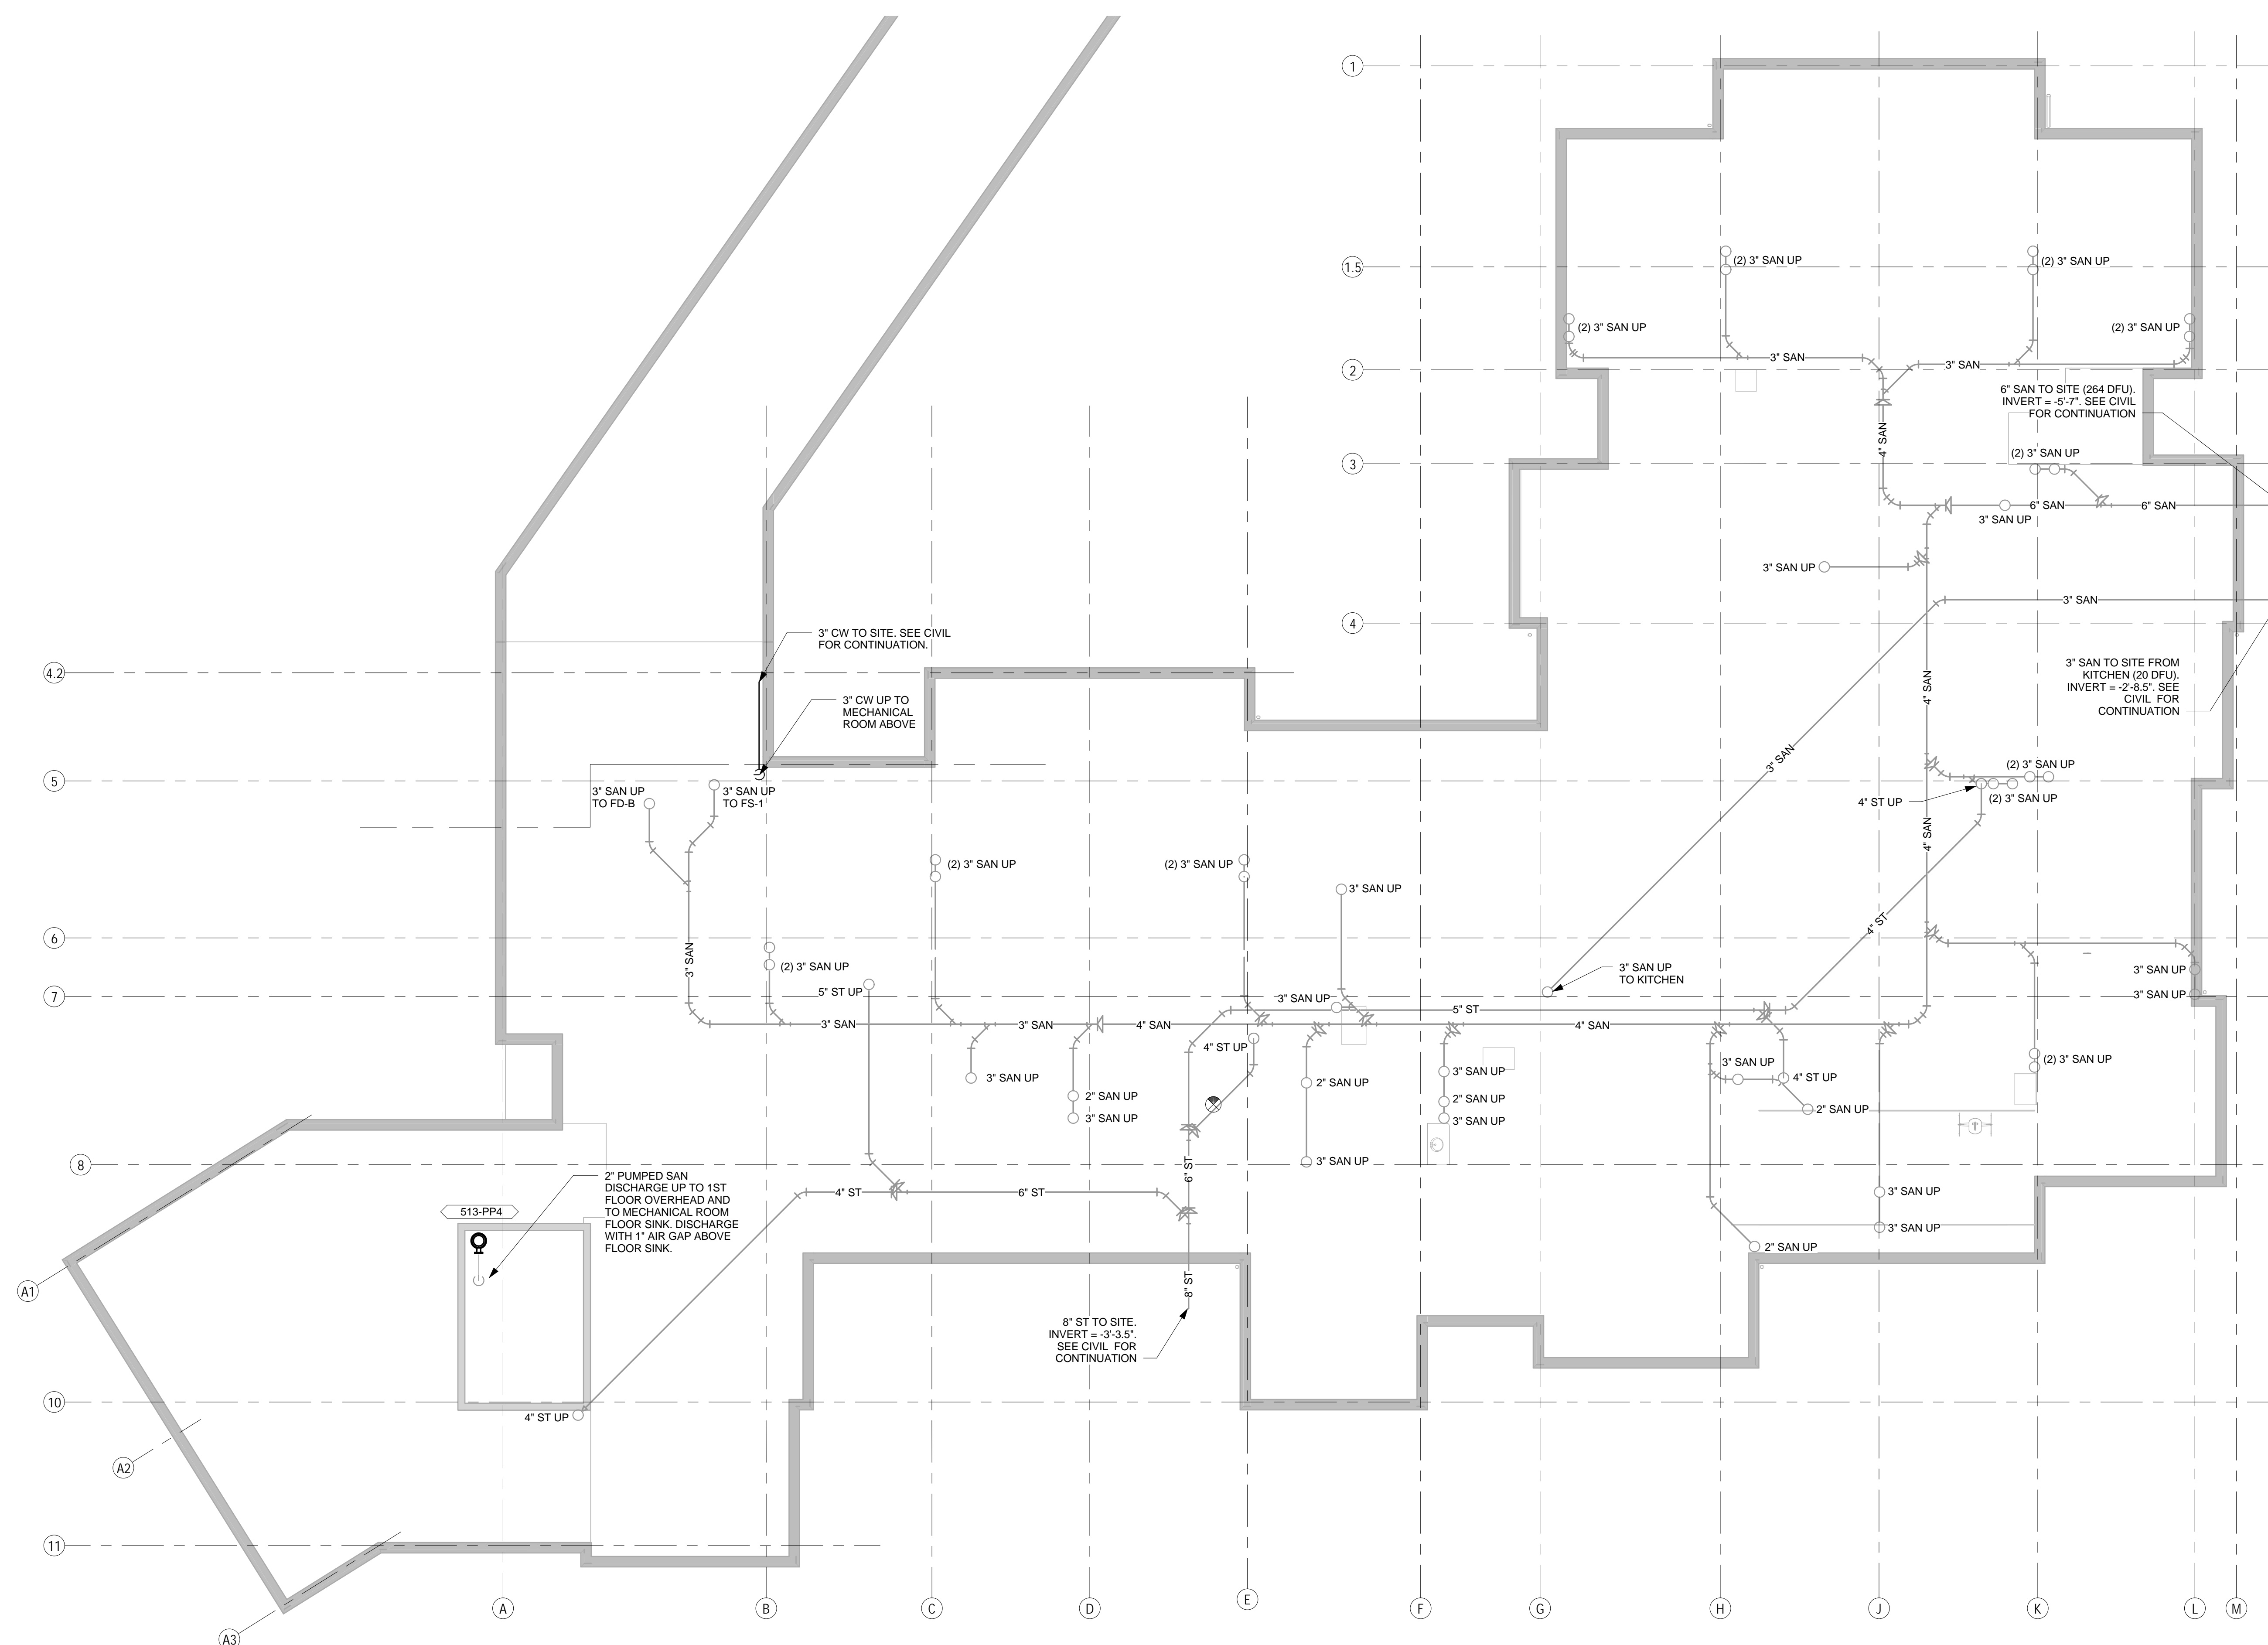

ENGINEERS:

Westlake
Reed
Leskosky

1634 EYE ST, NW, STE 900
WASHINGTON, DC 20006

Drawing Title	PLUMBING NEW WORK UNDERSLAB LEVEL
---------------	-----------------------------------

Approved: Project Director

Project Title	RELOCATE DEMENTIA UNIT
---------------	------------------------

Project Number	
----------------	--

Building Number
513

Drawing Number

P-100

Days of =

Office of
Construction
and Facilities
Management

