


- PLUMBING GENERAL NOTES
- 1 REFER TO P-001 FOR PLUMBING ABBREVIATIONS AND SYMBOLS.
 - 2 REFER TO P-501 THROUGH P-502 FOR PLUMBING DETAILS.
 - 3 REFER TO P-701 FOR PLUMBING SCHEDULES.
 - 4 REFER TO P-901 THROUGH P-902 FOR PLUMBING RISER DIAGRAMS.

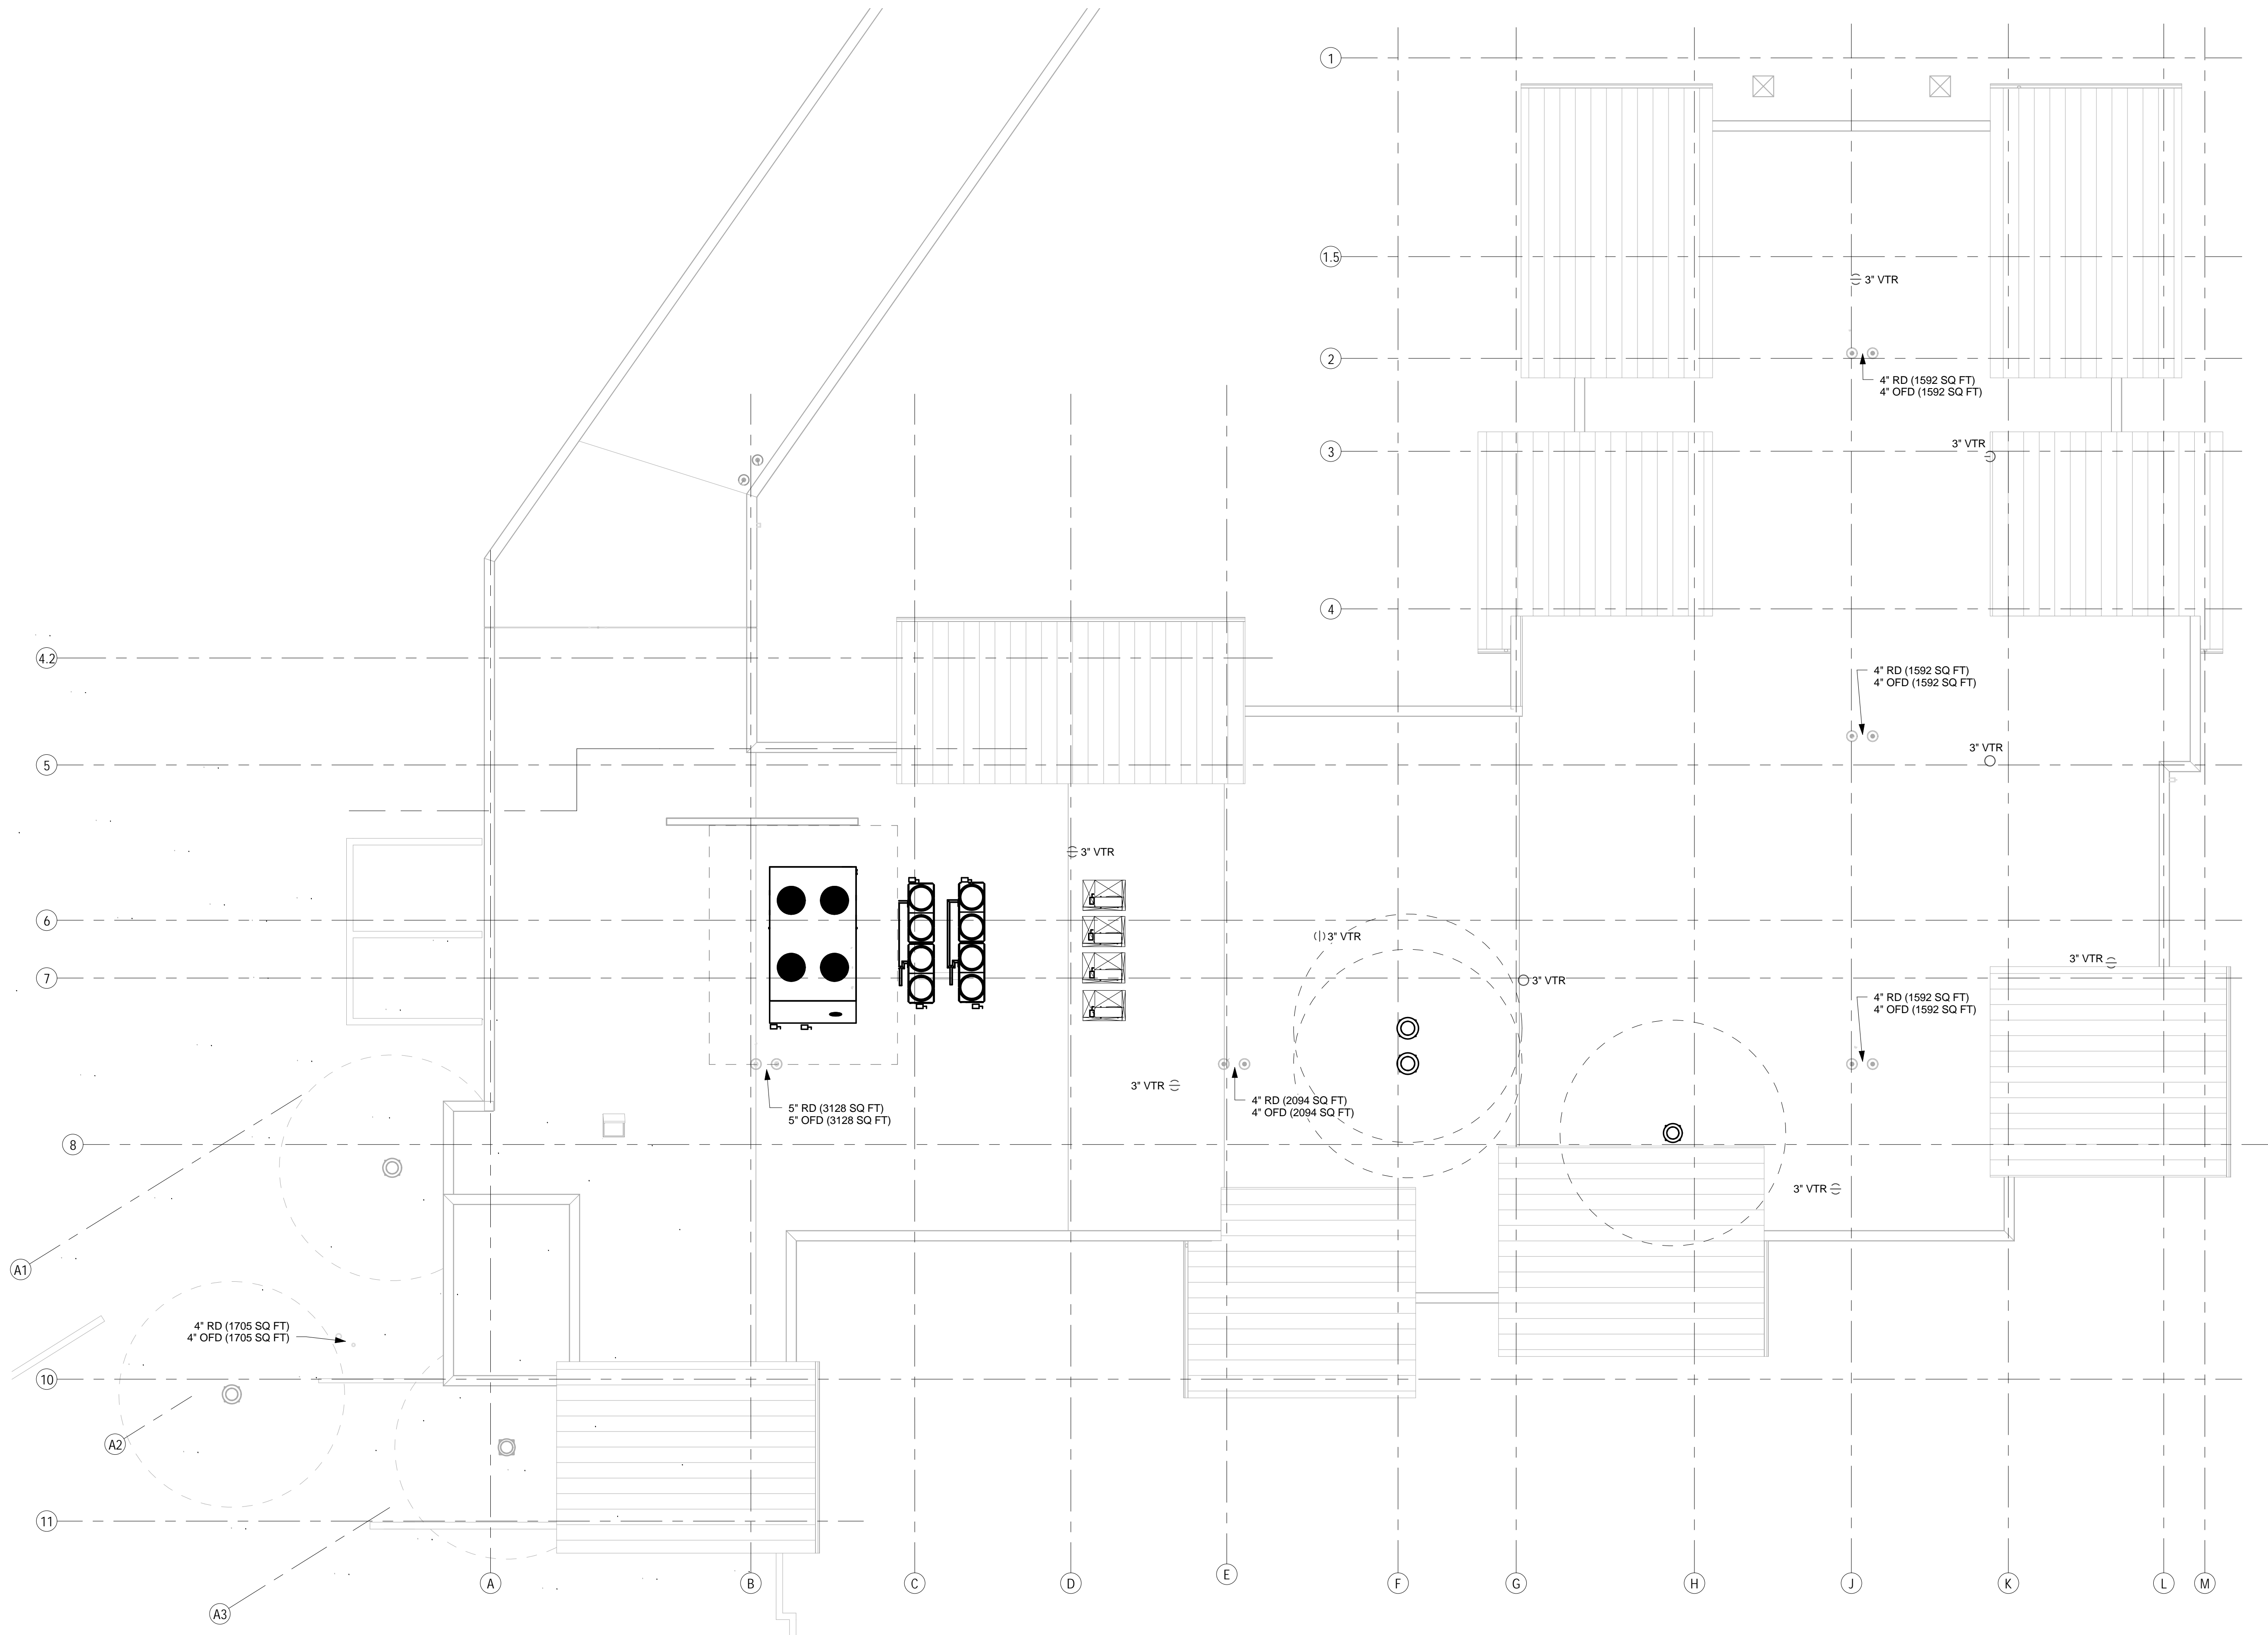

| | |
|------------|------|
| | |
| | |
| | |
| | |
| | |
| | |
| | |
| Revisions: | Date |

ARCHITECT:

C.C. HODGSON
ARCHITECTURAL GROUP



ENGINEERS:

**Westlake
Reed
Leskosky**

1634 EYE ST, NW, STE 900
WASHINGTON, DC 20006

Drawing Title

PLUMBING NEW WORK SANITARY ROOF LEVEL

Approved: Project Director

Project Title

RELOCATE DEMENTIA UNIT

Location

VAMC MARTINSBURG

Date

08/06/2012

Checked

SCS

Drawn

CJW

Project Number

VA PN 613-207

Building Number

513

Drawing Number

P-104

Dwg. of --

Office of
Construction
and Facilities
Management

Department of
Veterans Affairs