


- PLUMBING GENERAL NOTES
- 1 REFER TO P-001 FOR PLUMBING ABBREVIATIONS AND SYMBOLS.
 - 2 REFER TO P-501 THROUGH P-502 FOR PLUMBING DETAILS.
 - 3 REFER TO P-701 FOR PLUMBING SCHEDULES.
 - 4 REFER TO P-901 THROUGH P-902 FOR PLUMBING RISER DIAGRAMS.

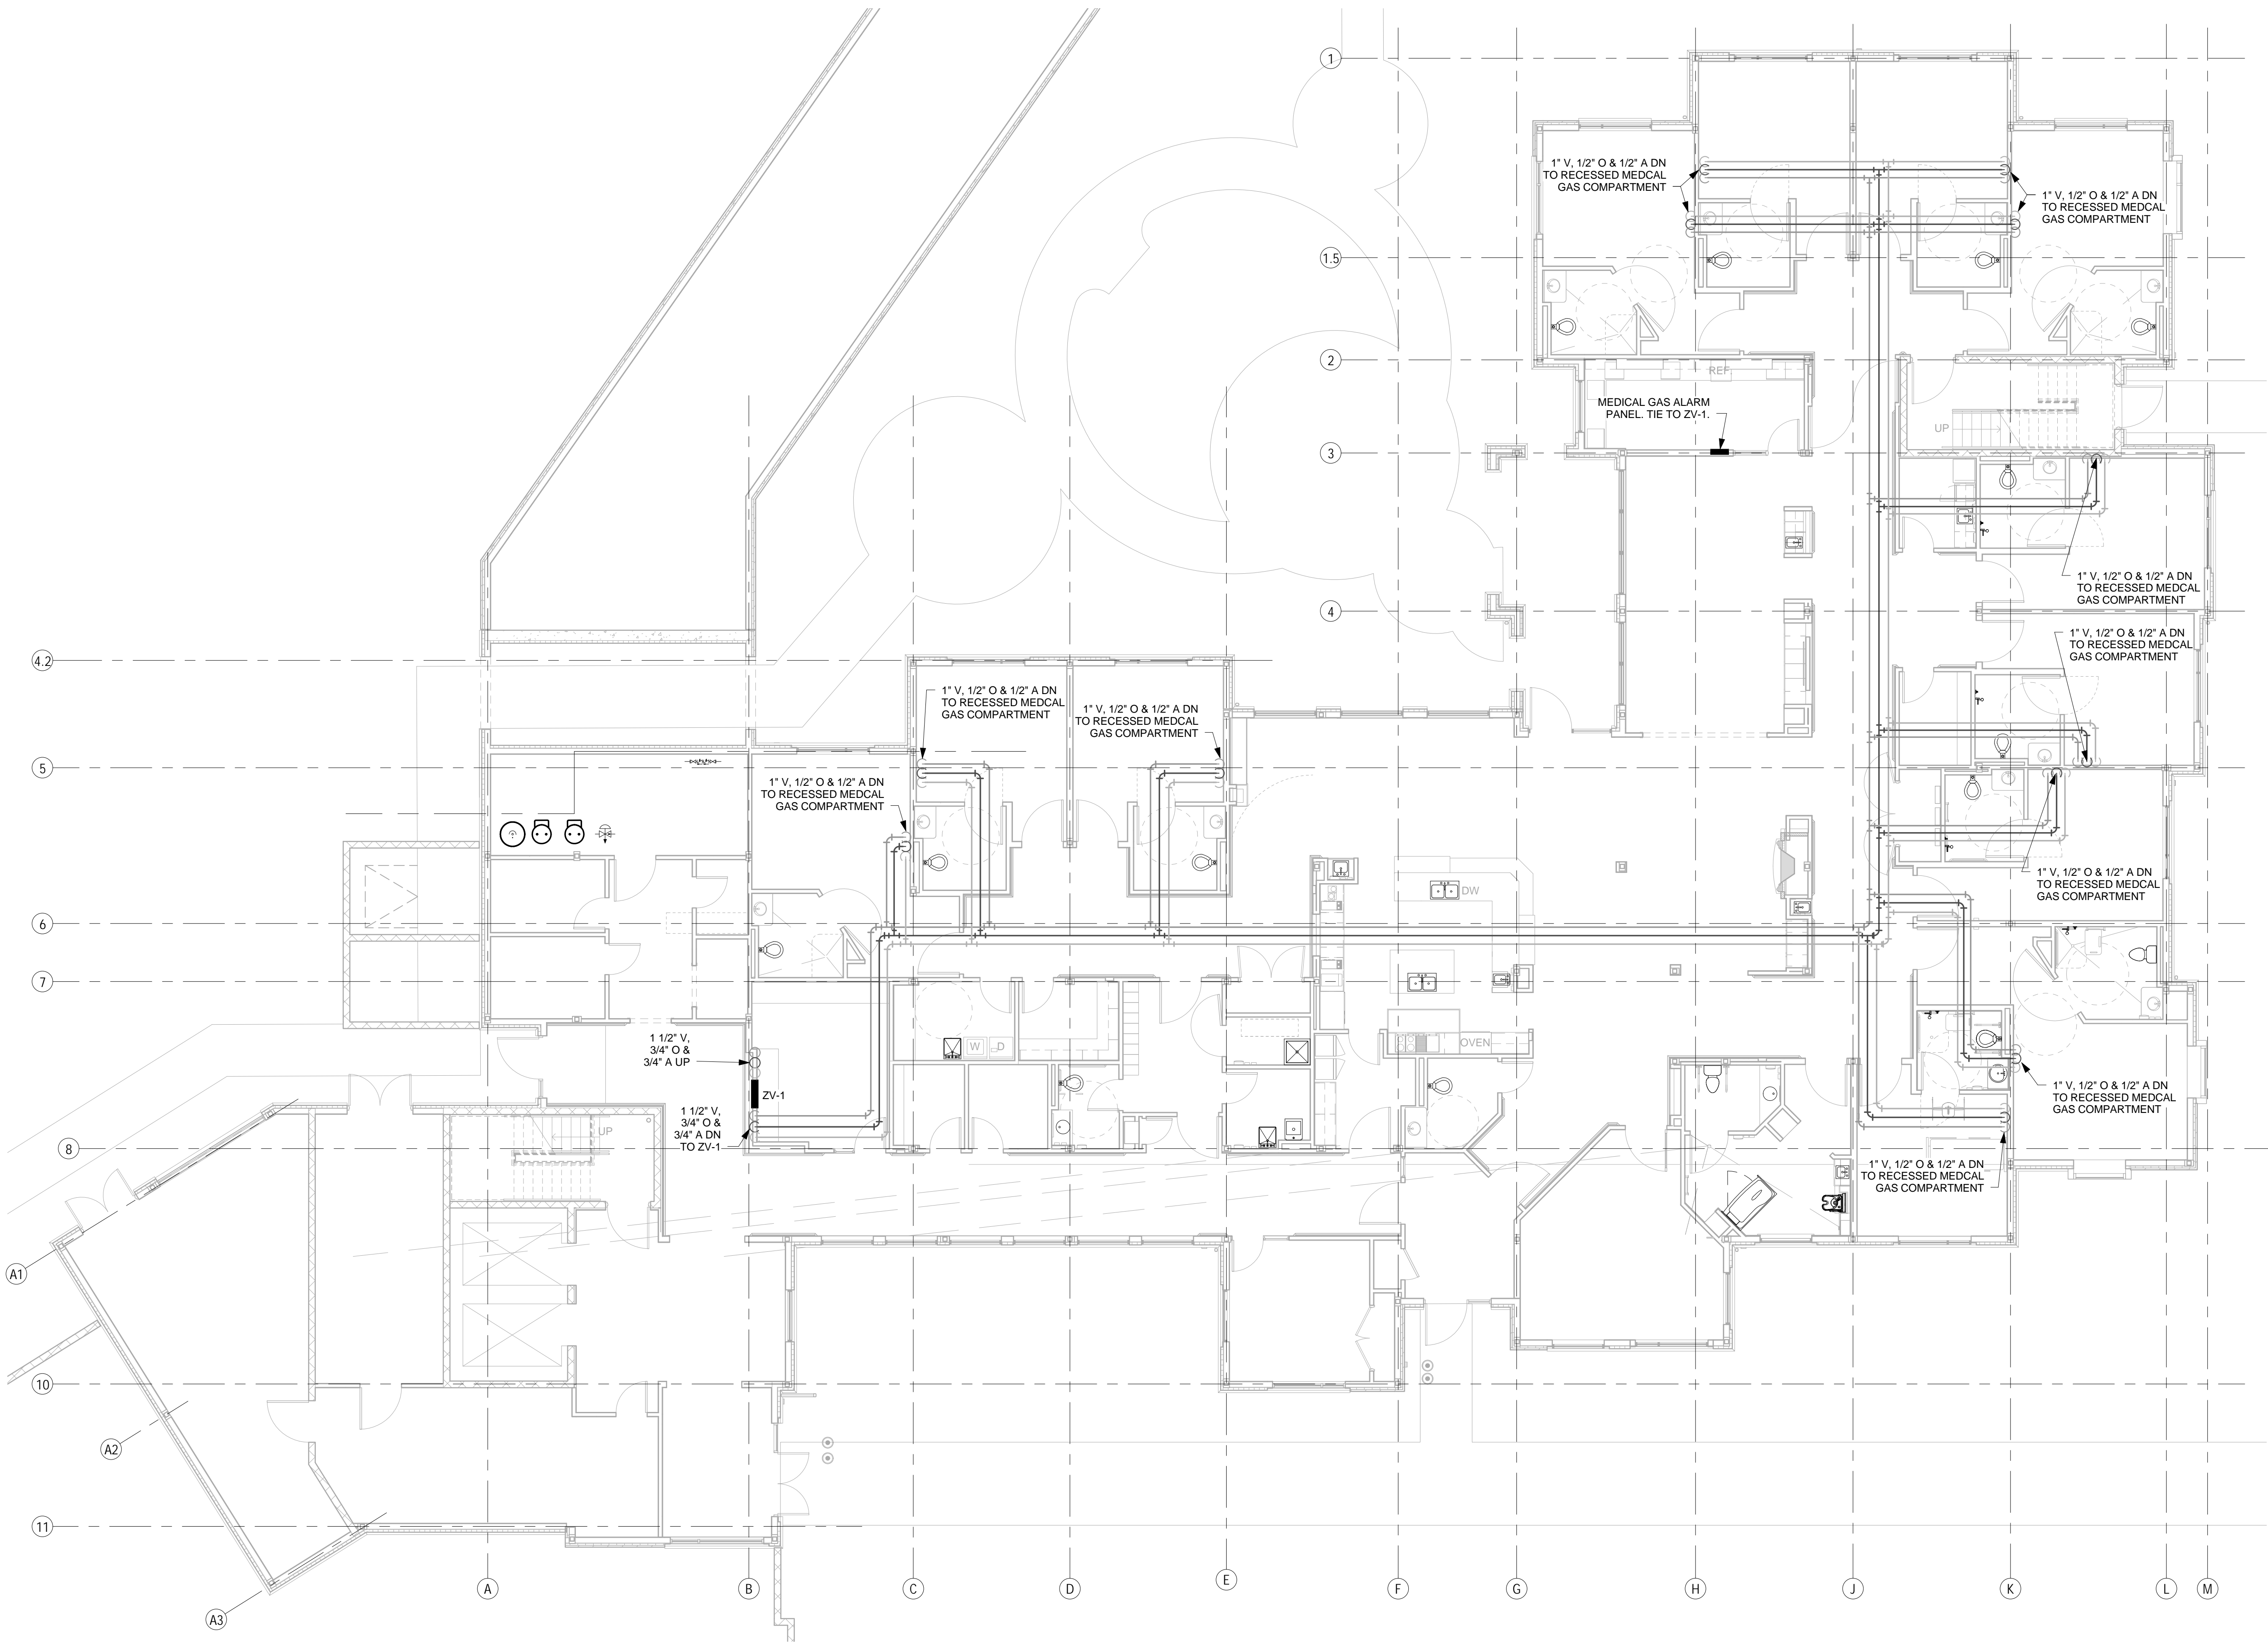

1 1ST FLOOR MEDICAL GAS PLAN
1/8" = 1'-0"

Revisions:	Date

ARCHITECT:

C.C. HODGSON
ARCHITECTURAL GROUP



ENGINEERS:

Westlake
Reed
Leskosky

1634 EYE ST, NW, STE 900
WASHINGTON, DC 20006

Drawing Title
PLUMBING NEW WORK MEDICAL GAS FIRST FLOOR PLAN
Approved: Project Director

Project Title		Project Number
RELOCATE DEMENTIA UNIT		VA PN 613-207
Location		Building Number
VAMC MARTINSBURG		513
Date	Checked	Drawn
08/06/2012	SCS	CJW
Drawing Number		Dwg. of --
P-301		
Office of Construction and Facilities Management Department of Veterans Affairs		