


- PLUMBING GENERAL NOTES
- 1 REFER TO P-001 FOR PLUMBING ABBREVIATIONS AND SYMBOLS.
  - 2 REFER TO P-501 THROUGH P-502 FOR PLUMBING DETAILS.
  - 3 REFER TO P-701 FOR PLUMBING SCHEDULES.
  - 4 REFER TO P-901 THROUGH P-902 FOR PLUMBING RISER DIAGRAMS.

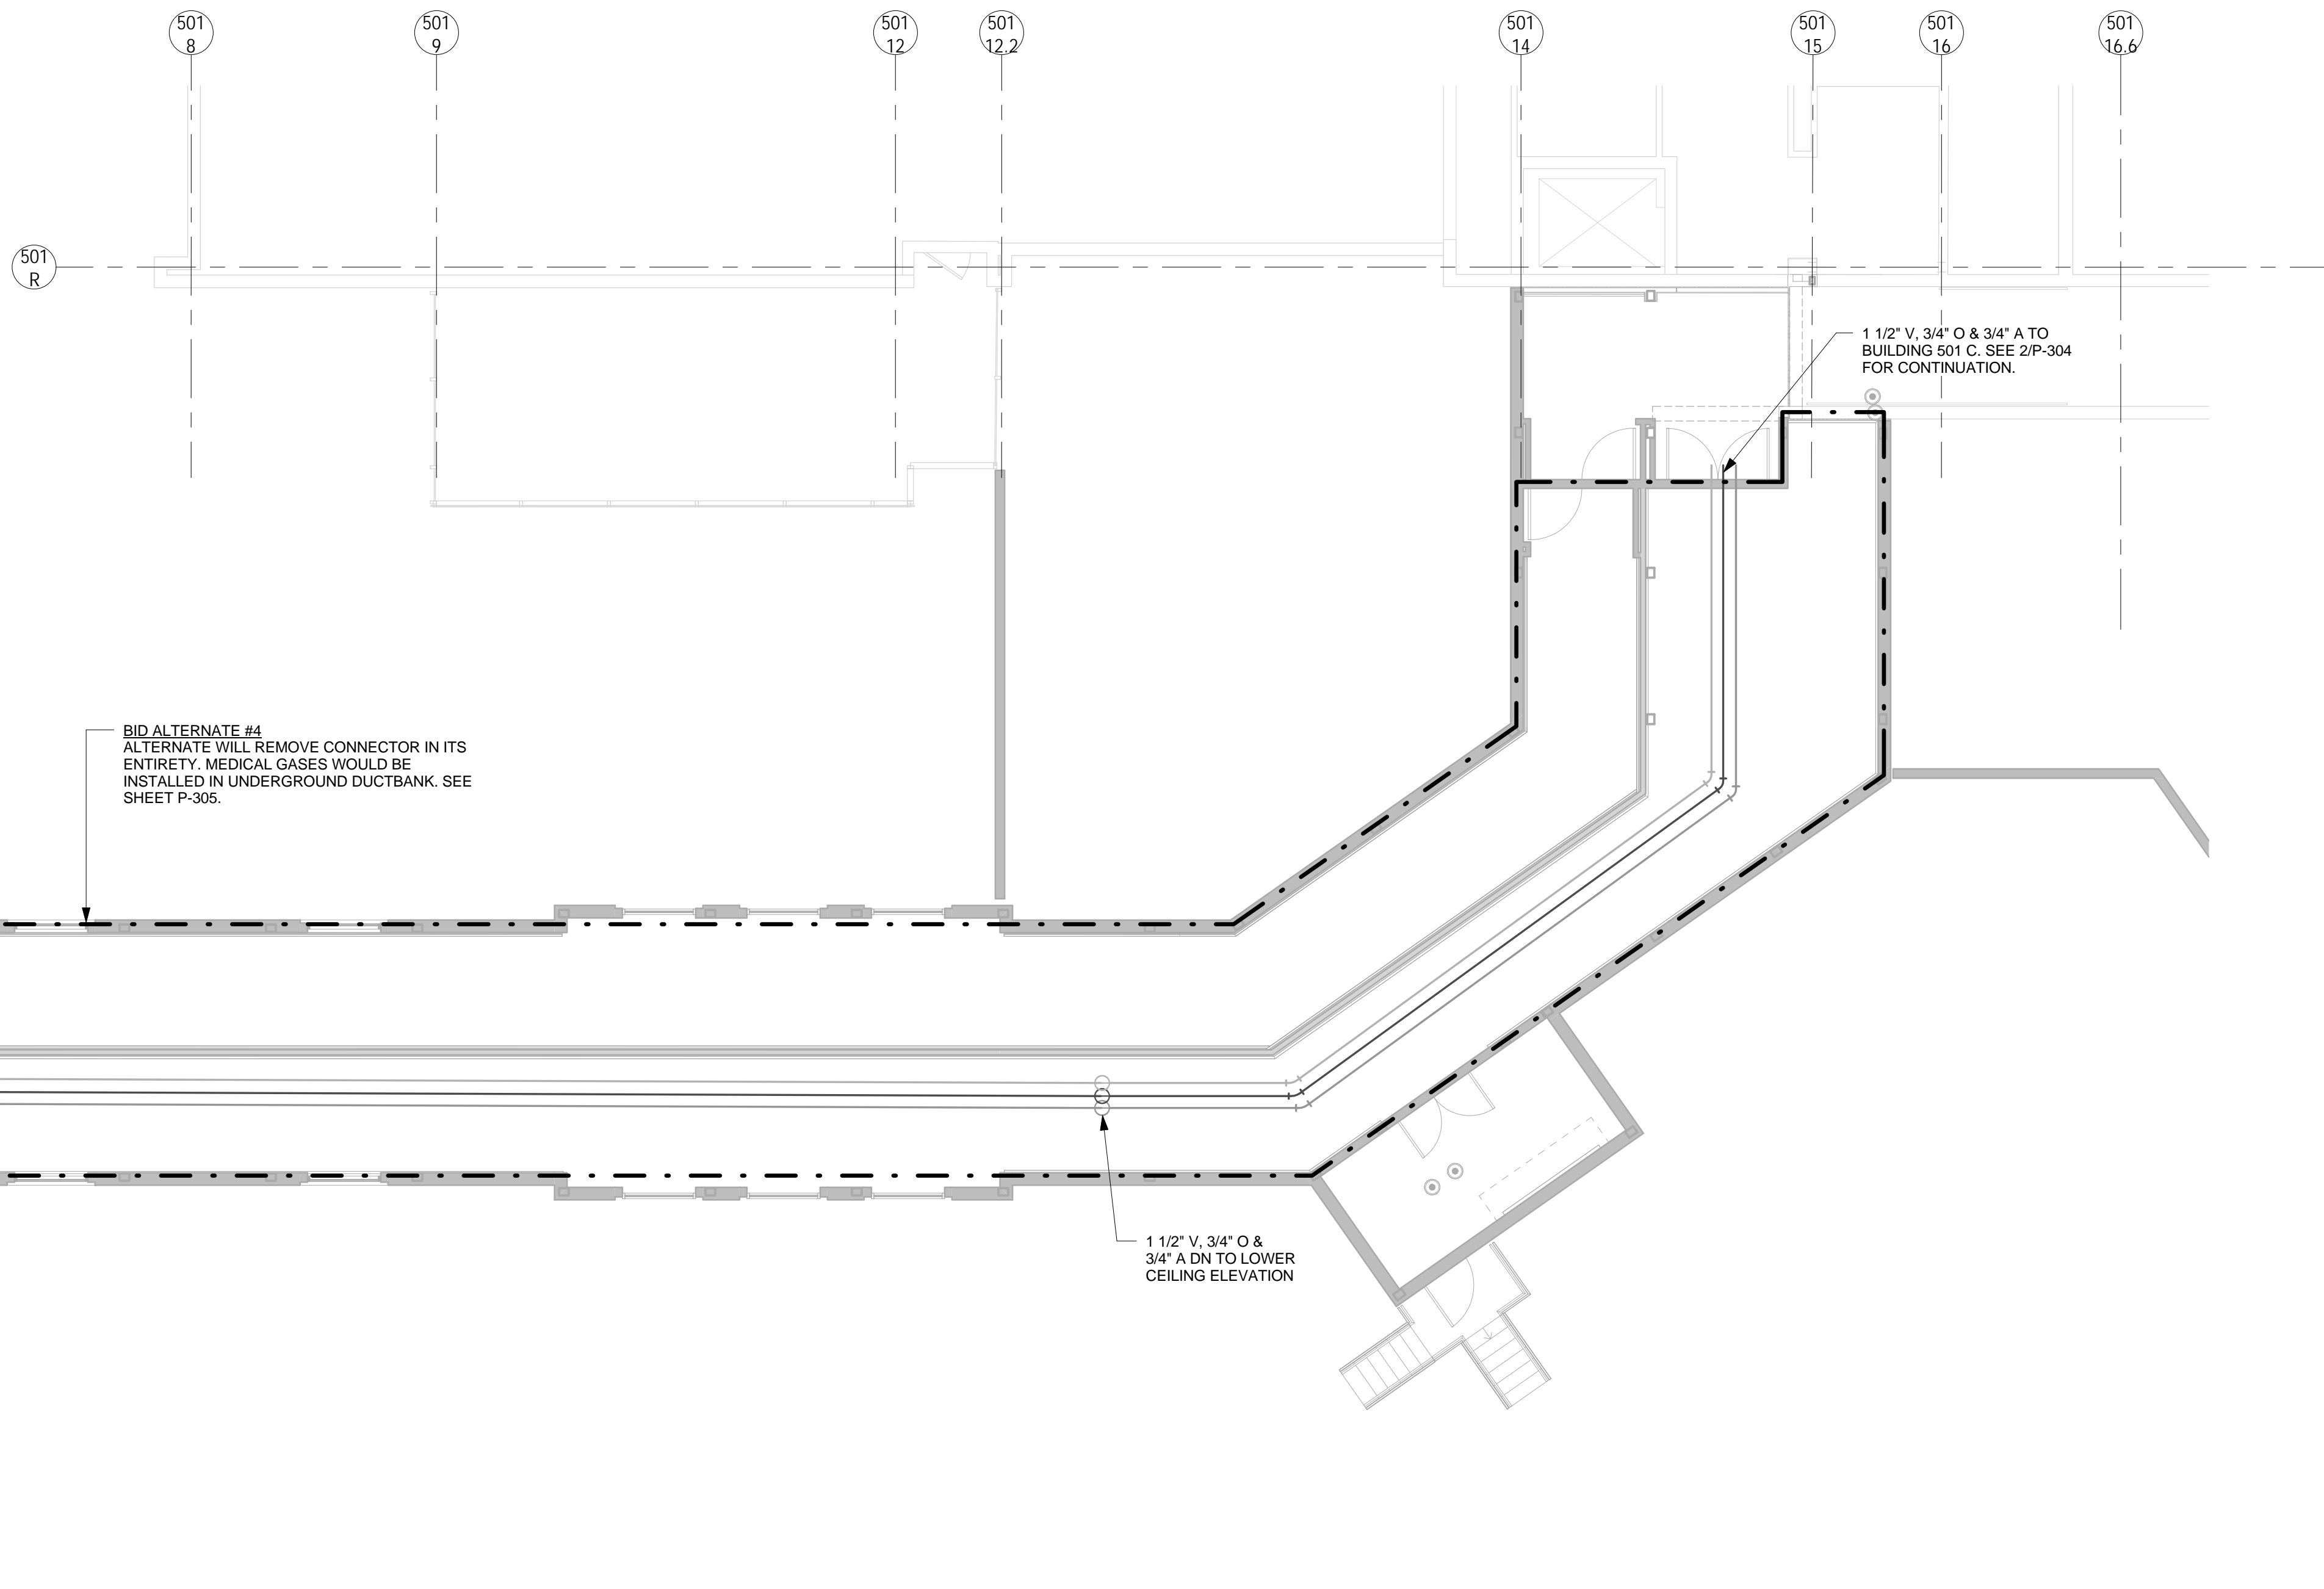

1 PLUMBING NEW WORK CORRIDOR LINK FLOOR PLAN  
1/8" = 1'-0"

Revisions:	Date

ARCHITECT:

C.C. HODGSON  
ARCHITECTURAL GROUP



ENGINEERS:

Westlake  
Reed  
Leskosky

1634 EYE ST, NW, STE 900  
WASHINGTON, DC 20006

Drawing Title

PLUMBING NEW WORK MED GAS CONNECTOR FLOOR  
PLAN

Approved: Project Director

Project Title

RELOCATE DEMENTIA UNIT

Location

VAMC MARTINSBURG

Date

08/06/2012

Checked

SCS

Drawn

CJW

Drawing Number

P-303

Dwg. of --

Office of  
Construction  
and Facilities  
Management

Department of  
Veterans Affairs