


1 BLDG 501 C BASEMENT DEMOLITION PLAN

SCALE 1/8\"/>

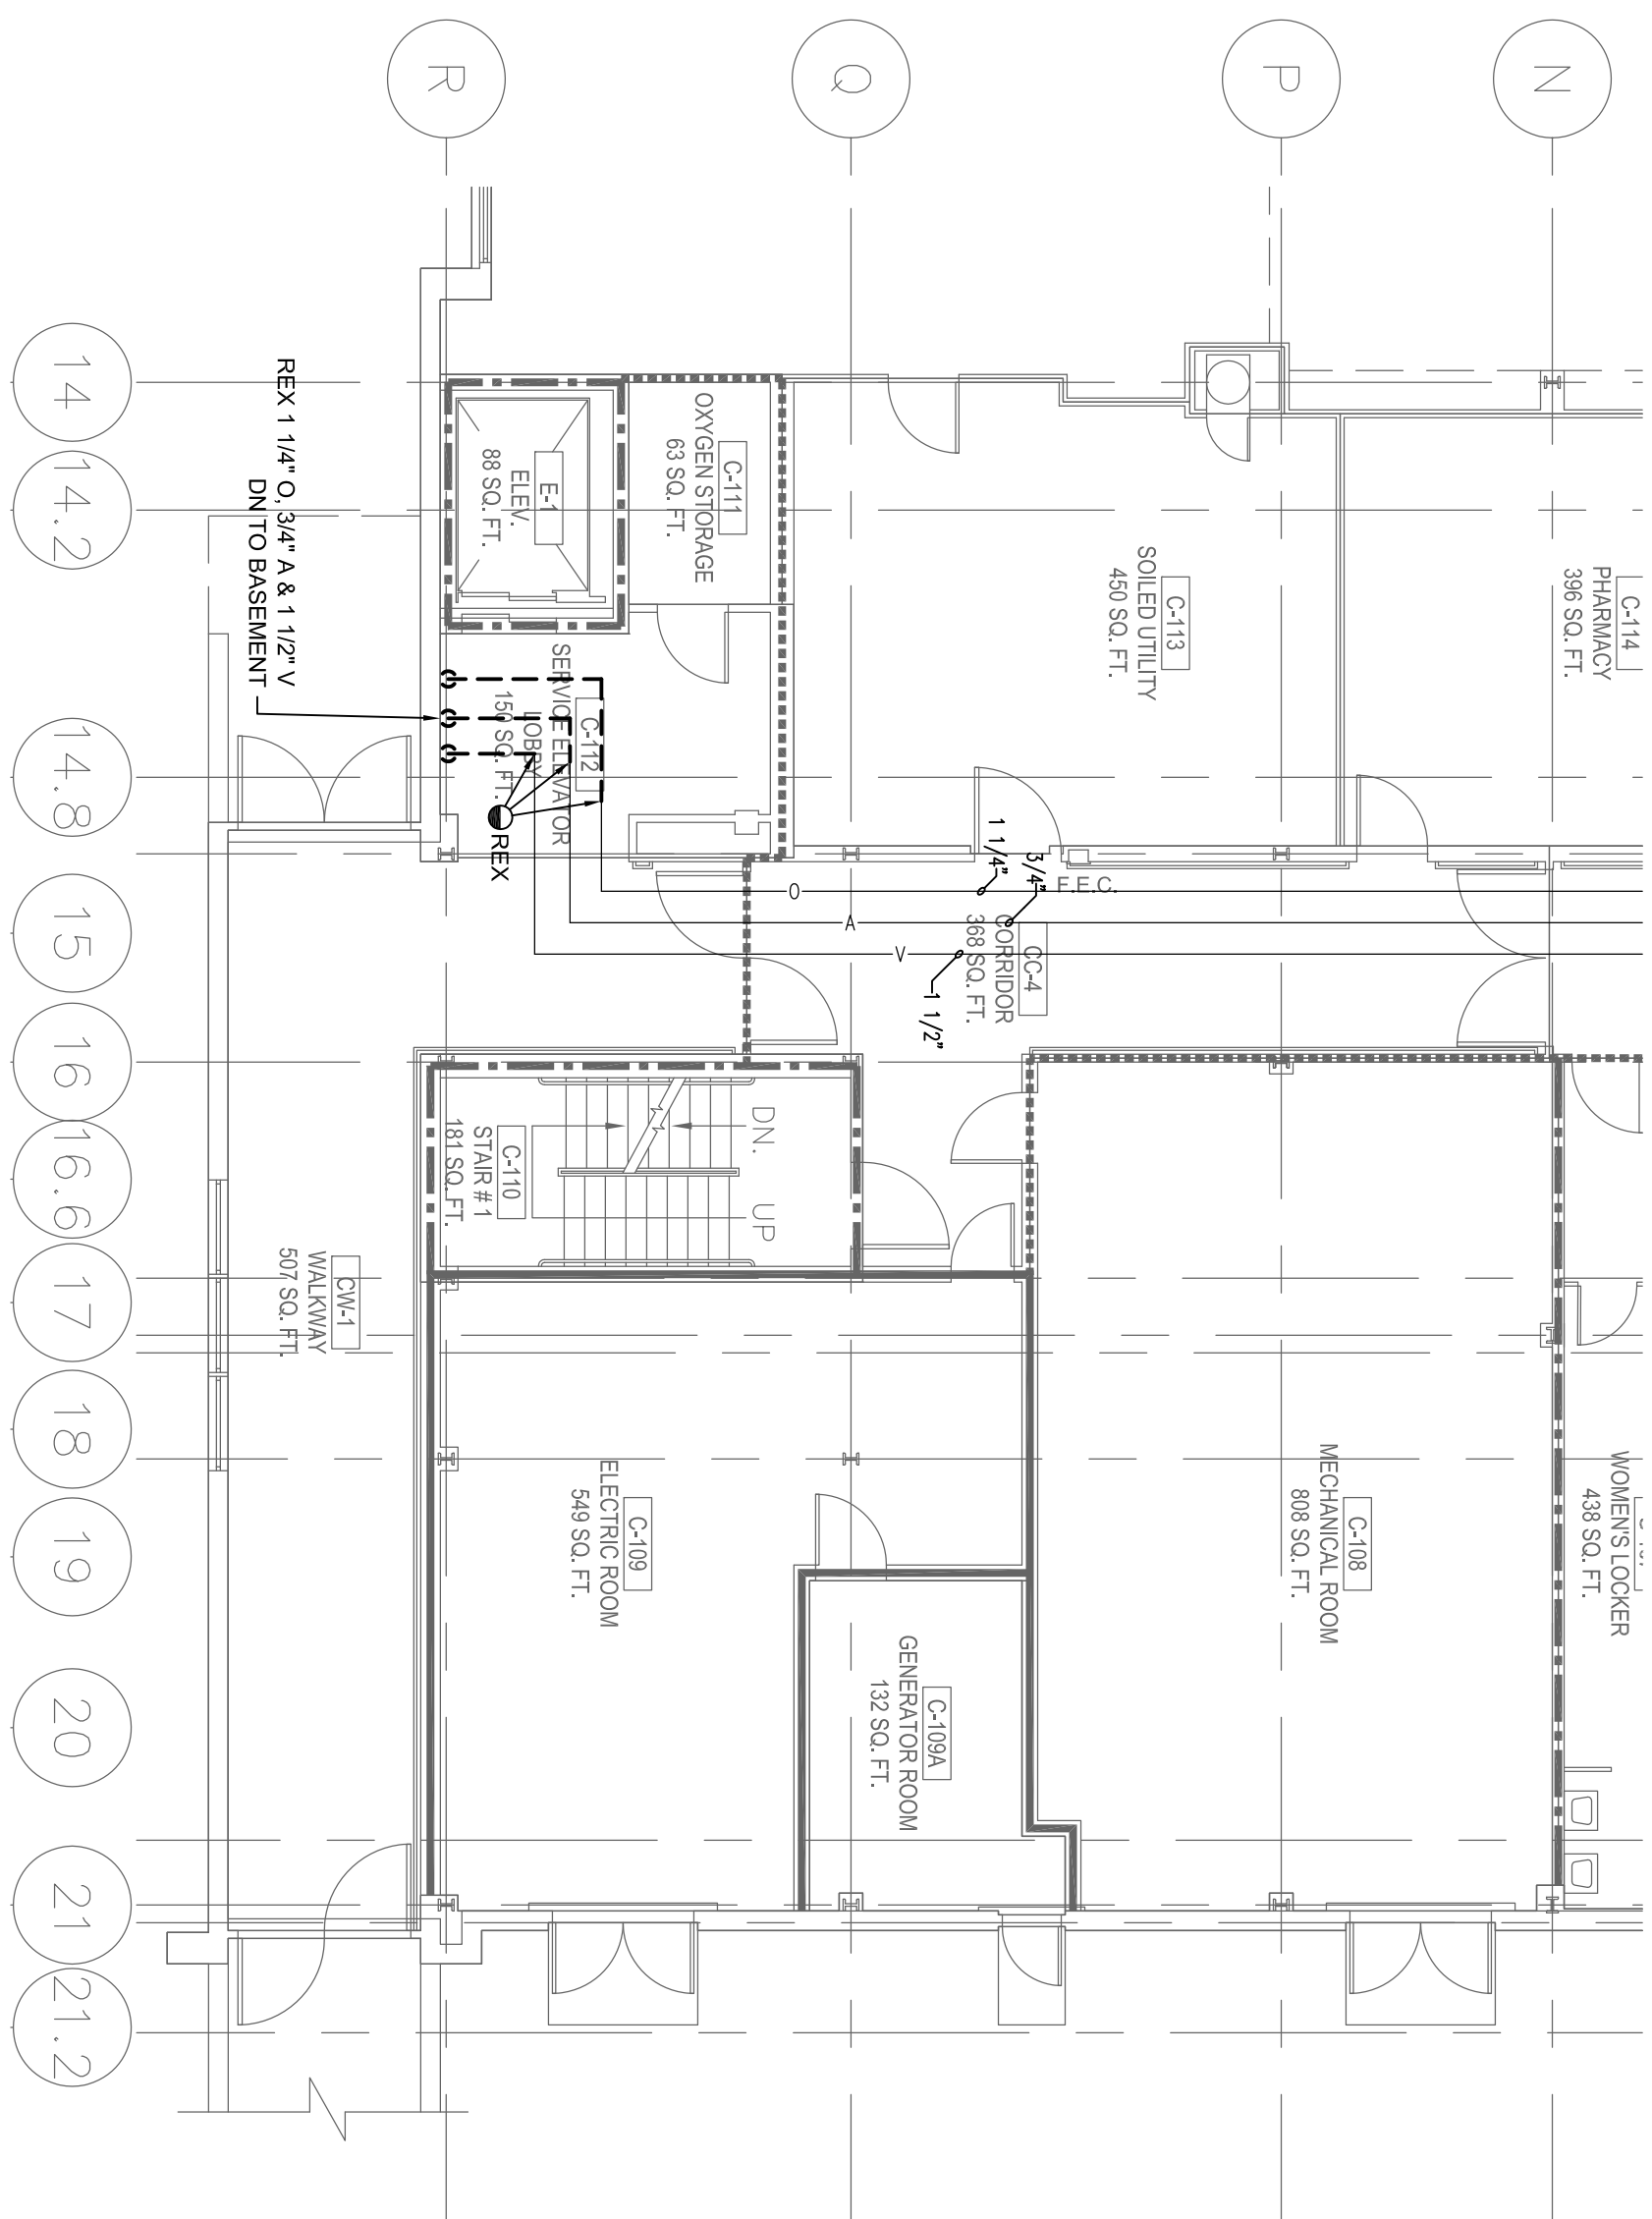

2 BLDG 501 C GROUND FLOOR DEMOLITION PLAN

SCALE 1/8\"/>

- PLUMBING GENERAL NOTES
1. REFER TO P-201 FOR PLUMBING MATERIALS AND SYMBOLS.
 2. REFER TO P-201 THROUGH P-202 FOR PLUMBING DETAILS.
 3. REFER TO P-701 FOR PLUMBING SCHEDULES.
 4. REFER TO P-901 THROUGH P-902 FOR PLUMBING RISER DIAGRAMS.


BID DOCUMENTS

FULLY SPRINKLERED

Revised:	Date:

ARCHITECT:

C.C. HODGSON
ARCHITECTURAL GROUP

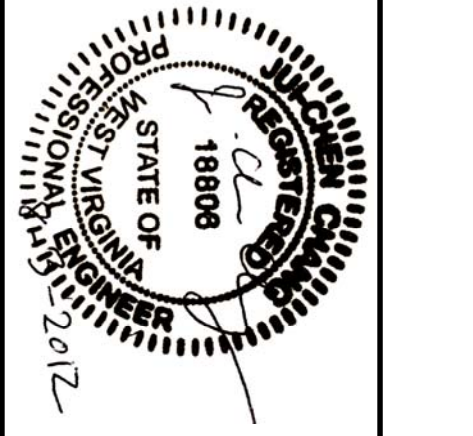

ENGINEERS:

Westlake
Reed
Leskosky

1634 EYE ST, NW, STE 900
WASHINGTON, DC 20006

Drawing Title

BIDG 501 C EXISTING MEDICAL GAS
DEMOLITION PLANS

Project Title

RELOCATE DEMENTIA UNIT

Location

YAMC MARTINSBURG

Date

08/06/2012

Checked

SCS

Drawn

CJW

Project Number

VA, PH 613-207

Building Number

513

Drawing Number

PD-304

Drawn of

...

Office of
Construction
and Facilities
Management