



1 TYPICAL ROOM WITH CEILING SENSOR

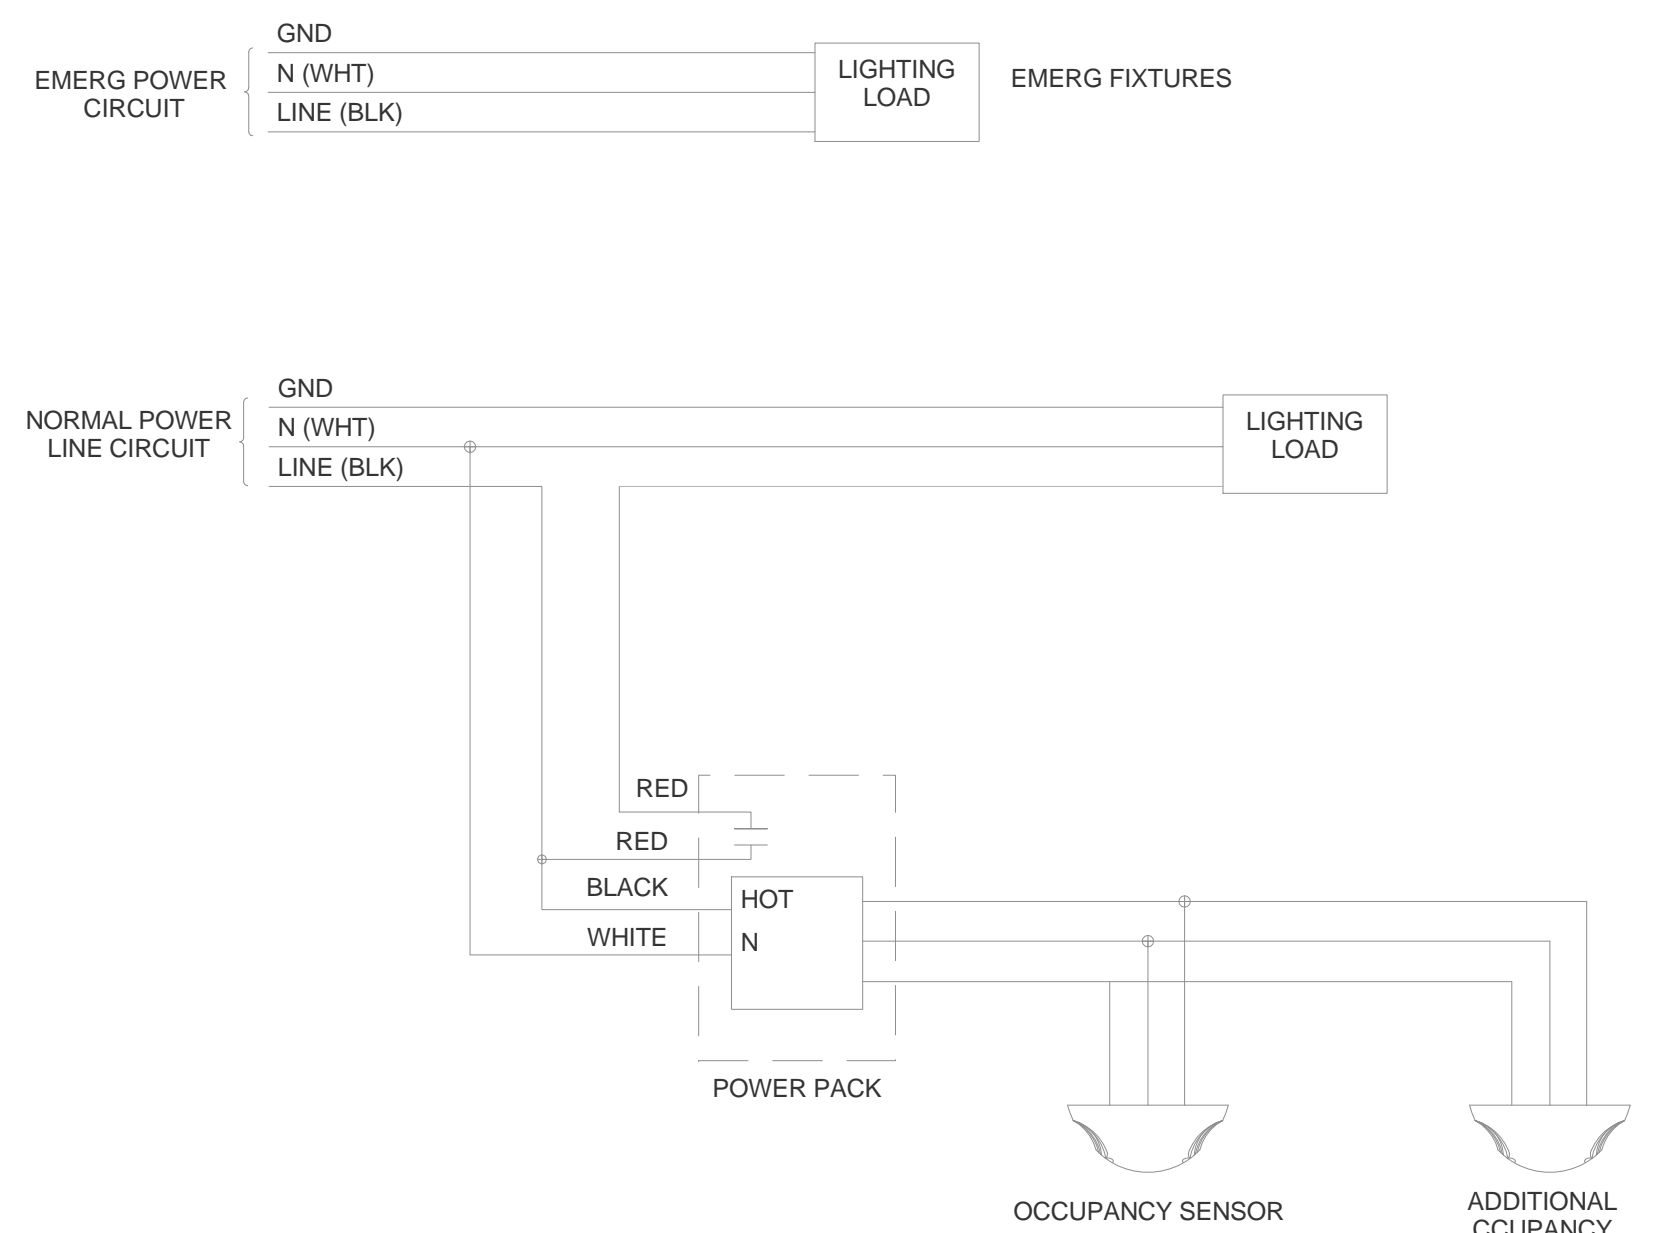


3 TYPICAL CORRIDOR CONTROL DIAGRAM

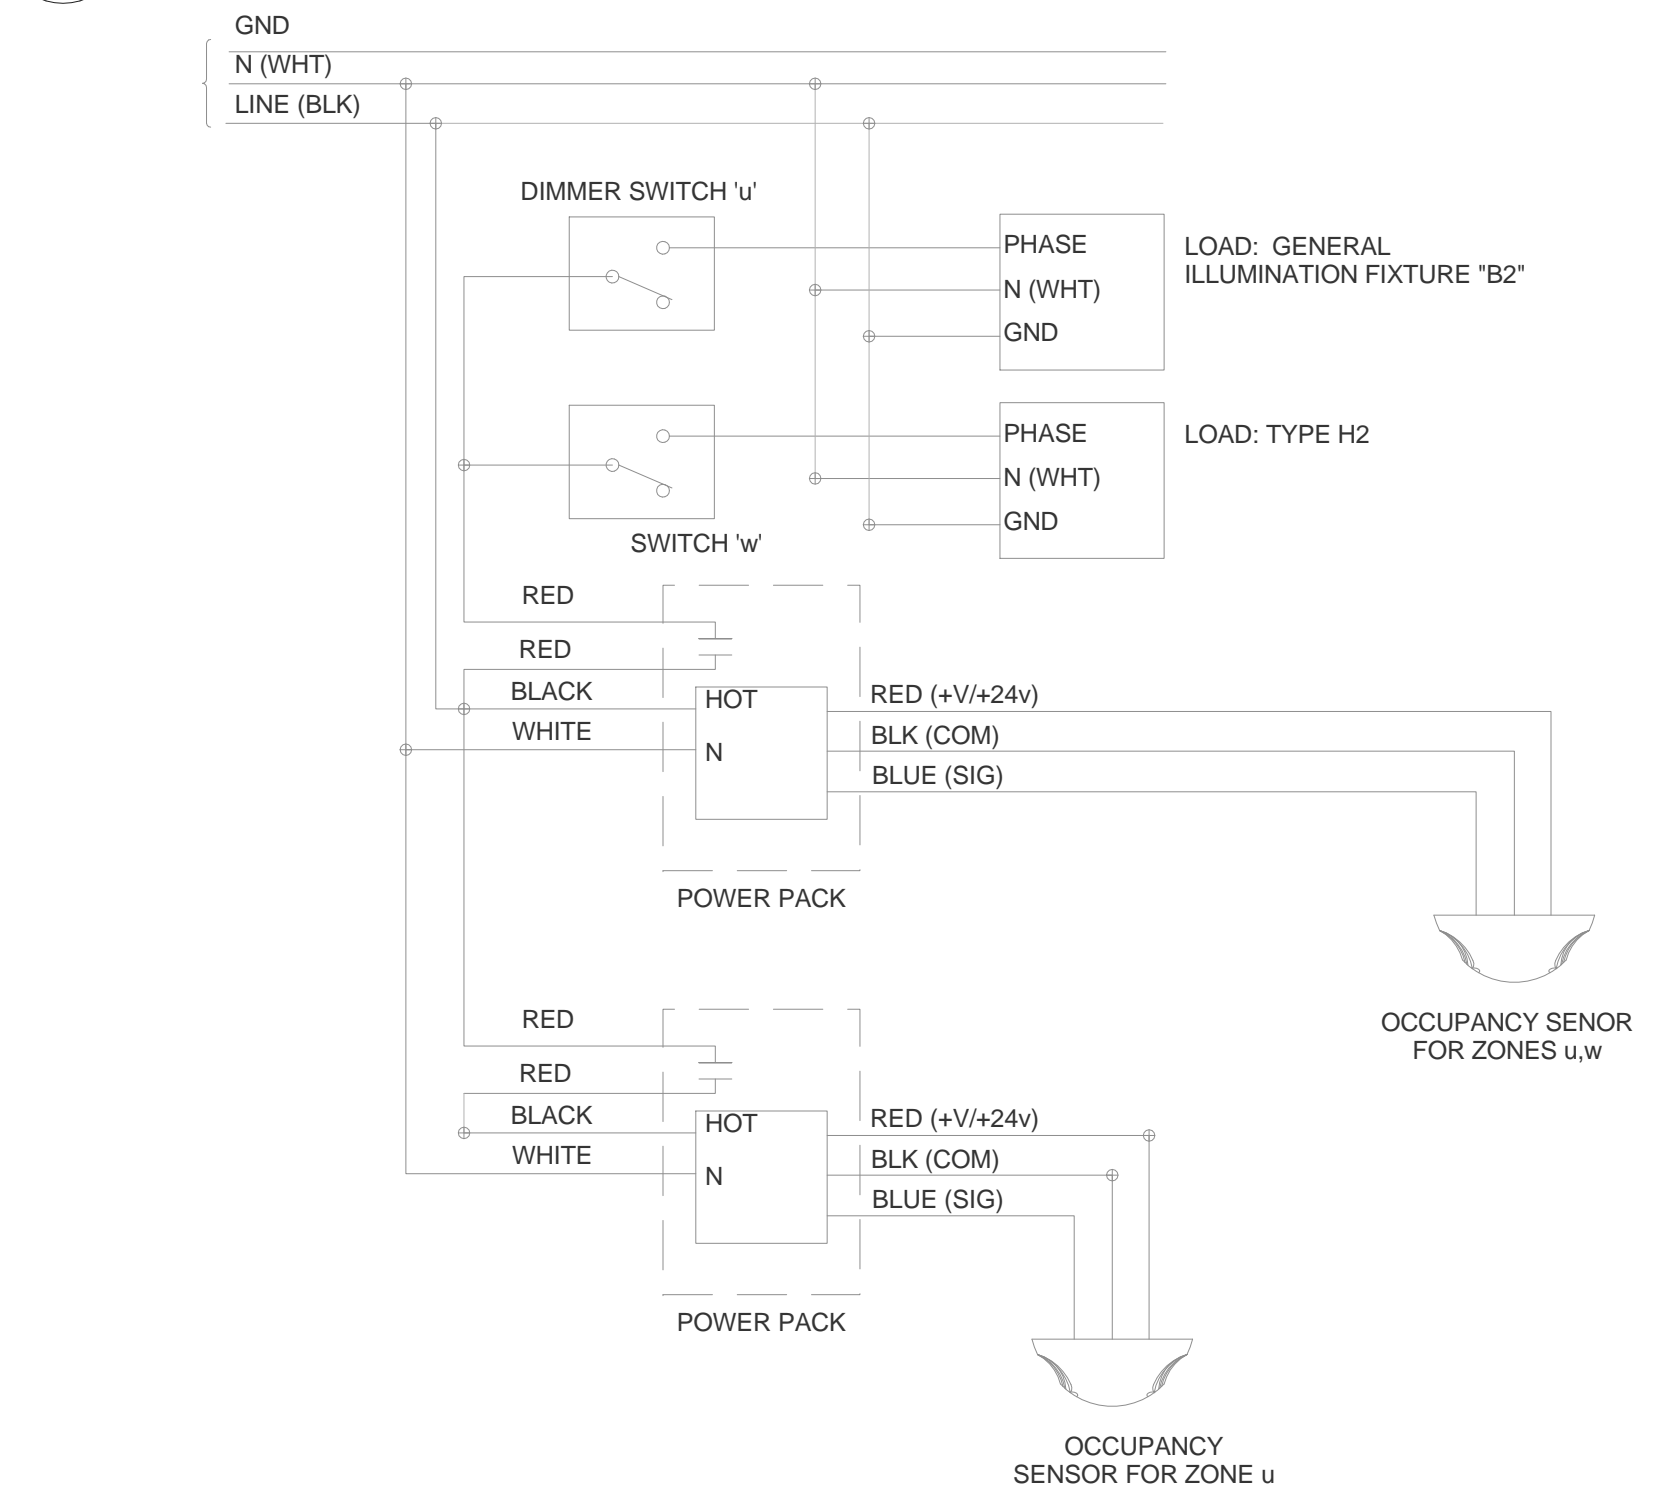


6 TYPICAL LIVING ROOM CONTROL DIAGRAM


2 TYPICAL ROOM WITH WALL SENSOR

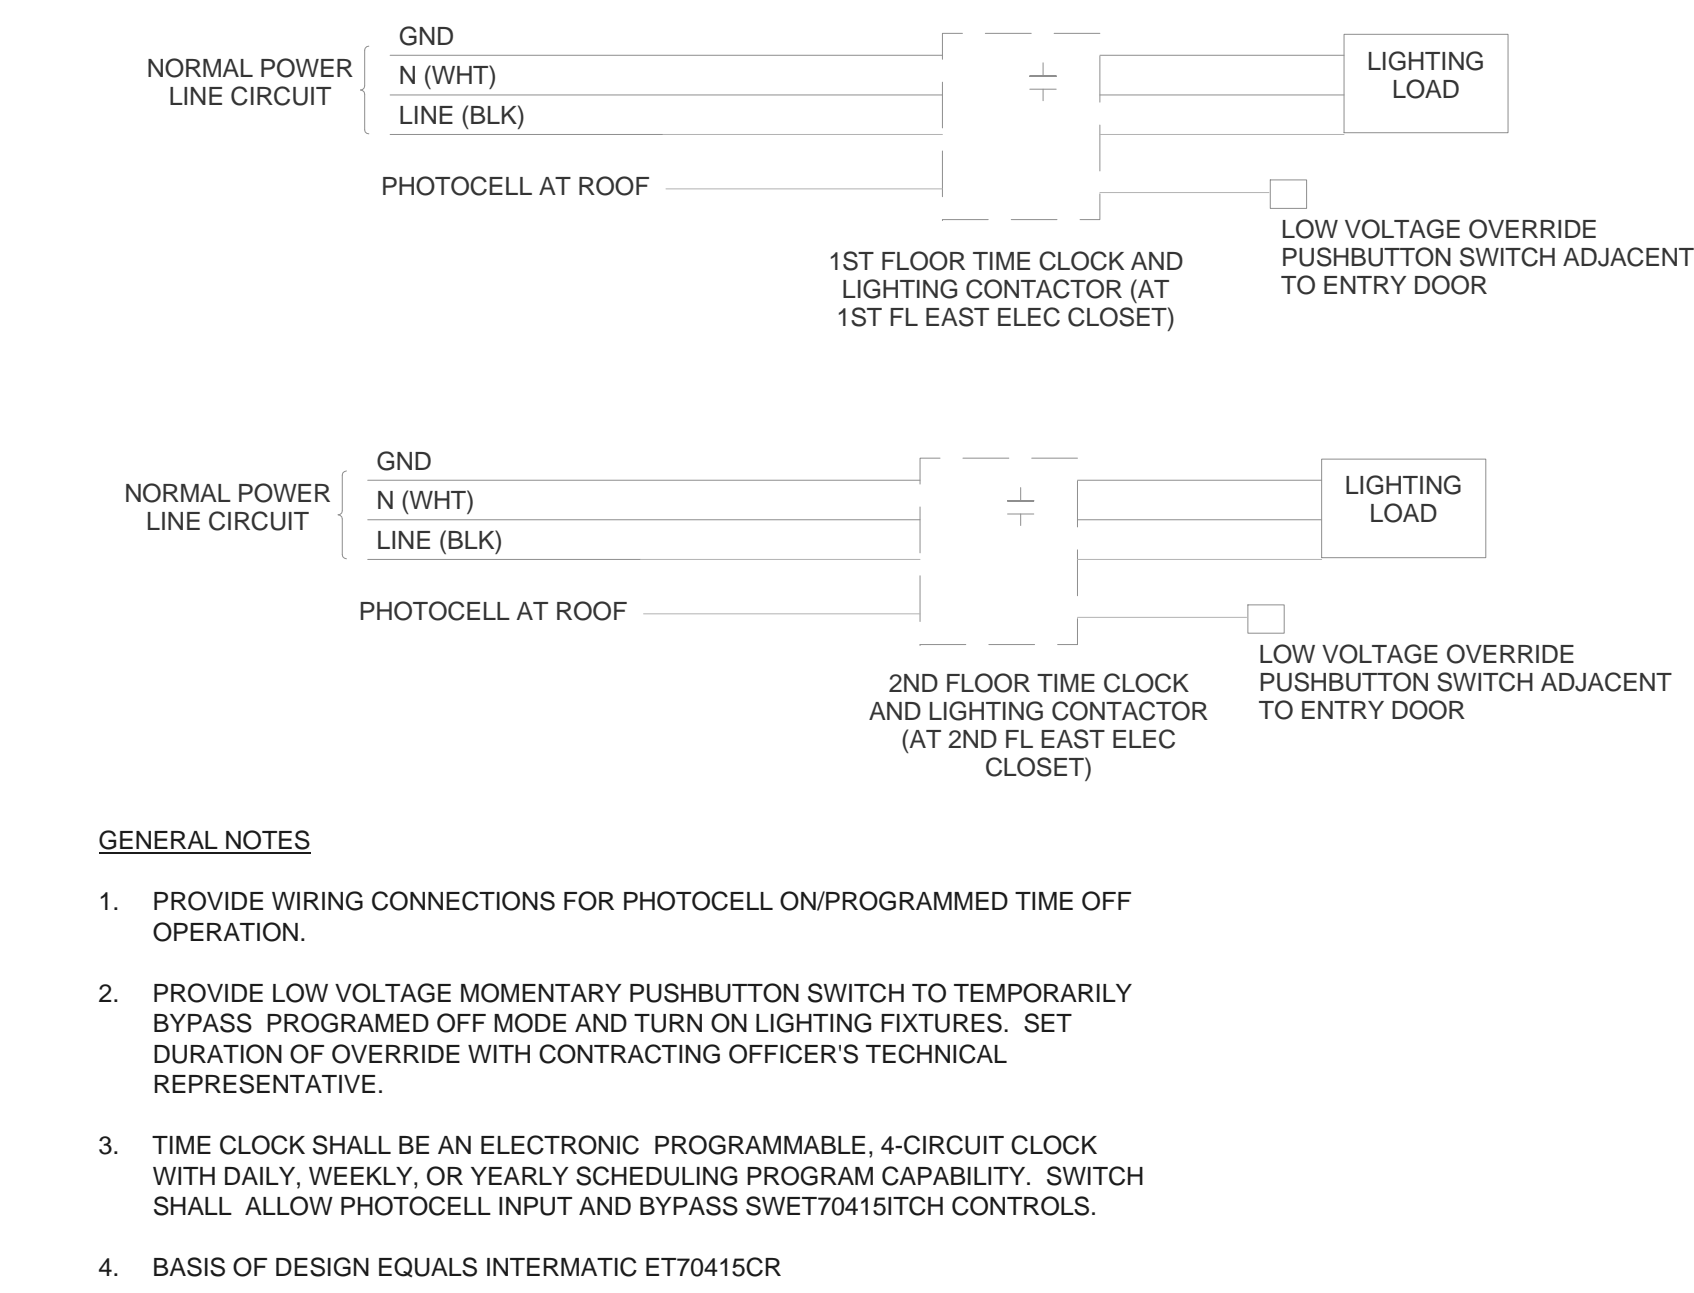


3 TYPICAL BALCONY CONTROL DIAGRAM

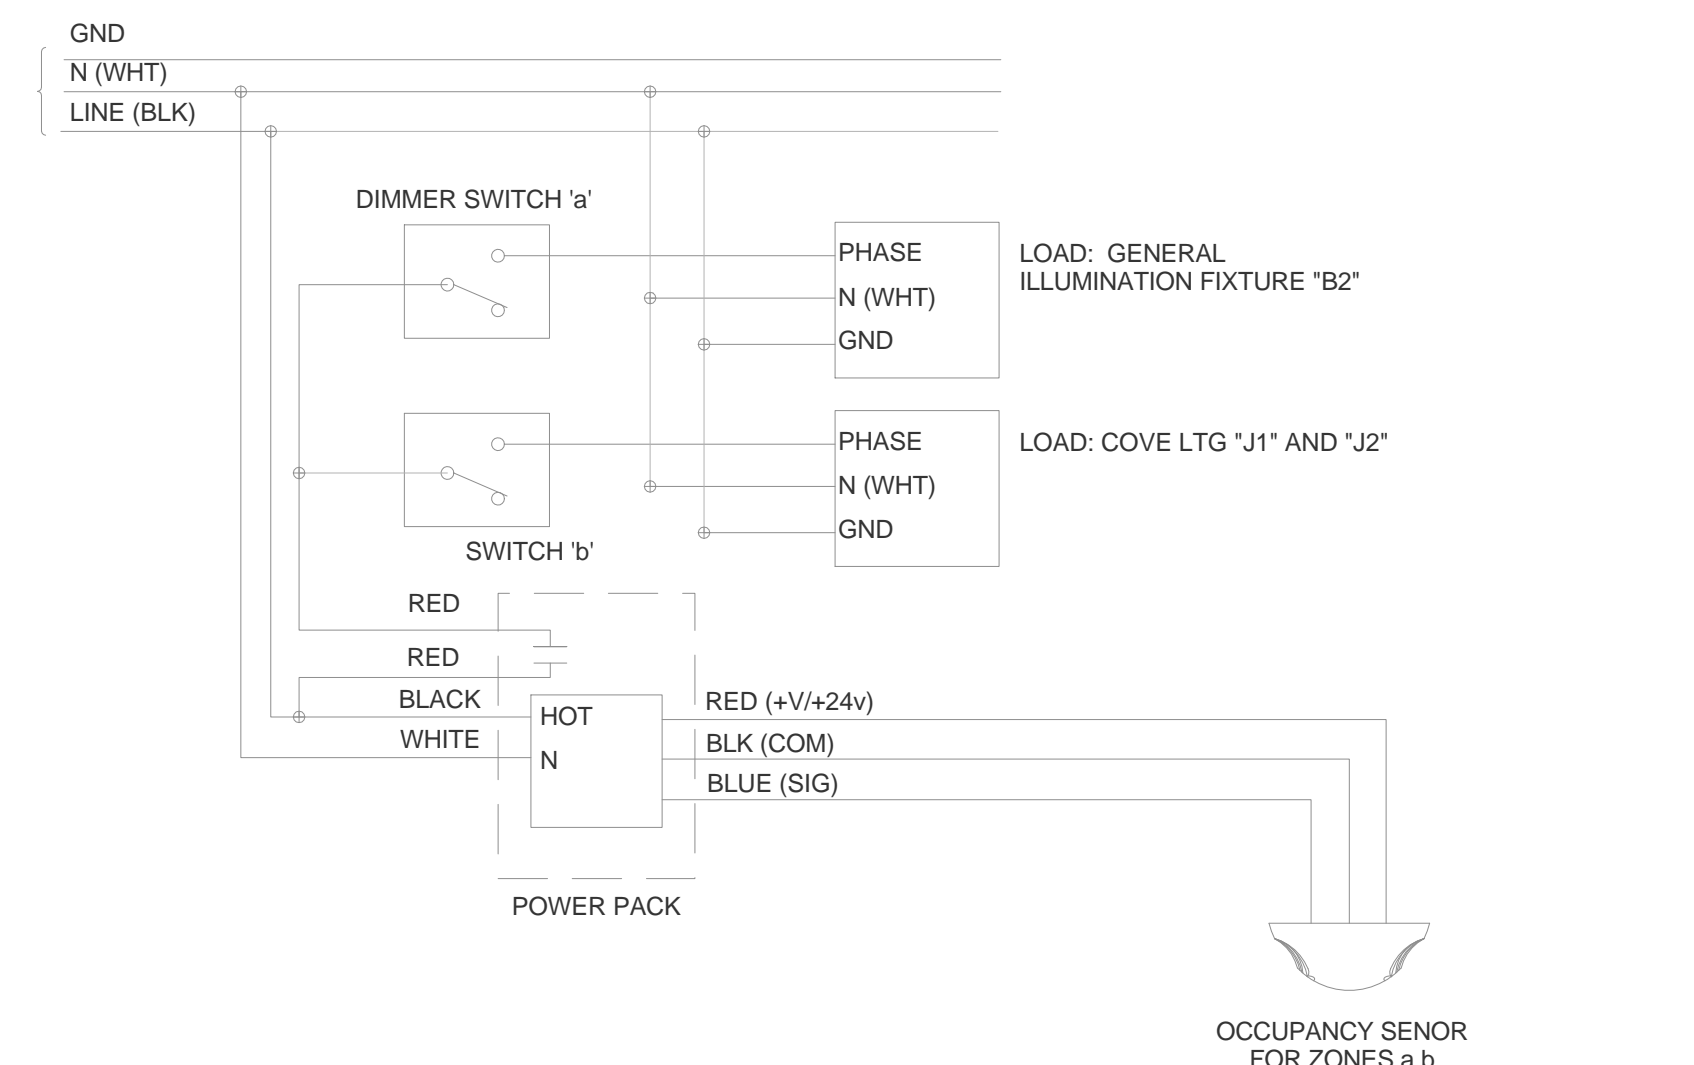


7 TYPICAL DINING ROOM CONTROL DIAGRAM

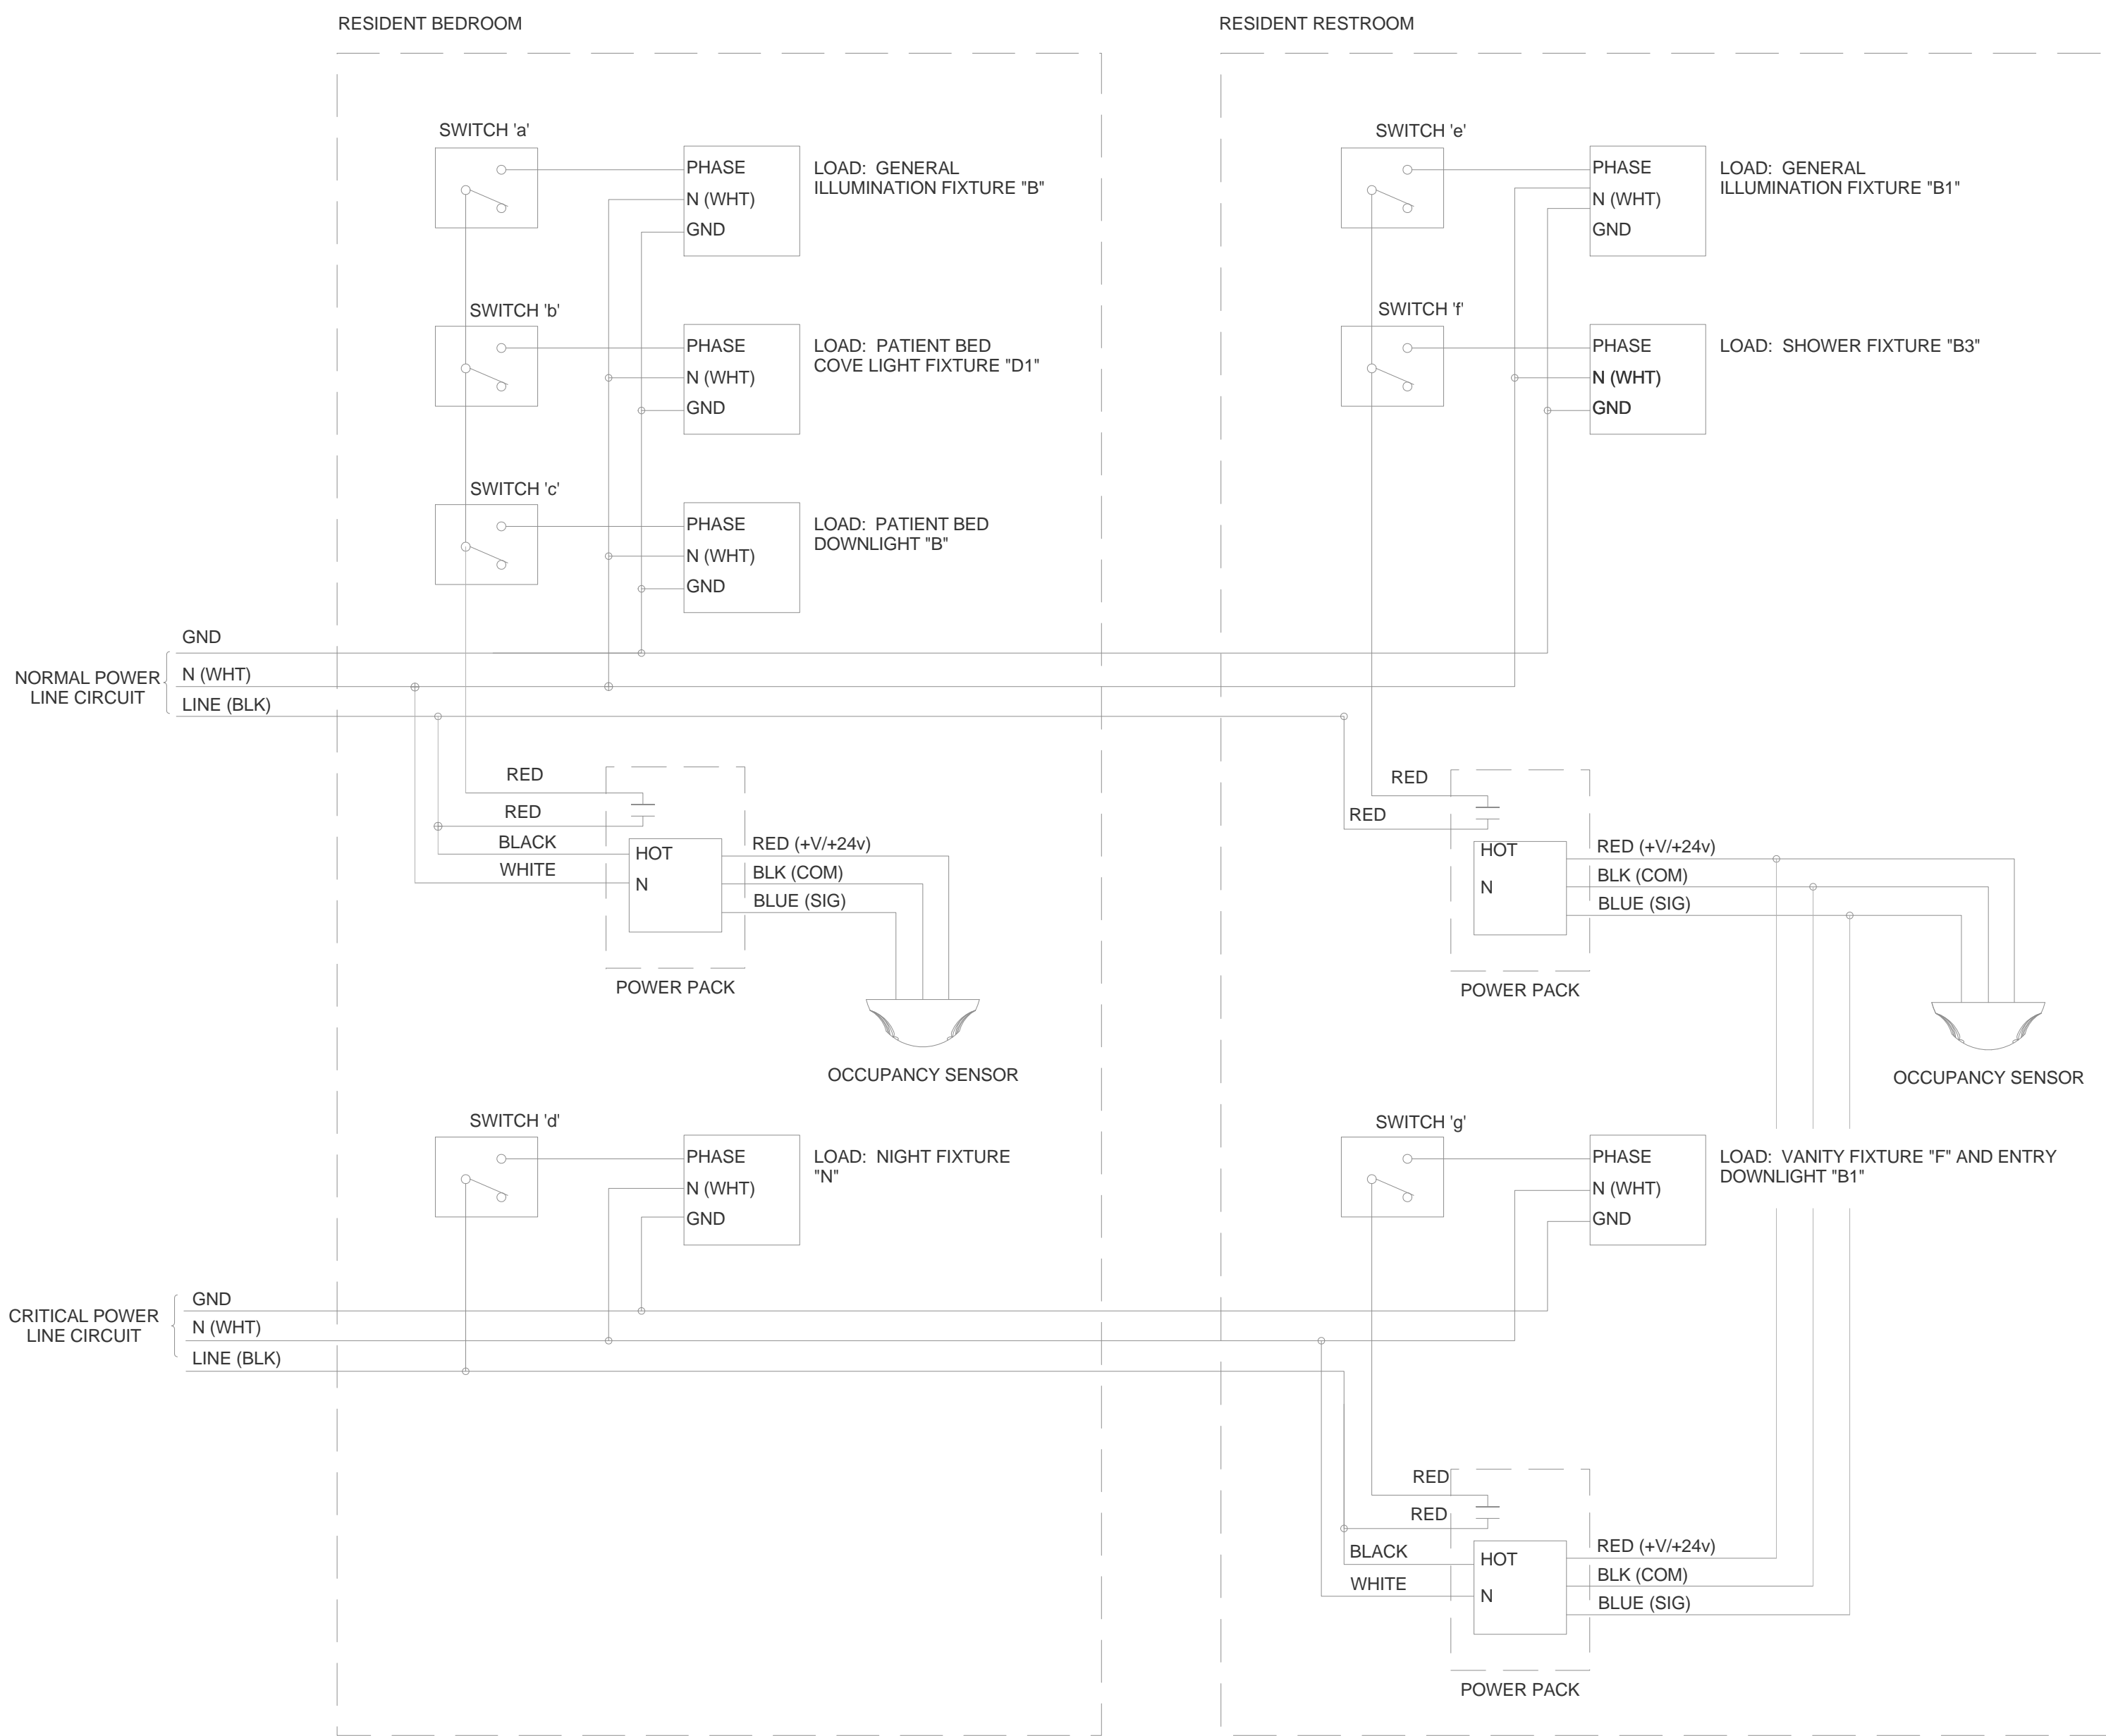

5 TYPICAL RESIDENT BEDROOM AND BATHROOM CONTROL DIAGRAM

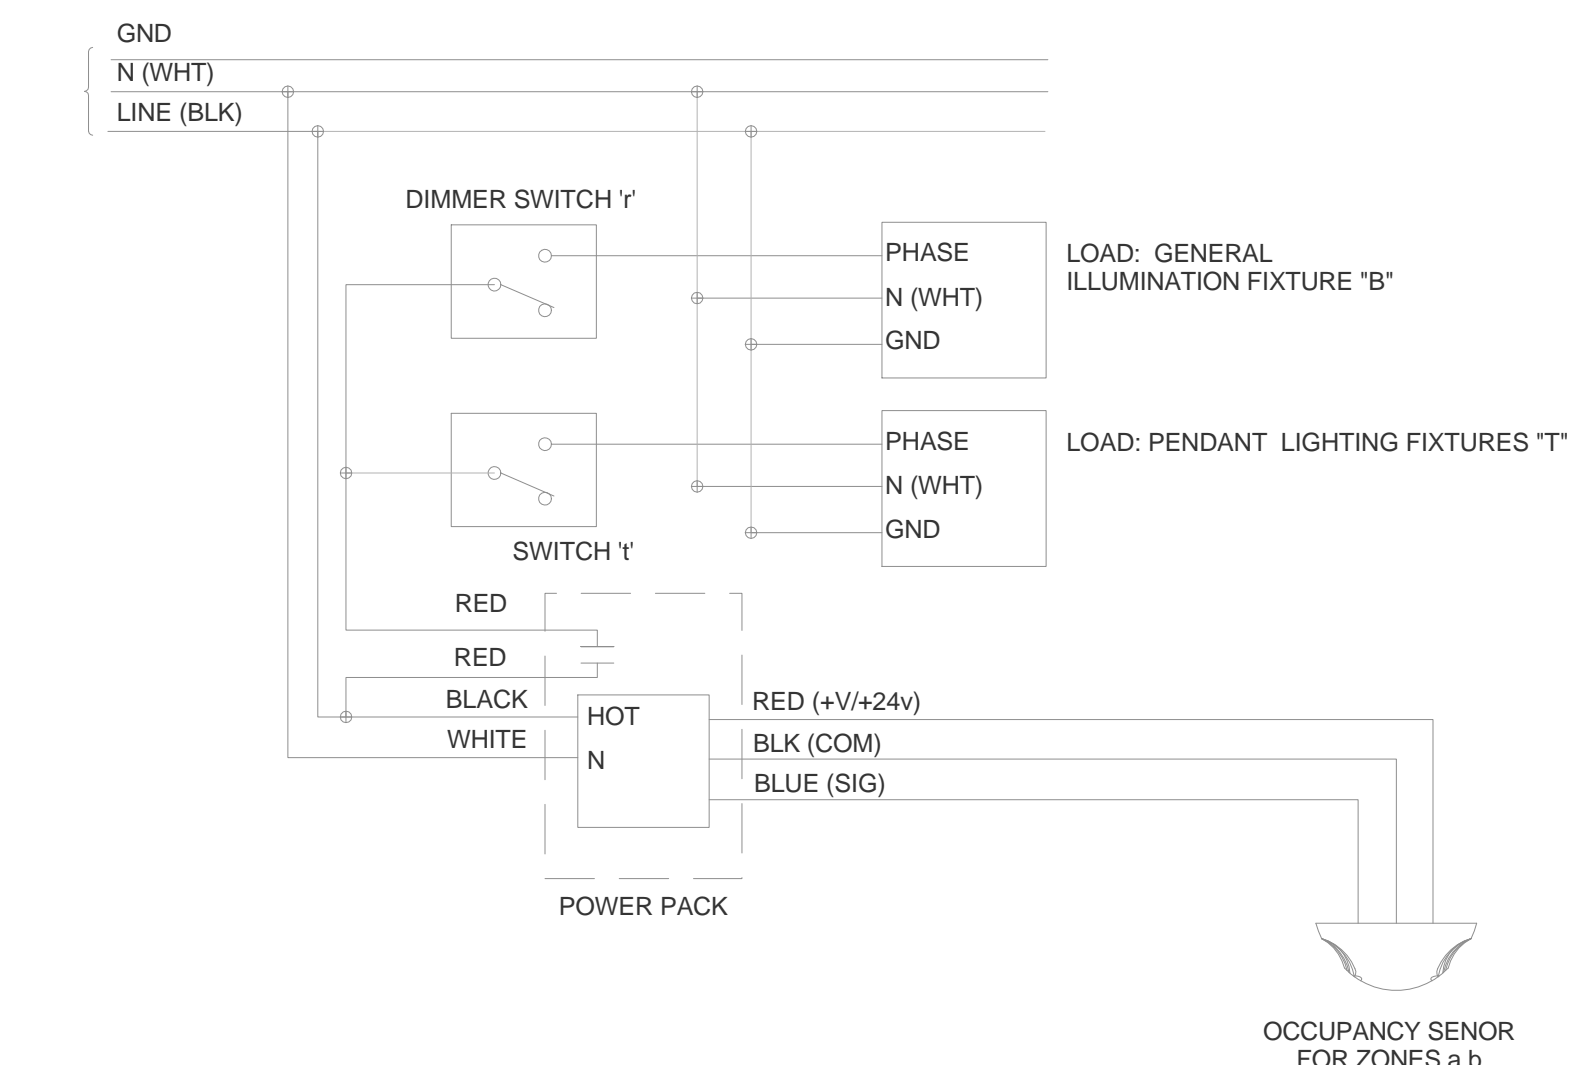

7 TYPICAL KITCHEN CONTROL DIAGRAM

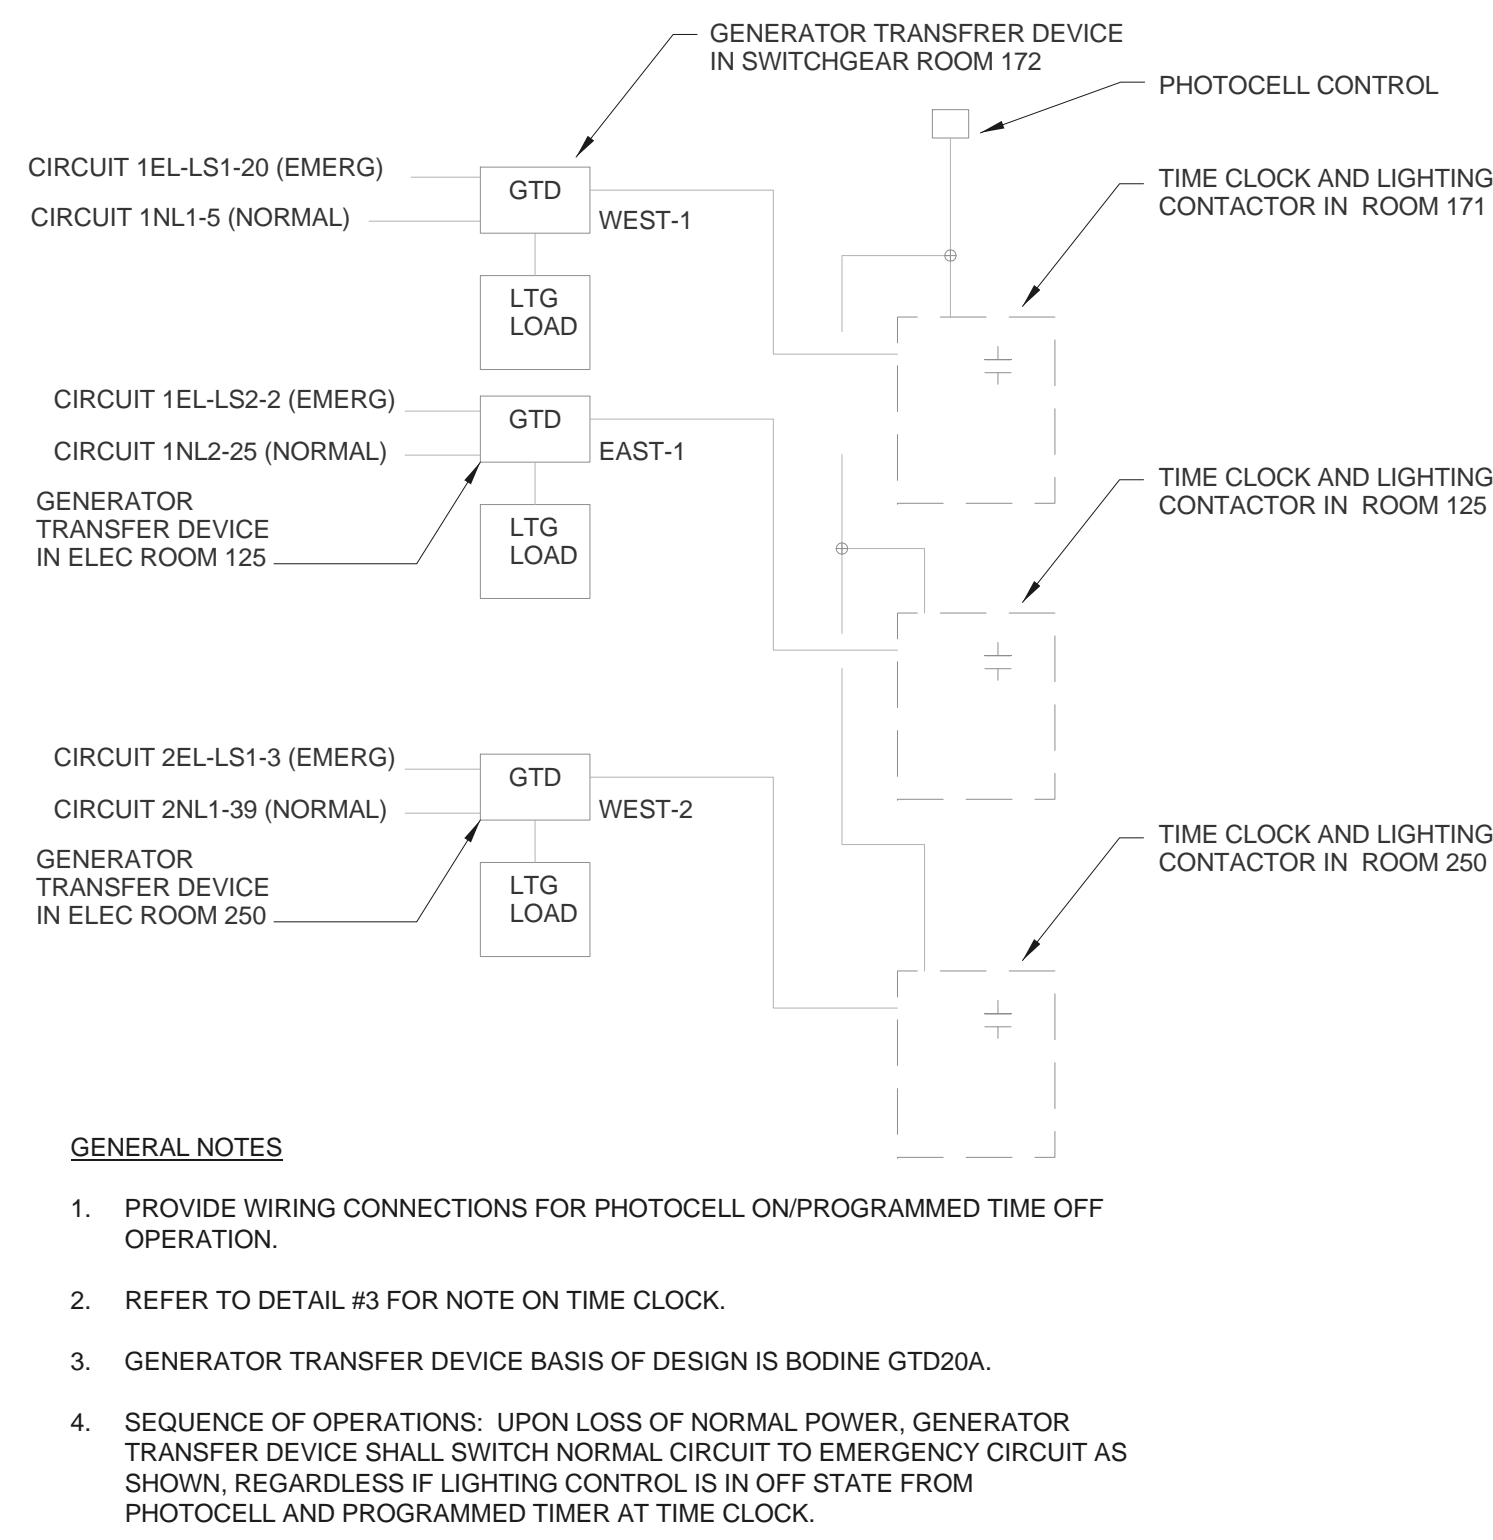

8 GENERATOR TRANSFER DEVICE CONTROL DIAGRAM

Revisions:	Date

ARCHITECT:

C.C. HODGSON
ARCHITECTURAL GROUP



ENGINEERS:

Westlake
Reed
Leskosky

1634 EYE ST, NW, STE 900
WASHINGTON, DC 20006

Drawing Title

LIGHTING CONTROL DIAGRAMS

Approved: Project Director

Project Title

RELOCATE DEMENTIA UNIT

Project Number

VA PN 613-207

Building Number

513

Location

VAMC MARTINSBURG

Date

08/06/2012

Checked

GSL

Drawn

DRW

Drawing Number

E-505

Dwg. of

--

Office of
Construction
and Facilities
Management

Department of
Veterans Affairs