



FIRE ALARM GENERAL NOTES
1 FIRE ALARM DEVICES SHALL BE COMPATIBLE WITH PROPRIETARY FIRE ALARM CONTROL PANEL: EDWARDS EST3.
2 NOT USED.

SHEET KEYED NOTES
1 EXISTING EDWARDS EST-3 FIRE ALARM CONTROL PANEL
2 EXISTING FIRE ALARM ENCLOSURE

BID ALTERNATE NOTES:
REFER TO SHEET FA-003.

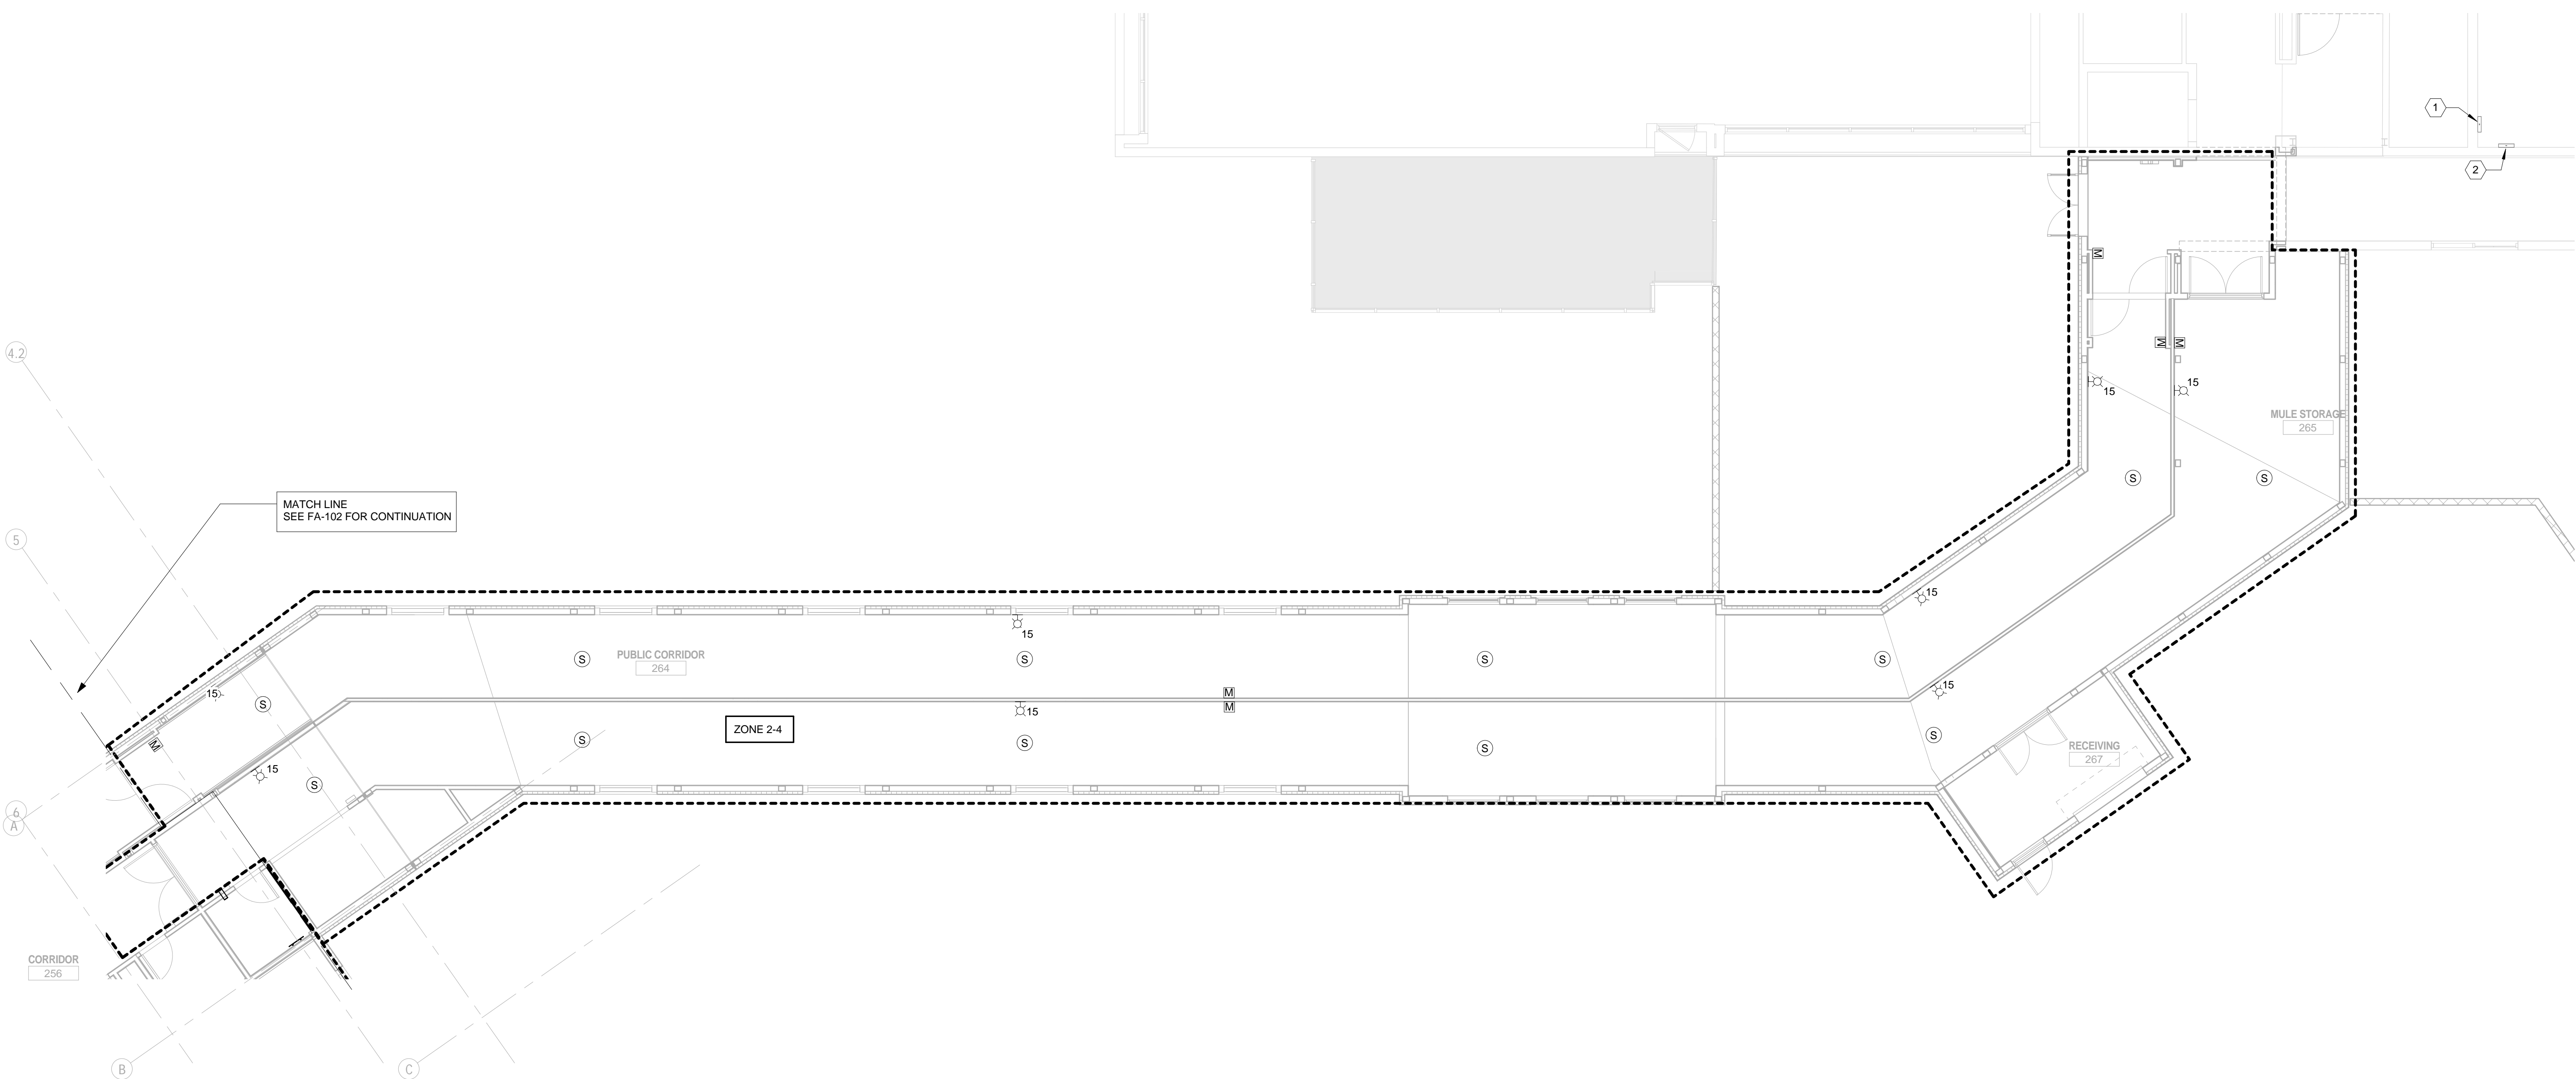


1 2ND FLOOR CORRIDOR LINK FIRE ALARM FLOOR PLAN
1/8" = 1'-0"

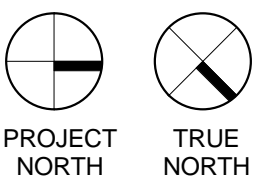

Revisions:	Date

ARCHITECT:

C.C. HODGSON
ARCHITECTURAL GROUP

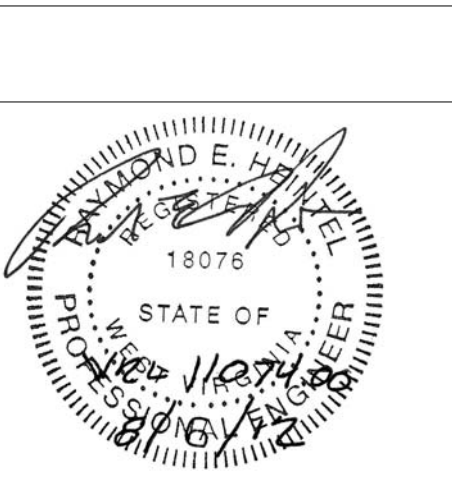

ENGINEERS:

Westlake
Reed
Leskosky
1634 EYE ST, NW, STE 900
WASHINGTON, DC 20006

Drawing Title
FIRE ALARM NEW WORK CORRIDOR LINK PLAN

Approved: Project Director

Project Title
RELOCATE DEMENTIA UNIT

Project Number
VA PN 613-207

Building Number
513

Drawing Number
FA-103

Dwg. of --

Office of
Construction
and Facilities
Management

Department of
Veterans Affairs