



three inches = one foot
one and one half inches = one foot
one inch = one foot
three quarters inch = one foot
one half inch = one foot
three eighths inch = one foot
one quarter inch = one foot
one eighth inch = one foot

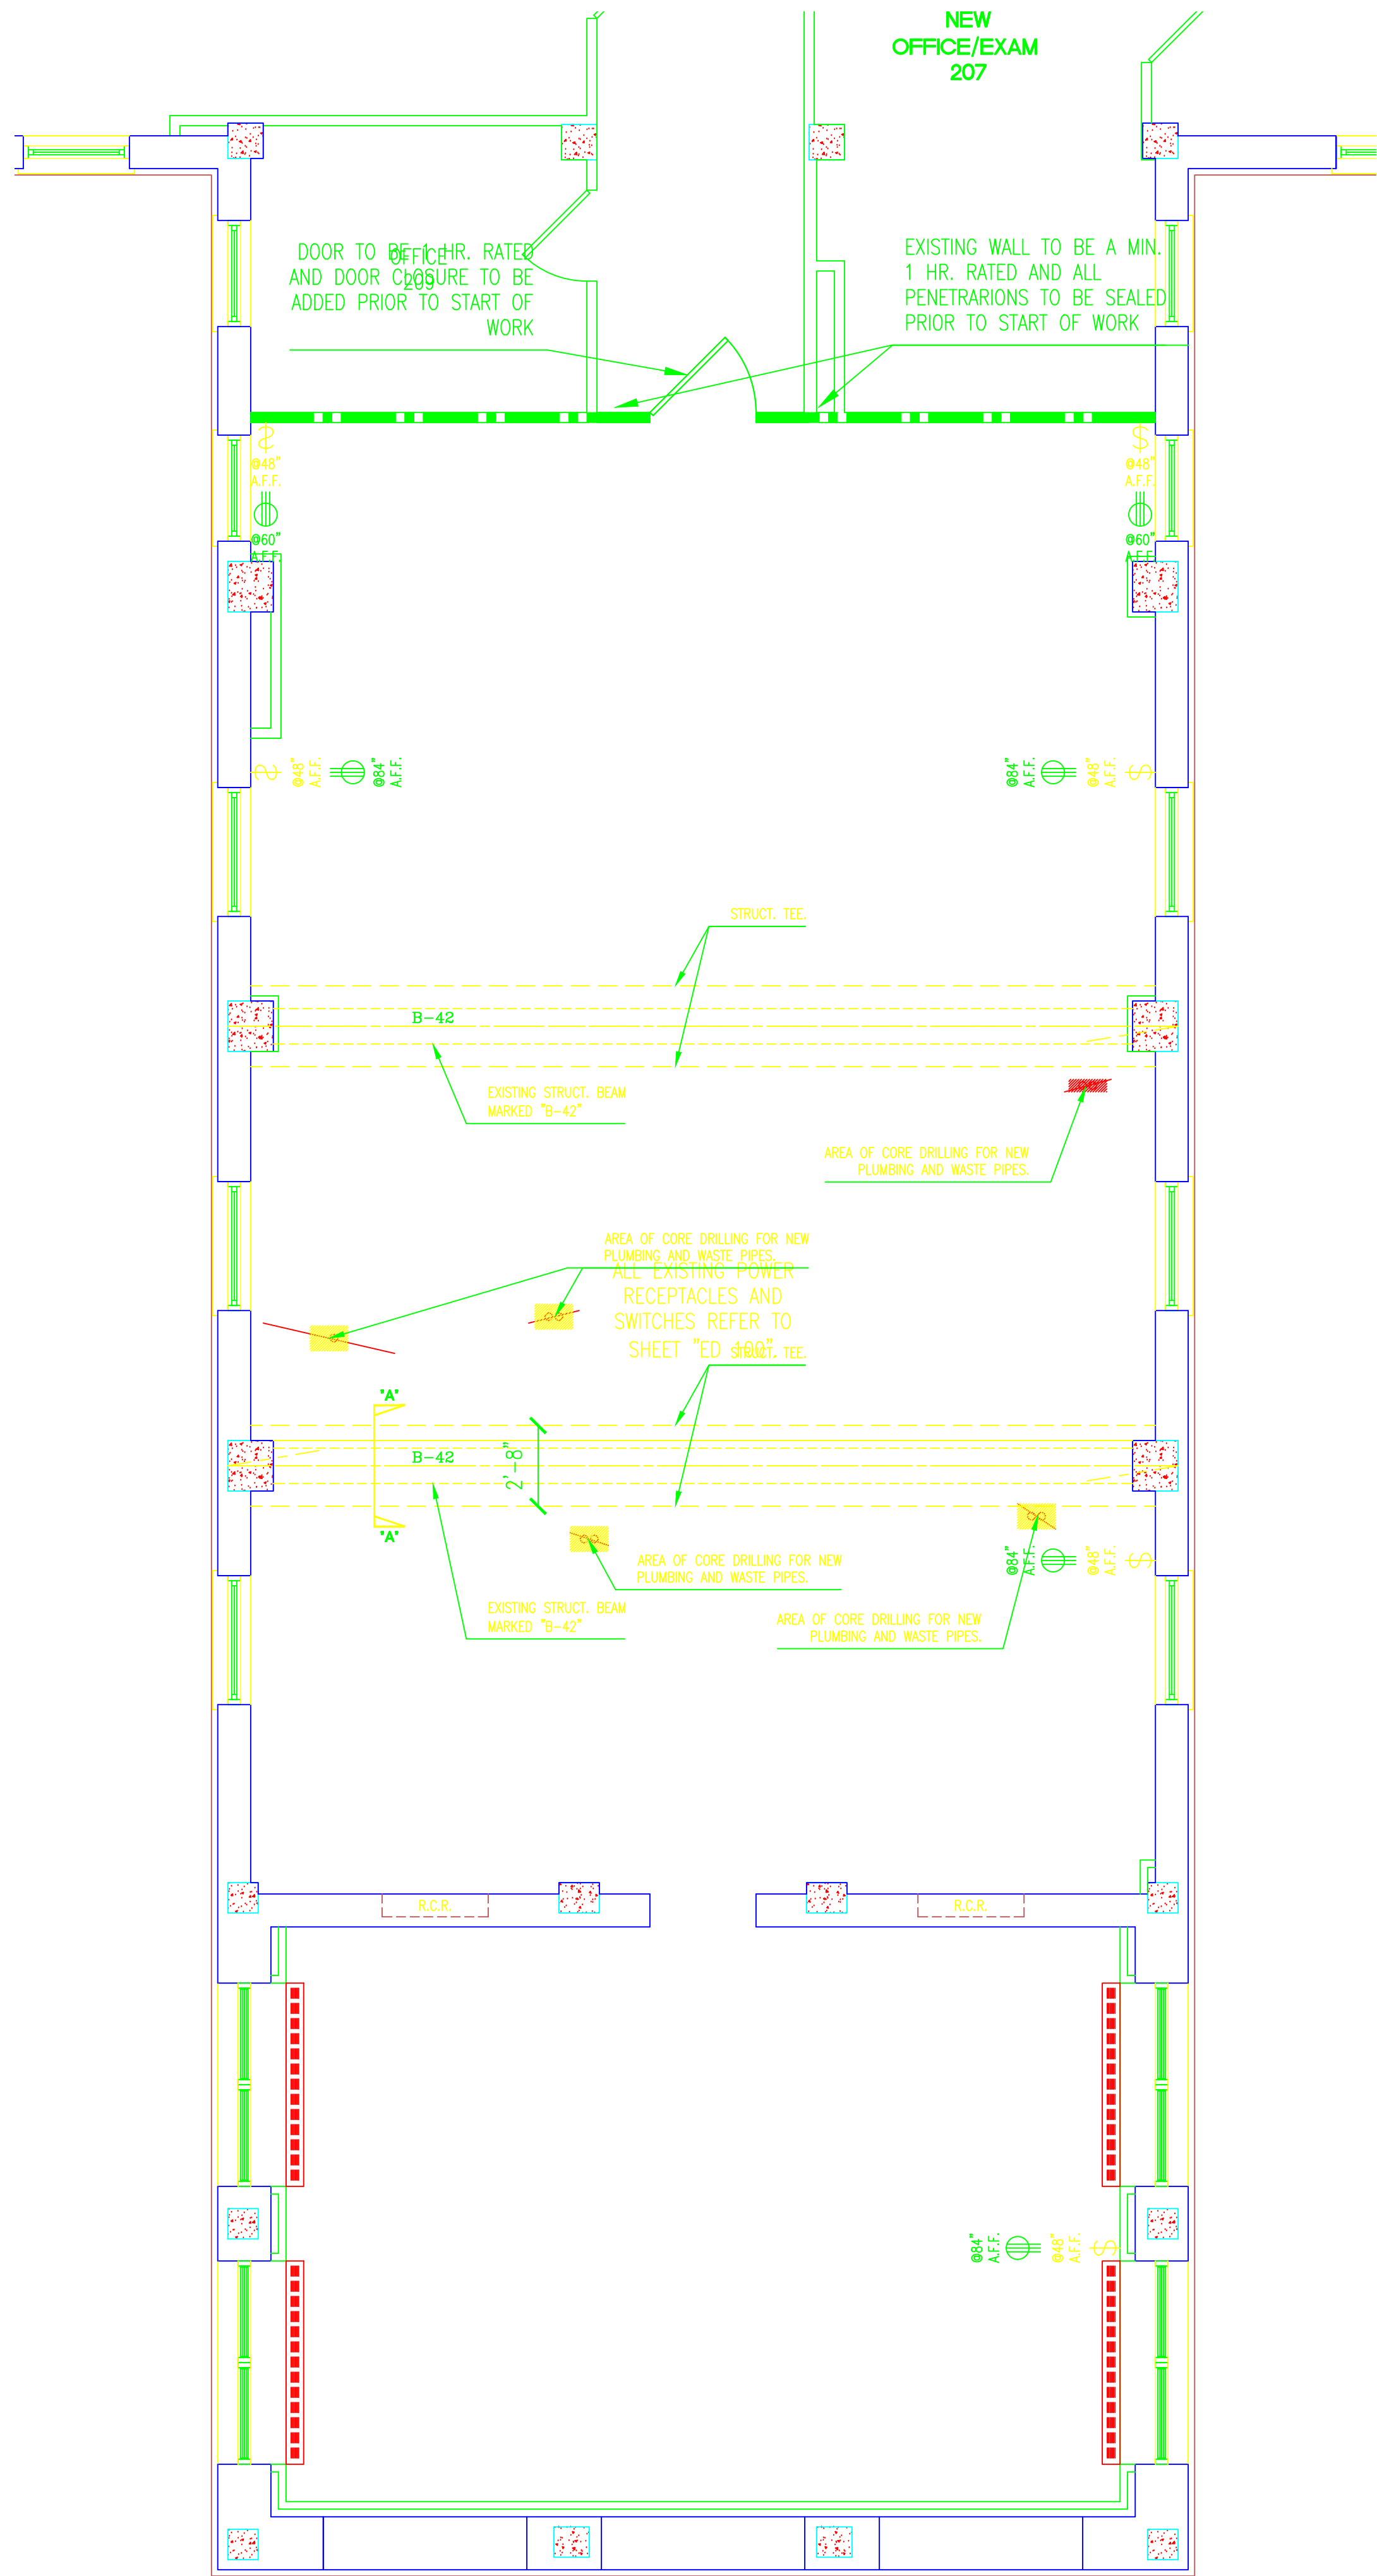


PARTIAL PLAN: PLUMBING DEMO.

SCALE: 1/4"=1'-0"

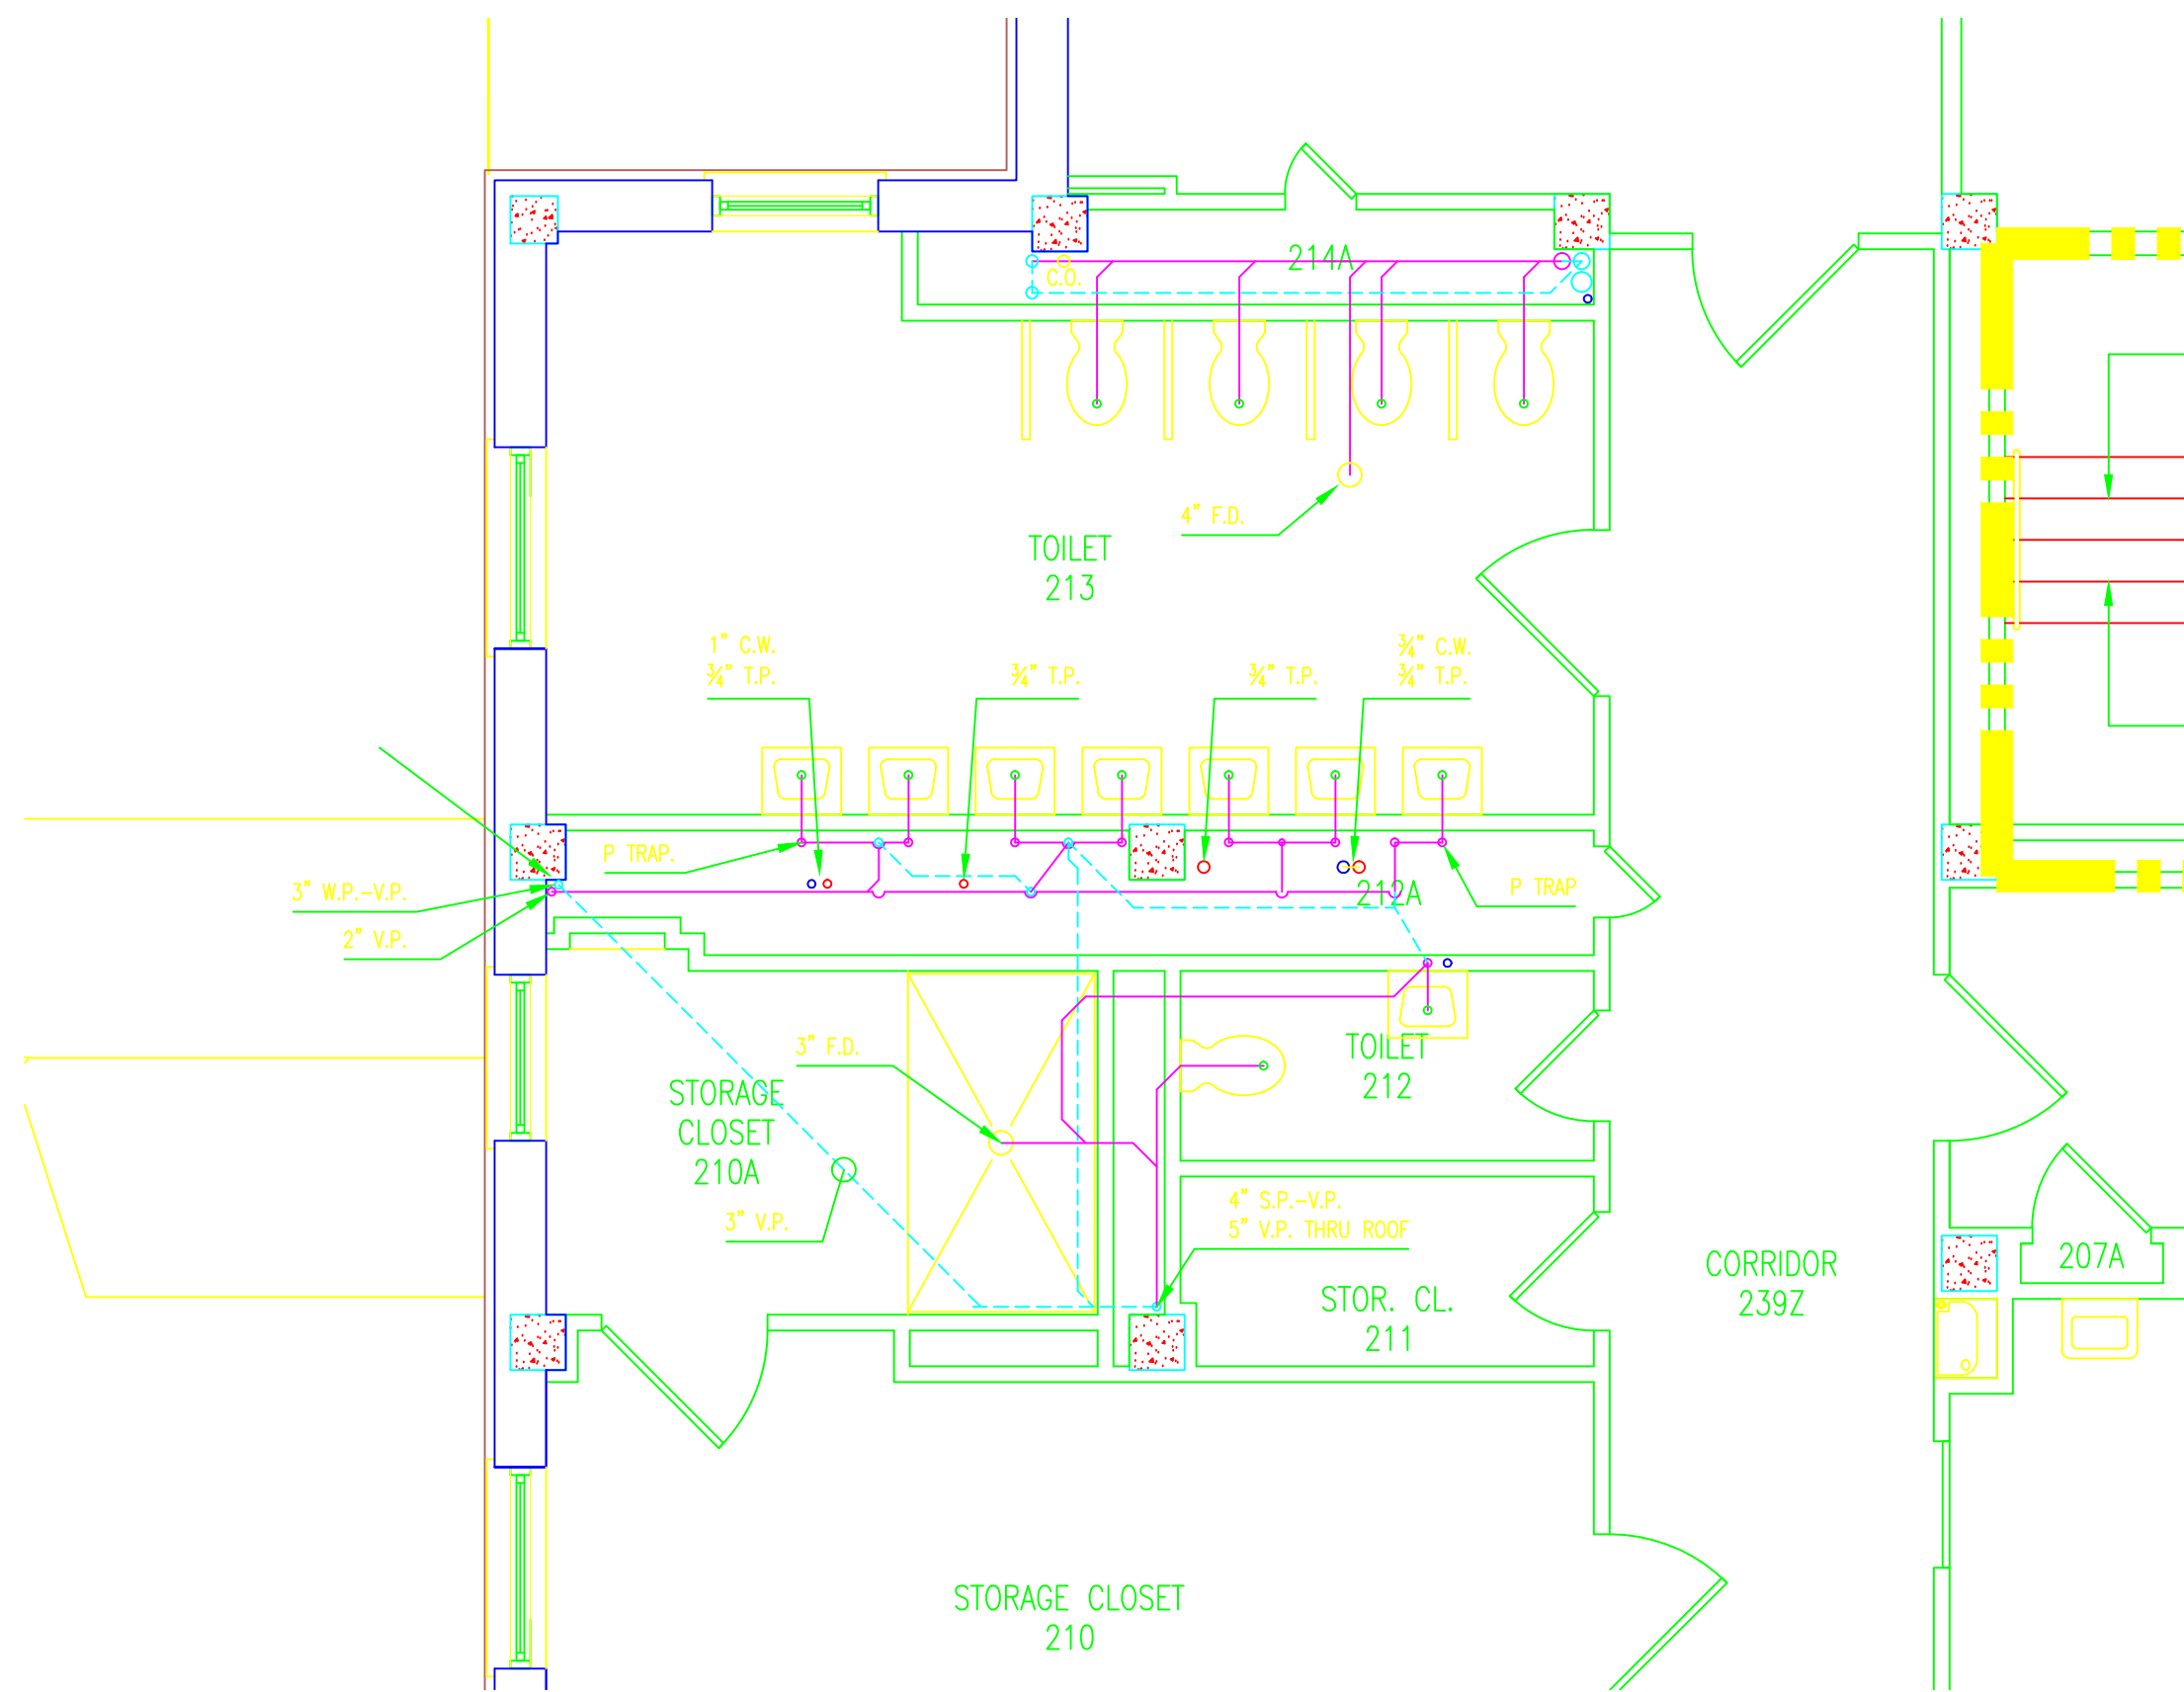

PARTIAL PLAN: EXST'G PLUMBING

SCALE: 1/4"=1'-0"

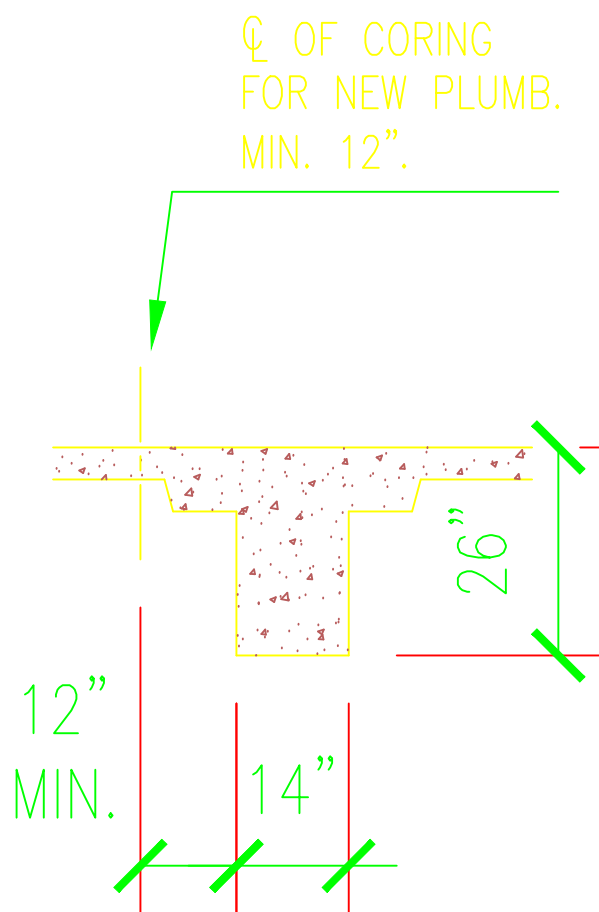

"AA" PARTIAL CORING DETAIL

SCALE: N.T.S.

GENERAL NOTES: EXIST'G PLUMBING

- FOR SIZES OF SOIL WASTE AND VENT PIPES (NOT SHOWN ON FLOOR PLANS) SEE PLUMBING DIAGRAMSON SHEET 3-16 OF ORIGINAL AS-BUILTS.
- PLUMBING STACKS AND CORRESPONDING PLUMBING DIAGRAMS AR NUMBERED THUS 7.
- PLUMBING DIAGRAMS ARE NOT TO SCALE AND DO NOY SHOW ALL PIPE AND FITTINGS REQUIRED.
- "THERMO VALVE" INDICATES THERMOSTATIC WATER TEMPERATURE CONTROL VALVE. SEE SEE SHEET 64 OF ORIGINAL AS-BUILTS.
- FOR GENERAL NOTES, SYMBOLS, AND DETAILS SEE STANDARD INTERIOR DETAIL SHEET FOR PLUMBING SHEET NO. 63 OF ORIGINAL AS-BUILTS.
- FOR RISES OF WATER CONNECTIONS NOT SHOWN TO FIXTURES SEE TABLE ON SHEET NO. 63 OF ORIGINAL AS-BUILTS.
- FOR EQUIPMENT SCHEDULE SEE FIRST FLOOR PLAN PLUMBING.
- FOR CONTINUATION OF SANITARY SEWER, STORM SEWER, AND WATER PIPING OUTSIDE OF BUILDING SEE SANITARY DRAWINGS SHEET NO. 5 OF ORIGINAL AS-BUILTS.
- DRAINS TO CONSIST OF 3/4" GLOBE VALVE WITH HOSE NIPPLE.
- FOR FUTURE FIXTURES IN UTILITY ROOMS PROVIDE PLUMBING TEES - 1" C.W. FOR #16, 3/4" C.W., 3/4" H.W. FOR #18 AND #20.

95 % CONSTRUCTION DOCUMENTS

		CONSULTANTS:		ARCHITECT/ENGINEERS:		NORTH:						Drawing Title		Project Title		Project Number		<div>Office of Facilities Management</div> <div>Department of Veterans Affairs</div>	
Schematic Design 100%		05-08-2012										PLUMBING DEMOLITION SECOND FLOOR Scale: AS NOTED		HOMELESS VETERANS OUTPATIENT CLINIC BLDG. 12 MONTROSE		620-11-248			
Careline Hatching and Editing		09-19-2007										Approved Director		Location		Building(s) Number			
FLOOR PLAN ALTERATIONS		09-13-2007												Montrose, New York		12			
Elevator Addition		09-10-2007										Approved Chief of Engineering		Date		Checked			
Title Block and Color Table Modifications		09-07-2007												06-27-2012		JA			
As-Built (Indus Sylems)		10-29-2004														Drawn			
Revisions		Date:														AMI			
																PD 100			
																DWG. 23 OF -			