



BUILDING SCHEDULE	
NO	NAME
2	DORMITORY
3	DUPLEX QUARTERS
4	DUPLEX QUARTERS
5	DUPLEX QUARTERS
11	DUPLEX QUARTERS
12	DUPLEX QUARTERS
13	DUPLEX QUARTERS
14	SINGLE QUARTERS
15	POWDER MAGAZINE
16	FIRE STATION
17	WAREHOUSE
20	ENGR. SHOPS
31	ENGR. WAREHOUSE
35	MANAGERS QUARTERS
41	SINGLE QUARTERS
42	SINGLE QUARTERS
43	SINGLE QUARTERS
47	SUPPLY STORAGE
52	FLAG POLE & MEMORIAL
54	MISC. STORAGE
141	ADMINISTRATION BUILDING
142	HEATING PLANT
144	7-CAR GARAGE
145	SINGLE GARAGE
146	7-CAR GARAGE

BUILDING SCHEDULE	
NO	NAME
150	DIETETICS
151	GAS METER HOUSE
152	RESERVOIR "IRRIGATION"
153	CHLORINATOR HOUSE
154	HOSPITAL
154A	OUT PATIENT ADDITION
156	BULK OXYGEN STORAGE
155	GENERATOR HOUSE
157	HIGH VOLTAGE SWITCH GEAR
158	GENERATOR HOUSE
159	GENERATOR HOUSE
160	BOOSTER PUMP HOUSE
161	WELL VALVE HOUSE
162	RESERVOIR "DOMESTIC WATER"
604	GARAGE
163	DOMESTIC WATER METER VAULT
164	IRRIGATION VALVE VAULT
165	PRV VAULT
166	HAZARDOUS WASTE
167	VBA REGIONAL OFFICE BLDG
168	LIBERTY HOUSE
169	INPATIENT MENTAL HEALTH UNIT
170	BOILER PLANT
171	AMM WAREHOUSE
172	FUTURE OUTPATIENT CLINIC
173	FUTURE MENTAL HEALTHCARE MINOR

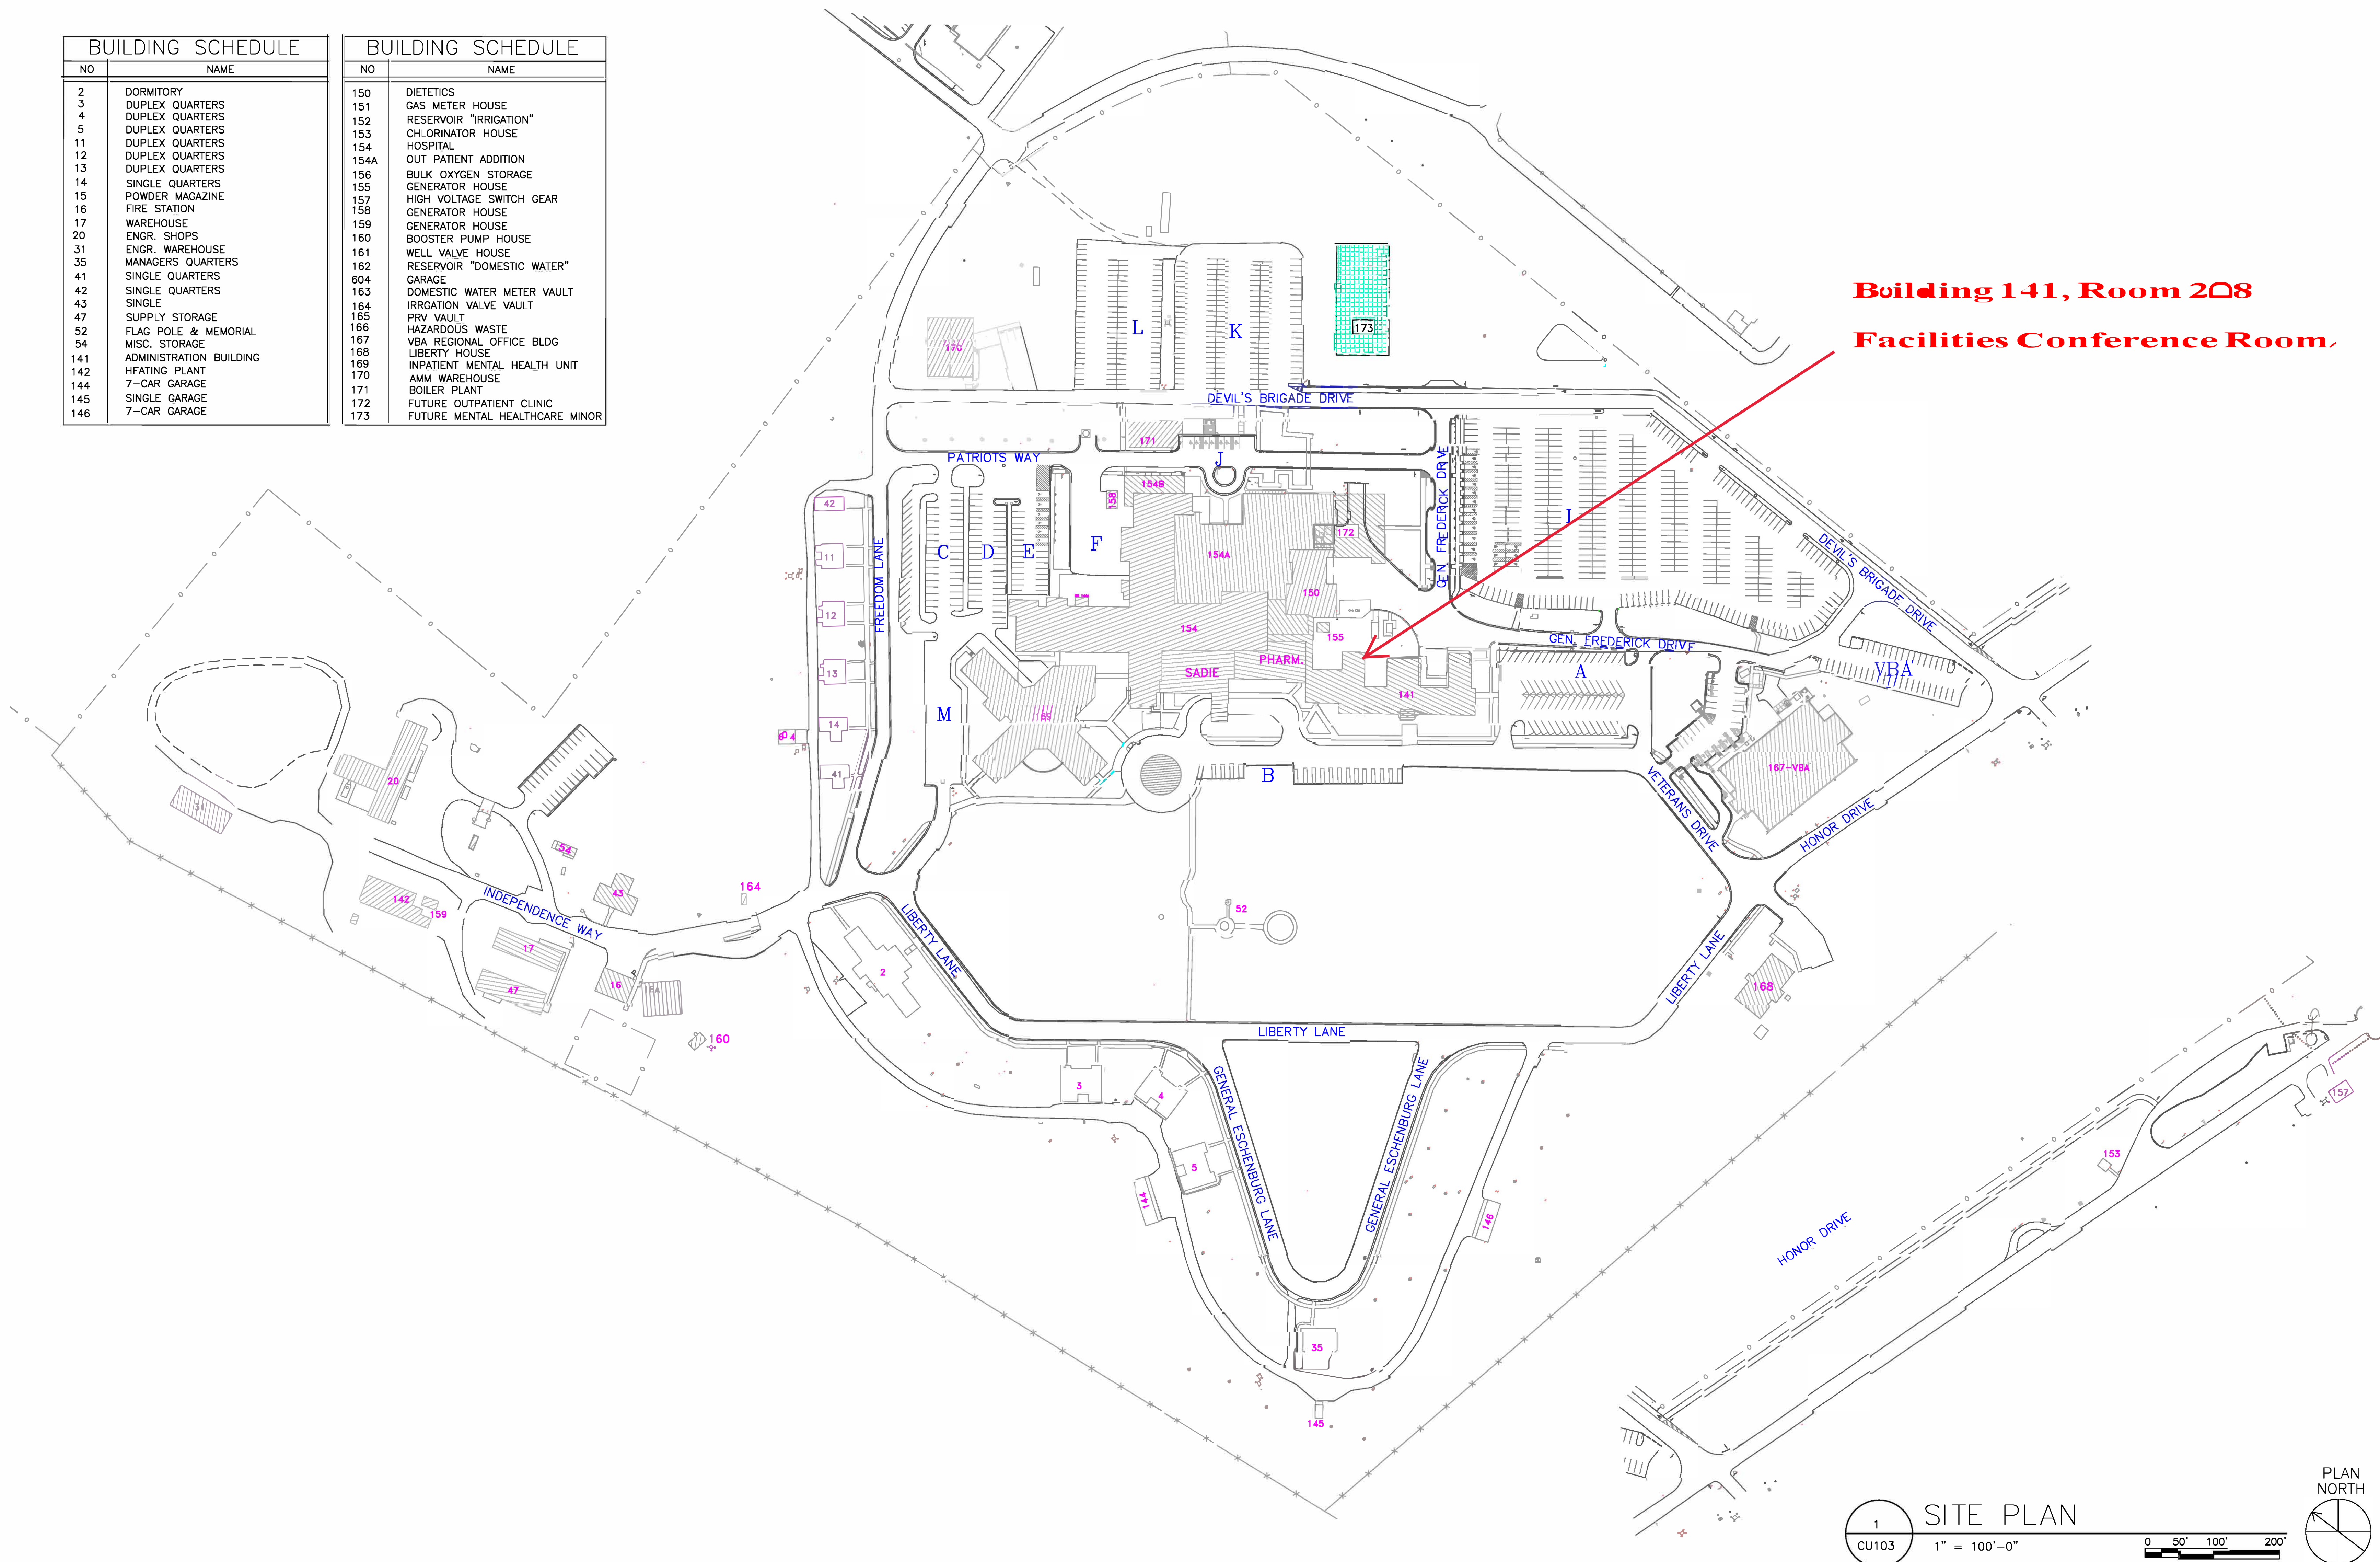

1 SITE PLAN
CU103 1" = 100'-0"

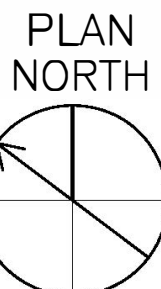

CONSULTANTS:		ARCHITECT/ENGINEERS:		Drawing Title FT HARRISON SITE MAP	Project Title FORT HARRISON, MONTANA	Project Number N/A	Office of Construction and Facilities Management Department of Veterans Affairs
				Approved: Project Director VAMC FORT HARRISON	Date 03/29/2017	Checked AT.	
					Drawn T.M.	Drawing Number CS101	
						Dwg. 1	