


three inches = one foot  
one and one half inches = one foot  
one inch = one foot  
three quarters inch = one foot  
one half inch = one foot  
three eighths inch = one foot  
one quarter inch = one foot  
one eighth inch = one foot

# COOLING TOWER REPLACEMENT

DEPARTMENT OF VETERANS AFFAIRS PROJECT NO. 595-11-135

LEBANON VA MEDICAL CENTER  
ACQUISITIONS (BLDG 99)  
1700 SOUTH LINCOLN AVENUE  
LEBANON, PENNSYLVANIA

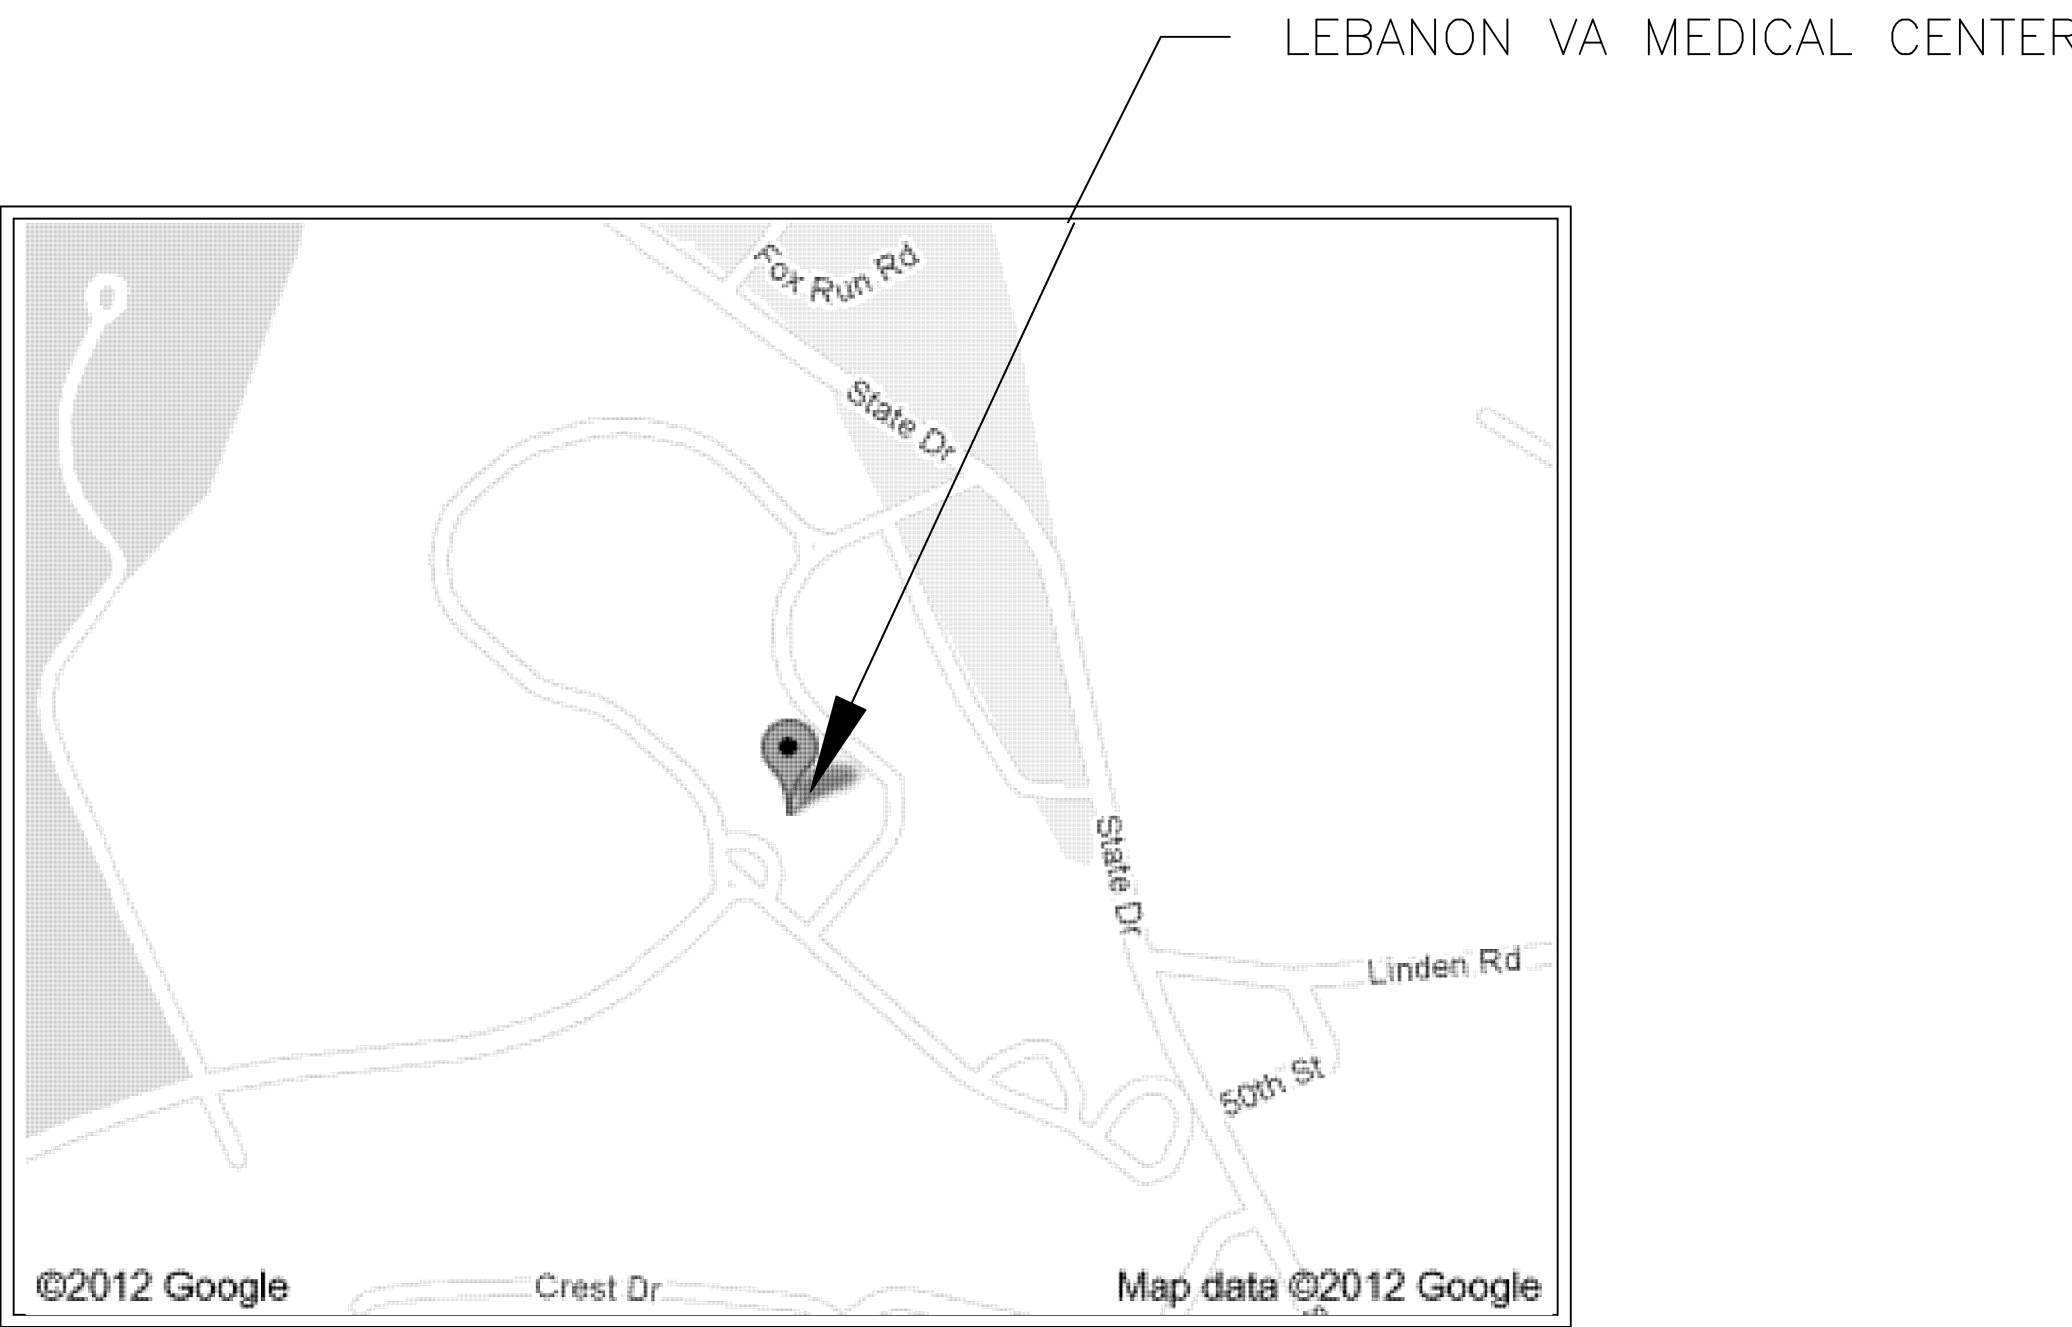

LOCATION MAP



## DRAWING INDEX

DWG. NO.	SHEET NAME	TITLE
<u>GENERAL</u> 01	GI-001	COVER SHEET AND DRAWING INDEX
<u>SITE/CIVIL</u> 02	CS-101	TOPOGRAPHIC SURVEY
<u>STRUCTURAL</u> 03 04 05 06 07 08	S-001 SD-101 SB-101 SF-101 SF-301 SF-501	STRUCTURAL NOTES STRUCTURAL DEMOLITION PLAN STRUCTURAL FOUNDATION PLAN STRUCTURAL FRAMING PLAN STRUCTURAL SECTIONS STRUCTURAL DETAILS
<u>MECHANICAL</u> 09 10 11 12 13 14 15	M-001 MD-101 MP-101 MP-301 M-501 M-601 M-602	MECHANICAL NOTES, SYMBOLS AND ABBREVIATIONS MECHANICAL DEMOLITION PIPING PLAN MECHANICAL PIPING PLAN MECHANICAL PIPING SECTIONS & ELEVATIONS MECHANICAL DETAILS CONDENSER WATER FLOW DIAGRAM EQUIPMENT SCHEDULES
		<u>ELECTRICAL</u> 16 17 18 19 20 21 22 23  <u>PLUMBING</u> 24 25 26
		EI-001 ED-101 EL-101 EP-101 EP-102 EP-103 EP-501 EP-601  P-001 PD-101 PL-101
		ELECTRICAL NOTES, SYMBOLS & ABBREVIATIONS ELECTRICAL DEMOLITION PLAN LIGHTING PLAN ELECTRICAL PLAN DATA & COMMUNICATION INSTALLATION PLAN LIGHTNING AND GROUNDING PLAN DETAIL 1 SINGLE LINE DIAGRAM  PLUMBING NOTES, SYMBOLS AND ABBREVIATIONS PLUMBING DEMOLITION PIPING PLAN PLUMBING PIPING PLAN

## CONSTRUCTION DOCUMENTS

<div>ADDENDUM #2</div> <div>Revisions</div>		CONSULTANTS:	Mechanical/Electrical/Plumbing/Structure: <div>ANTHONY A. DIAMOND, JR., P.E. MILLER-REMICK CORPORATION PROFESSIONAL ENGINEER PENNSYLVANIA LICENSE NO. PE062779</div> <div>SIGNATURE: _____</div>	ARCHITECT/ENGINEERS: <div> Miller-Remick LLC M.E.P. &amp; Structural Engineering A Veteran Owned Small Business 1010 KINGS HIGHWAY SOUTH BUILDING ONE - 1st FLOOR CHERRY HILL, NEW JERSEY 08034 PHONE: (856)429-4000 FAX: (856)429-5002</div>	Drawing Title COVER SHEET AND DRAWING INDEX SCALE: NTS	Project Title COOLING TOWER REPLACEMENT	Project Number 595-11-135 Building Number 10	Office of Construction and Facilities Management			
					Approved Project Director	Location VA MED. CENTER, LEBANON, PA	Date 8/27/2012	Checked MANNIX	Drawn JAKATT	Drawing Number GI-001 Dwg. 01 of 26	Department of Veterans Affairs